


Avoid cutting underground utility lines. It's costly.

Call before you Dig.

1-800-227-2600
UNDERGROUND SERVICE (USA)

SCALE $1" = 40'$

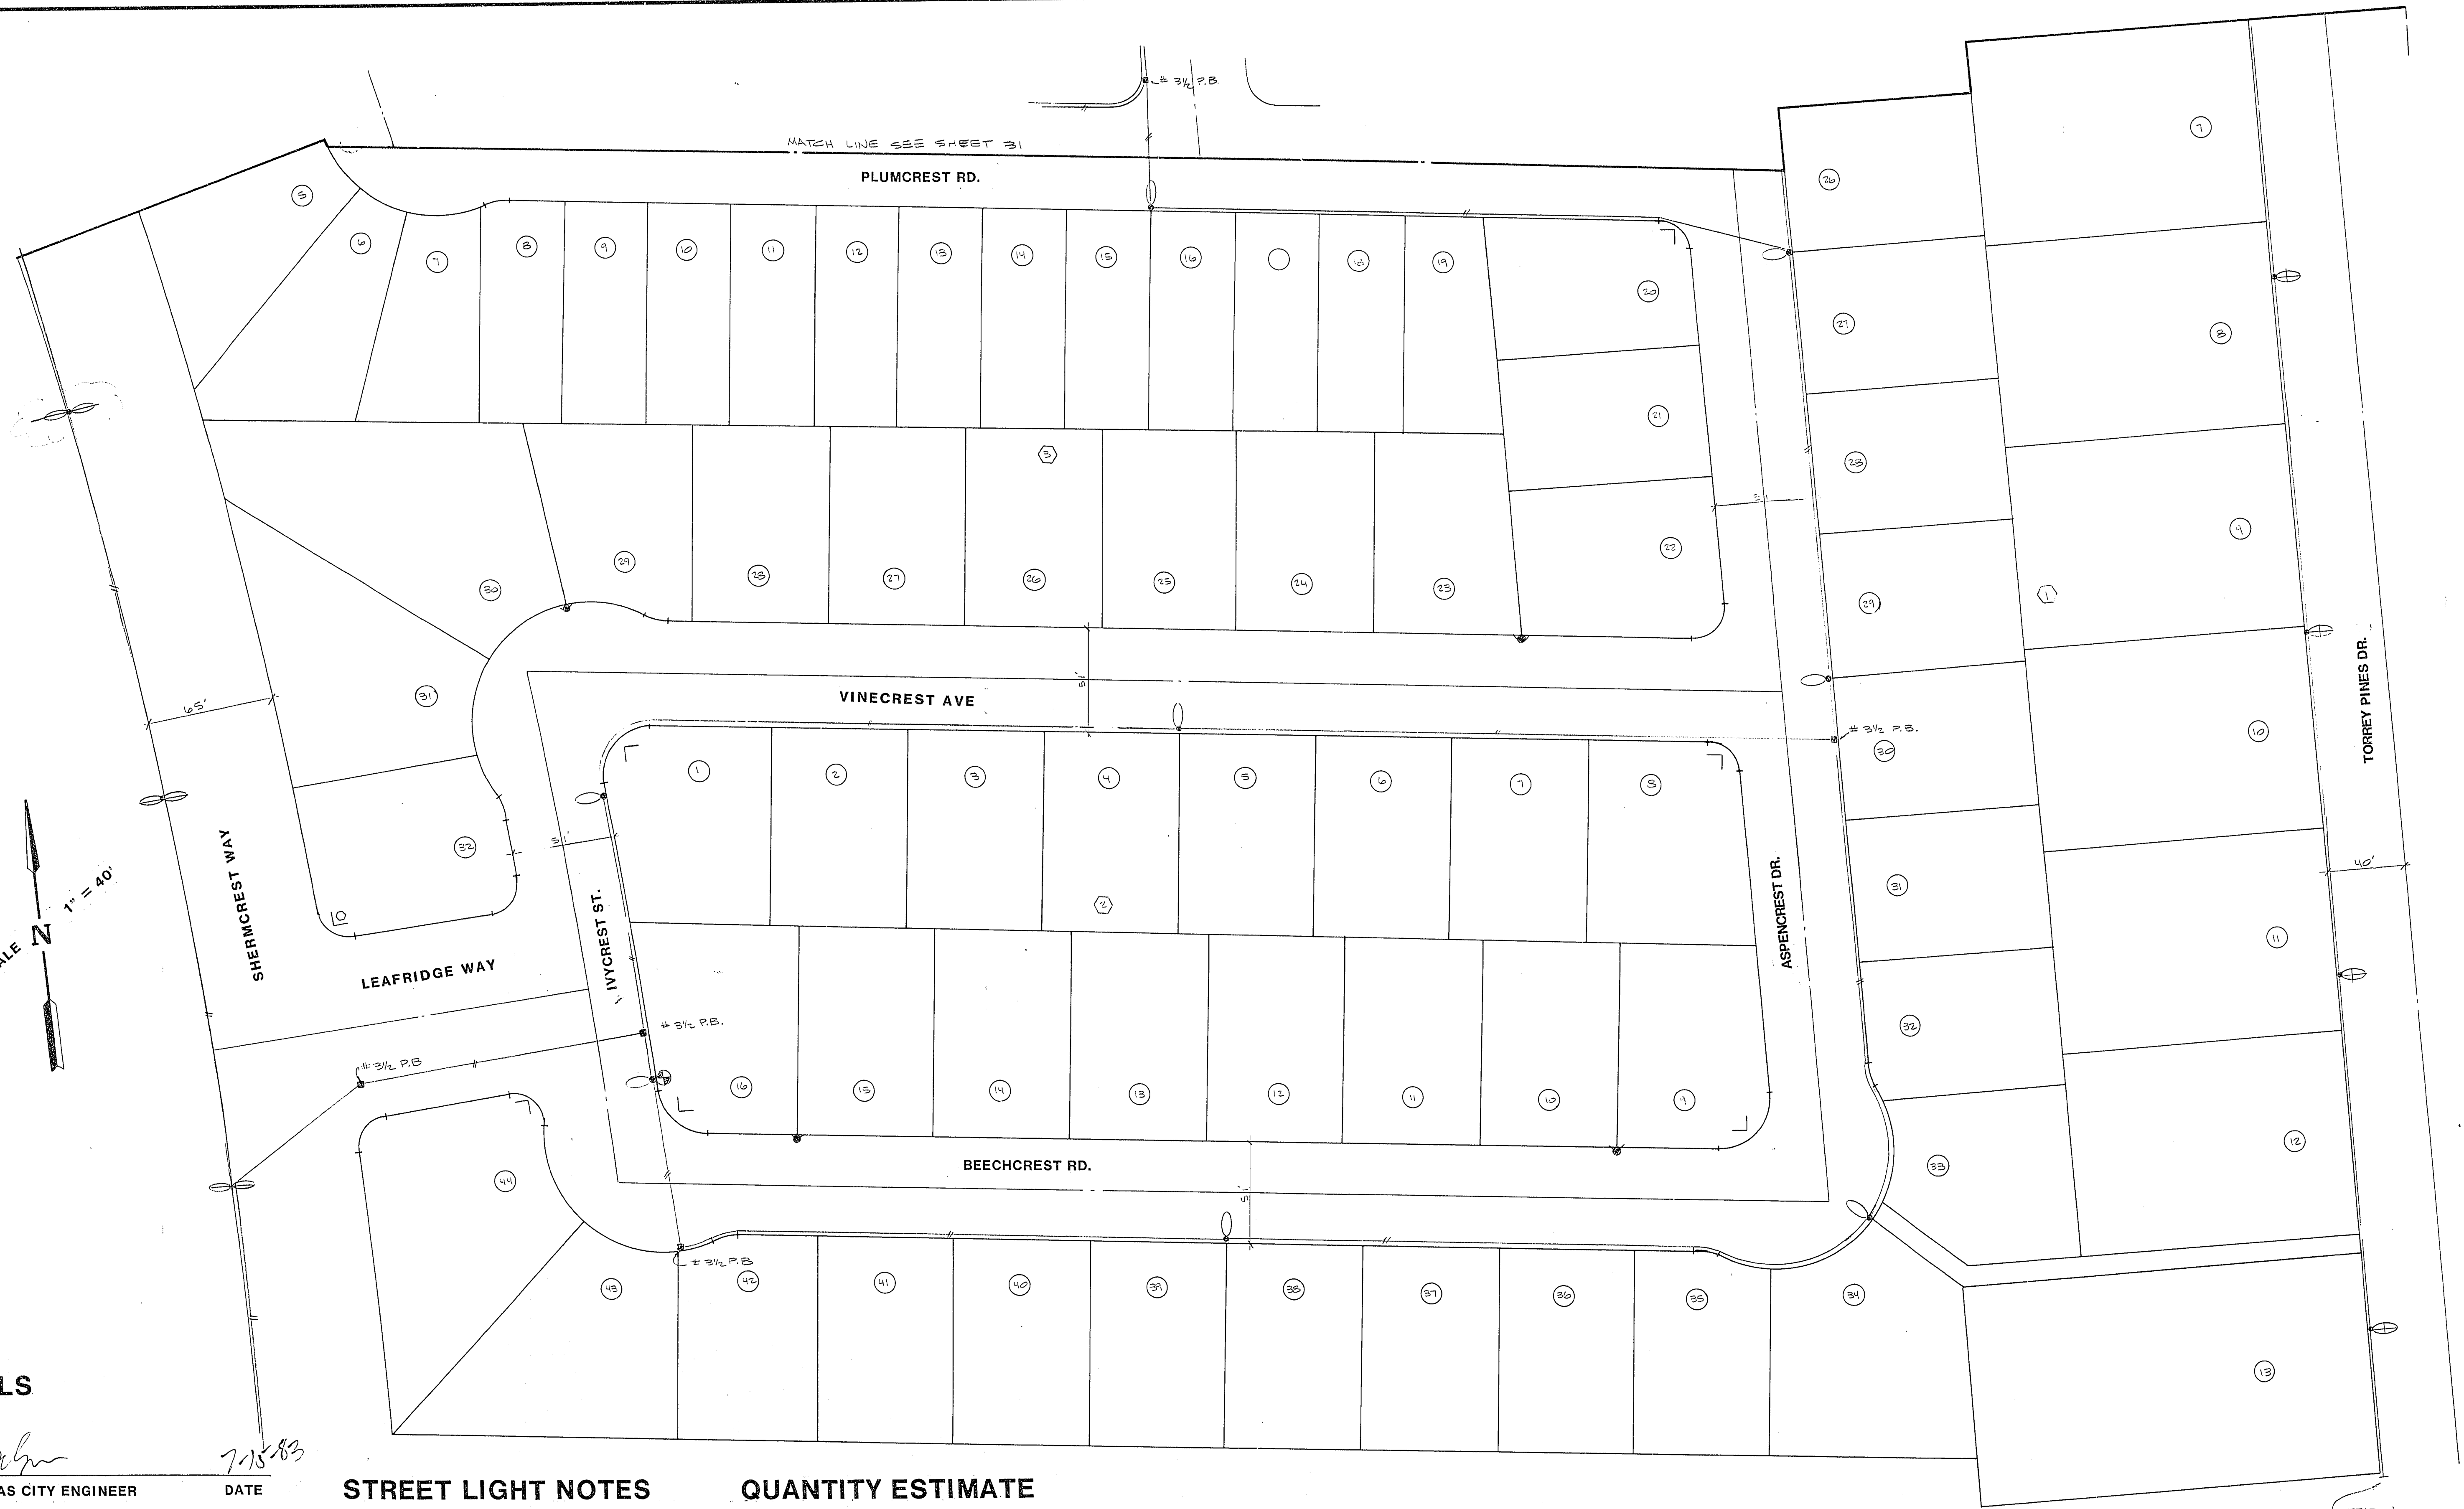

APPROVALS

	7/18/83
CITY OF LAS VEGAS CITY ENGINEER	DATE
	7/18/83
CITY OF LAS VEGAS QUALITY CONTROL	DATE
	7-6-83
CITY OF LAS VEGAS CITY ELECTRICIAN	DATE
	7/6/83
CITY OF LAS VEGAS ELECT. COORDINATOR	DATE
	6/28/83
NEVADA POWER COMPANY	DATE

STREET LIGHT NOTES


ALL STREET LIGHTING INSTALLATIONS, EXCEPT AS NOTED ON THE STREET LIGHTING PLANS, SHALL CONFORM TO THE STANDARD DETAILS FOR STREET LIGHTING AND TRAFFIC SIGNALS DRAWINGS L-779 (INCLUDING STANDARD STREET LIGHTING NOTES) WITH REVISIONS NO LATER THAN MARCH 26, 1976. THESE INSTALLATIONS SHALL ALSO CONFORM TO THE UNIFORM STANDARD SPECIFICATIONS FOR PUBLIC WORKS CONSTRUCTION OF OFF-SITE IMPROVEMENTS, CLARK COUNTY AREA, NEVADA AND THE UNIFORM STANDARD DRAWINGS FOR PUBLIC WORKS CONSTRUCTION, CLARK COUNTY, AREA, WHERE APPLICABLE.

QUANTITY ESTIMATE

250 WATT HPS STREET LIGHT	17 EA.
200 WATT HPS STREET LIGHT	6 EA.
100 WATT HPS STREET LIGHT	16 EA.
1 1/2" CONDUIT	1550 L.F.
# 3/4" P.B.	8 EA.
STREET SIGN	15 EA.
STOP SIGN	4 EA.
R.O.C. SERVICE POINT	2 EA.
OFFSITE (SEE SHEETS (4,5) (8-16)	
250 WATT HPS STREET LIGHT	37 EA.
200 WATT HPS STREET LIGHT	7 EA.
1 1/2" CONDUIT	4250 L.F.
# 3/4" P.B.	1 EA.

SUBMITTED BY

PAUL VALENTINE P.E.
NEVADA CERTIFICATE NO. 5916
DATE 6/29/83

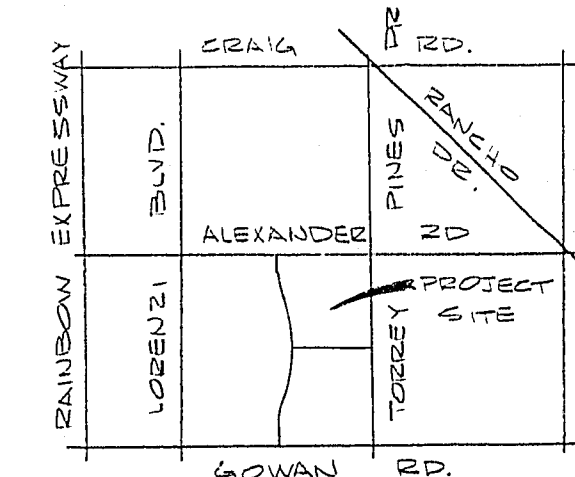

VICINITY MAP

ADD ST. LT. NOT SHOWN 9/15/83

E S I	ENGINEERS & SURVEYORS INCORPORATED	7022 W. CHARLESTON BLVD. LAS VEGAS, NEV. 89117 PHONE: 702 - 363-6415		
	WOODCREST UNIT # 1 MASTER STREET LIGHT & STREET SIGN PLAN			
DRWN.	D. E. K.	DES. D. E. K.	CHKD. P. E. V.	DATE 5-10-83
WO. NO.	830201-1	H. SCALE 1" = 40'	V. SCALE —	SHEET 22 OF 32

6-9-84

2074-3348-1