



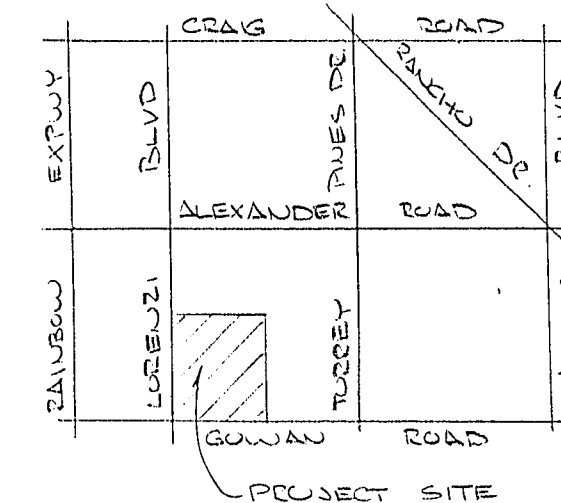

VICINITY MAP

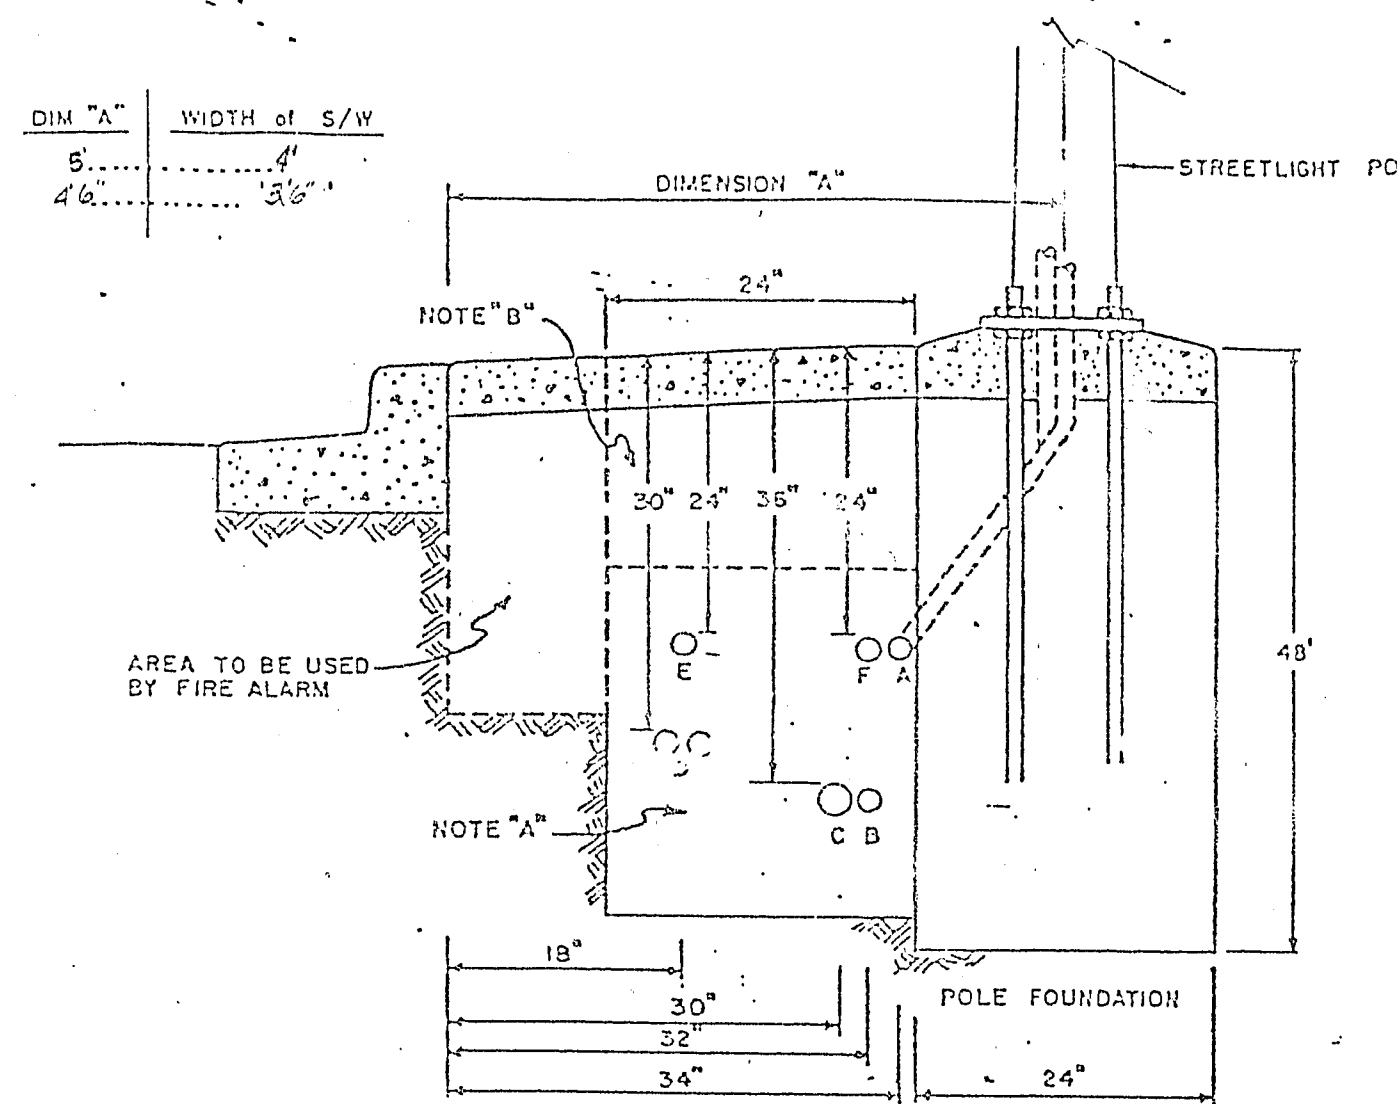


- A. STREETLIGHT CONDUIT
 - B. POWER COMPANY SECONDARY
 - C. POWER COMPANY PRIMARY
 - D. TELEPHONE CONDUITS
 - E. CABLE T.V. CONDUIT
 - F. TRAFFIC SIGNAL CONDUIT
- NOTES: "A" SELECT NATURAL FILL WILL BE ALLOWED BELOW TYPE 2 GRAVEL BASE
 "B" TYPE 2 GRAVEL (MAXIMUM SIZE 1") COMPACTED TO 90% DENSITY WITH THE TOP 10" COMPACTED TO 95% DENSITY.

STREET LIGHT NOTES:

ALL STREET LIGHTING INSTALLATIONS, EXCEPT AS NOTED ON THE STREET LIGHTING PLANS, SHALL CONFORM TO THE STANDARD DETAILS FOR STREET LIGHTING AND TRAFFIC SIGNALS DRAWINGS L-779 (INCLUDING STANDARD STREET LIGHTING NOTES) WITH REVISIONS NO LATER THAN MARCH 26, 1978. THESE INSTALLATIONS SHALL ALSO CONFORM TO THE UNIFORM STANDARD SPECIFICATIONS FOR PUBLIC WORKS CONSTRUCTION OF OFF-SITE IMPROVEMENTS, CLARK COUNTY AREA, NEVADA AND THE UNIFORM STANDARD DRAWINGS FOR PUBLIC WORKS CONSTRUCTION, CLARK COUNTY, AREA, WHERE APPLICABLE.

QUANTITY ESTIMATE:

- 100 WATT H.P.S. _____ 10 EA
- CONDUIT _____ 500 LF
- #3 1/2 P.B. _____ 10 EA
- STOP SIGN _____ 2 EA
- STREET NAME SIGN _____ 14 EA
- 25 MPH TRAFFIC SIGN _____ 2 EA
- DRIVEWAY LOCATION _____

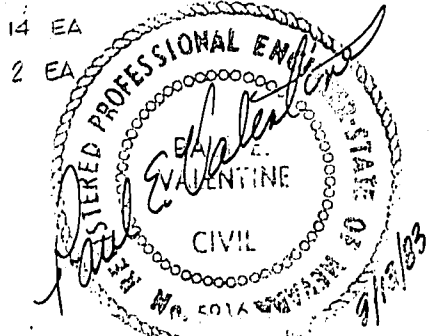

APPROVAL: *[Signature]* 10/25/83
 C.L.V. CHIEF, FLOOD CONTROL & LAND DEVELOPMENT DATE

Call before you Dig.

1-800-227-2600
 UNDERGROUND SERVICE, USA

REV	DATE	BY	REVISION
1	10/25/83	DM	REV. AS PER CIV. CHECK SHEETS
2	11-9-83	DM	LOCATION OF DRIVEWAYS

ENGINEERS & SURVEYORS
 INCORPORATED
 7022 W. CHARLESTON BLVD.
 LAS VEGAS, NEVADA 89117
 PHONE: 702 / 363-6415

TITLE: STREET LIGHTING PLAN
 PROJECT: WOODCREST UNIT #3

WO NO 830301-3
 BY: DWM
 DATE: 9-83
 SCALE: 1" = 80'

SHEET 13
 OF 13 SHEETS

Drawn By: *[Signature]* 11/18/83
 NEVADA POWER CO. DATE

6-9-86 207 y - 3348-3