


UTILITY NOTE:

EXISTING UTILITIES SHOWN ON THIS PLAN REFLECT ONLY THOSE UTILITIES KNOWN, LOCATED OR RESEARCHED AND DOES NOT CONSTITUTE ALL EXISTING UTILITIES ON SITE. THE CONTRACTOR IS RESPONSIBLE FOR CORRECT LOCATION AND VERIFICATION OF ALL EXISTING UTILITIES ON SITE. IN THE EVENT OF ANY DESIGN DISCREPANCIES THE CONTRACTOR IS TO NOTIFY THE CONSTRUCTION MANAGER PRIOR TO COMMENCEMENT OF CONSTRUCTION.

- CONSTRUCTION NOTES**
1. INSTALL 8" DI SANITARY SEWER PER SD-22 DCSWCS LATEST EDITION. SEE SECTION 2.2.18 SHALLOW LATERALS
 2. INSTALL CLEAN OUT TO GRADE MIN. 100' O.C. PER DETAILS 1 & 2 SHEET C8.01
 3. INSTALL 8" APPROVED SS TAPPING SADDLE TYPE CONNECTION PER DCSWCS SECTION 4.6. CONTRACTOR TO VERIFY VCP O.D. FOR PROPER CONNECTION SIZE
 4. TRENCH BACKFILL WITH CLSM IN PAVED AREAS PER DCSWCS SD-17
 5. INSTALL 6" PVC SANITARY SEWER HORIZONTAL WYE ADAPTOR PER DCSWCS LATEST EDITION
 6. INSTALL 6" PVC C-900 OR SCH 80 SANITARY SEWER PER DCSWCS LATEST EDITION. SEE SECTION 2.2.18 SHALLOW LATERALS
 7. INSTALL 4" CAP TO EXIST. SANITARY SEWER LATERAL PER DCSWCS LATEST EDITION
 8. REMOVE AND REPLACE CROSS GUTTER AS NEEDED PER USDOCA DWG. NO. 228

Date	Description	No.
Revisions		

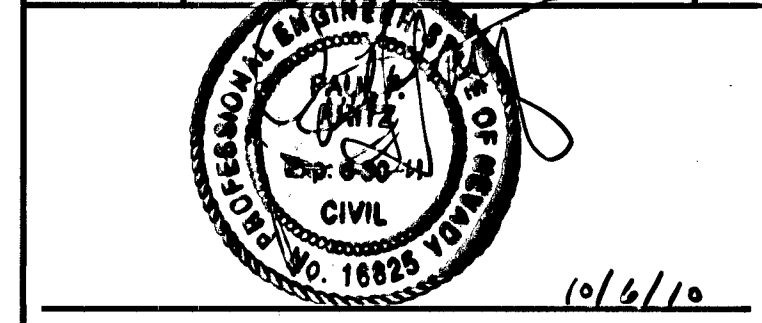

LANGAN
ENGINEERING & ENVIRONMENTAL SERVICES

3900 Paradise Road
Suite E
Las Vegas, NV 89169
P: 702.415.2040 F: 702.415.2041
www.langan.com

NEW JERSEY PENNSYLVANIA NEW YORK CONNECTICUT
NEVADA VIRGINIA CALIFORNIA

Project
WYANDOTTE APTS
LAS VEGAS

CLARK COUNTY NV
Drawing Title
SANITARY SEWER UTILITY PLAN

Project No. 600019801	Drawing No. C5.01
Date 08/23/2010	Scale 1"=10'
Drn. By pff	Last Revised 08/23/2010
10	Of 11

124899