
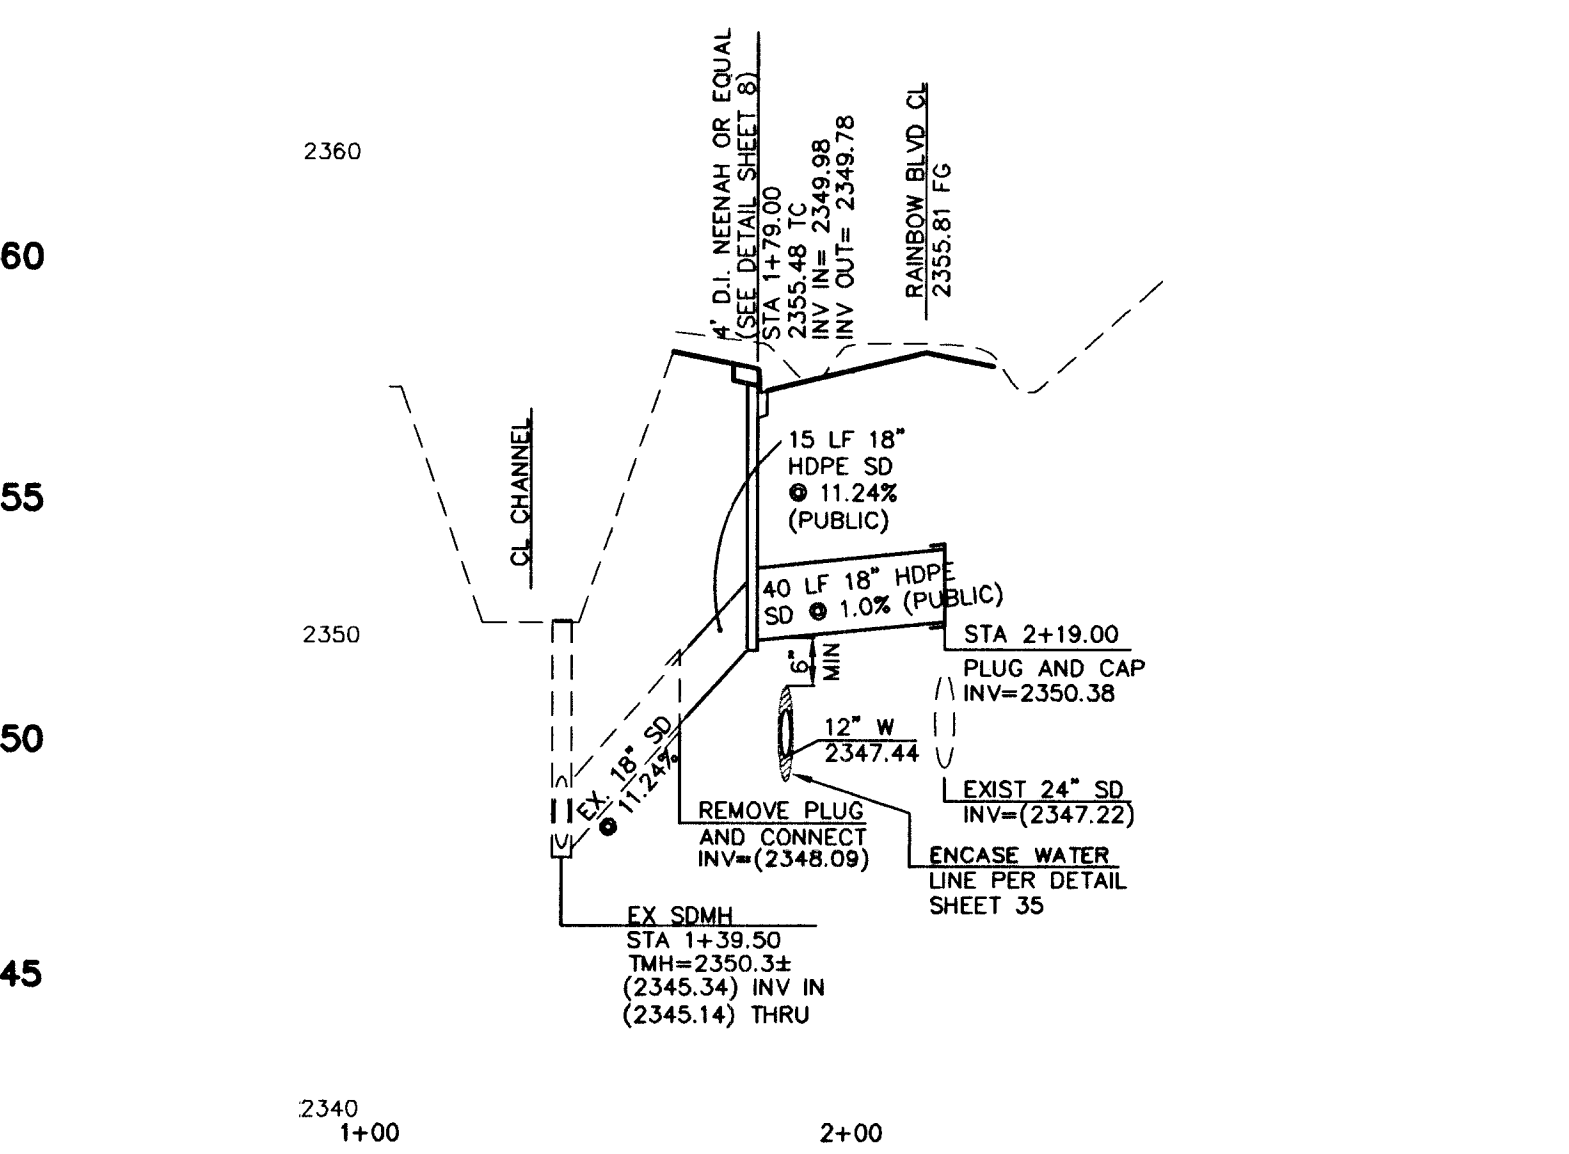
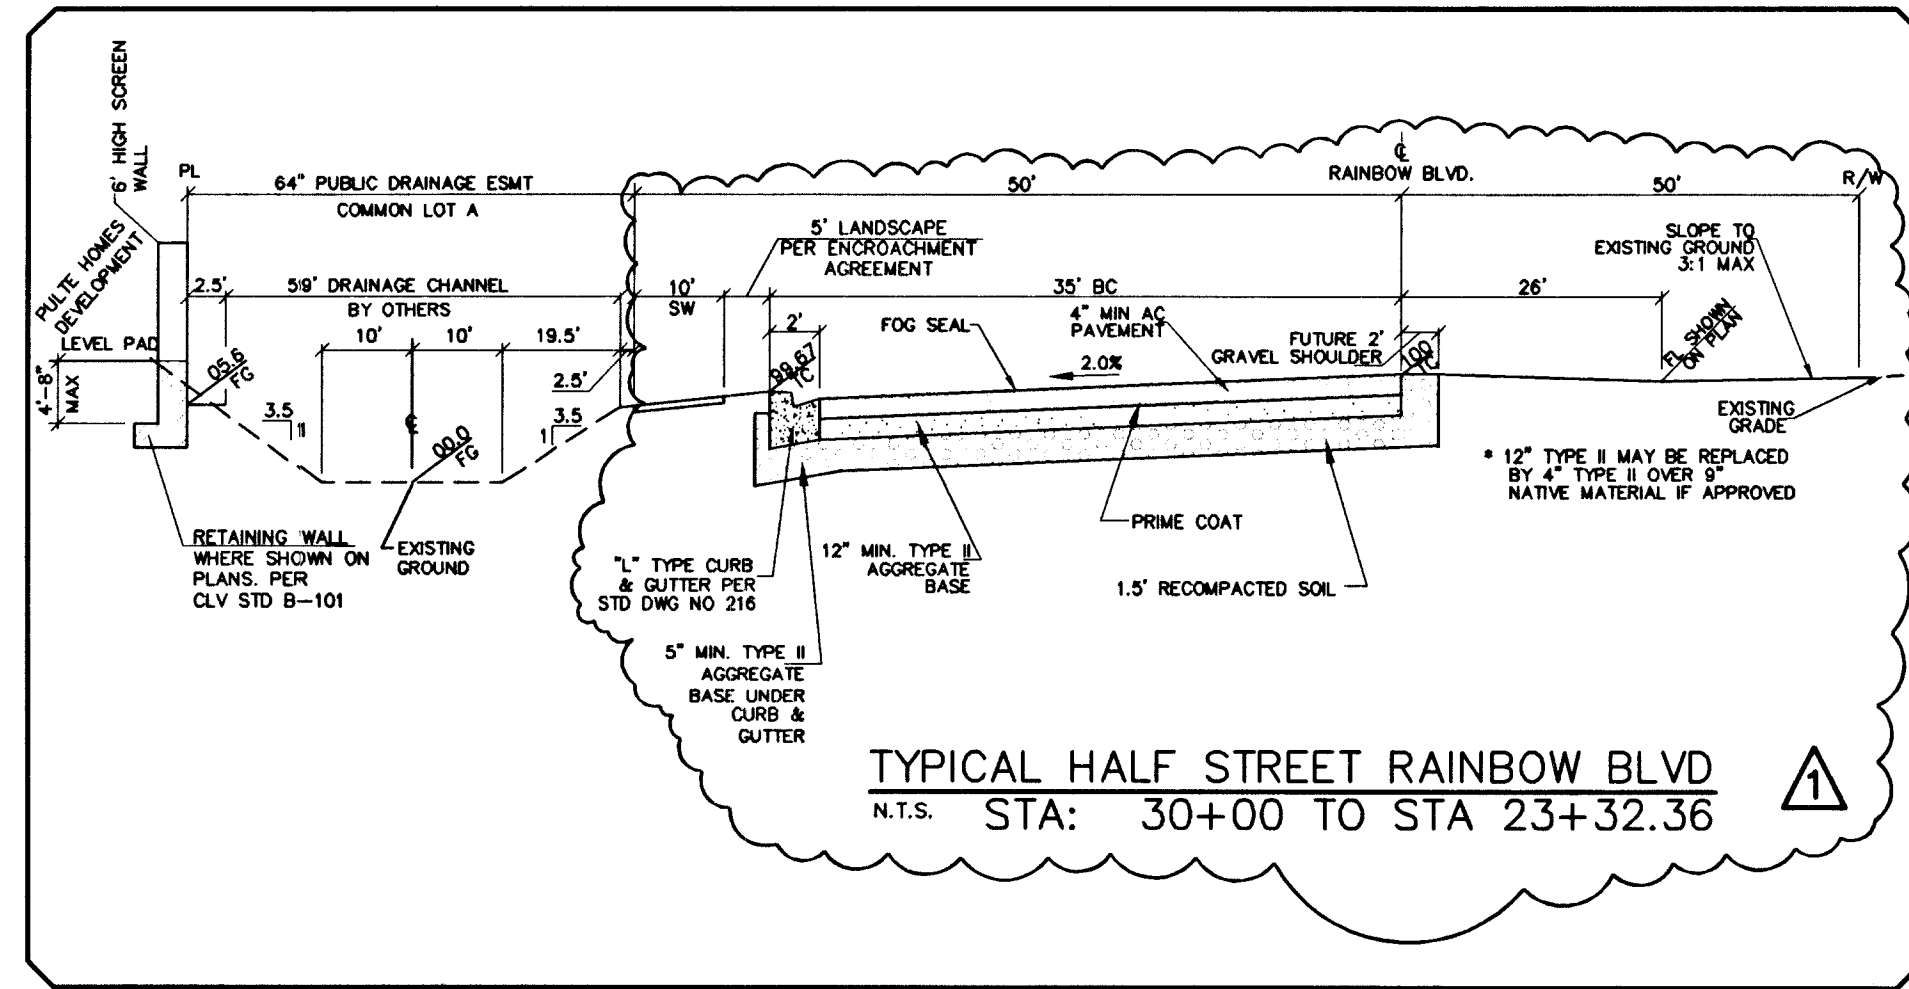
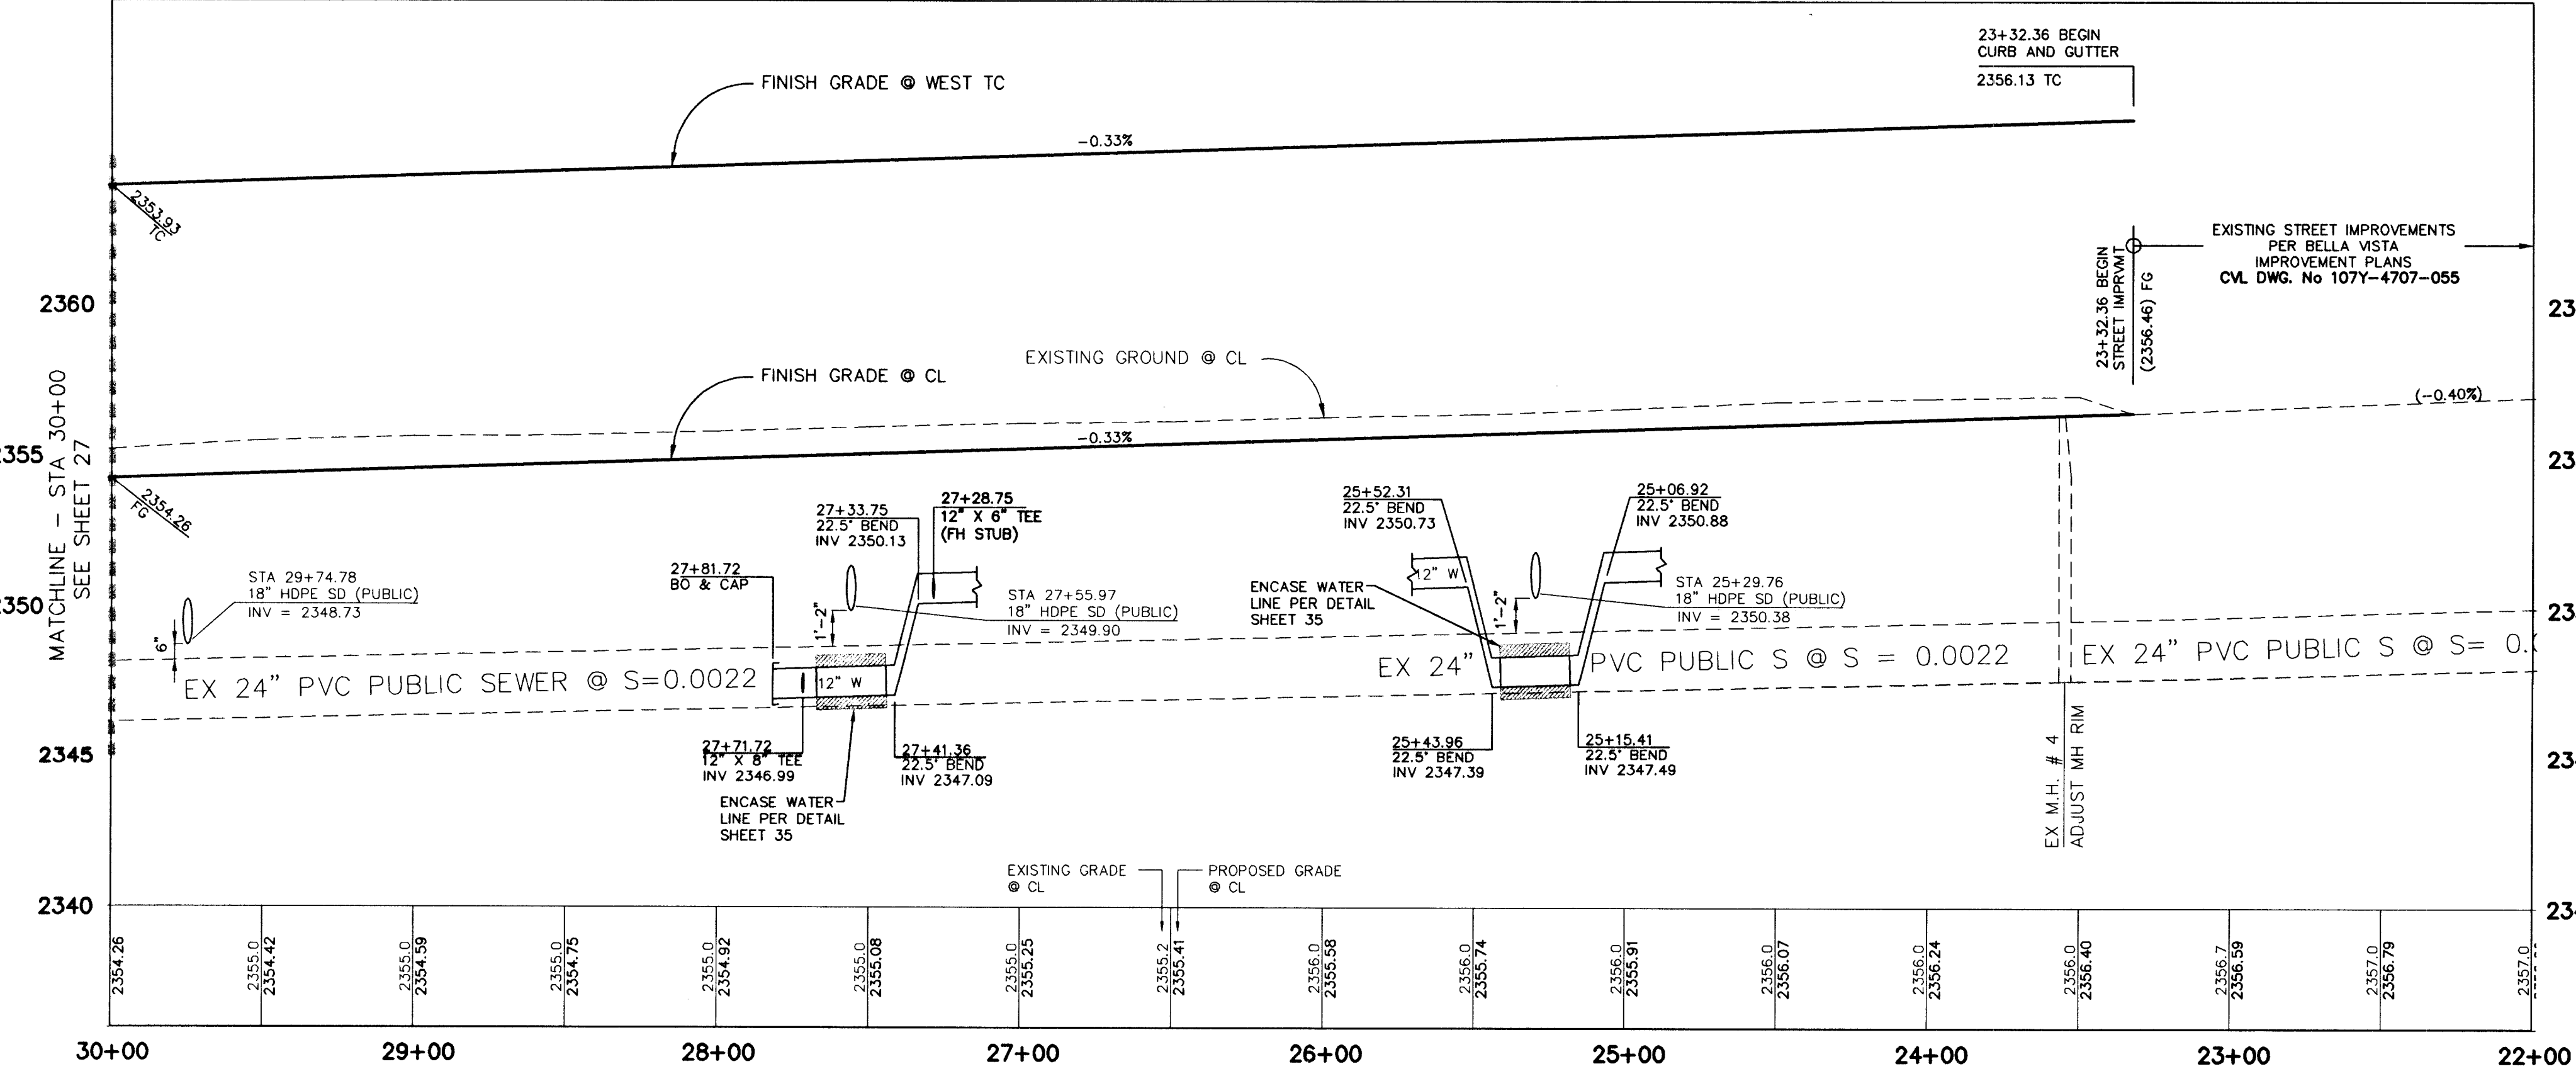


W:\Active\8847028\Drawings\unit 1 plans\01-pp020.DWG ttrues Wed, 25 Feb 2004 - 1:51pm

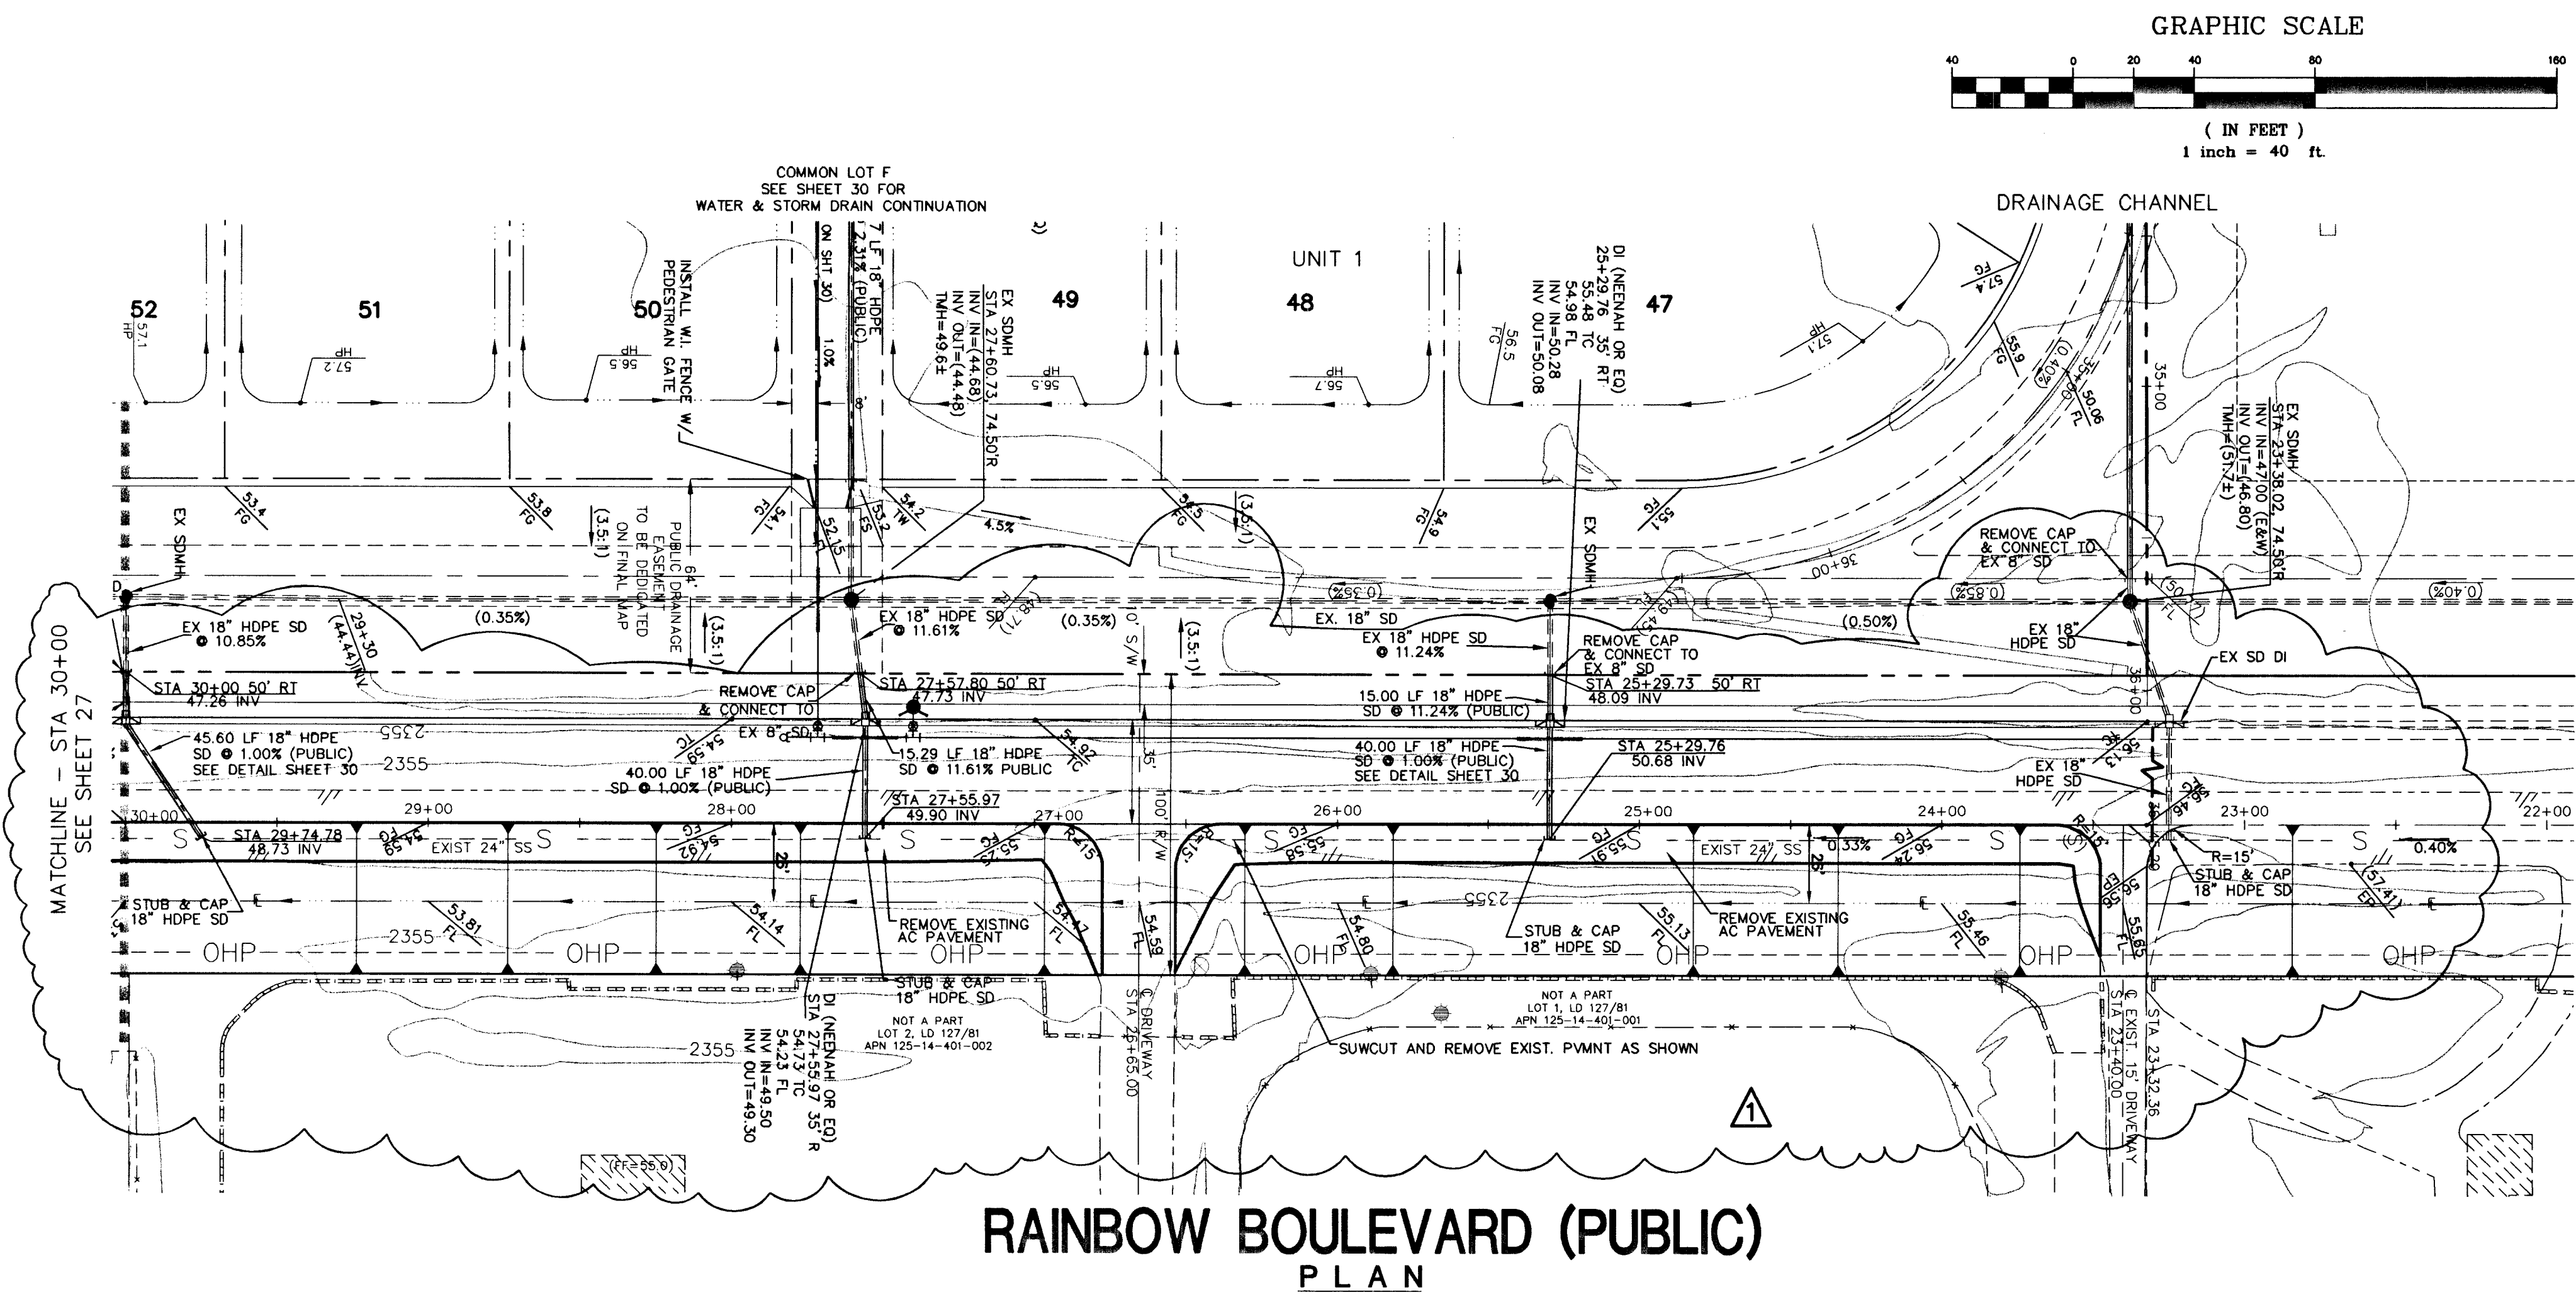

HOPE PIPE CONSTRUCTION NOTE:
CONTRACTOR SHALL PROVIDE 30" MINIMUM COVER OVER HOPE PIPE PRIOR TO VEHICLE LOADING DURING CONSTRUCTION. TRENCH WIDTH MUST BE WIDE ENOUGH TO ACCOMMODATE COMPACTION EQUIPMENT. SEE MANUFACTURER'S GUIDELINES (PRODUCT NOTE 3.115) AND ASTM D2321. CONTRACTOR SHALL NOT USE HYDRO-HAMMER TYPE COMPACTIONERS OVER PIPE TRENCH AREA.

RAINBOW BOULEVARD (PUBLIC) PROFILE

SCALE: HORIZ. 1" = 40'
VERT. 1" = 4'

APPROVAL FOR CONSTRUCTION
1st App'd. 5/7/02
Robert J. Morgan
LAS VEGAS VALLEY WATER DISTRICT
2/26/04
DATE

BASIS OF BEARING
THE BASIS OF BEARING FOR THIS SURVEY IS THE WEST LINE OF THE SOUTHEAST QUARTER (SE 1/4) OF SECTION 15, TOWNSHIP 19 SOUTH, RANGE 60 EAST, M.D.M., CLARK COUNTY, NEVADA, AS SHOWN IN FILE 115, PAGE 13 OF OFFICIAL RECORDS, CLARK COUNTY, NEVADA. I.E. NORTH 00°11'55" EAST

Call before you do Overhead
1-702-593-6111

Call before you Dig.
1-800-227-2600

REV.	DESCRIPTION	DATE	APP'D.
1	REV. STREET SECTION 1-27-04 (RE-PLOTTED)	3/1/04	AKS

PULTE HOMES
1635 VILLAGE CENTER CIRCLE, SUITE 250
LAS VEGAS, NEVADA 89113
(702) 256-7900

PENTACORE
PENTACORE CONSTRUCTION MANAGEMENT, INC.
1635 VILLAGE CENTER CIRCLE, SUITE 250
LAS VEGAS, NEVADA 89113
(702) 256-7900

RAINBOW BOULEVARD STA 23+32.36 TO STA 30+00.00 PLAN AND PROFILE
WYETH RANCH UNIT 1

DATE:	11/26/01
DRAWN BY:	
DESIGNED BY:	
CHECKED BY:	
JOB NO.:	01470231
SCALE:	1"=40'

PROFESSIONAL ENGINEER - STATE OF NEVADA
RICHARD W. CUMMINGS
EX-1234
CIVIL
5447

SHEET **28** OF 41
C.L.V. DWG # 107Y-4699