
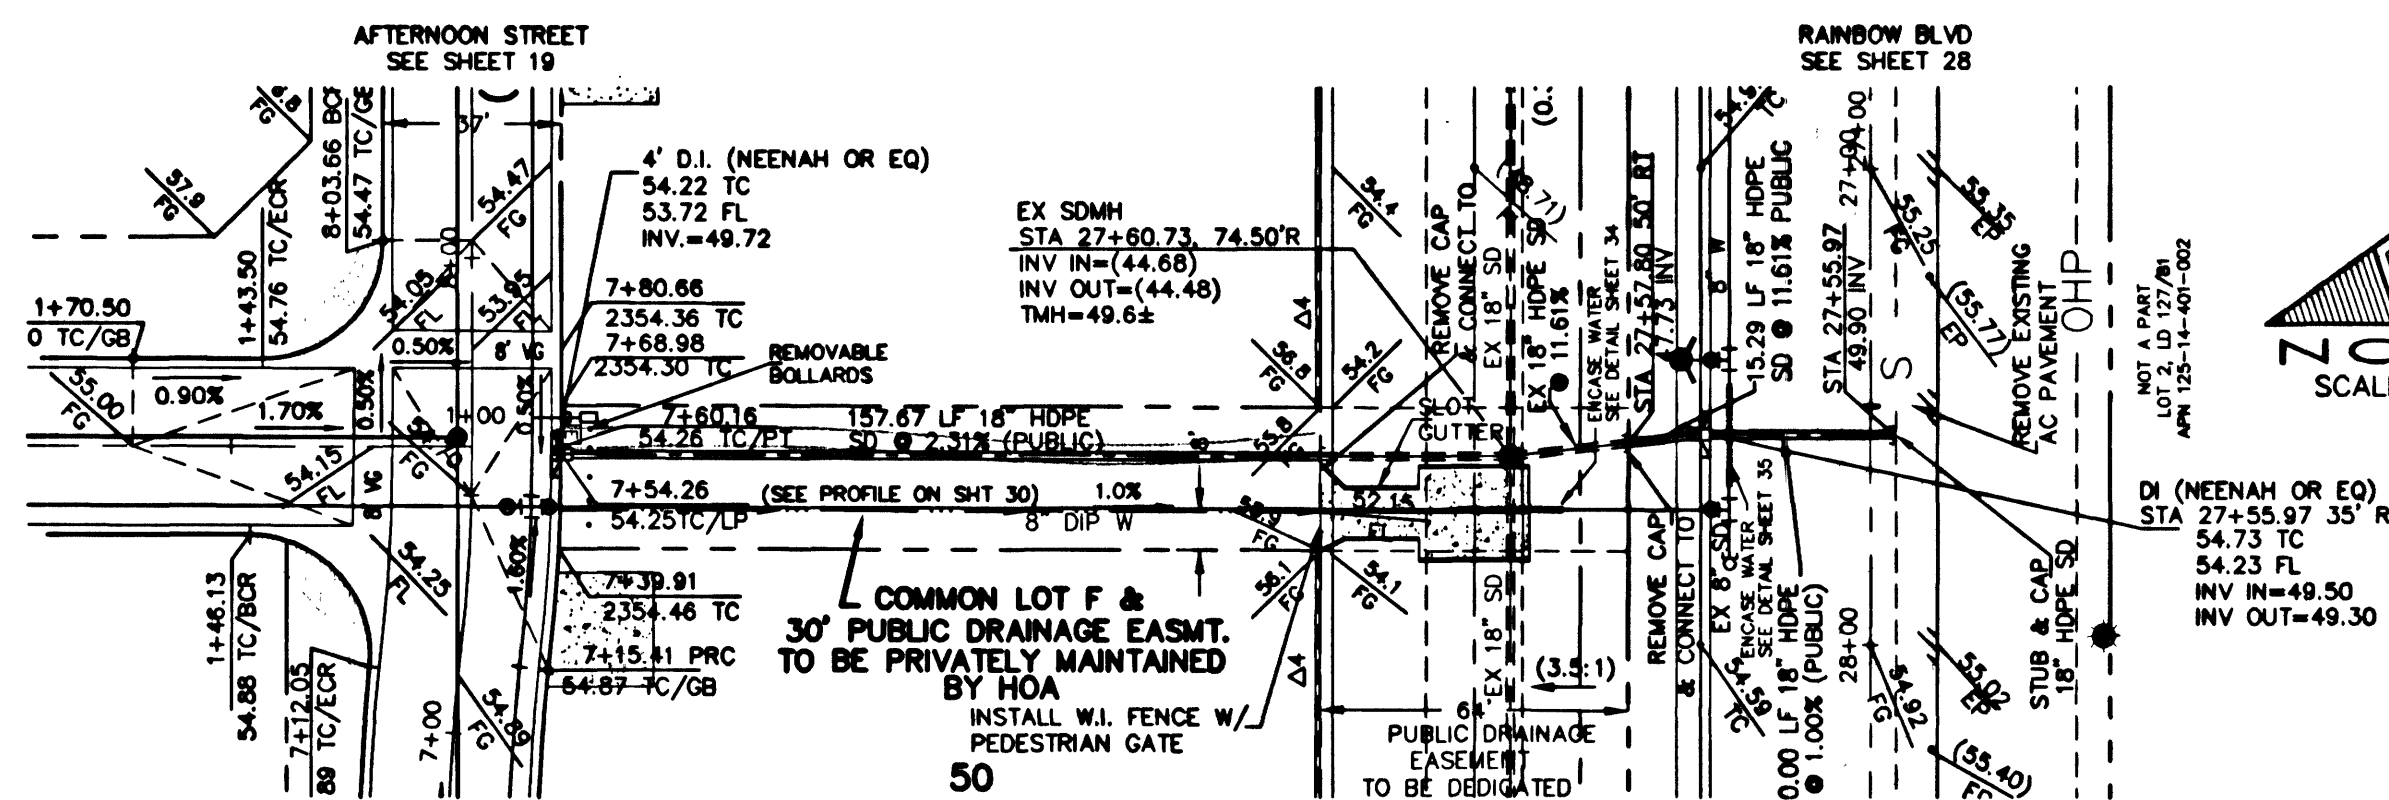


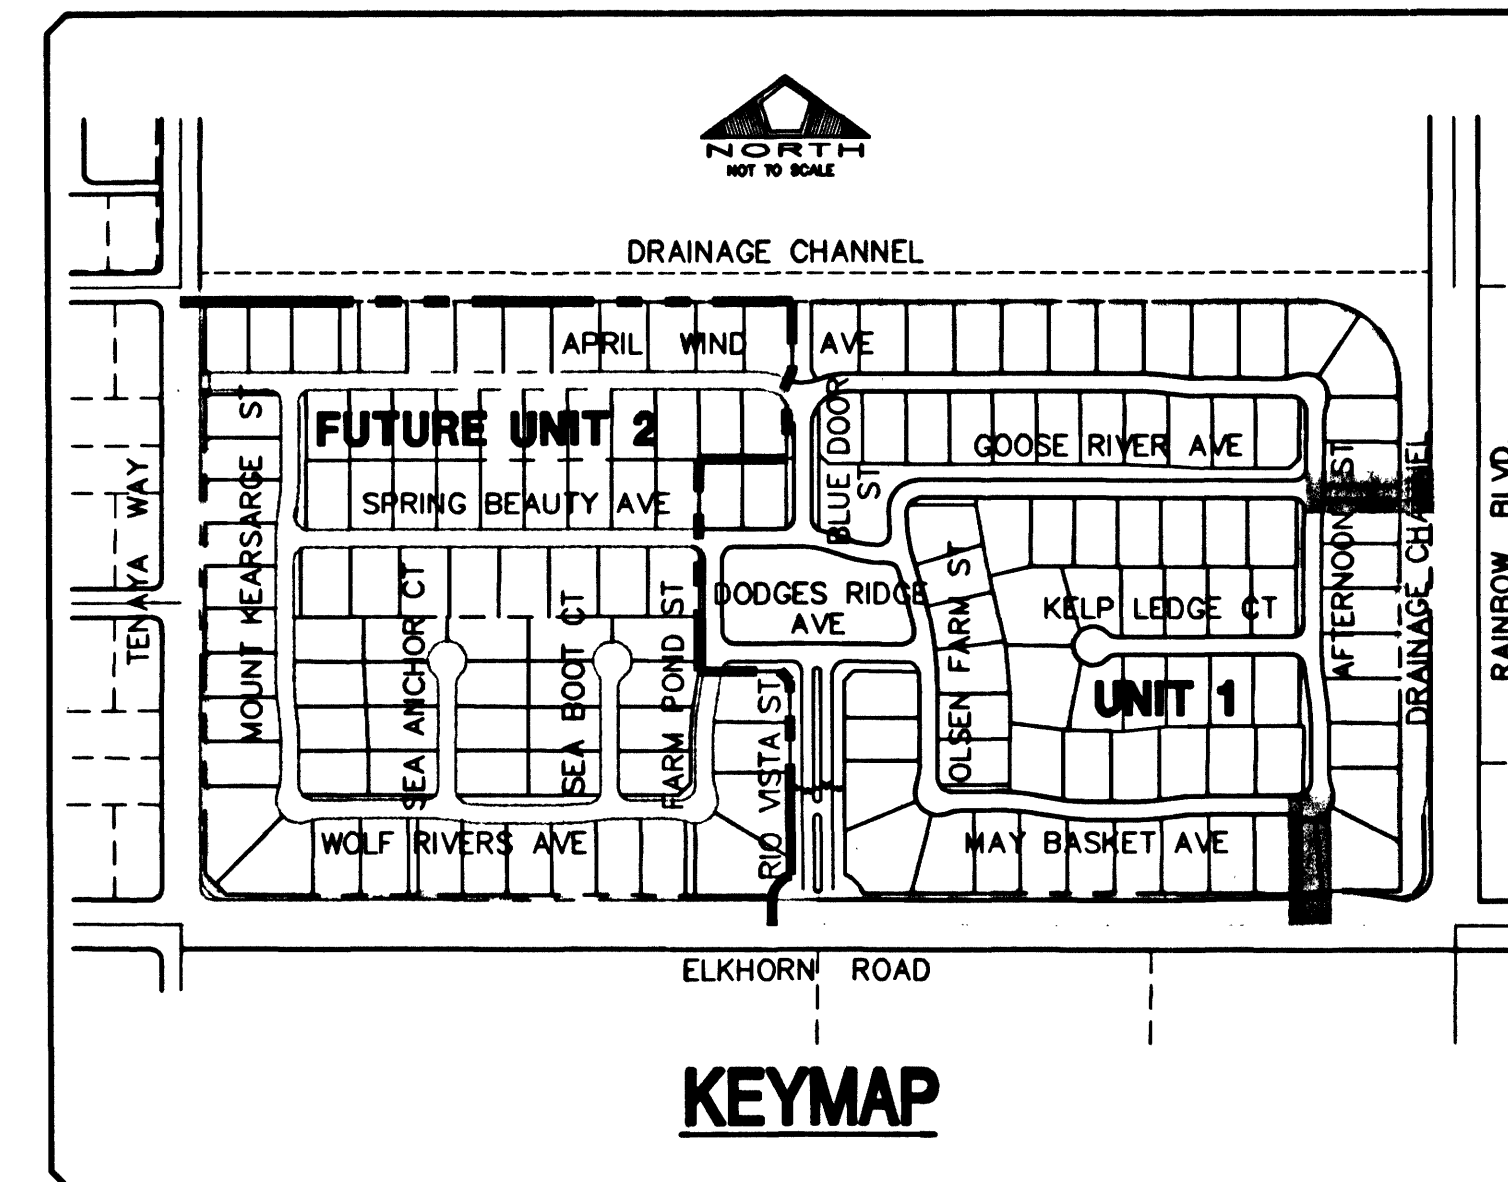

Profile view of a sewer line showing elevations, stationing, and pipe details.

Left Side (Station 1+00 to 2+00):

- ELKHORN RD. STA 1+50 CL INT
- 2353.27 FG
- SSMH# 1-1 STA 1+35.78
- TM=2352.83
- 2346.69 INV IN
- 2346.69 INV OUT
- STA 2+01.20
- 2352.78 TC

Right Side (Station 3+00 to 4+00):

- 4" D.I. MEEHAW OR EQUAL (SEE DETAIL SHEET 8)
- 2353.00 TC
- 2353.00 FG
- INV = 2348.87
- STA 3+56.40 CL INT
- 2353.44 FG
- 4" D.I. MEEHAW OR EQUAL (SEE DETAIL SHEET 8)
- STA 3+56.40
- 2353.16 TC
- INV = 2349.17
- (SEE DETAIL SHEET 8)

Center Line (Station 2+00 to 3+00):

- FINISH GRADE ● CL
- EXISTING GROUND ● CL
- 189.84 LF 18" HDPE SD @ 1.78%
- 2347.31 INV
- ENCASE WATER LINE PER DETAIL SHEET 35
- 262.64 LF 8" PVC SEWER @ 0.40% (PUBLIC)
- 6" MIN
- 52.69 LF HDPE SD @ 0.50%
- 6" MIN

Bottom Labels:

- SSMH# 1-1 STA 1+35.78
- TM=2352.83
- 2344.64 (8") INV IN
- (2343.66) (27") INV
- SSMH# 1-2 STA 3+56.40
- TM=2353.34
- 2345.69 INV IN
- 2345.69 INV OUT

SHEET 30 OF 41
C.L.V. DWG.#

[illegible]

PULTE HOMES
635 VILLAGE CENTER CIRCLE, SUITE 250
LAS VEGAS, NEVADA 89134
(702) 256-7900

PENTACORE
CIVIL ENGINEERING · LAND SURVEYING · PLANNING
CONSTRUCTION MANAGEMENT · ADA CONSULTING
6763 WEST CHARLESTON BOULEVARD
LAS VEGAS, NEVADA 89146 (702)238-0115

COMMON LOT "C" AND "F"
STORM DRAIN
PLAN AND PROFILE

WYETH RANCH
UNIT 1

DATE :	11/19/01
PM :	SLY
DRAWN BY :	
DESIGNED BY :	
CHECKED BY :	
ADA CHECKED :	
JOB NO. :	0147.0230
SCALE :	1" = 40'