
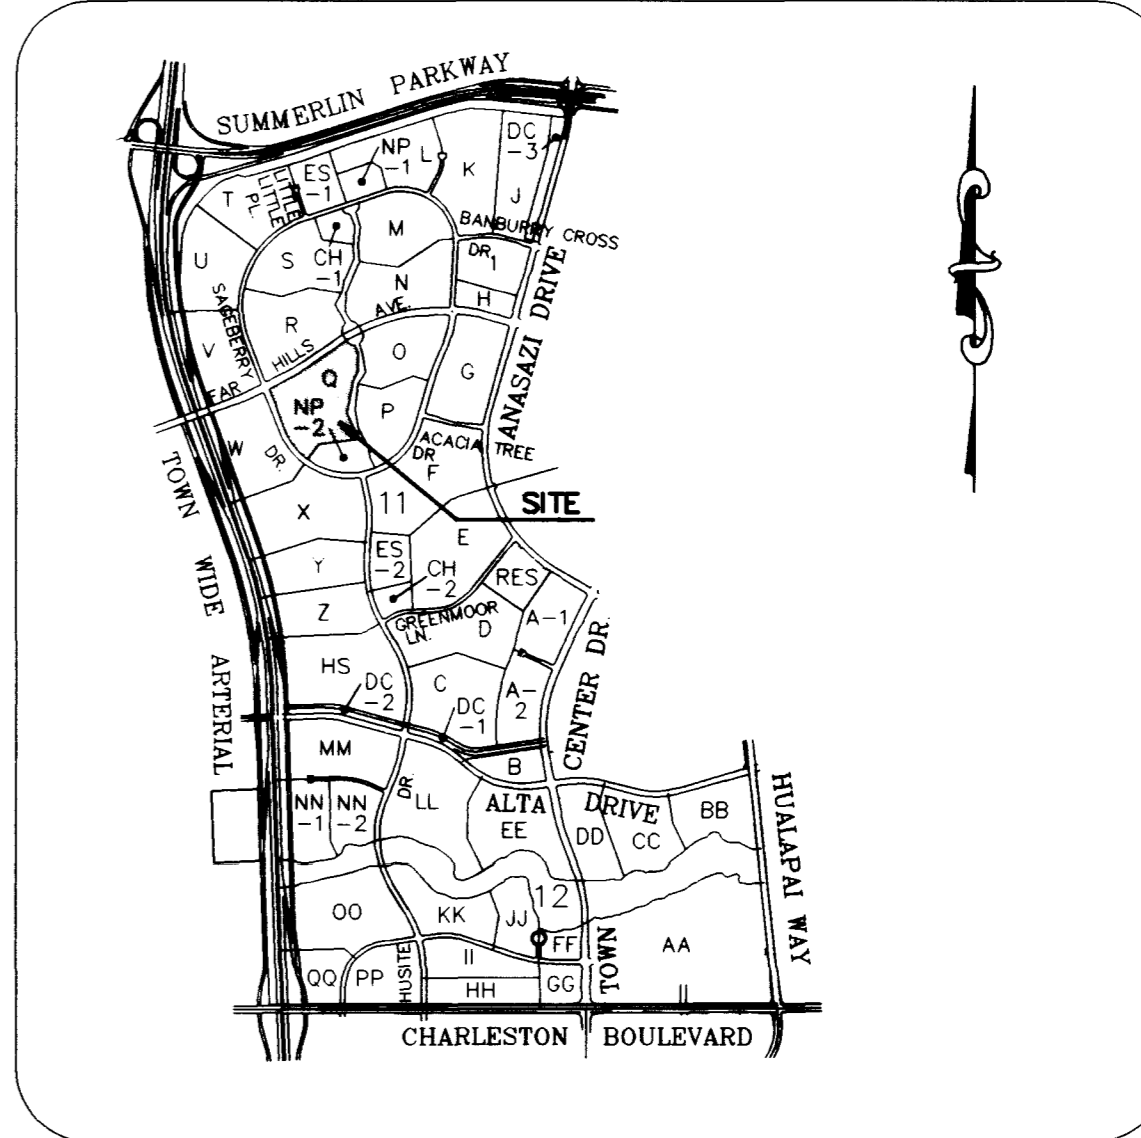


PROJECT VICINITY
SEE AREA MAP

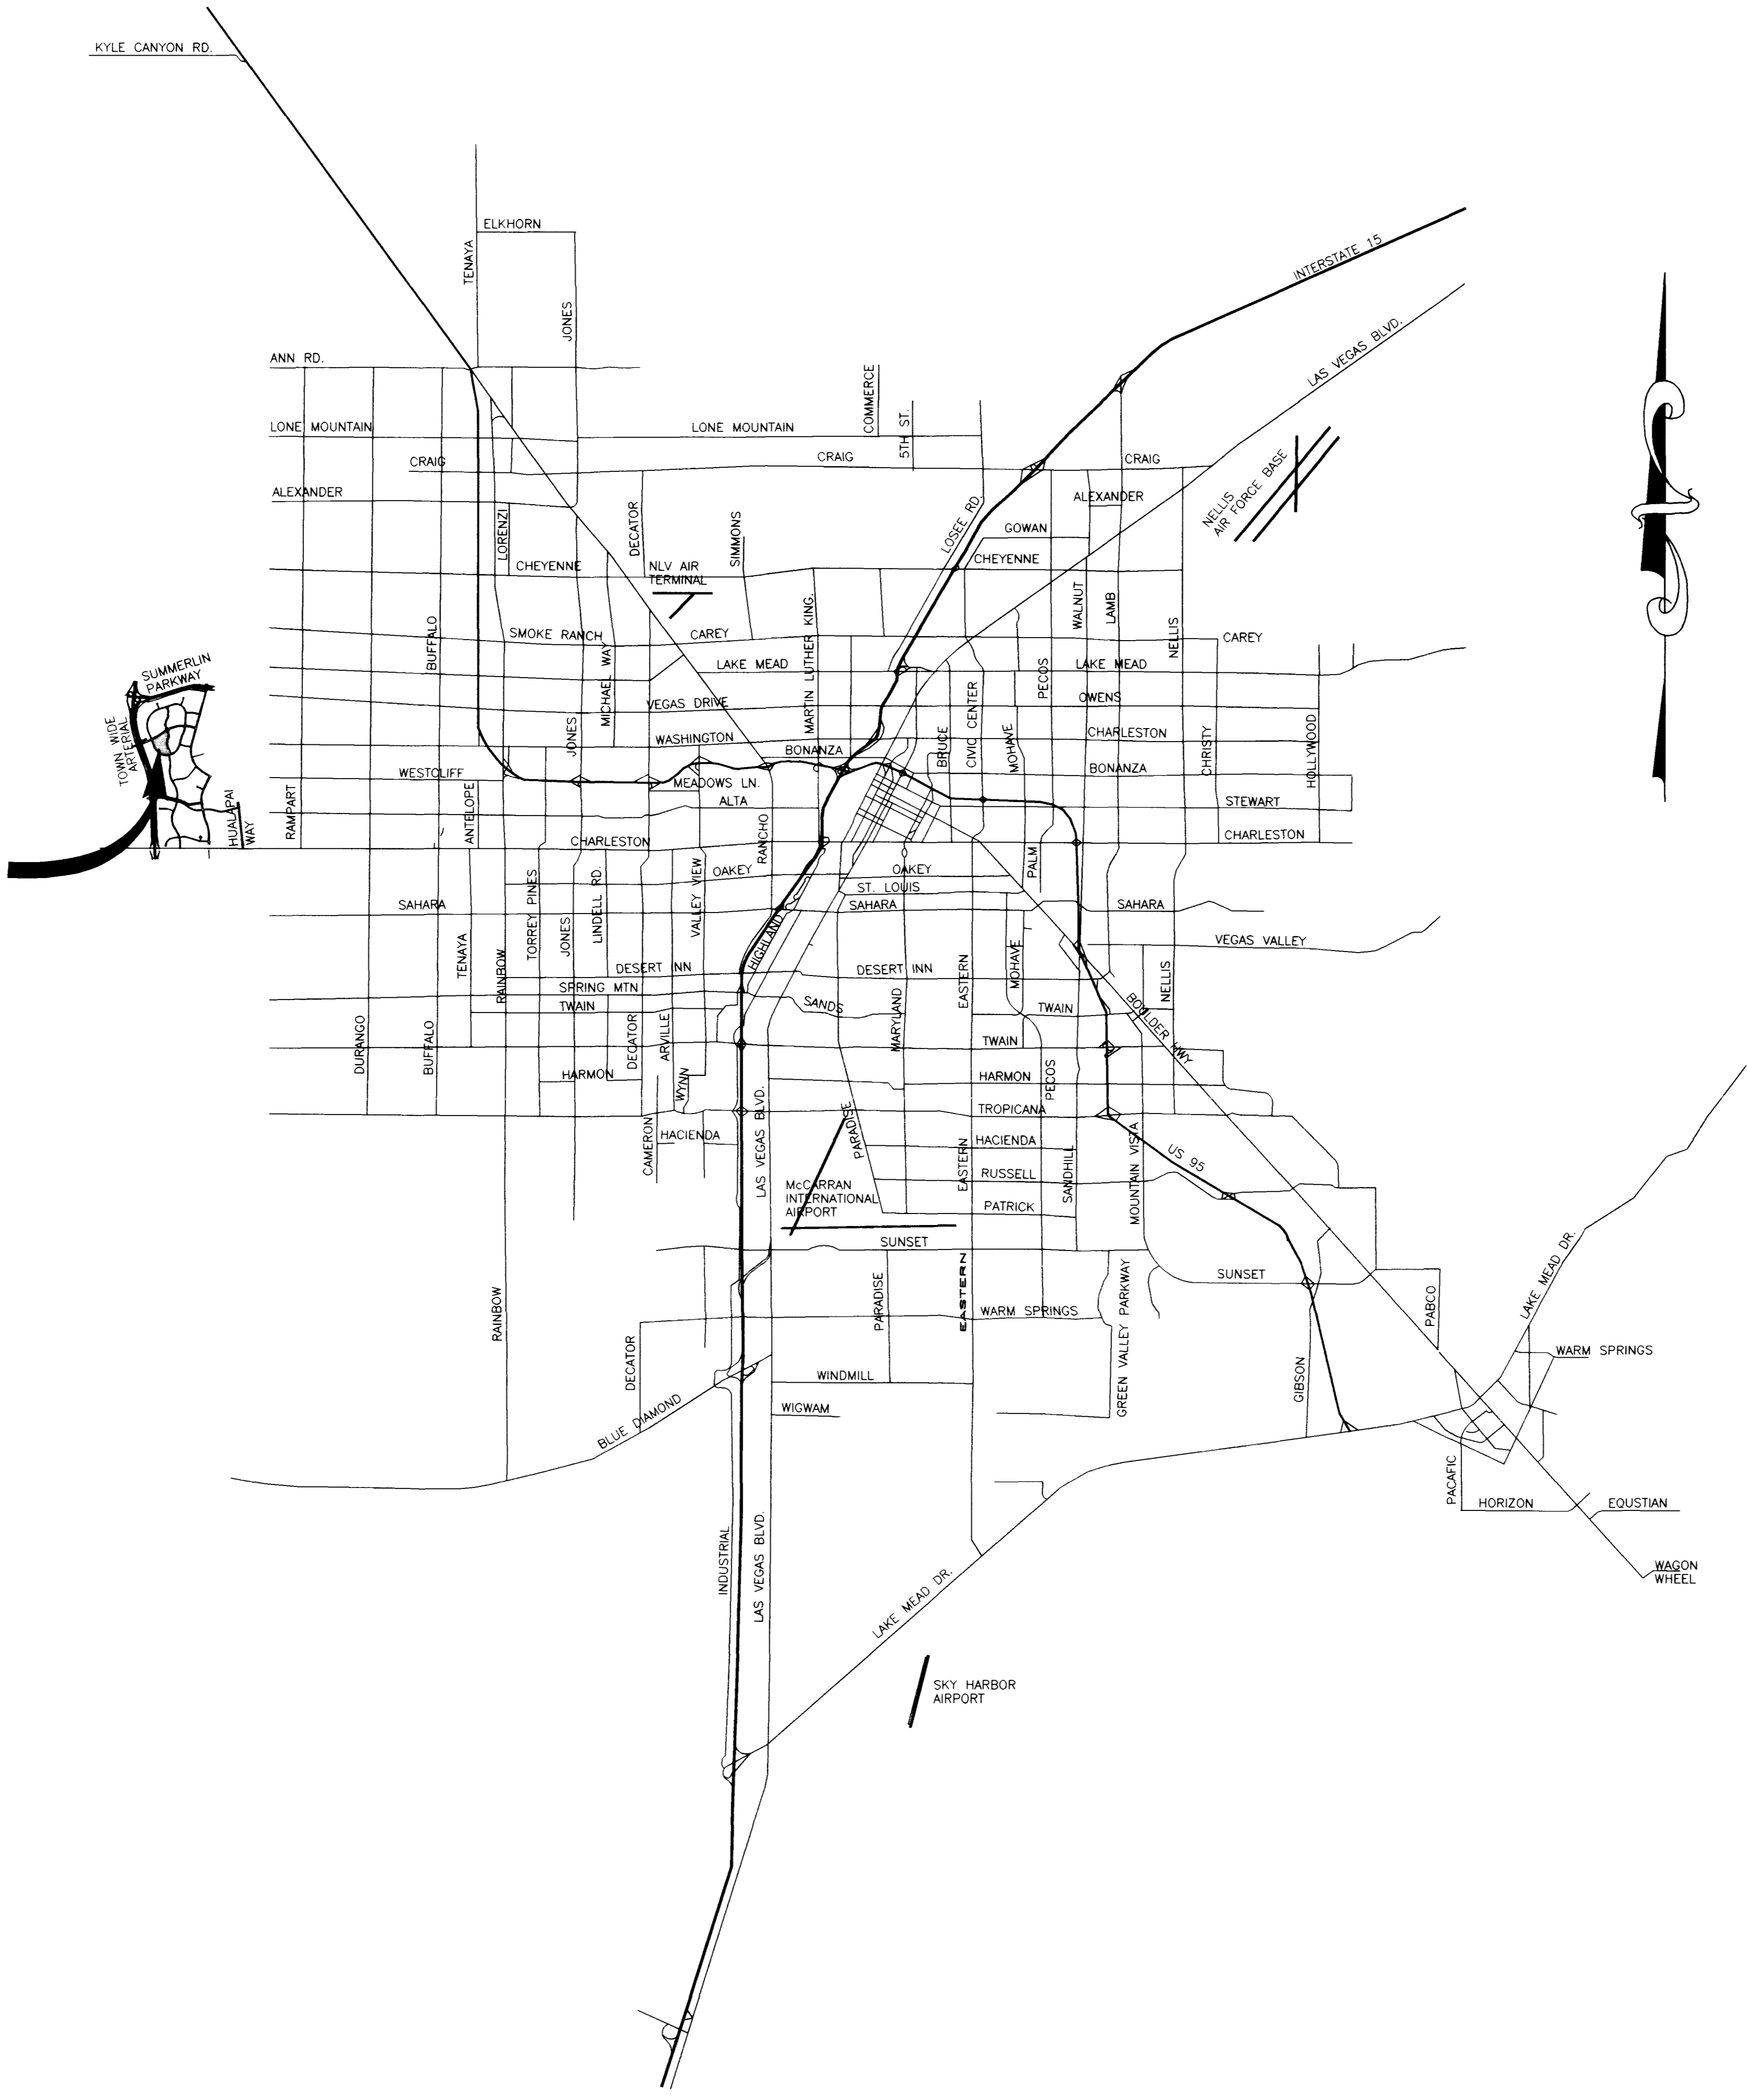

AREA MAP
SCALE: NONE

SHEET INDEX

SHEET #	SHEET	DESCRIPTION
1	C1	COVER SHEET
2	C2	VICINITY MAP
3	C3	GENERAL NOTES
4	C4	QUANTITIES
5	C5	MASTER UTILITY PLAN
6	C6	MASTER UTILITY PLAN
7	C7	MASTER UTILITY PLAN
8	C8	MASTER UTILITY PLAN
9	G1	GRADING PLAN
10	G2	GRADING PLAN
11	G3	GRADING PLAN
12	G4	GRADING PLAN
13	G5	GRADING DETAILS
14	S1	STREET PLAN & PROFILE - CARDINAL CREST AVENUE
15	S2	STREET PLAN & PROFILE - WINTER TEAL AVENUE
16	S3	STREET PLAN & PROFILE - SUMMER QUAIL AVENUE
17	S4	STREET PLAN & PROFILE - DESERT DOVE AVENUE & EVENING LARK AVENUE
18	S5	STREET PLAN & PROFILE - CLIFF SWALLOW AVENUE
19	S6	STREET PLAN & PROFILE - WHITE FALCON STREET
20	S7	STREET PLAN & PROFILE - EAGLEWOOD STREET STA 10+00.00 TO 16+00.0
21	S8	STREET PLAN & PROFILE - EAGLEWOOD STREET STA 16+00.00 TO 23+34.93
22	S9	TYPICAL STREET SECTIONS
23	TS1	STREET LIGHTING PLAN & SIGNAGE PLAN
24	TS2	STREET LIGHTING PLAN & SIGNAGE PLAN
25	TS3	STREET LIGHTING PLAN & SIGNAGE PLAN
26	TS4	STREET LIGHTING PLAN & SIGNAGE PLAN
27	SS1	SANITARY SEWER PLAN & PROFILE - CARDINAL CREST AVENUE
28	SS2	SANITARY SEWER PLAN & PROFILE - WINTER TEAL AVENUE
29	SS3	SANITARY SEWER PLAN & PROFILE - SUMMER QUAIL AVENUE
30	SS4	SANITARY SEWER PLAN & PROFILE - DESERT DOVE AVENUE & EVENING LARK AVENUE
31	SS5	SANITARY SEWER PLAN & PROFILE - CLIFF SWALLOW AVENUE
32	SS6	SANITARY SEWER PLAN & PROFILE - WHITE FALCON STREET
33	SS7	SANITARY SEWER PLAN & PROFILE - EAGLEWOOD STREET STA 10+00.00 TO 16+00.0 & EAGLEWOOD ST. TO EXISTING SEWER
34	SS8	SANITARY SEWER PLAN & PROFILE - EAGLEWOOD STREET STA 16+00.00 TO 23+11.78
35	SD1	STORM DRAIN & PROFILE

WOODSIDE HOMES	
3855 S. JONES #102 LAS VEGAS, NV 89103 (702) 889-7800	
vicinity nevada	
CONSULTING ENGINEERS • PLANNERS • LAND SURVEYORS INC. (702) 414-7500 FAX (702) 462-1997 3227 SOUTH RAINBOW BOULEVARD LAS VEGAS, NEVADA 89102-6148	
VICINITY MAP	QUAIL RIDGE
SHEET	TITLE
DRAWN BY: SNA	SCALE: -
DESIGNED BY: SNA	DATE: 12/97
CHECKED BY: DE	DATE: 12/97
PROJECT NO: E280	DATE: 12/97
C2 2 of 35 SHEETS DRAWING NO. 1074-4552	

