

Avoid cutting underground utility lines. It's costly.

Avoid overhead power line contact




Call before you Dig
1-800-227-2600

Call before you OVERHEAD
1-702-593-6111

BENCHMARK


PROJECT DATUM SUMMERLIN
CLV BENCHMARK NO. CLV09365ES
RIVET AND PLATE IN TOP OF CURB NORTHEAST RETURN OF
CHARLESTON BOULEVARD AND HUALAPAI
ELEVATION=2910.05 (SUMMERLIN DATUM)
ELEVATION=887.6503 METERS(2912.23 FEET)=(NAVD 88 DATUM)

NOTE: CONTRACTOR SHALL VERIFY HORIZONTAL AND VERTICAL LOCATION OF EXISTING UTILITIES AND NOTIFY THE DESIGN ENGINEER IMMEDIATELY OF ANY DISCREPANCIES PRIOR TO CONSTRUCTION.

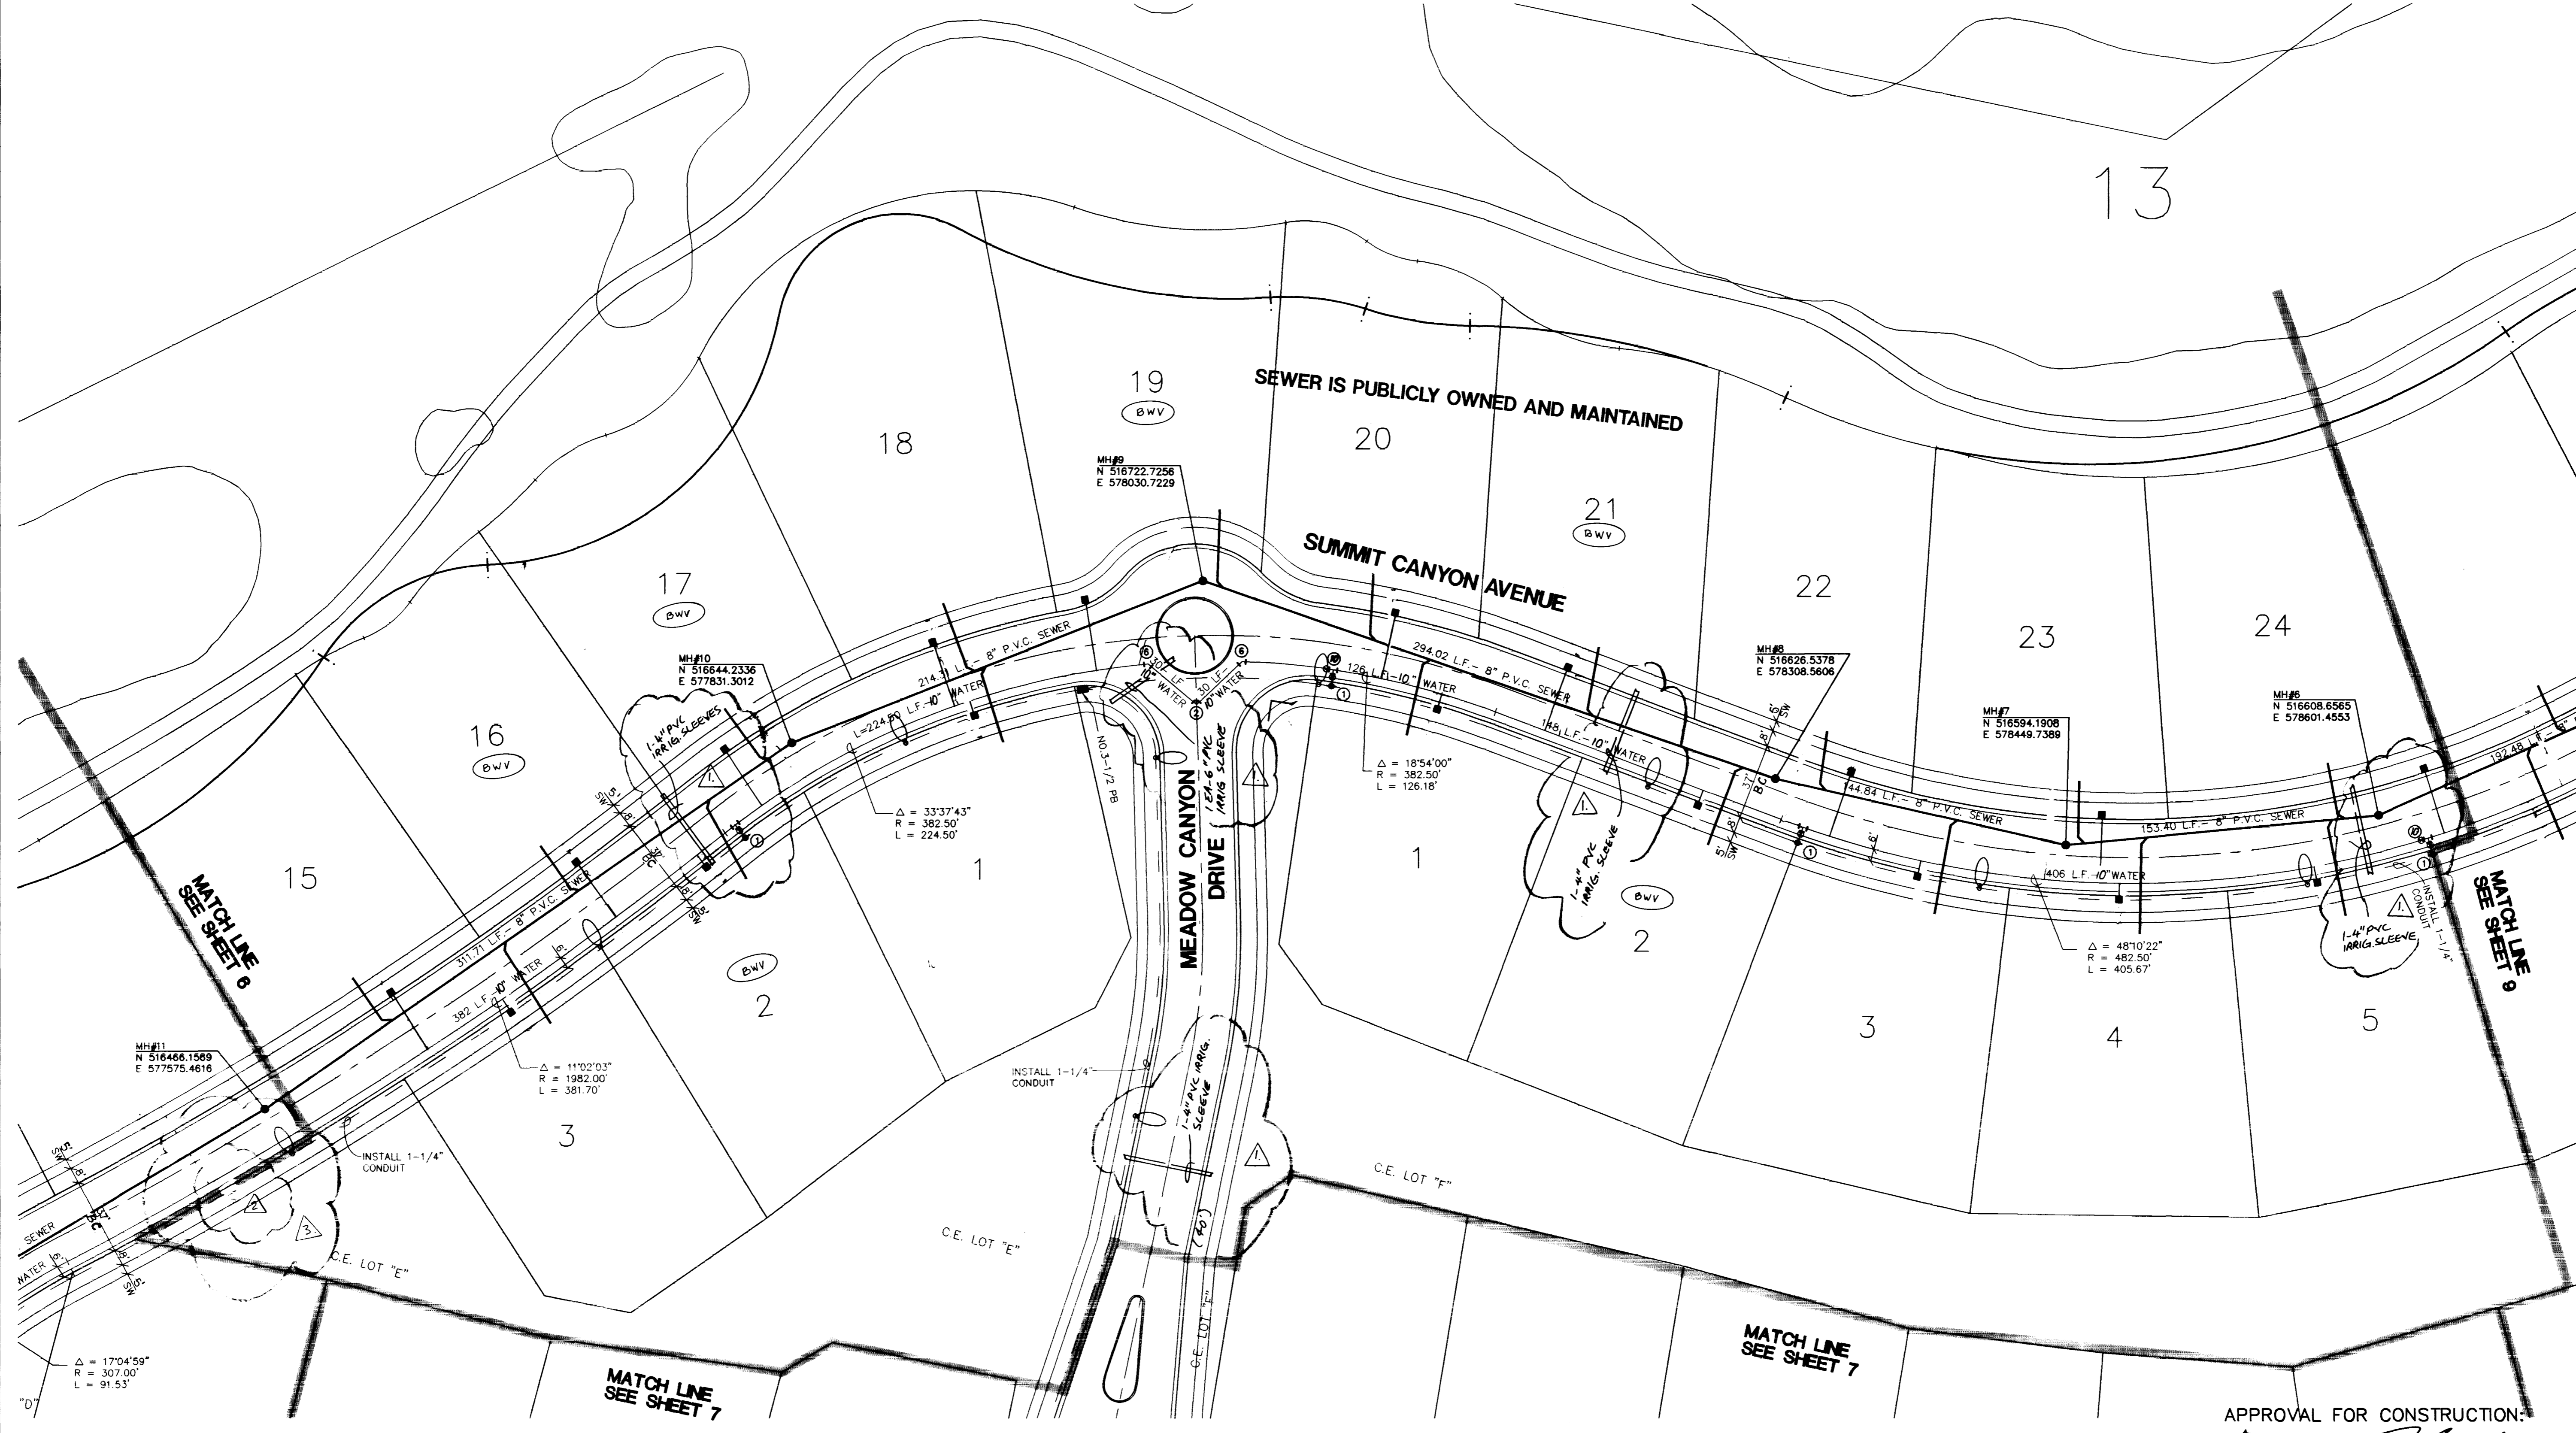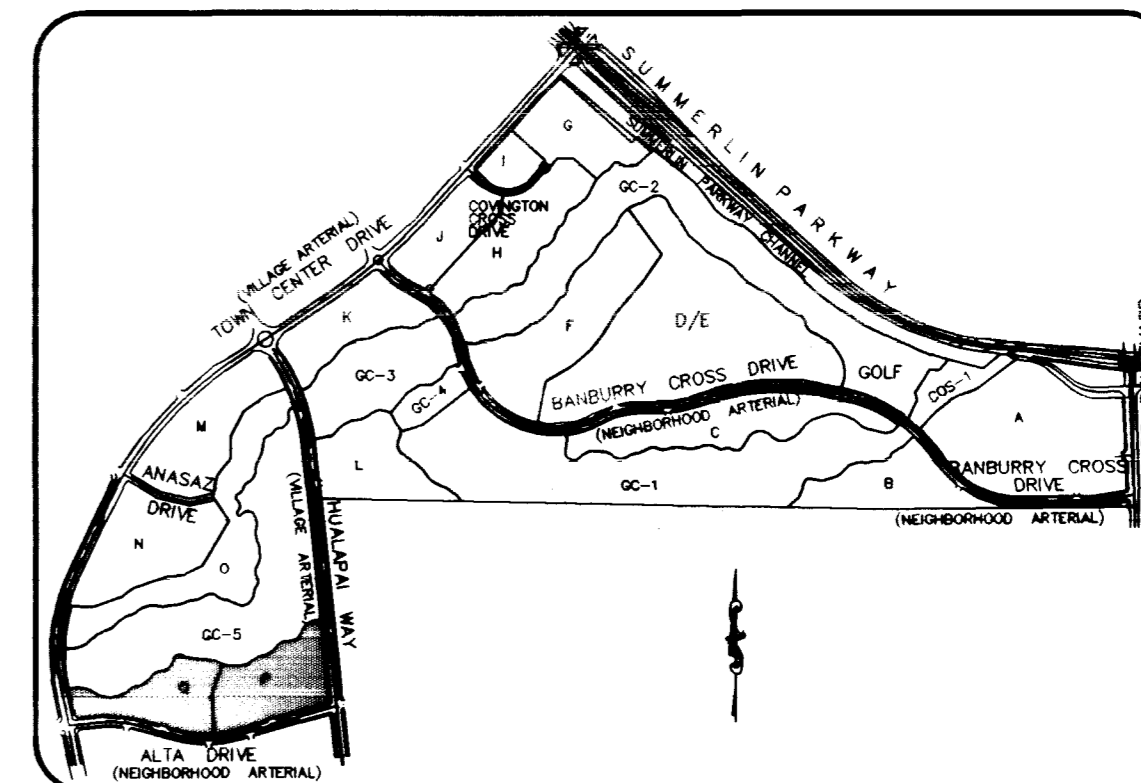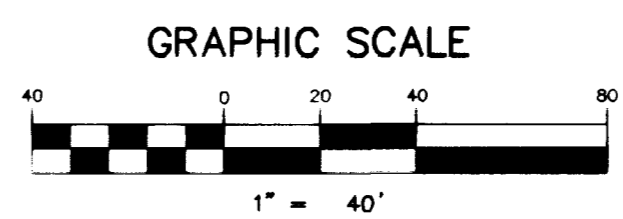


BENTWOOD MEMBERS, L.L.C.

CITY OF LAS VEGAS, NEVADA

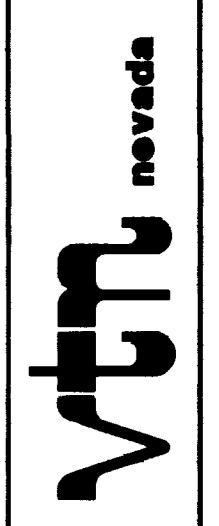

MASTER UTILITY PLAN

STAR CANYON ESTATES
PARCEL "P-Q"-SUMMERLIN VILLAGE 3

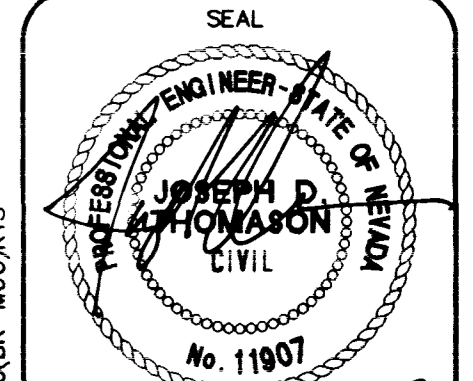

WO NO 5165
BY JOE T./RTS
DATE MAY, 1997
SCALE HORIZ 1"=40'
VERT. NONE
SHEET 8 OF 15 SHEETS

APPROVAL FOR CONSTRUCTION:
LAS VEGAS VALLEY WATER DISTRICT
DATE 4/27/97

H:\CAD\N\DEV\5165\5165SU11.FR, Jun 20 08:27:20 1997 Plotted by

7027

307Y-4526

