
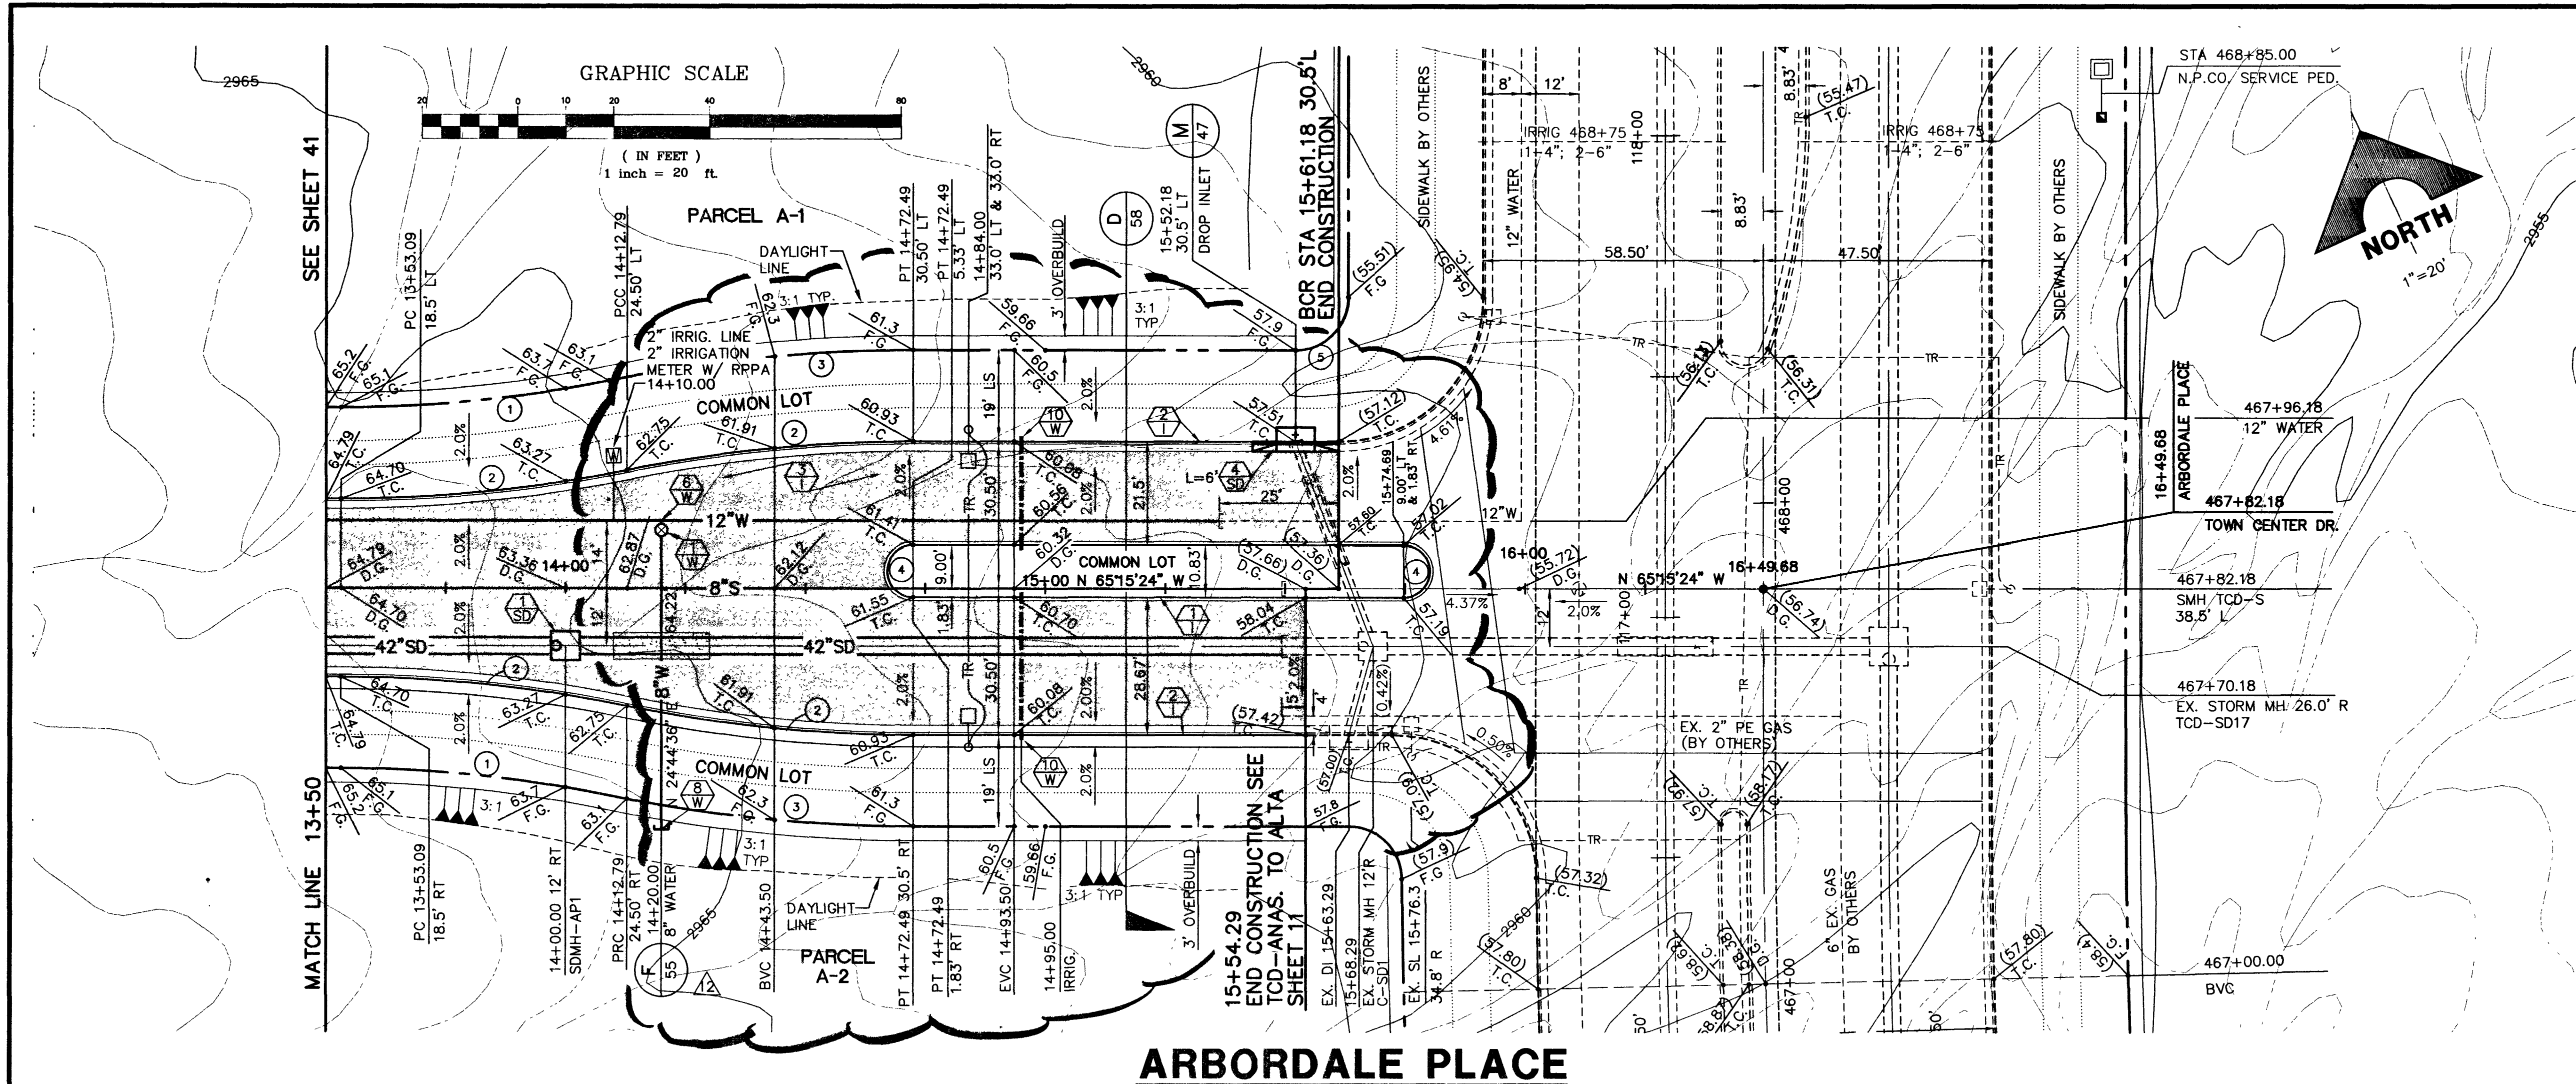


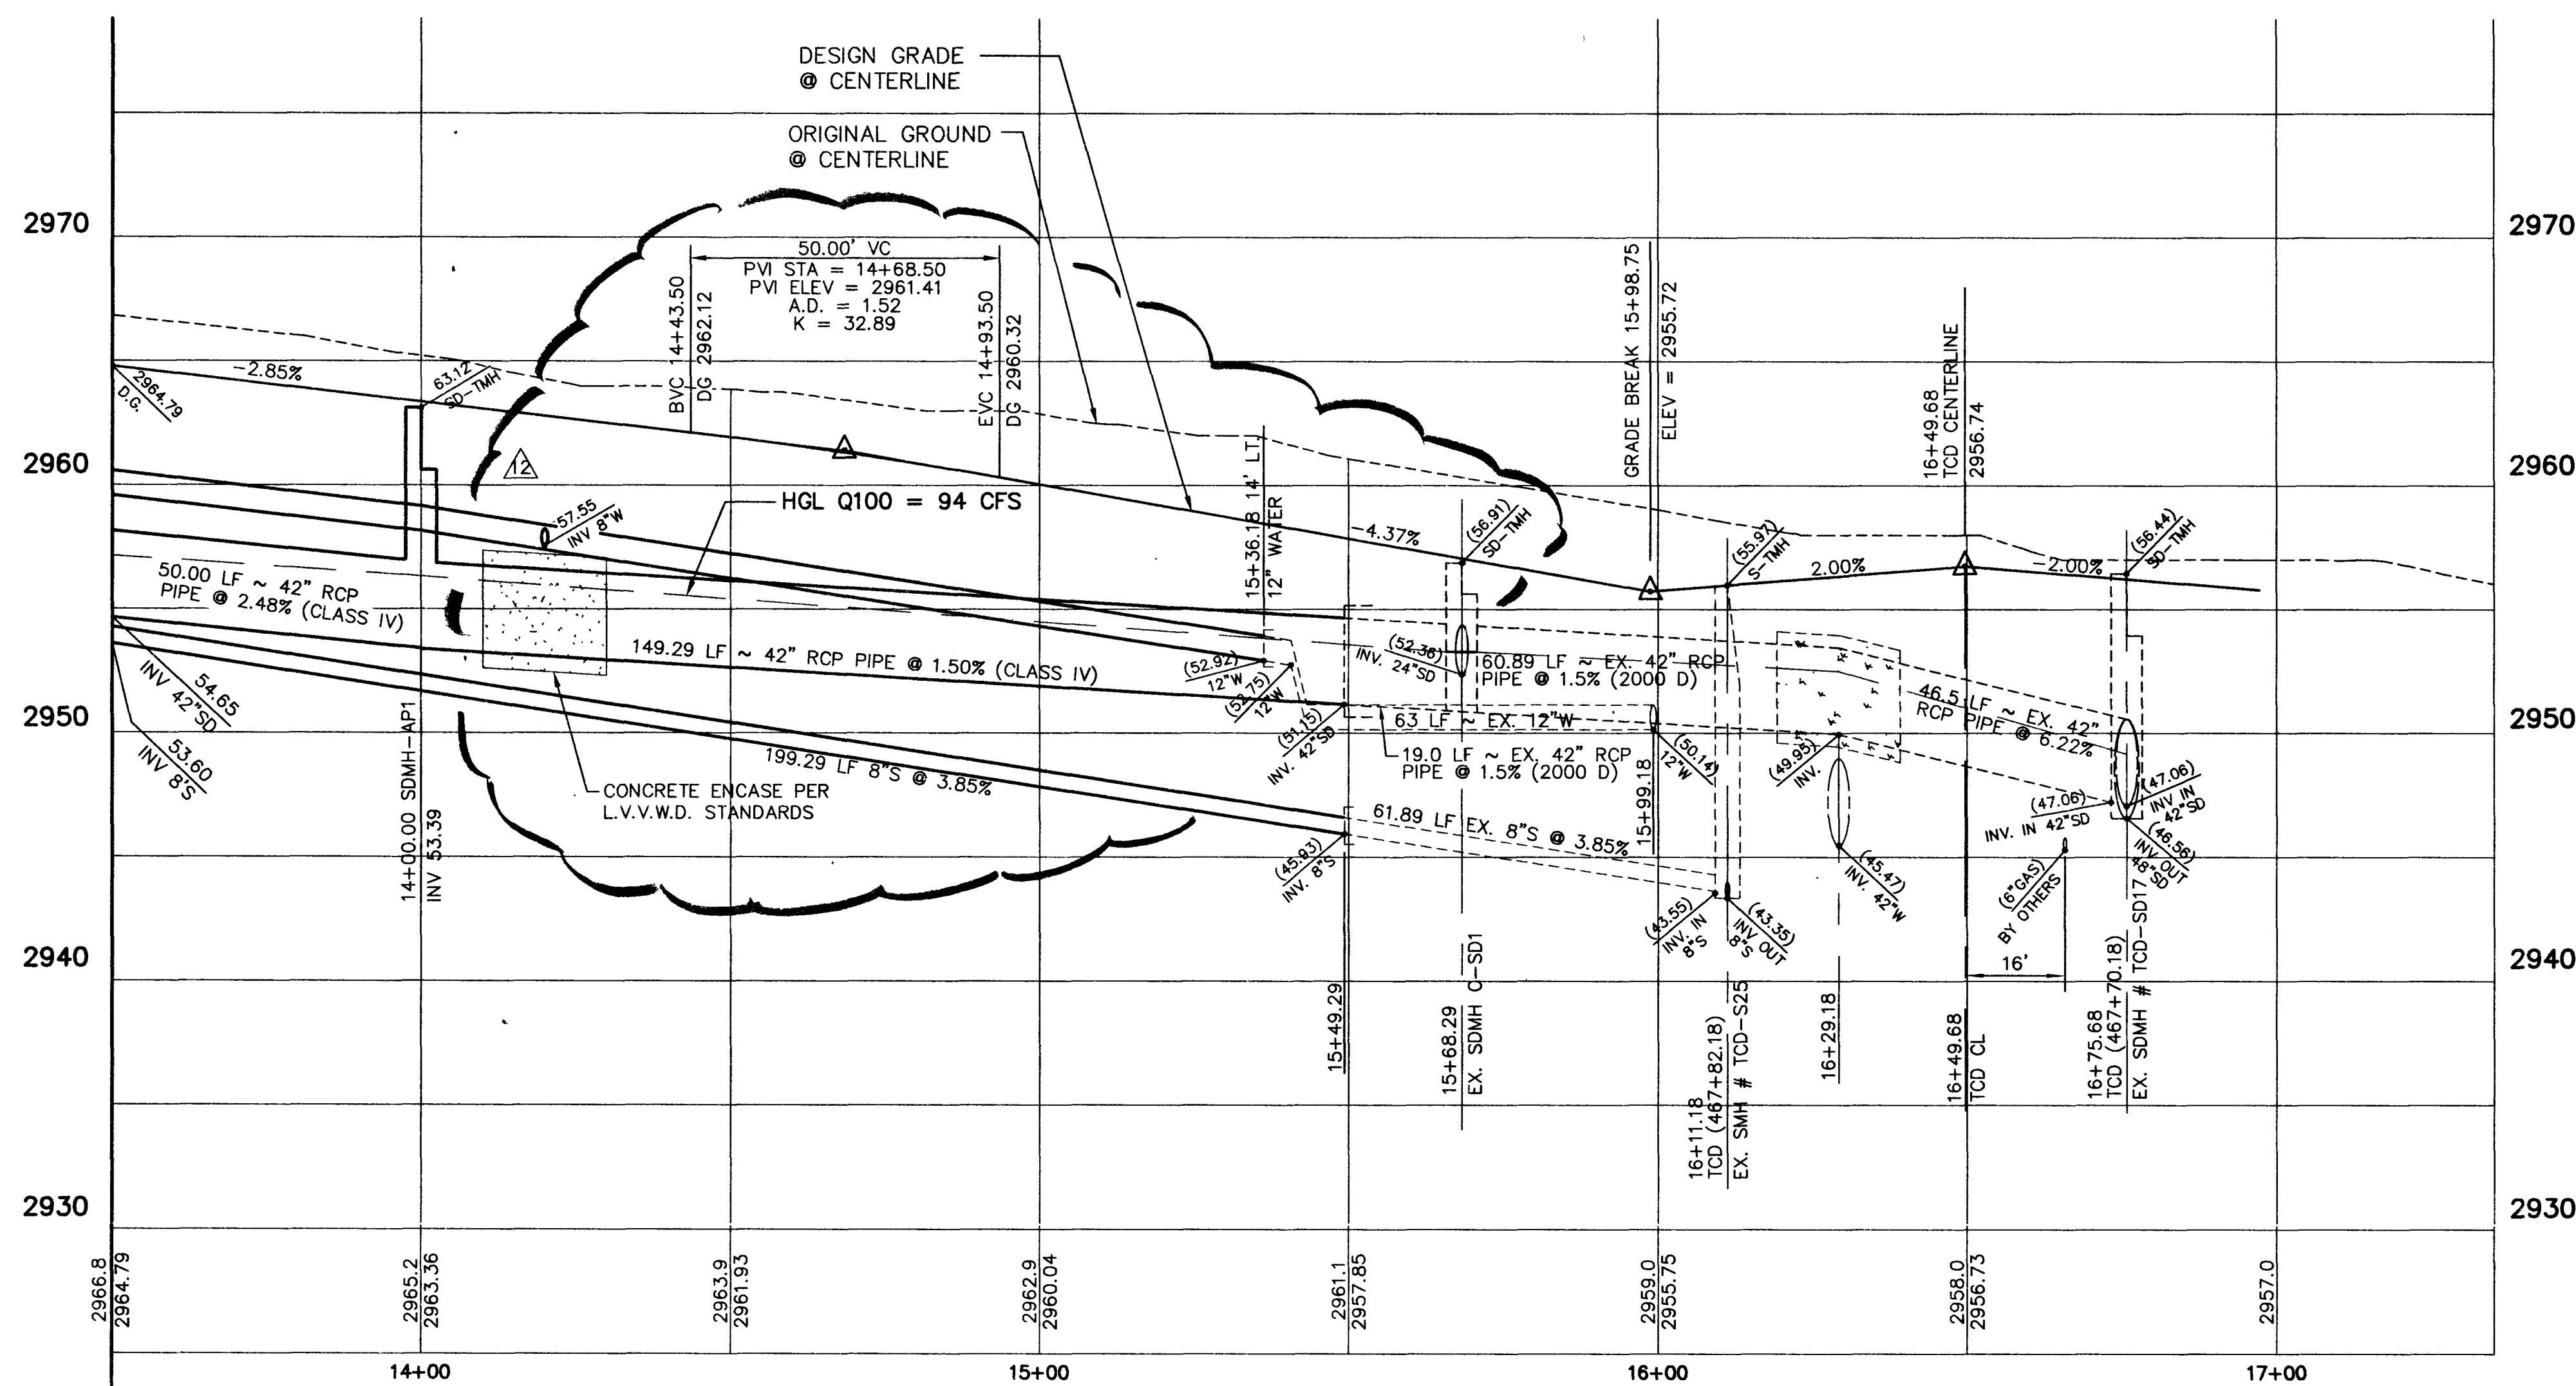

ARBORDALE PLACE

SCALE: HORIZ. 1" = 20'
VERT. 1" = 5'

CURVE DATA

① INDICATES CURVE NUMBER (THIS SHEET ONLY)

CURVE	DELTA	RADIUS	LENGTH	TANGENT
1	112°28'42"	281.00'	56.29'	28.24'
2	112°28'42"	303.00'	60.10'	30.15'
3	112°28'42"	319.00'	63.91'	32.06'
4	180°00'00"	5.41'	17.01'	---
5	90°00'00"	11.00'	17.28'	11.00'

CONSTRUCTION NOTES

IMPROVEMENTS

- INSTALL "A" TYPE CURB (S-50)
- INSTALL "L" TYPE CURB & GUTTER (S-47)
- INSTALL AC PAVEMENT PER SECTION SHEETS 56, 57, & 58
- INSTALL CROSSWALK (S-78)
- INSTALL DEPRESSED CURB (S-75)

WATER

INSTALL WATER PIPES PER SUMMERLIN STD. U-20

- INSTALL 12" DIA. GATE VALVE & BOX (U-34)
- INSTALL 8" DIA. GATE VALVE & BOX (U-34)
- INSTALL 12"x12"x12" TEE (U-34)
- INSTALL 12"x12"x12"x12" CROSS (U-34)
- INSTALL 12"x12" ELBOW (U-34)
- INSTALL 12"x12"x8" TEE (U-34)
- INSTALL 12"x12"x8"x6" CROSS (U-34)
- INSTALL 2" TEMP. BLOW-OFF & CAP (U-32)
- INSTALL FIRE HYDRANT ASSEMBLY COMPLETE PER (U-33)
- IRRIGATION SLEEVE (U-18)
- EXISTING GATE VALVE MUST BE IN CLOSED POSITION PRIOR TO REMOVAL OF CAP

STORM DRAIN

INSTALL STORM DRAIN PIPES PER SUMMERLIN STD. U-20

- INSTALL STORM DRAIN MANHOLE (D1-D10)
- INSTALL 4' TYPE "A" DROP INLET (D-12)
- INSTALL TYPE "B" DROP INLET (D-13)
- INSTALL TYPE "C" MODIFIED DROP INLET (D-14)
- INSTALL 6' TYPE "A" DROP INLET (D-12)

SEWER

INSTALL SEWER PIPES PER SUMMERLIN STD. U-20


- INSTALL SEWER MANHOLE (SD1-8 CLV)

STREET LIGHTING

- INSTALL STREET LIGHT, SEE ELECTRICAL PLANS (E-2)
- STREET LIGHT OR COMMON TRENCH, SEE ELECTRICAL PLANS

TRAFFIC

- INSTALL 2-3" CONDUIT (E-32)
- INSTALL NO. 5 PULLBOX (E-32)

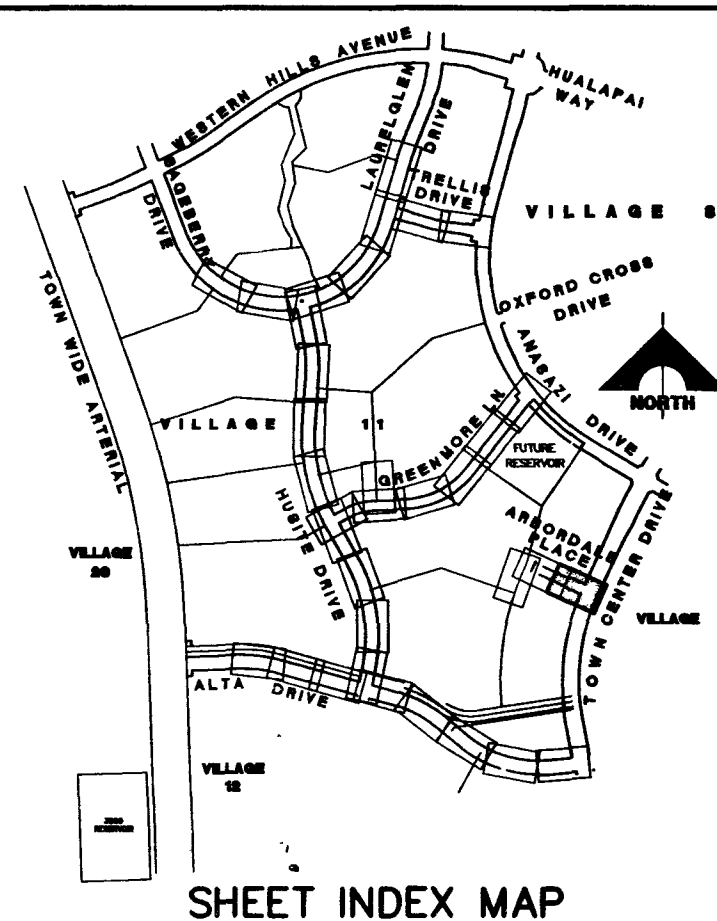

SHEET INDEX MAP

APPROVAL:

For Approval 5-27-96

LAS VEGAS VALLEY WATER DISTRICT

DATE 12-4-96

SUMMERLIN

VILLAGE 11/12 THE ARBORS - UNIT 2A

ARBORDALE PLACE

PLAN & PROFILE
STA 13+50 TO 15+81.18

SHEET

42

SHT 42 OF 64

