
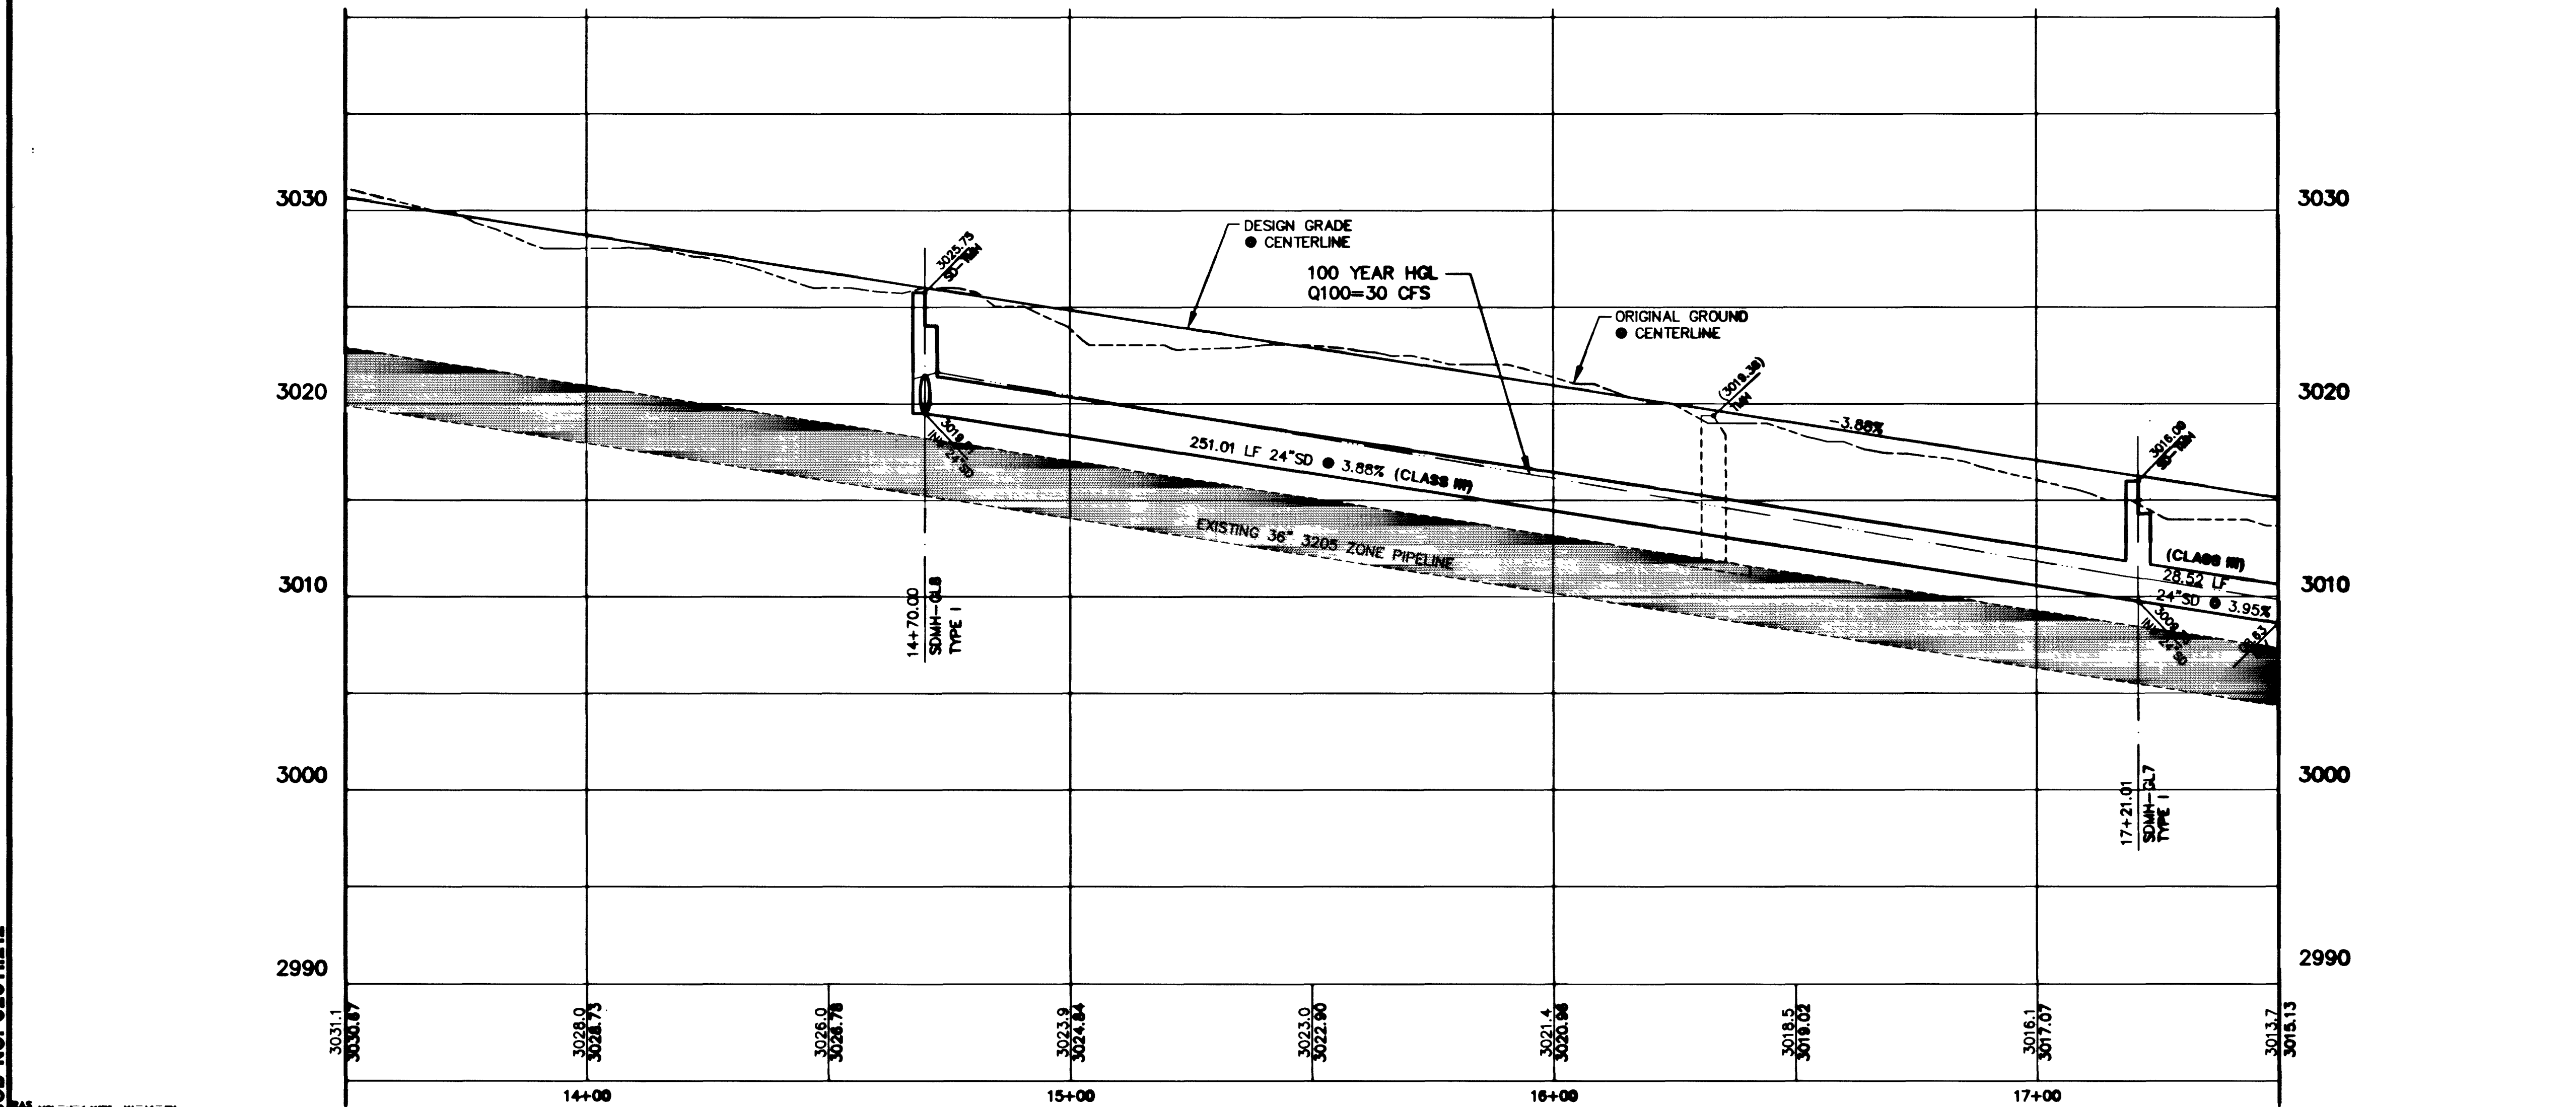


Job No. 82011.212
May 29, 1996 11:18:06 a.m.
Drawing: C:\DWG\11-12\UNIT-2A\OXF-S-2.DWG
Xref: OX-TOPO.DWG OXF-S-MS.DWG

Job No. 82011.212
May 29, 1996 11:18:06 a.m.
Drawing: C:\DWG\11-12\UNIT-2A\OXF-S-2.DWG
Xref: OX-TOPO.DWG OXF-S-MS.DWG

Job No. 82011.212
May 29, 1996 11:18:06 a.m.
Drawing: C:\DWG\11-12\UNIT-2A\OXF-S-2.DWG
Xref: OX-TOPO.DWG OXF-S-MS.DWG

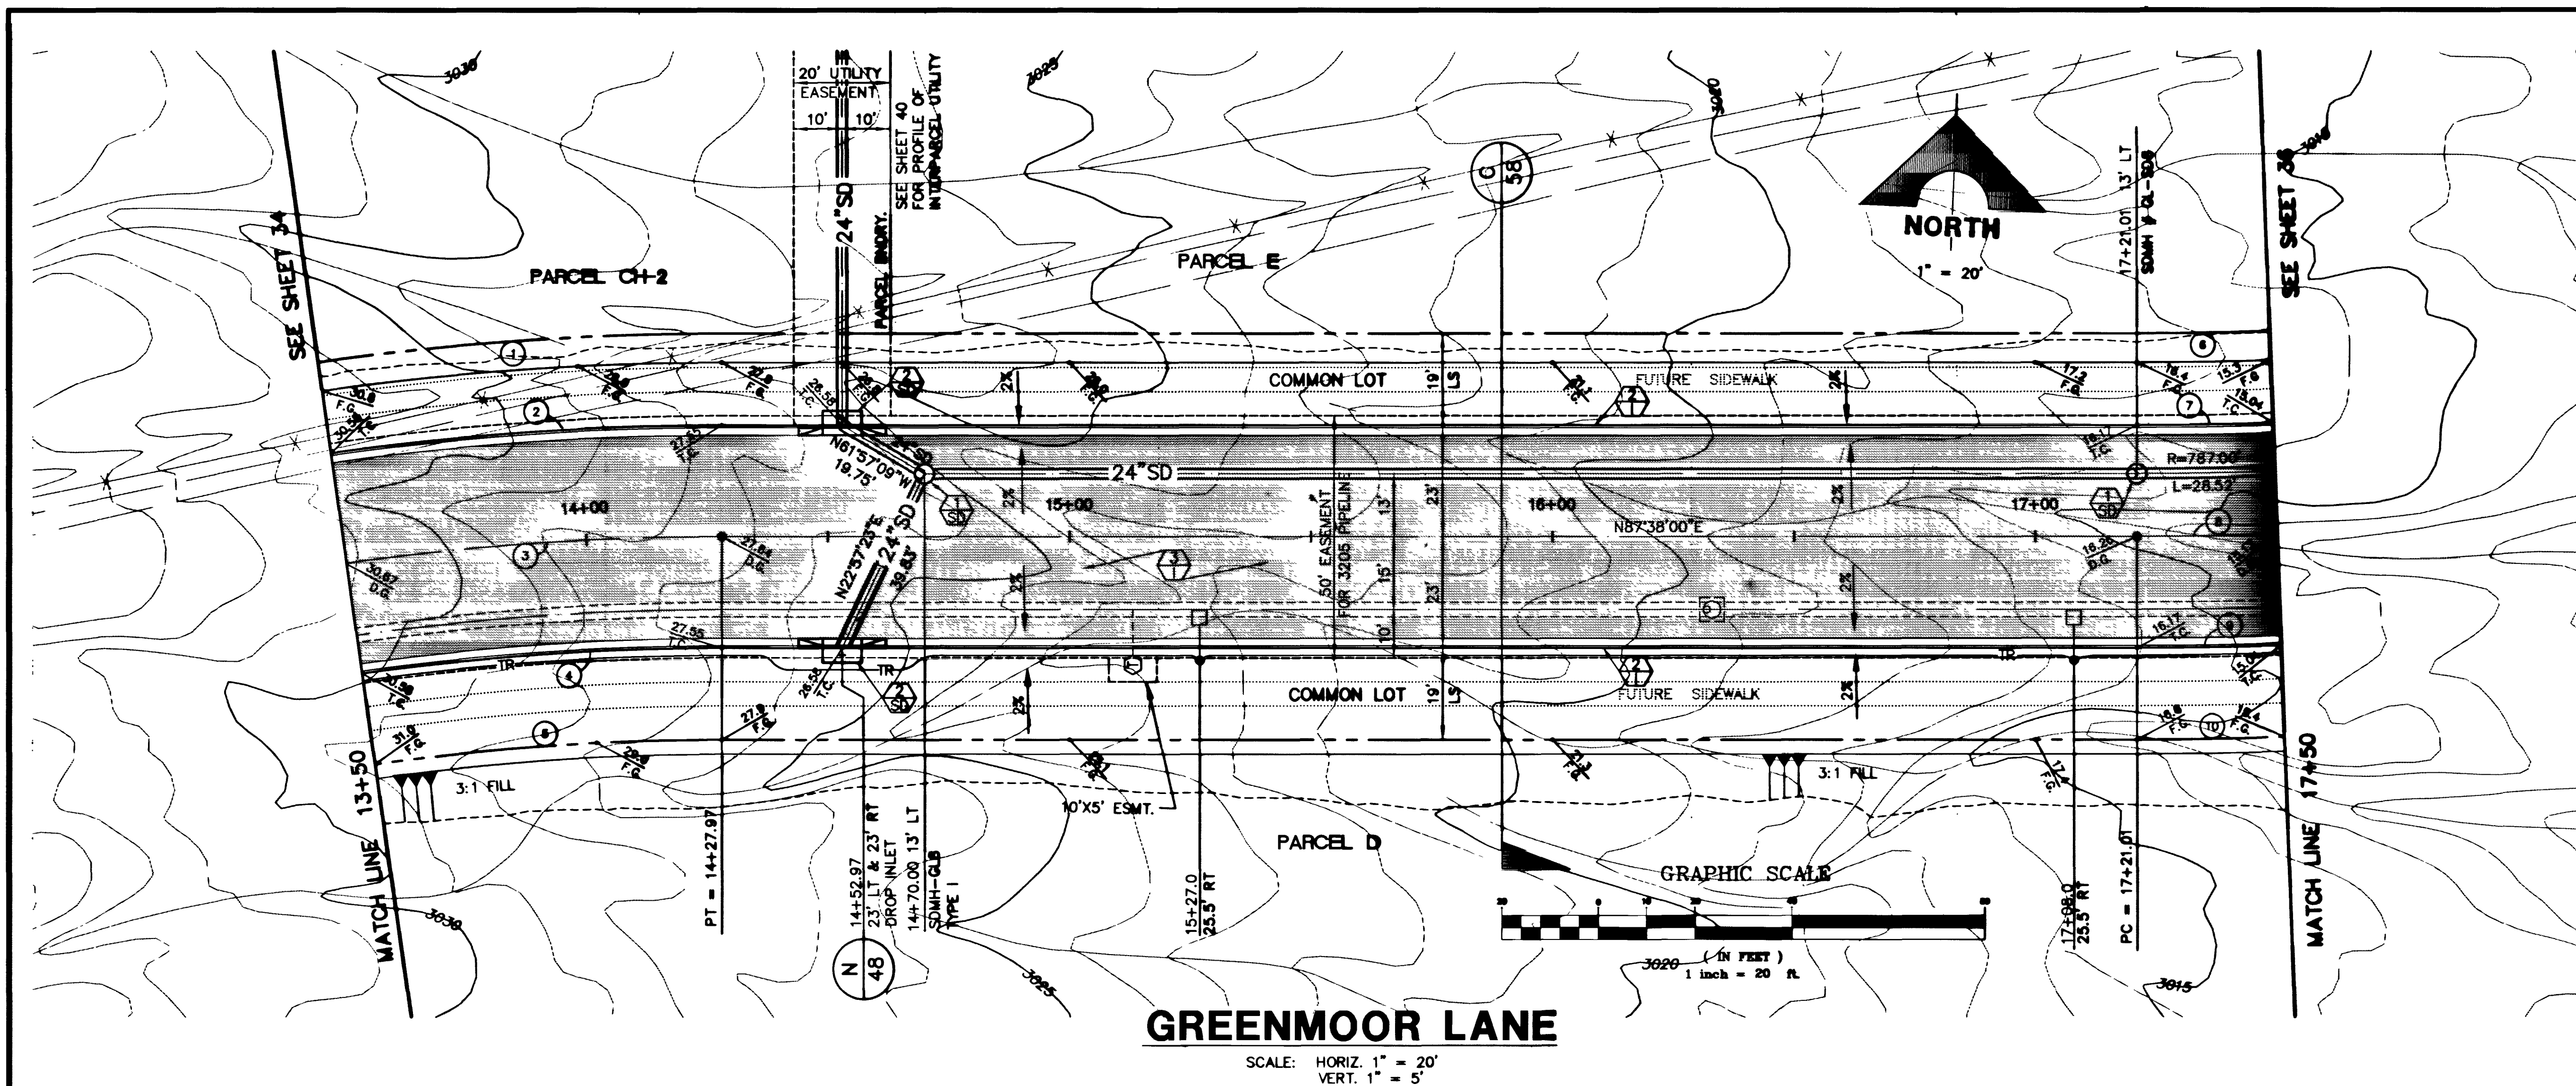

CURVE DATA				
① INDICATES CURVE NUMBER (THIS SHEET ONLY)				
CURVE	DELTA	RADIUS	LENGTH	TANGENT
1	08°07'19"	592.00	83.82	42.03
2	08°07'19"	573.00	81.24	40.88
3	08°07'19"	560.00	77.77	39.42
4	08°07'19"	527.00	74.50	37.42
5	08°07'19"	508.00	72.00	36.07
6	08°07'19"	478.00	67.47	33.74
7	02°04'35"	777.00	28.18	14.08
8	02°04'35"	800.00	28.88	14.50
9	02°04'35"	823.00	29.83	14.97
10	02°04'35"	842.00	30.91	15.49

- ### CONSTRUCTION NOTES
- #### IMPROVEMENTS
- INSTALL "A" TYPE CURB (S-50)
 - INSTALL "L" TYPE CURB & GUTTER (S-47)
 - INSTALL AC PAVEMENT PER SECTION SHEETS 56, 57, & 58
 - INSTALL CROSSWALK (S-78)
 - INSTALL DEPRESSED CURB (S-75)


- #### WATER
- INSTALL WATER PIPES PER SUMMERLIN STD. U-20
 - INSTALL 12" DIA. GATE VALVE & BOX (U-34)
 - INSTALL 8" DIA. GATE VALVE & BOX (U-34)
 - INSTALL 12"x12"x12" TEE
 - INSTALL 12"x12"x12" CROSS
 - INSTALL 12"x12" ELBOW
 - INSTALL 12"x12"x8" TEE
 - INSTALL 12"x12"x8" CROSS
 - INSTALL 2" TEMP. BLOW-OFF & CAP (U-32)
 - INSTALL FIRE HYDRANT ASSEMBLY COMPLETE PER (U-33)
 - IRRIGATION SLEEVE (U-18)
 - EXISTING GATE VALVE MUST BE IN CLOSED POSITION PRIOR TO REMOVAL OF CAP

- #### STORM DRAIN
- INSTALL STORM DRAIN PIPES PER SUMMERLIN STD. U-20
 - INSTALL STORM DRAIN MANHOLE (D-12)
 - INSTALL 4" TYPE "A" DROP INLET (D-12)
 - INSTALL TYPE "B" DROP INLET (D-13)
 - INSTALL TYPE "C" MODIFIED DROP INLET (D-14)
 - INSTALL 6" TYPE "A" DROP INLET (D-12)

- #### SEWER
- INSTALL SEWER PIPES PER SUMMERLIN STD. U-20
 - INSTALL SEWER MANHOLE (SD-18)

- #### STREET LIGHTING
- INSTALL STREET LIGHT, SEE ELECTRICAL PLANS (E-2)
 - STREET LIGHT OR COMMON TRENCH, SEE ELECTRICAL PLANS

- #### TRAFFIC
- INSTALL 2-3" CONDUIT
 - INSTALL NO. 5 PULLBOX (E-32)

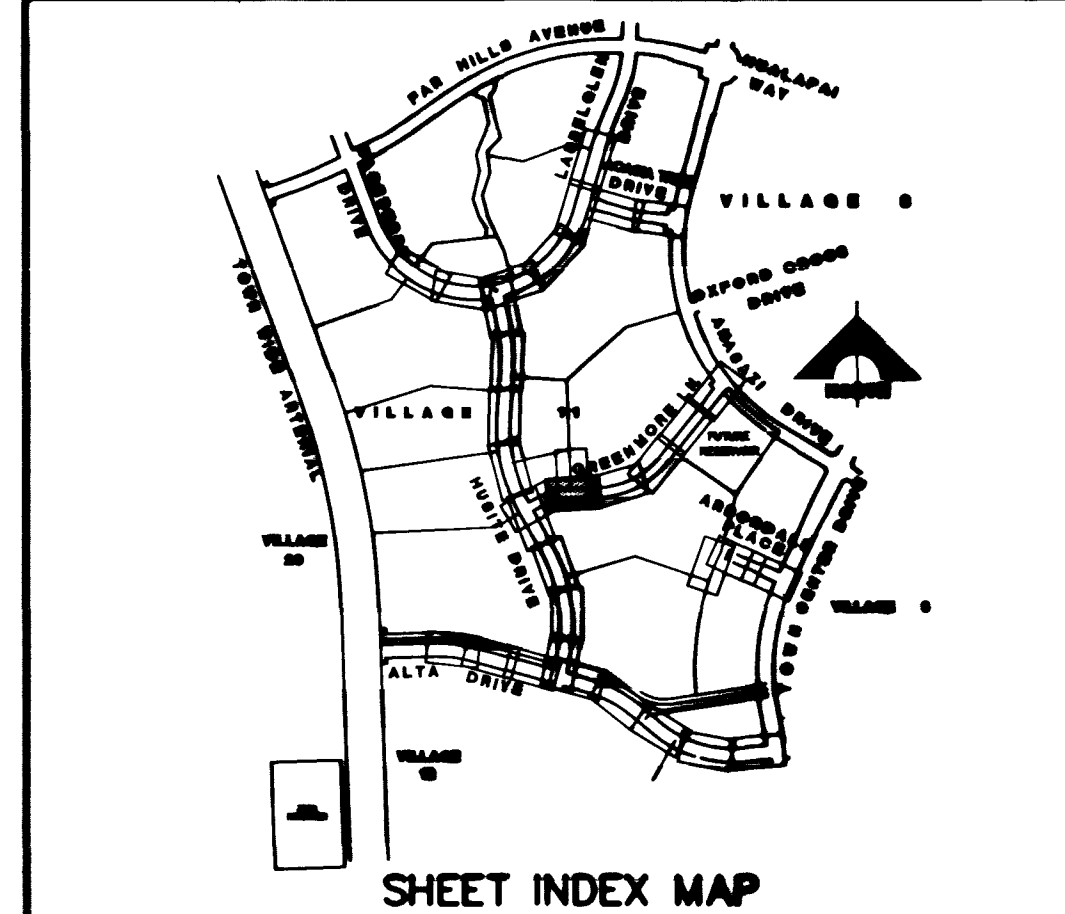

APPROVAL:
LAS VEGAS VALLEY WATER DISTRICT
DATE: 5/31/96

RECOMMENDED BY: CHRISTOPHER M. ANDERSON
DATE: 5/31/96

REVIEWED BY: [Signature]
DATE: 5/31/96

DESIGNED BY: [Signature]
DATE: 5/31/96

DRAWN BY: [Signature]
DATE: 5/31/96

STATE OF NEVADA
REGISTERED PROFESSIONAL ENGINEER
CHRISTOPHER M. ANDERSON
NO. 5071
EXPIRATION DATE: 5/31/97

G.C. WALLACE, INC.
Engineering/Architecture
1000 S. MAIN ST., SUITE 200
LAS VEGAS, NV 89101

SUMMERLIN
VILLAGE 11/12 THE ARBORS - UNIT 2A
GREENMOOR LANE
PLAN & PROFILE
STA 13+50 TO 17+50

SHEET
35
SHT 35 OF 64

FINAL SUBMITTAL

7497

11-32-159

107Y-4463-2A

