

NOTES:


- ① ALL FIXTURES ARE 2B UNLESS NOTED OTHERWISE. PROVIDE 8' ARMS FOR DOUBLE 2B FIXTURES. PROVIDE 5' ARMS FOR SINGLE 2B FIXTURES.
- ② ALL STREETLIGHT WIRING IS 2#4, 1#8, 1-1/4" C UNLESS NOTED OTHERWISE. ALL WIRE IS THIN.
- ③ ALL FULLBOXES ARE NO. 3-1/2 UNLESS NOTED OTHERWISE.
- ④ PROVIDE PULL STRINGS IN ALL SPARE CONDUITS.
- ⑤ PROVIDE 2#4, 1#8, IN 1-1/4" C. DO NOT CONNECT WIRES AT EITHER END OF CONDUIT.
- ⑥ THIS POLE AND LUMINAIRE ARE TO BE INSTALLED IN FUTURE AND ARE SHOWN FOR REFERENCE ONLY.
- ⑦ CONNECT TO EXISTING STREETLIGHT AT STA. 116+47, CIRCUIT 3 IN SP-23 (UNIT 2A).
- ⑧ PROVIDE 2#4, 1#8, 3#10, 1-1/4" C FOR CIRCUIT 1.
- ⑨ PROVIDE 2#4, 1#8, 3#10, 1-1/4" C FOR CIRCUIT 3.
- ⑩ INTERCEPT EXISTING 1-1/4" C CONDUIT AND INSTALL NEW NO. 3-1/2 FULLBOX.
- ⑪ PROVIDE 1-1/4" C.O. WITH PULLSTRINGS.

GENERAL NOTE:

STREETLIGHT FIXTURES AND ARMS SHALL BE POWDER COATED BRONZE IN LIEU OF ANODIZED FIXTURE AND PAINTED ARM AS SHOWN ON STANDARD DRAWINGS.

STREET CLASSIFICATIONS:

ANASAZI DRIVE	NEIGHBORHOOD ARTERIAL
BANBURY CROSS DRIVE	NEIGHBORHOOD COLLECTOR I
BRIAR OAKS DRIVE	RESIDENTIAL COLLECTOR
FAR HILLS AVENUE-WEST OF LAURELGLEN DRIVE	NEIGHBORHOOD ARTERIAL
FAR HILLS AVENUE- EAST OF LAURELGLEN DRIVE	VILLAGE ARTERIAL
LAURELGLEN DRIVE	RESIDENTIAL COLLECTOR
SAGEBERRY DRIVE	RESIDENTIAL COLLECTOR

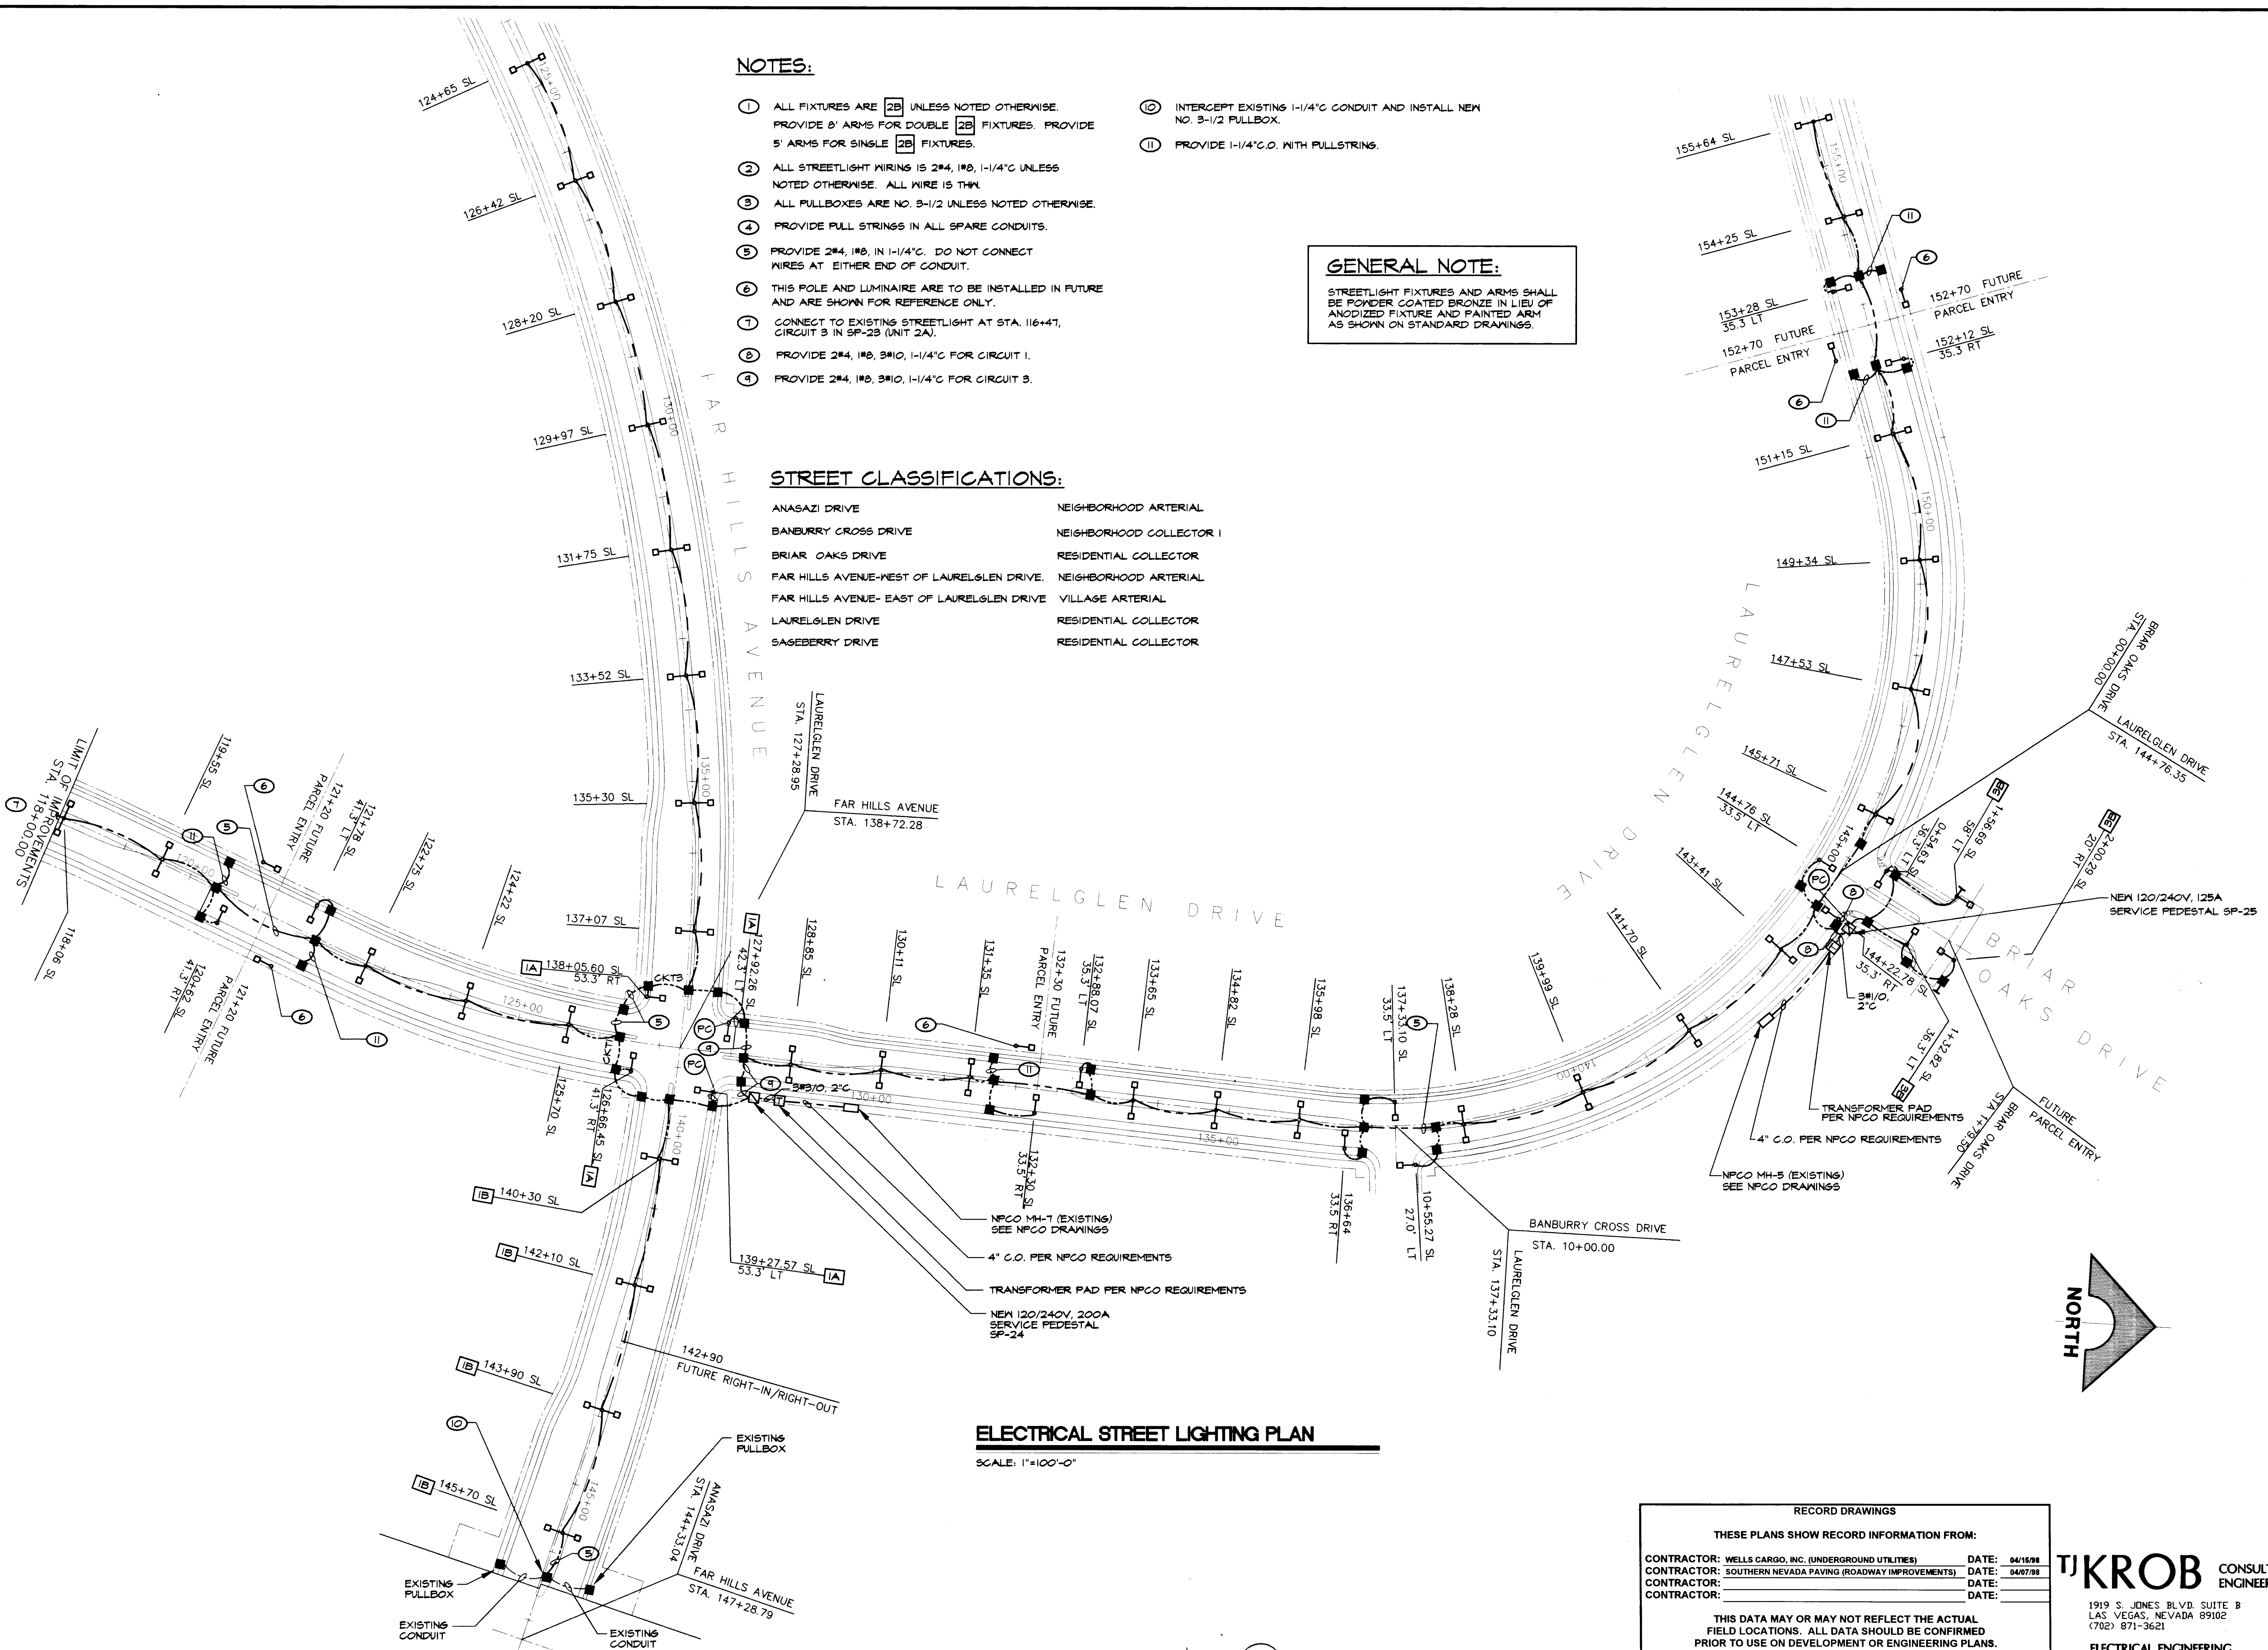

ELECTRICAL STREET LIGHTING PLAN

SCALE: 1"=100'-0"

RECORD DRAWINGS

THESE PLANS SHOW RECORD INFORMATION FROM:

CONTRACTOR: WELLS CARGO, INC. (UNDERGROUND UTILITIES)	DATE: 04/15/98
CONTRACTOR: SOUTHERN NEVADA PAVING (ROADWAY IMPROVEMENTS)	DATE: 04/07/98
CONTRACTOR:	DATE:

THIS DATA MAY OR MAY NOT REFLECT THE ACTUAL FIELD LOCATIONS. ALL DATA SHOULD BE CONFIRMED PRIOR TO USE ON DEVELOPMENT OR ENGINEERING PLANS.

TJKROB CONSULTING ENGINEERS, INC.

1919 S. JONES BLVD. SUITE B
LAS VEGAS, NEVADA 89102
(702) 871-3621

ELECTRICAL ENGINEERING

RECORD DRAWING INFORMATION	DATE	APPROVAL
4/23/98	12/1/97	
<p>G.C. WALLACE, INC. Engineering/Architecture 1555 SOUTH RAINBOW BLVD. LAS VEGAS, NEVADA 89102</p>		
<p>SUMMERLIN VILLAGE 11/12 UNIT 2B ELECTRICAL STREET LIGHTING PLAN</p>		
<p>SHEET E-2 OF 46</p>		

