


Xrefs: OX-TOP.DWG DXF-S-MS.DWG

Drawing: C:\DWG\VL11-12\UNIT-2A\DXF-S-2.DWG


May 29, 1996 11:18:06 a.m.

JOB NO. 62011.212

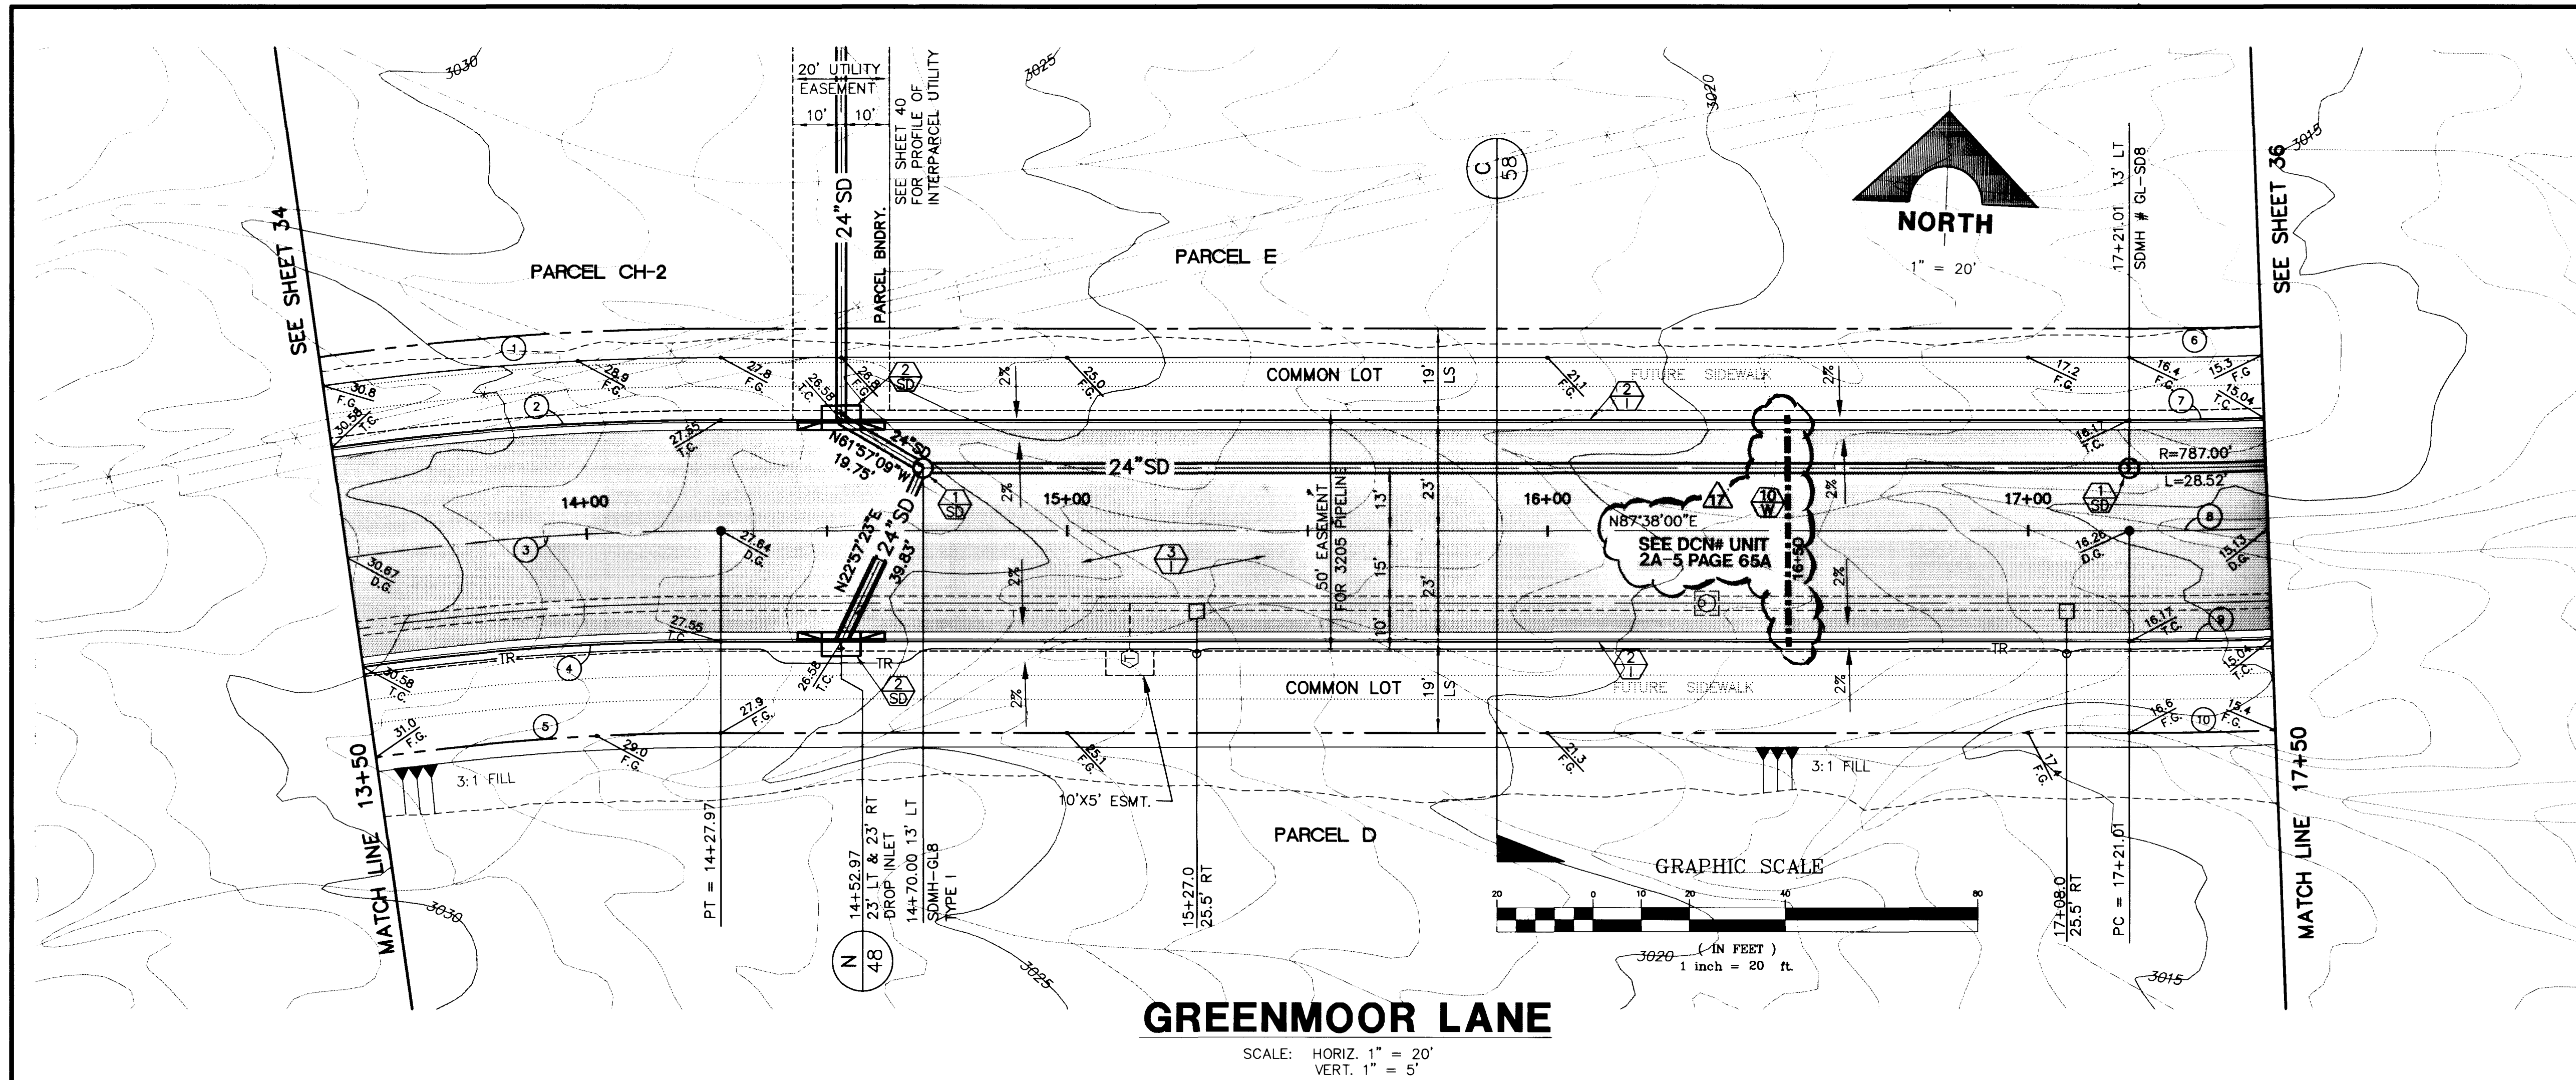

GREENMOOR LANE

SCALE: HORIZ. 1" = 20'
VERT. 1" = 5'

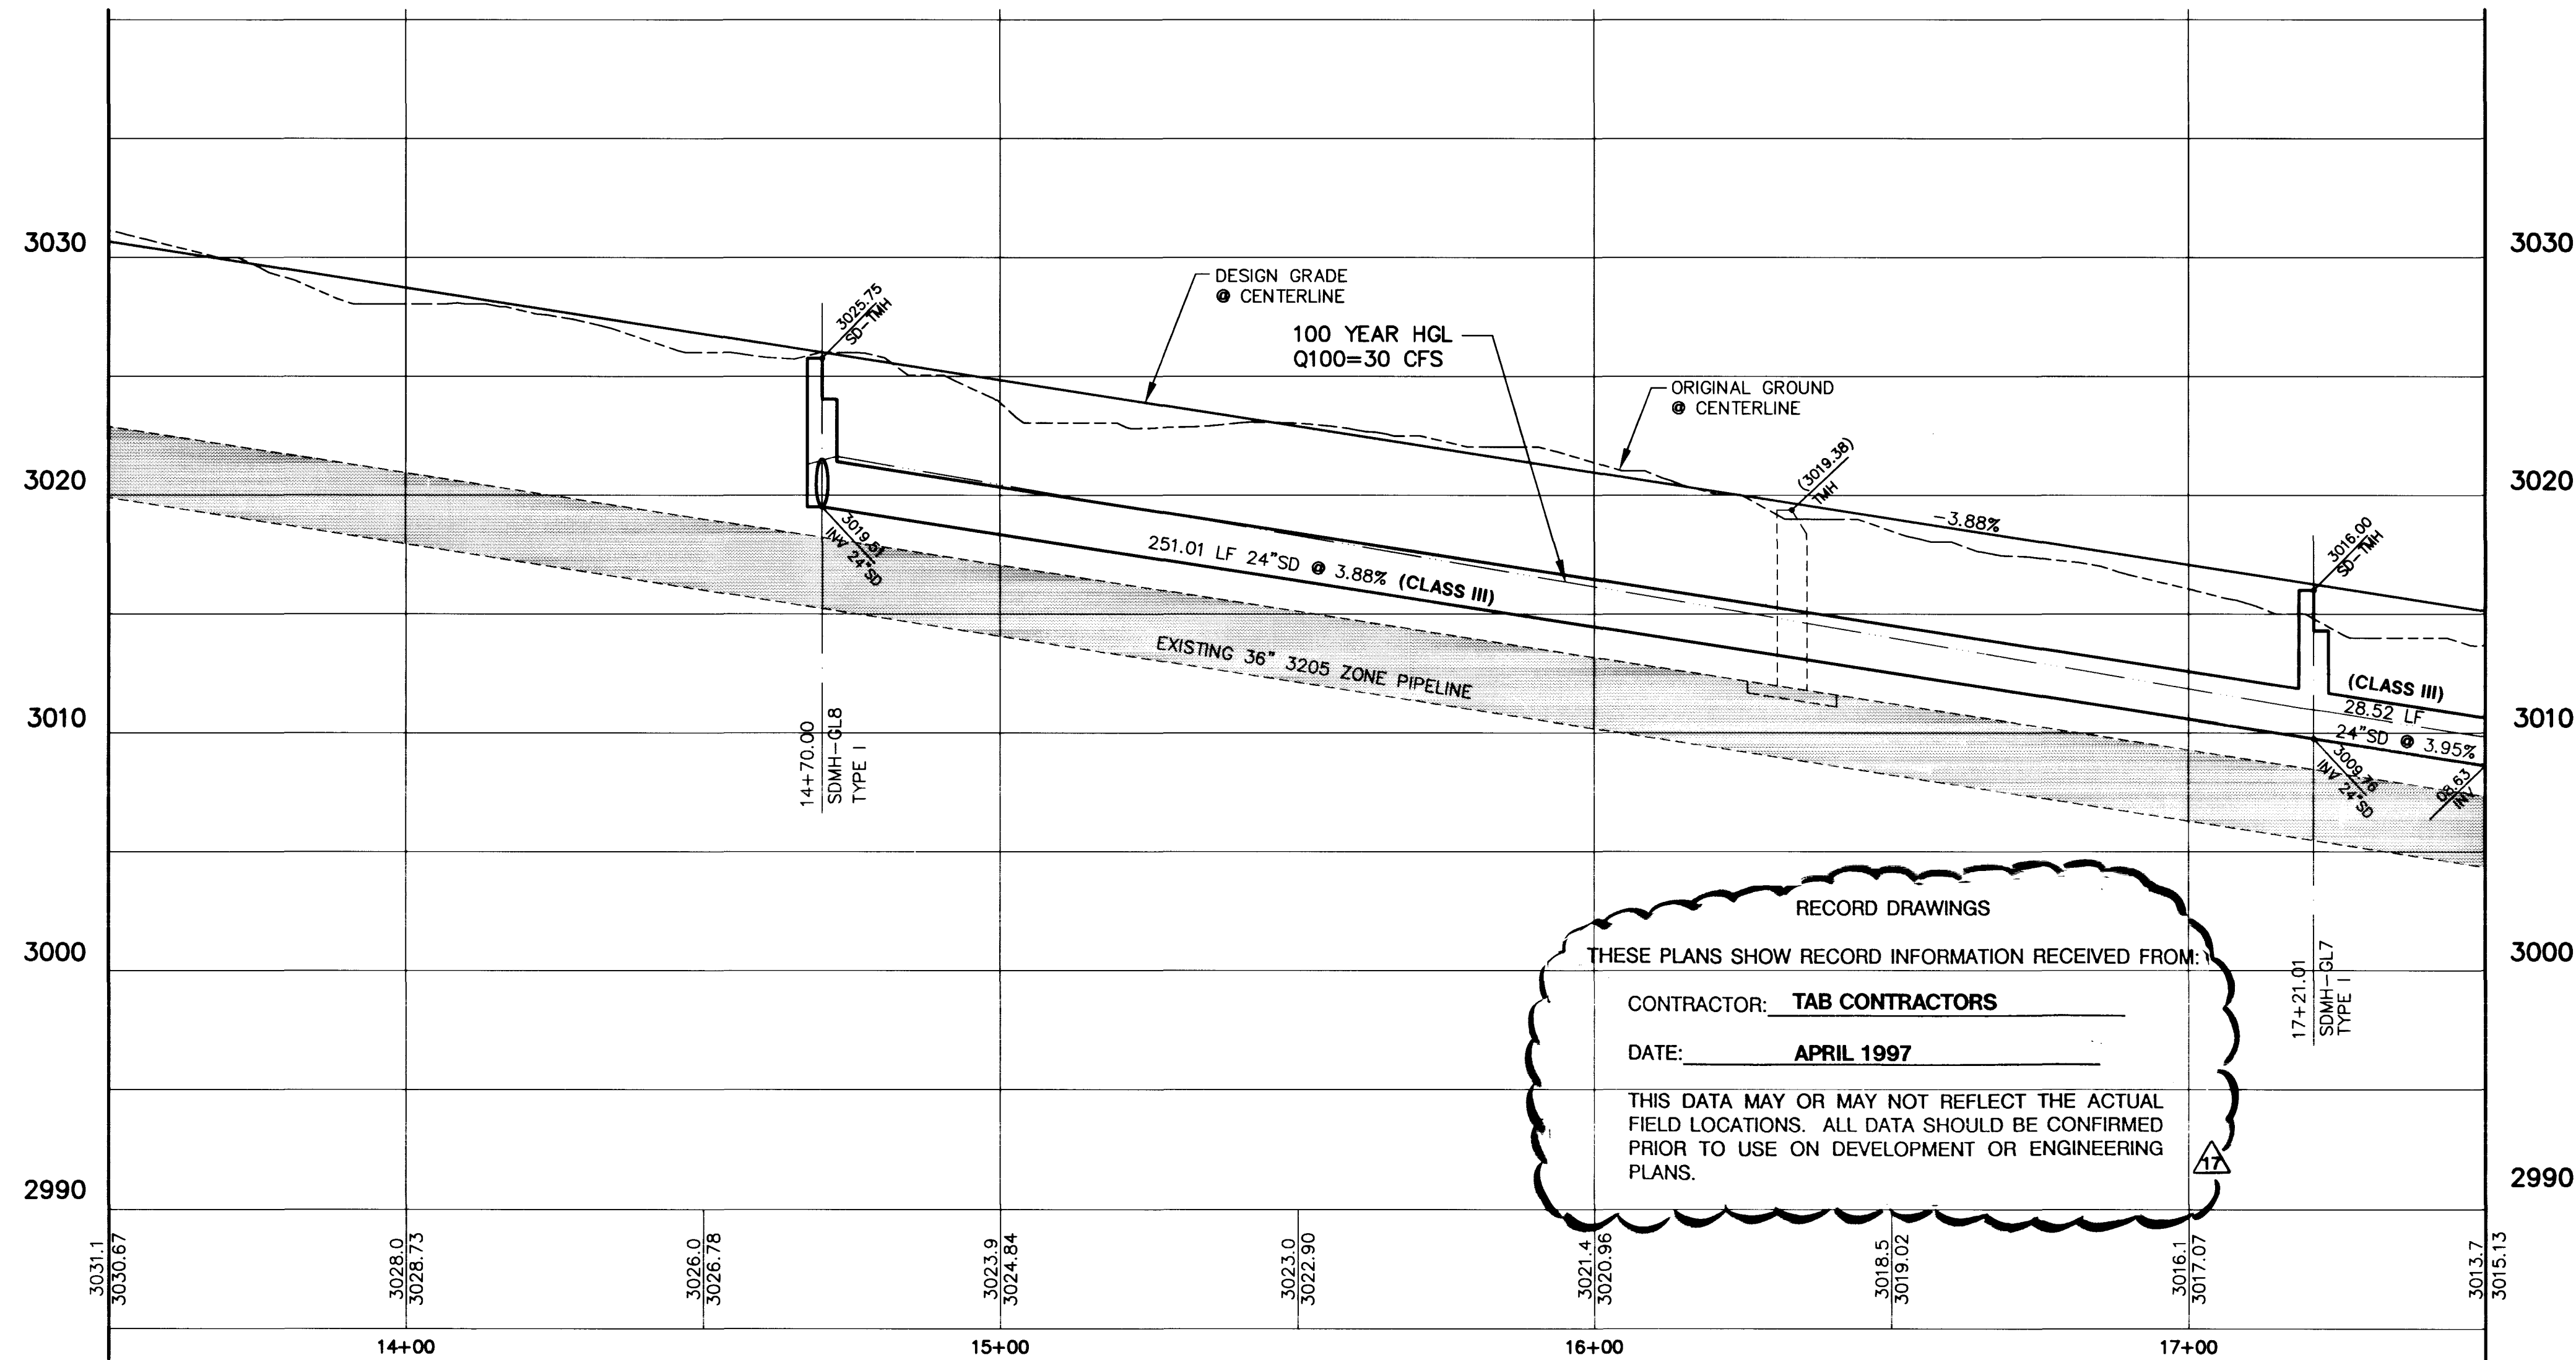

RECORD DRAWINGS
THESE PLANS SHOW RECORD INFORMATION RECEIVED FROM:
CONTRACTOR: **TAB CONTRACTORS**
DATE: **APRIL 1997**
THIS DATA MAY OR MAY NOT REFLECT THE ACTUAL
FIELD LOCATIONS. ALL DATA SHOULD BE CONFIRMED
PRIOR TO USE ON DEVELOPMENT OR ENGINEERING
PLANS.

CURVE DATA				
(1) INDICATES CURVE NUMBER (THIS SHEET ONLY)				
CURVE	DELTA	RADIUS	LENGTH	TANGENT
1	08°07'19"	592.00'	83.92'	42.03'
2	08°07'19"	573.00'	81.23'	40.68'
3	08°07'19"	550.00'	77.97'	39.05'
4	08°07'19"	527.00'	74.70'	37.42'
5	08°07'19"	508.00'	72.01'	36.07'
6	02°04'35"	758.00'	27.47'	13.74'
7	02°04'35"	777.00'	28.16'	14.08'
8	02°04'35"	800.00'	28.99'	14.50'
9	02°04'35"	823.00'	29.83'	14.91'
10	02°04'35"	842.00'	30.51'	15.26'

CONSTRUCTION NOTES

IMPROVEMENTS

1. INSTALL "A" TYPE CURB (S-50 S)
2. INSTALL "L" TYPE CURB & GUTTER (S-47 S)
3. INSTALL AC PAVEMENT PER SECTION SHEETS 56, 57, & 58
4. INSTALL CROSSWALK (S-78 S)
5. INSTALL DEPRESSED CURB (S-75 S)

WATER

- INSTALL WATER PIPES PER SUMMERLIN STD. U-20
1. INSTALL 12" DIA. GATE VALVE & BOX (U-34 S)
 2. INSTALL 8" DIA. GATE VALVE & BOX (U-34 S)
 3. INSTALL 12"x12"x12" TEE (U-34 S)
 4. INSTALL 12"x12"x12"x12" CROSS (U-34 S)
 5. INSTALL 12"x12" ELBOW (U-34 S)
 6. INSTALL 12"x12"x8" TEE (U-34 S)
 7. INSTALL 12"x12"x8"x6" CROSS (U-32 S)
 8. INSTALL 2" TEMP. BLOW-OFF & CAP (U-32 S)
 9. INSTALL FIRE HYDRANT ASSEMBLY COMPLETE PER (U-33 S)
 10. IRRIGATION SLEEVE (U-18 S)
 11. EXISTING GATE VALVE MUST BE IN CLOSED POSITION PRIOR TO REMOVAL OF CAP

STORM DRAIN

- INSTALL STORM DRAIN PIPES PER SUMMERLIN STD. U-20
1. INSTALL STORM DRAIN MANHOLE (D1-D10 S)
 2. INSTALL 4' TYPE "A" DROP INLET (D-12 S)
 3. INSTALL TYPE "B" DROP INLET (D-13 S)
 4. INSTALL TYPE "C" MODIFIED DROP INLET (D-14 S)
 5. INSTALL 6' TYPE "A" DROP INLET (D-12 S)

SEWER


- INSTALL SEWER PIPES PER SUMMERLIN STD. U-20
1. INSTALL SEWER MANHOLE (SD1-8 CLV)

STREET LIGHTING

1. INSTALL STREET LIGHT, SEE ELECTRICAL PLANS (E-2 S)
2. STREET LIGHT OR COMMON TRENCH, SEE ELECTRICAL PLANS

TRAFFIC

1. INSTALL 2-3" CONDUIT (E-32 S)
2. INSTALL NO. 5 PULLBOX (E-32 S)

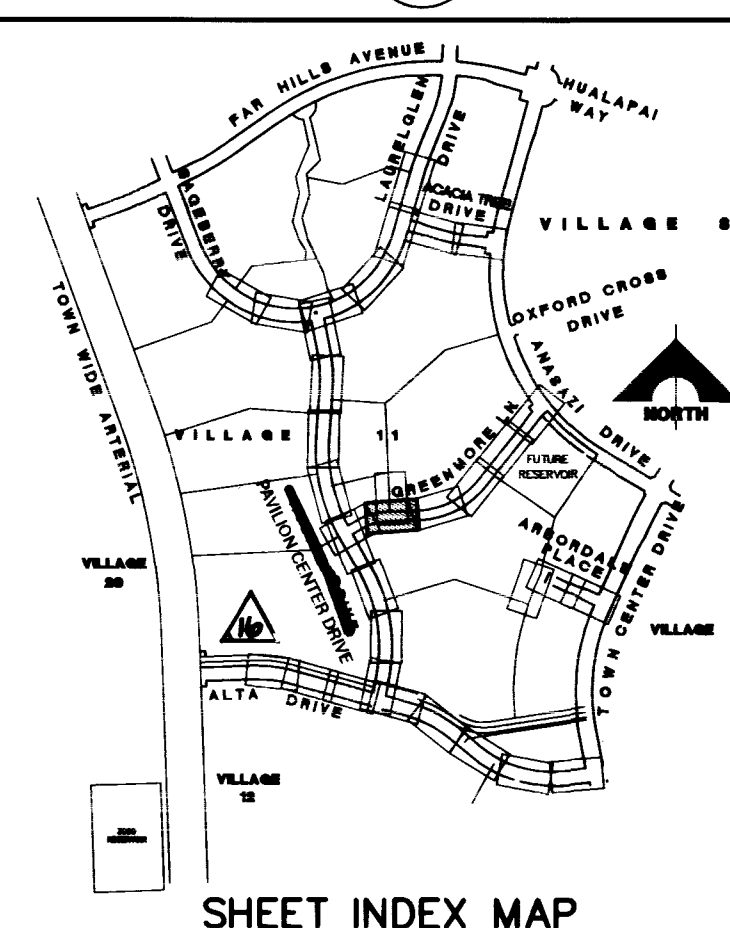

SHEET INDEX MAP

APPROVAL:

[Signature] 5/3/96
LAS VEGAS VALLEY WATER DISTRICT DATE

RECOMMENDED
CHRISTOPHER W. ANDERSON
REGISTERED PROFESSIONAL ENGINEER - STATE OF NEVADA
DIVISION OF ENGINEERING
EXPIRATION DATE: 5/31/2001

G.C. WALLACE, INC.
Engineering/Architecture
1955 SOUTH RAINBOW BLVD./LAS VEGAS, NEVADA 89102

VILLAGE 11/12 THE ARBORS - UNIT 2A
GREENMOOR LANE
PLAN & PROFILE
STA 13+50 TO 17+50

SHEET
35
SHT 35 OF 65

FINAL SUBMITTAL

