


Refs: 01-TOPO.DWG 01F-S-45.DWG

Drawing: C:\DWG\11-12\UNIT-2A\01F-S\05F-S-6.DWG


May 29, 1996 12:03:01 p.m.

JOB NO. 62011.212

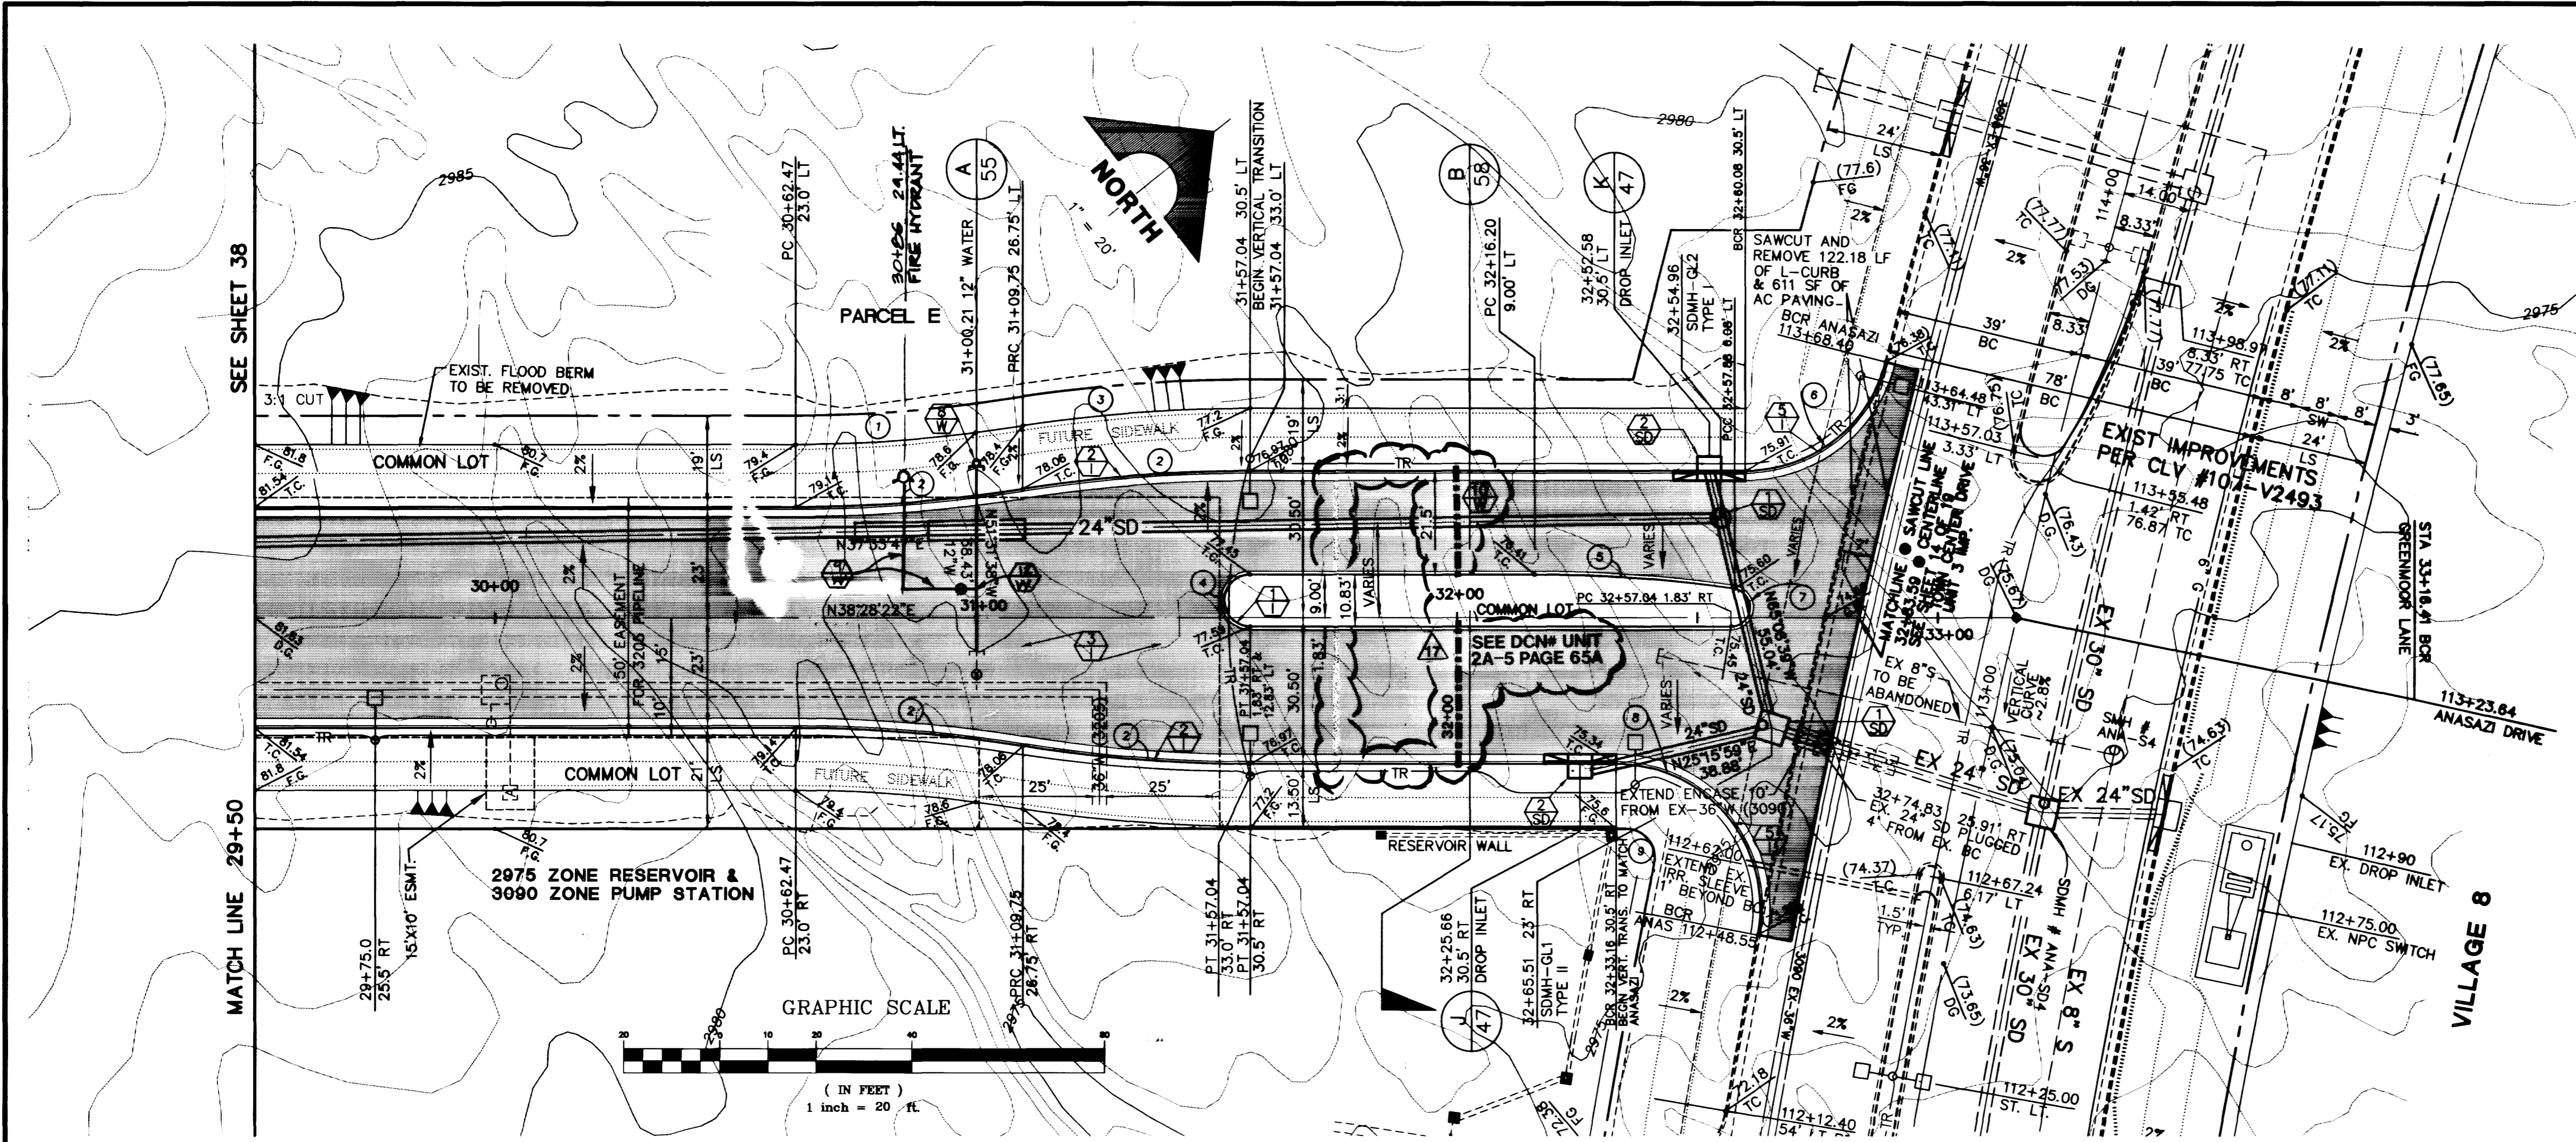

### GREENMOOR LANE

SCALE: HORIZ. 1" = 20'  
VERT. 1" = 5'

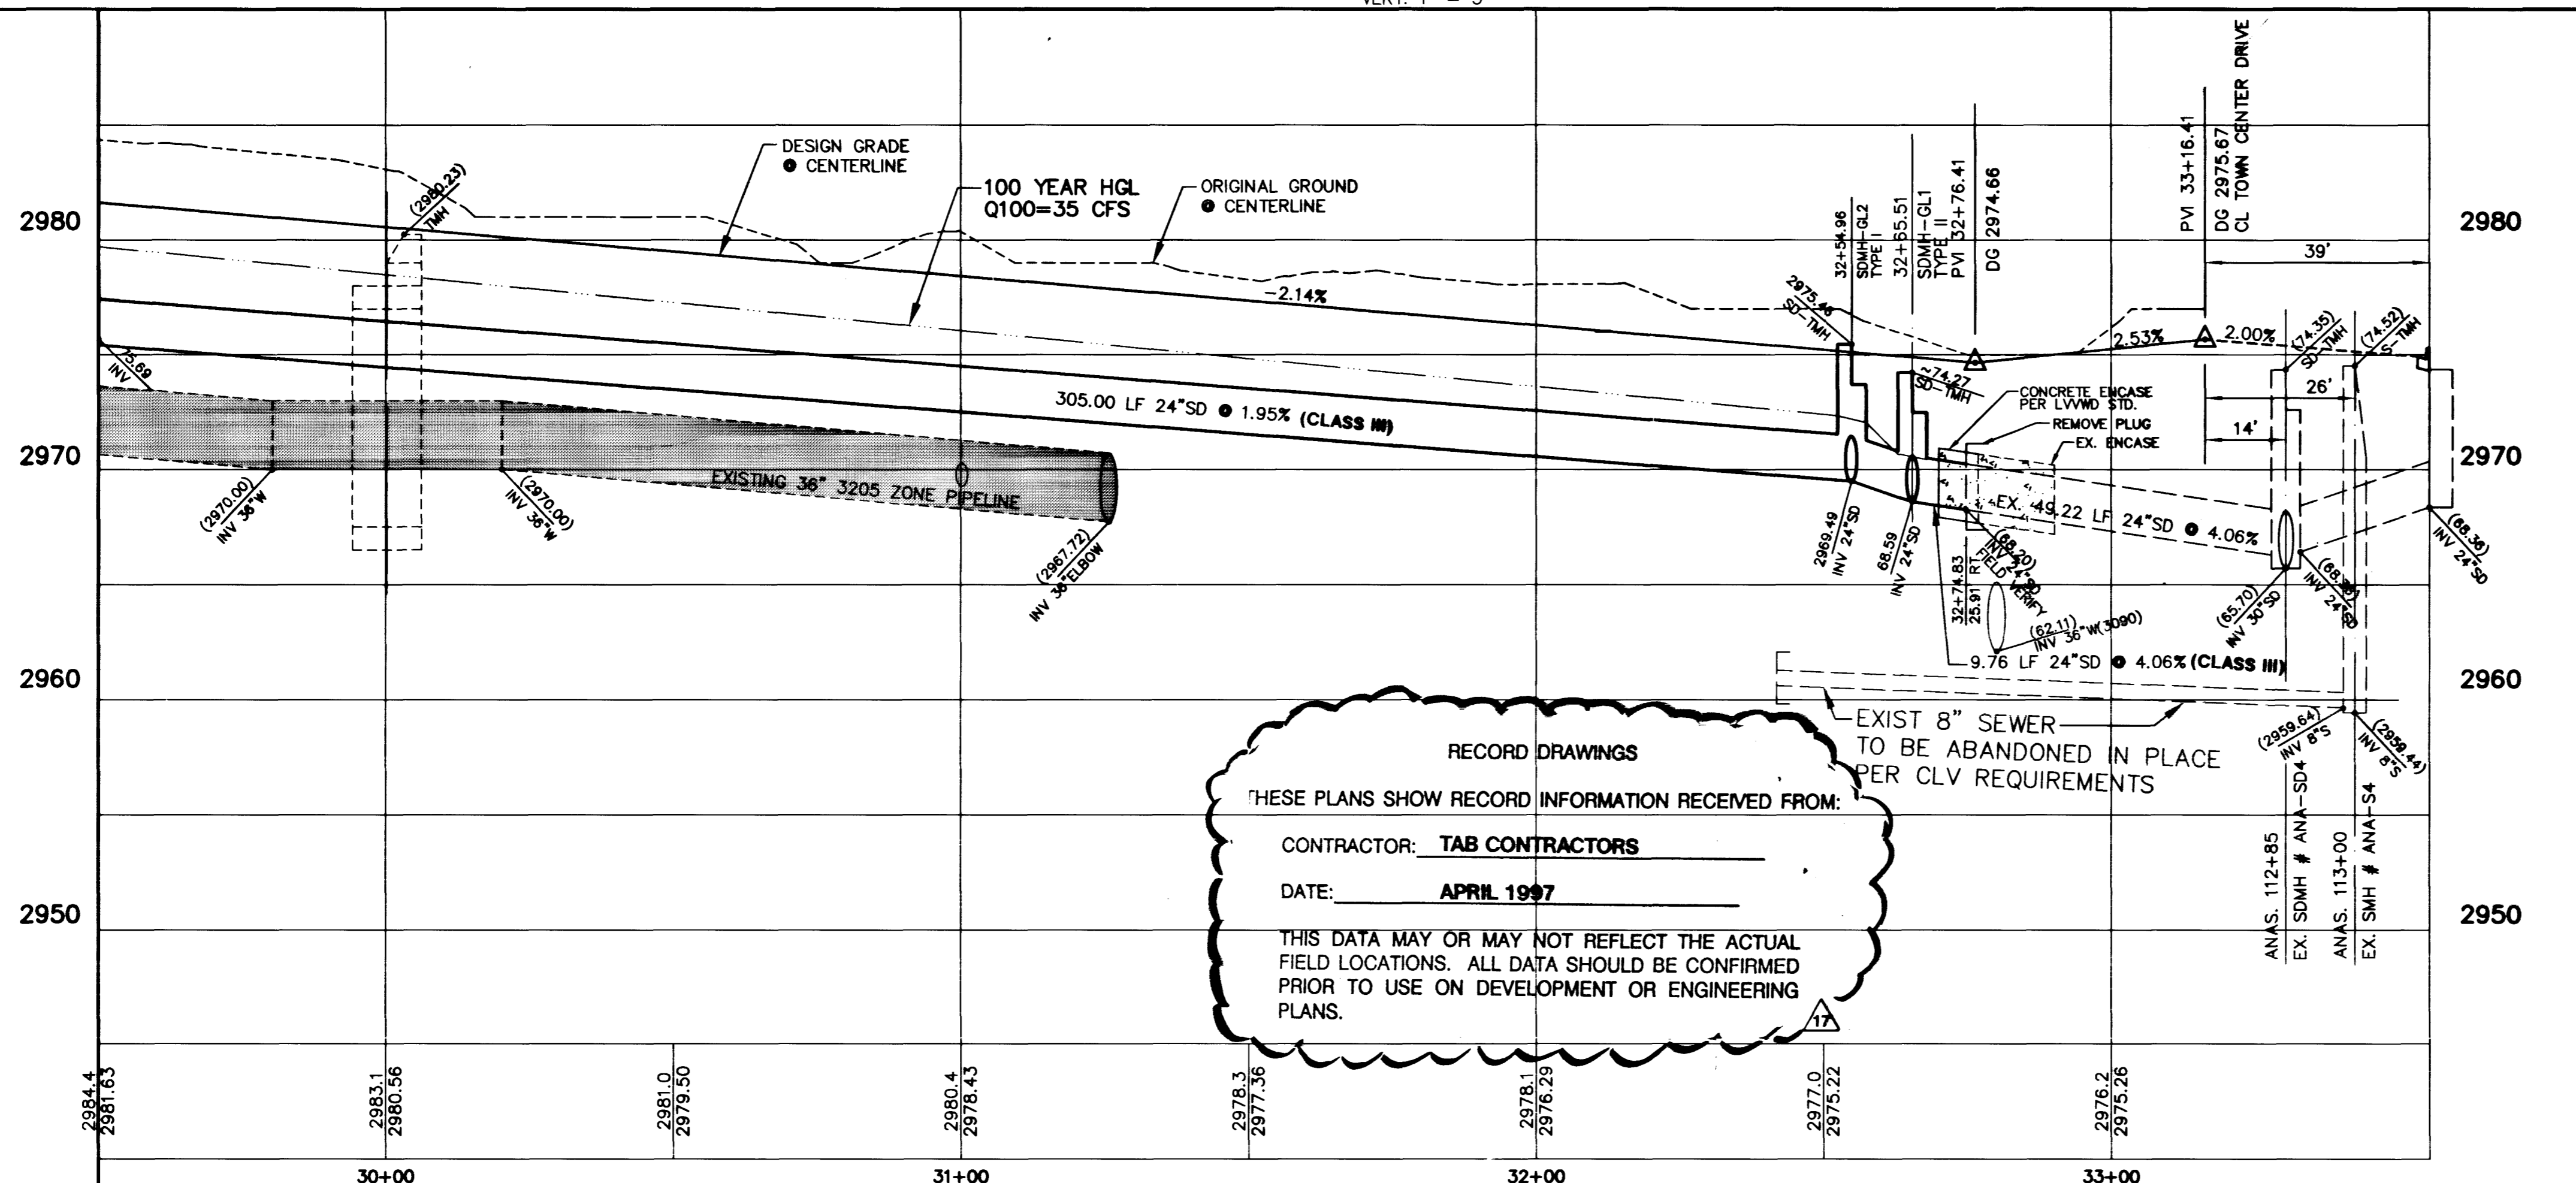

RECORD DRAWINGS  
 THESE PLANS SHOW RECORD INFORMATION RECEIVED FROM:  
 CONTRACTOR: **TAB CONTRACTORS**  
 DATE: **APRIL 1997**  
 THIS DATA MAY OR MAY NOT REFLECT THE ACTUAL FIELD LOCATIONS. ALL DATA SHOULD BE CONFIRMED PRIOR TO USE ON DEVELOPMENT OR ENGINEERING PLANS.

**CURVE DATA** (1 INDICATES CURVE NUMBER (THIS SHEET ONLY))

CURVE	DELTA	RADIUS	LENGTH	TANGENT
1	09°04'07"	281.00'	44.48'	22.28'
2	09°04'07"	300.00'	47.48'	23.79'
3	09°04'07"	319.00'	50.49'	25.30'
4	18°00'00"	5.42'	17.01'	---
5	07°55'47"	300.00'	41.52'	20.79'
6	75°44'12"	30.00'	39.66'	23.33'
7	172°34'12"	4.00'	12.01'	57.71'
8	100°49'43"	30.00'	52.79'	36.28'
9	101°07'30"	6.00'	10.59'	7.22'

- CONSTRUCTION NOTES**
- IMPROVEMENTS**
- INSTALL "A" TYPE CURB (S-50 S)
  - INSTALL "L" TYPE CURB & GUTTER (S-47 S)
  - INSTALL AC PAVEMENT PER SECTION SHEETS 56, 57, & 58
  - INSTALL CROSSWALK (S-78 S)
  - INSTALL DEPRESSED CURB (S-75 S)


- WATER**
- INSTALL WATER PIPES PER SUMMERLIN STD. U-20
  - INSTALL 12" DIA. GATE VALVE & BOX (U-34 S)
  - INSTALL 8" DIA. GATE VALVE & BOX (U-34 S)
  - INSTALL 12"x12"x12" TEE
  - INSTALL 12"x12"x12"x12" CROSS
  - INSTALL 12"x12" ELBOW
  - INSTALL 12"x12"x8" TEE
  - INSTALL 12"x12"x8"x6" CROSS (U-32 S)
  - INSTALL 2" TEMP. BLOW-OFF & CAP (U-33 S)
  - INSTALL FIRE HYDRANT ASSEMBLY COMPLETE PER (U-18 S)
  - IRRIGATION SLEEVE (U-18 S)
  - EXISTING GATE VALVE MUST BE IN CLOSED POSITION PRIOR TO REMOVAL OF CAP
  - INSTALL 12"x12"x8" TEE


- STORM DRAIN**
- INSTALL STORM DRAIN PIPES PER SUMMERLIN STD. U-20
  - INSTALL STORM DRAIN MANHOLE (D1-D10 S)
  - INSTALL 4" TYPE "A" DROP INLET (D-12 S)
  - INSTALL TYPE "B" DROP INLET (D-13 S)
  - INSTALL TYPE "C" MODIFIED DROP INLET (D-14 S) (SEE PLANS FOR LENGTH)
  - INSTALL 6" TYPE "A" DROP INLET (D-12 S)

- SEWER**
- INSTALL SEWER PIPES PER SUMMERLIN STD. U-20
  - INSTALL SEWER MANHOLE (SD1-B CLV)

- STREET LIGHTING**
- INSTALL STREET LIGHT, SEE ELECTRICAL PLANS (E-2 S)
  - STREET LIGHT OR COMMON TRENCH, SEE ELECTRICAL PLANS

- TRAFFIC**
- INSTALL 2-3" CONDUIT (E-32 S)
  - INSTALL NO. 5 PULLBOX (E-32 S)

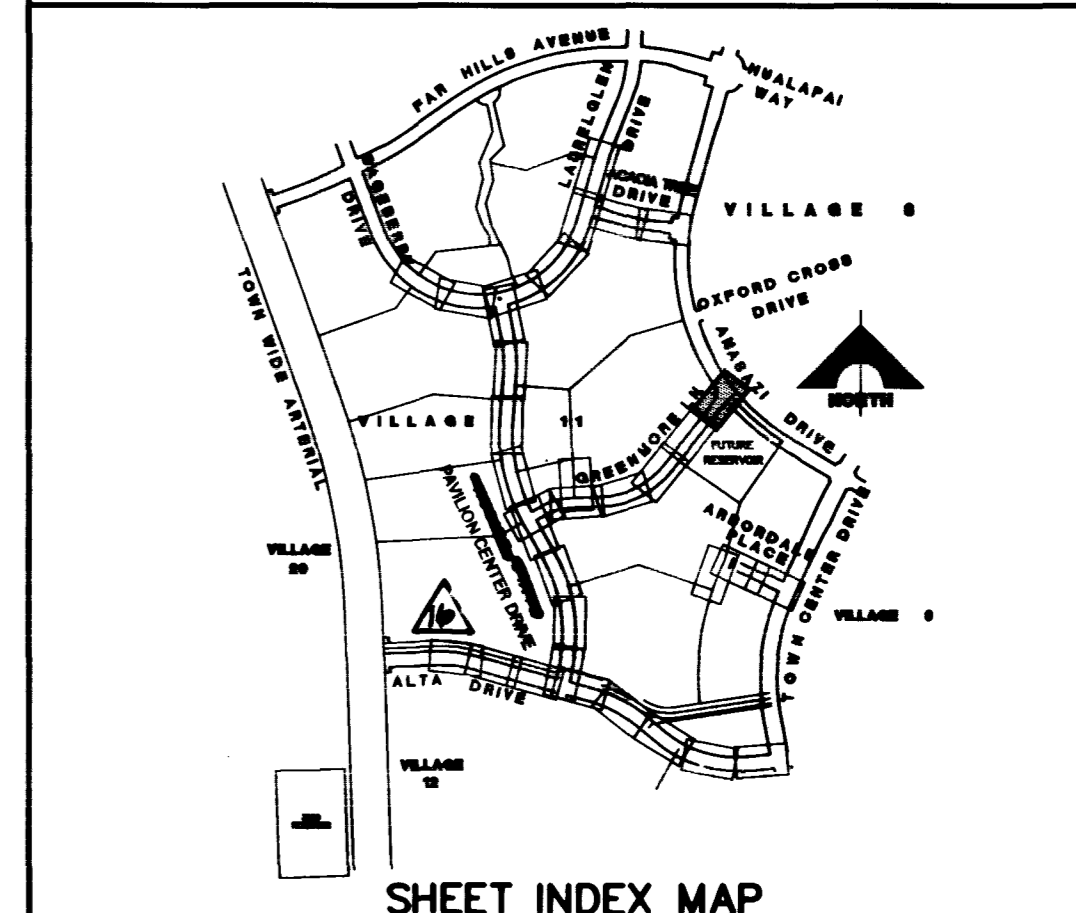

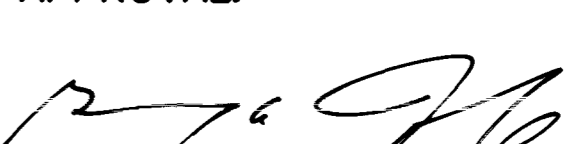APPROVAL:  5/31/96  
 LAS VEGAS VALLEY WATER DISTRICT DATE


**FINAL SUBMITTAL**

RECOMMENDED: CHRISTOPHER W. ANDERSON, ENGINEER, STATE OF NEVADA, LICENSE # 10000, DATE 5/31/96


G. C. WALLACE, INC. Engineering/Architecture, 1535 SOUTH RAINBOW BLVD., SUITE 100, LAS VEGAS, NEVADA 89102

**SUMMERLIN VILLAGE 11/12 THE ARBORS - UNIT 2A GREENMOOR LANE PLAN & PROFILE STA 29+00 TO 32+83.69**

SHEET **39** OF 65

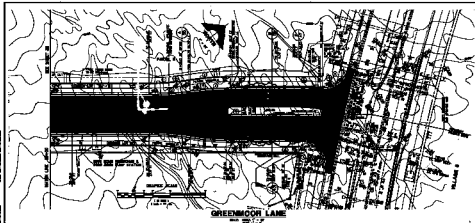

**GREENMOOR LANE**

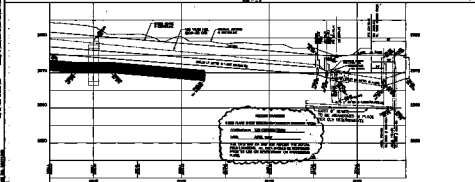

DATE: 10/15/54

NO.	DATE	BY	REVISION
1			
2			
3			
4			
5			

**CONSTRUCTION NOTES**

- 1. GRADE TO BE MAINTAINED AS SHOWN ON THIS PLAN.
- 2. GRADE TO BE MAINTAINED AS SHOWN ON THIS PLAN.
- 3. GRADE TO BE MAINTAINED AS SHOWN ON THIS PLAN.
- 4. GRADE TO BE MAINTAINED AS SHOWN ON THIS PLAN.
- 5. GRADE TO BE MAINTAINED AS SHOWN ON THIS PLAN.

- 6. GRADE TO BE MAINTAINED AS SHOWN ON THIS PLAN.
- 7. GRADE TO BE MAINTAINED AS SHOWN ON THIS PLAN.
- 8. GRADE TO BE MAINTAINED AS SHOWN ON THIS PLAN.
- 9. GRADE TO BE MAINTAINED AS SHOWN ON THIS PLAN.
- 10. GRADE TO BE MAINTAINED AS SHOWN ON THIS PLAN.

- 11. GRADE TO BE MAINTAINED AS SHOWN ON THIS PLAN.
- 12. GRADE TO BE MAINTAINED AS SHOWN ON THIS PLAN.
- 13. GRADE TO BE MAINTAINED AS SHOWN ON THIS PLAN.
- 14. GRADE TO BE MAINTAINED AS SHOWN ON THIS PLAN.
- 15. GRADE TO BE MAINTAINED AS SHOWN ON THIS PLAN.

- 16. GRADE TO BE MAINTAINED AS SHOWN ON THIS PLAN.
- 17. GRADE TO BE MAINTAINED AS SHOWN ON THIS PLAN.
- 18. GRADE TO BE MAINTAINED AS SHOWN ON THIS PLAN.
- 19. GRADE TO BE MAINTAINED AS SHOWN ON THIS PLAN.
- 20. GRADE TO BE MAINTAINED AS SHOWN ON THIS PLAN.

- 21. GRADE TO BE MAINTAINED AS SHOWN ON THIS PLAN.
- 22. GRADE TO BE MAINTAINED AS SHOWN ON THIS PLAN.
- 23. GRADE TO BE MAINTAINED AS SHOWN ON THIS PLAN.
- 24. GRADE TO BE MAINTAINED AS SHOWN ON THIS PLAN.
- 25. GRADE TO BE MAINTAINED AS SHOWN ON THIS PLAN.

- 26. GRADE TO BE MAINTAINED AS SHOWN ON THIS PLAN.
- 27. GRADE TO BE MAINTAINED AS SHOWN ON THIS PLAN.
- 28. GRADE TO BE MAINTAINED AS SHOWN ON THIS PLAN.
- 29. GRADE TO BE MAINTAINED AS SHOWN ON THIS PLAN.
- 30. GRADE TO BE MAINTAINED AS SHOWN ON THIS PLAN.



APPROVAL:

*[Signature]*