


AVOID CUTTING UNDERGROUND UTILITY LINES. IT'S COSTLY.
Call before you Dig.
 1-800-227-2600
 UNDERGROUND SERVICE ALERT (USA)

DRAINAGE CERTIFICATION
 I CERTIFY THIS GRADING PLAN IS IN CONFORMANCE WITH THE APPROVED DRAINAGE STUDY ON FILE WITH THE CITY OF LAS VEGAS FOR THIS PROJECT.

Samih F. Alhwayek
 SAMIH F. ALHWAYEK P.E. NO. 10502 DATE 4-16-97




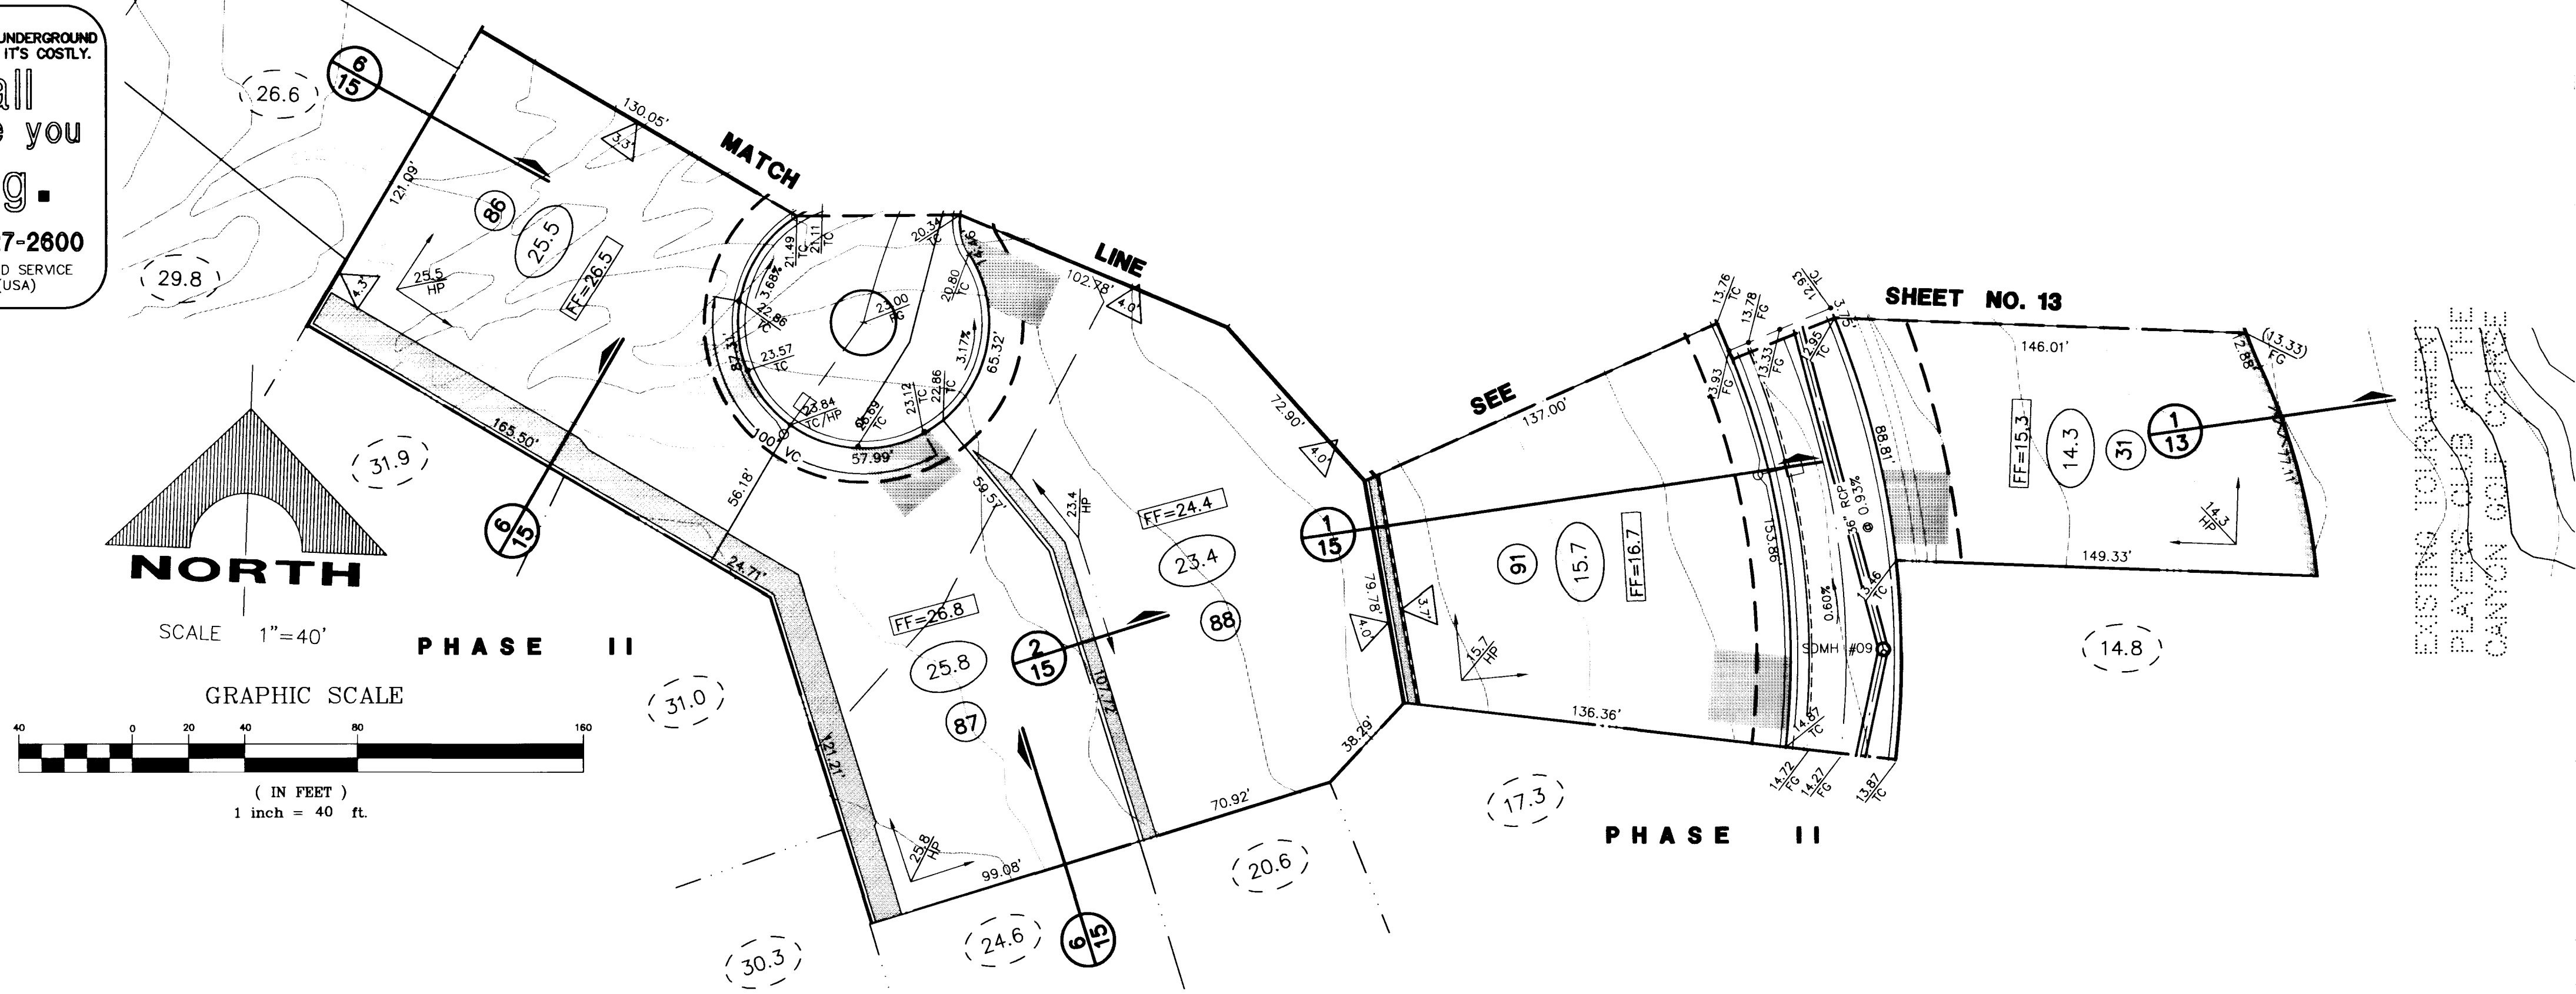


SHEET NO. 13

RECOMMENDED
 SAMIH F. ALHWAYEK P.E.
 CIVIL ENGINEER
 10502
 1997

DATE: 4-16-97

DESCRIPTION: PHASE II GRADING PLAN

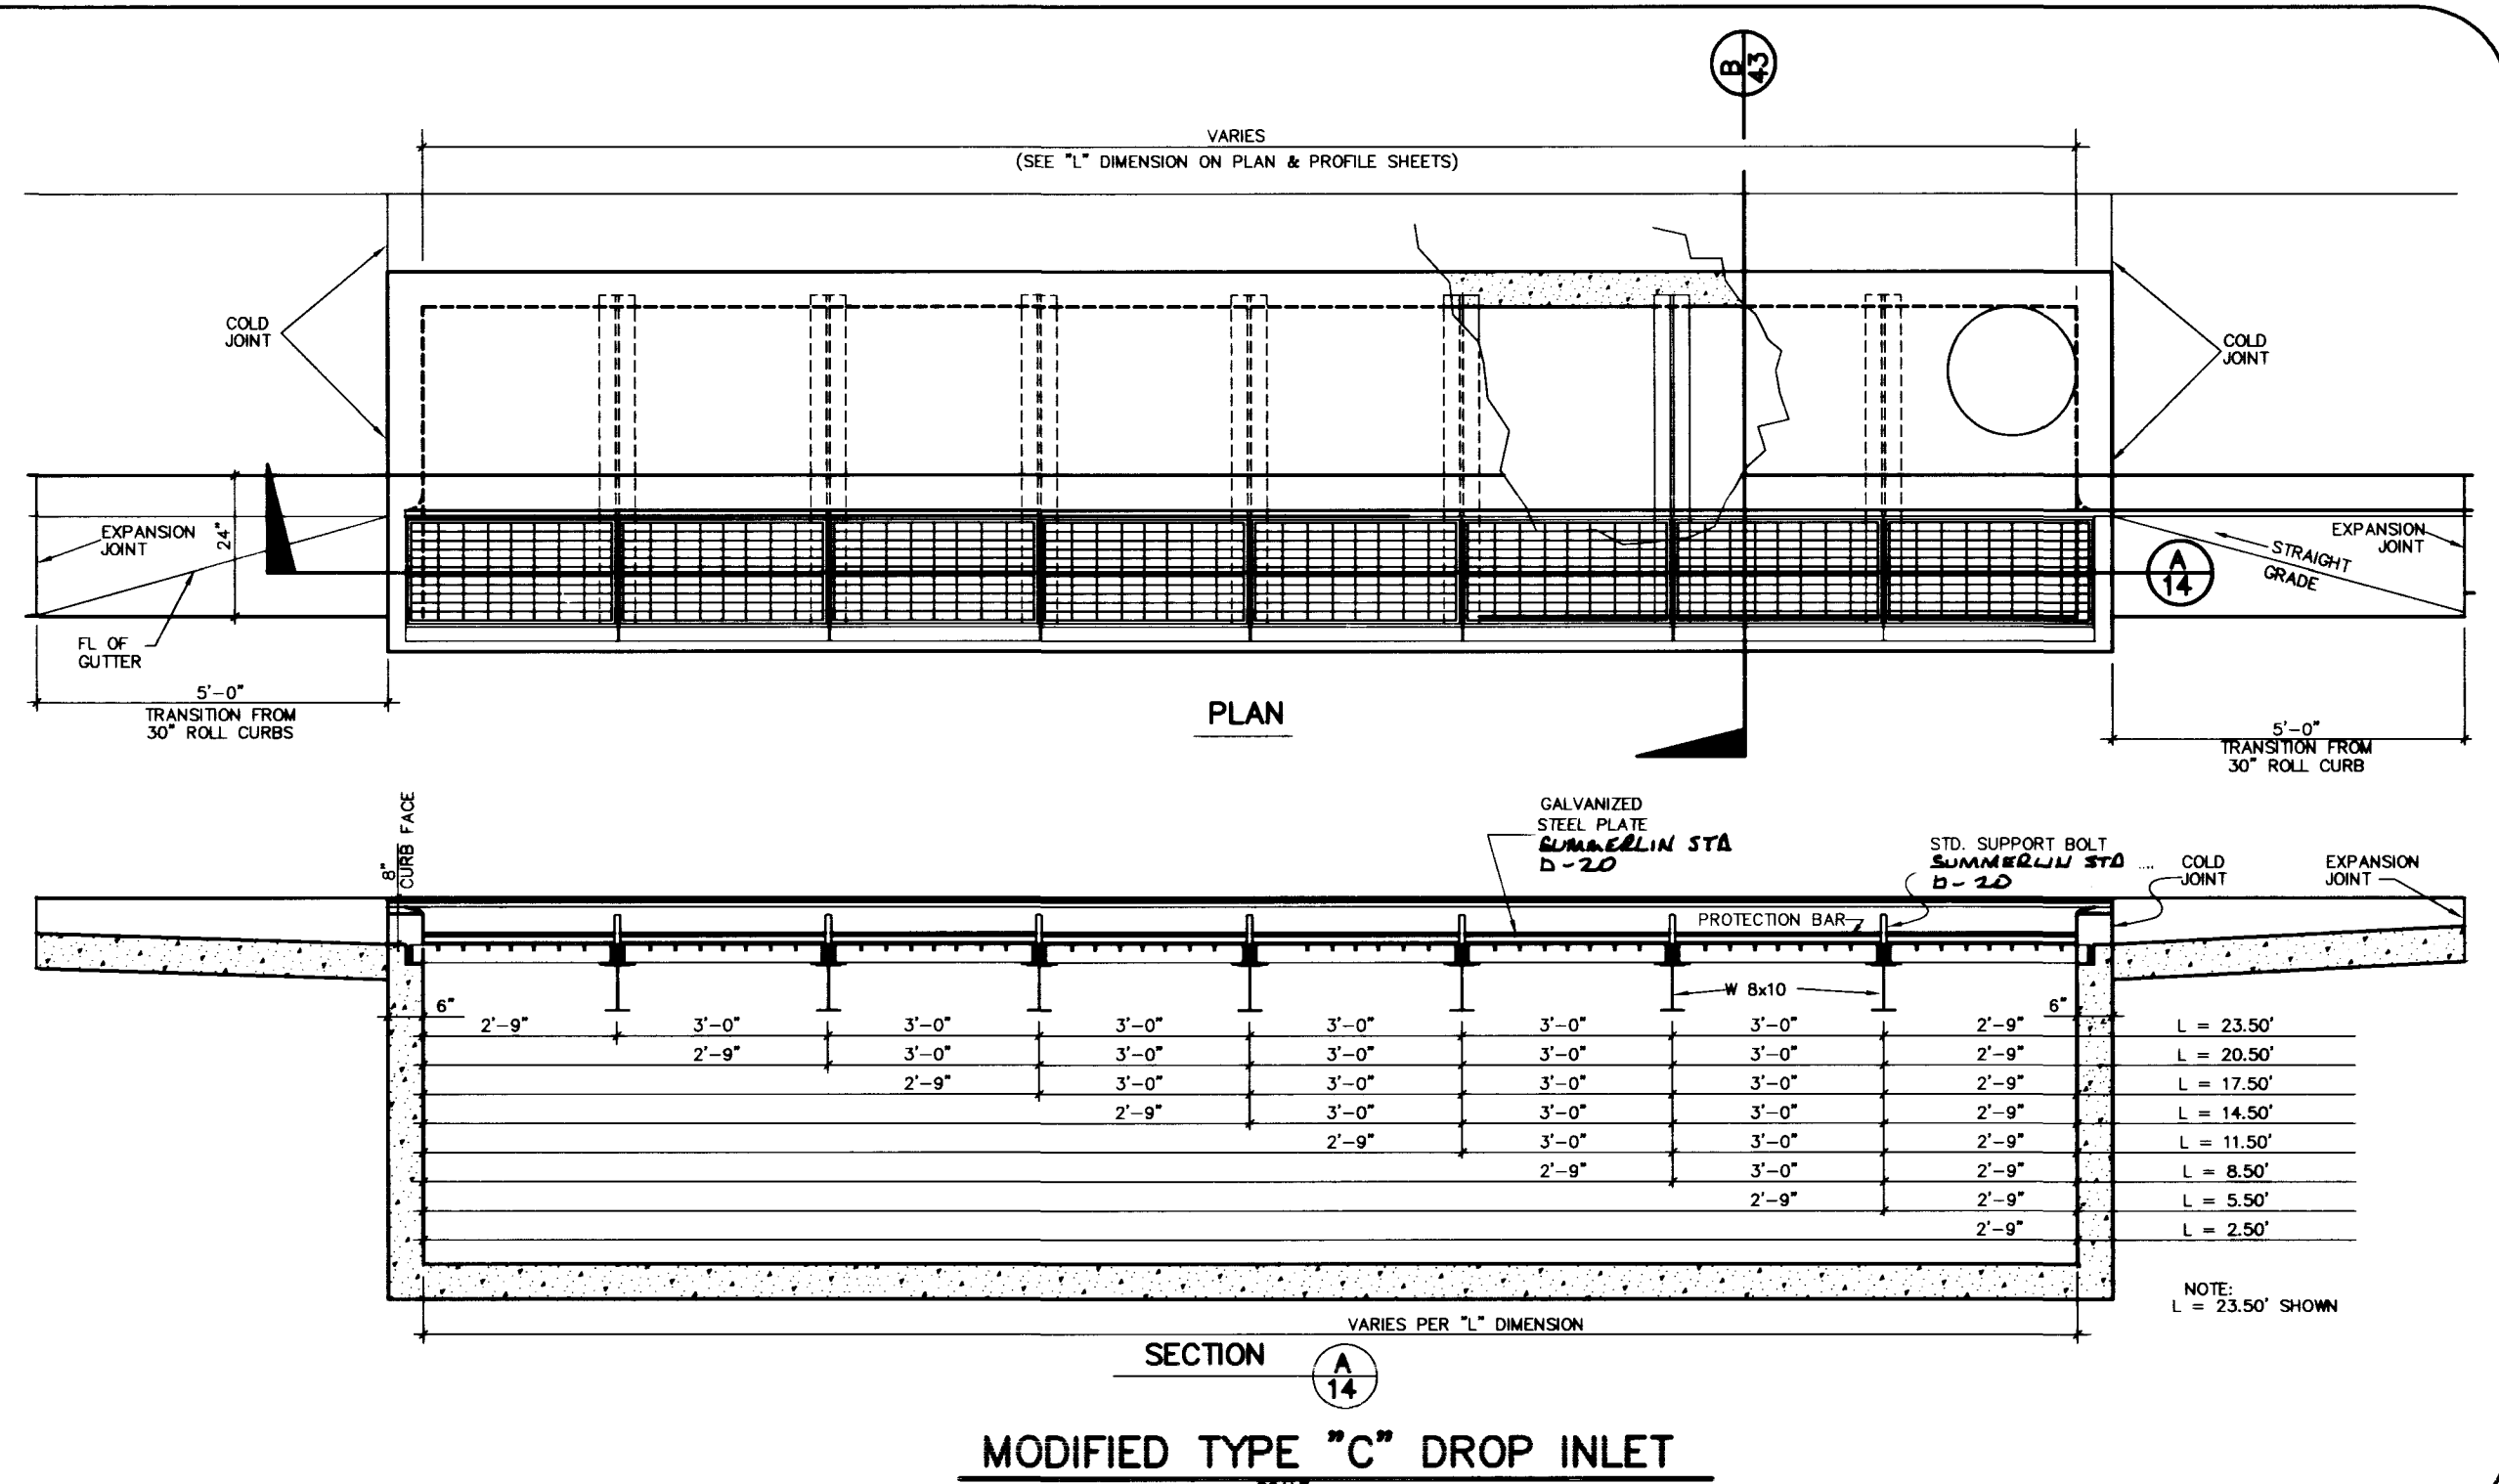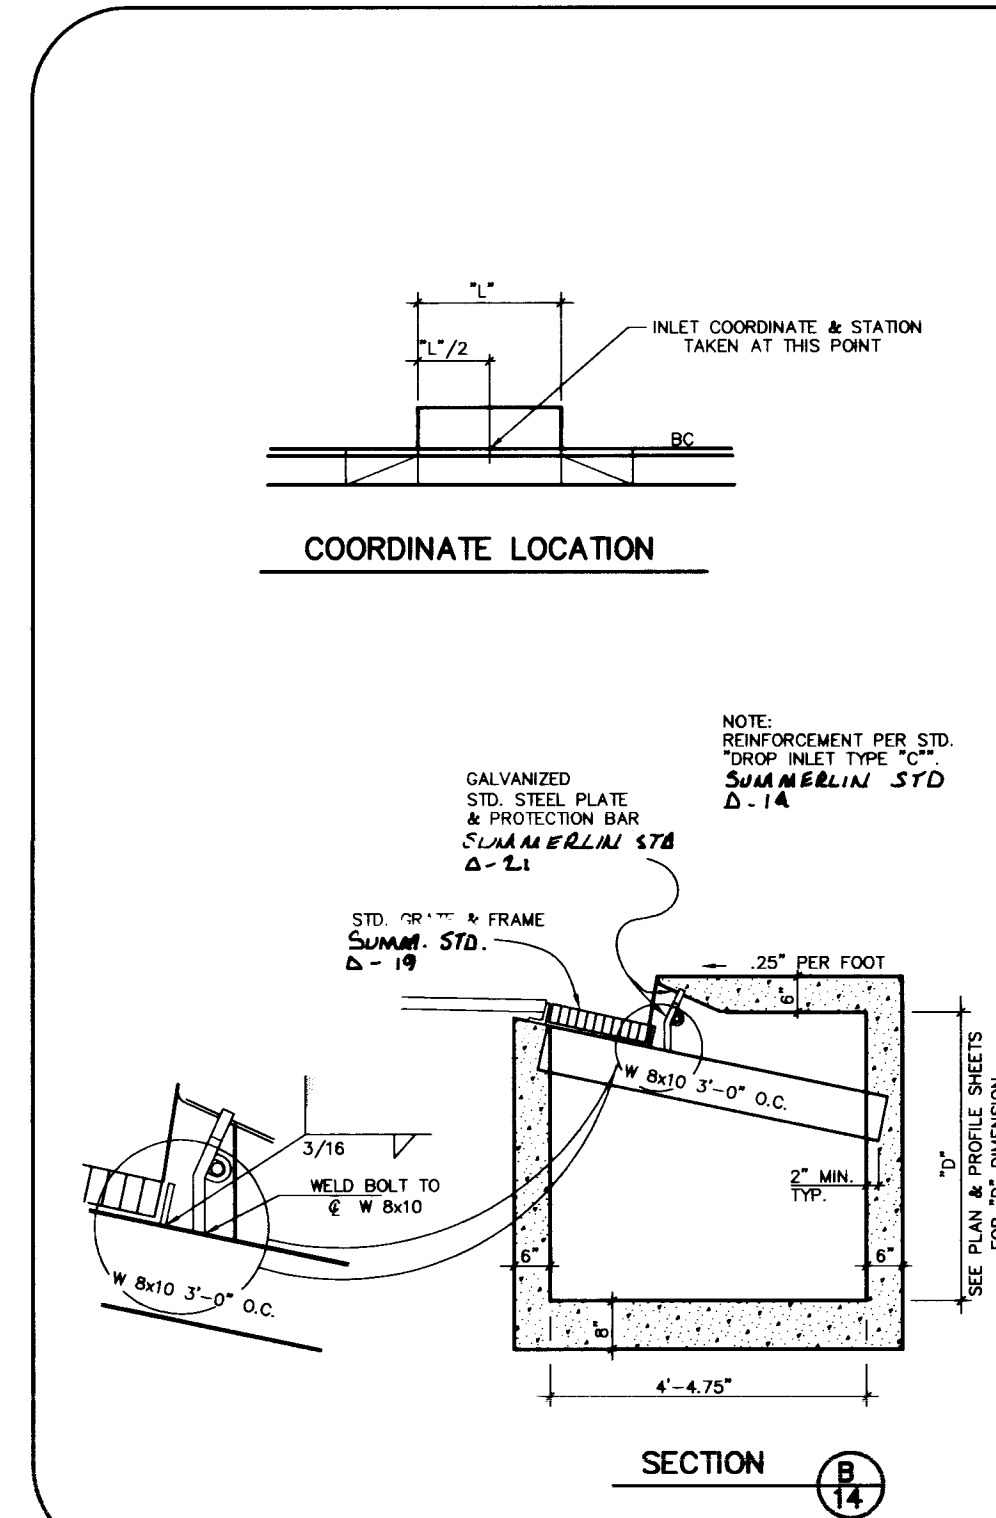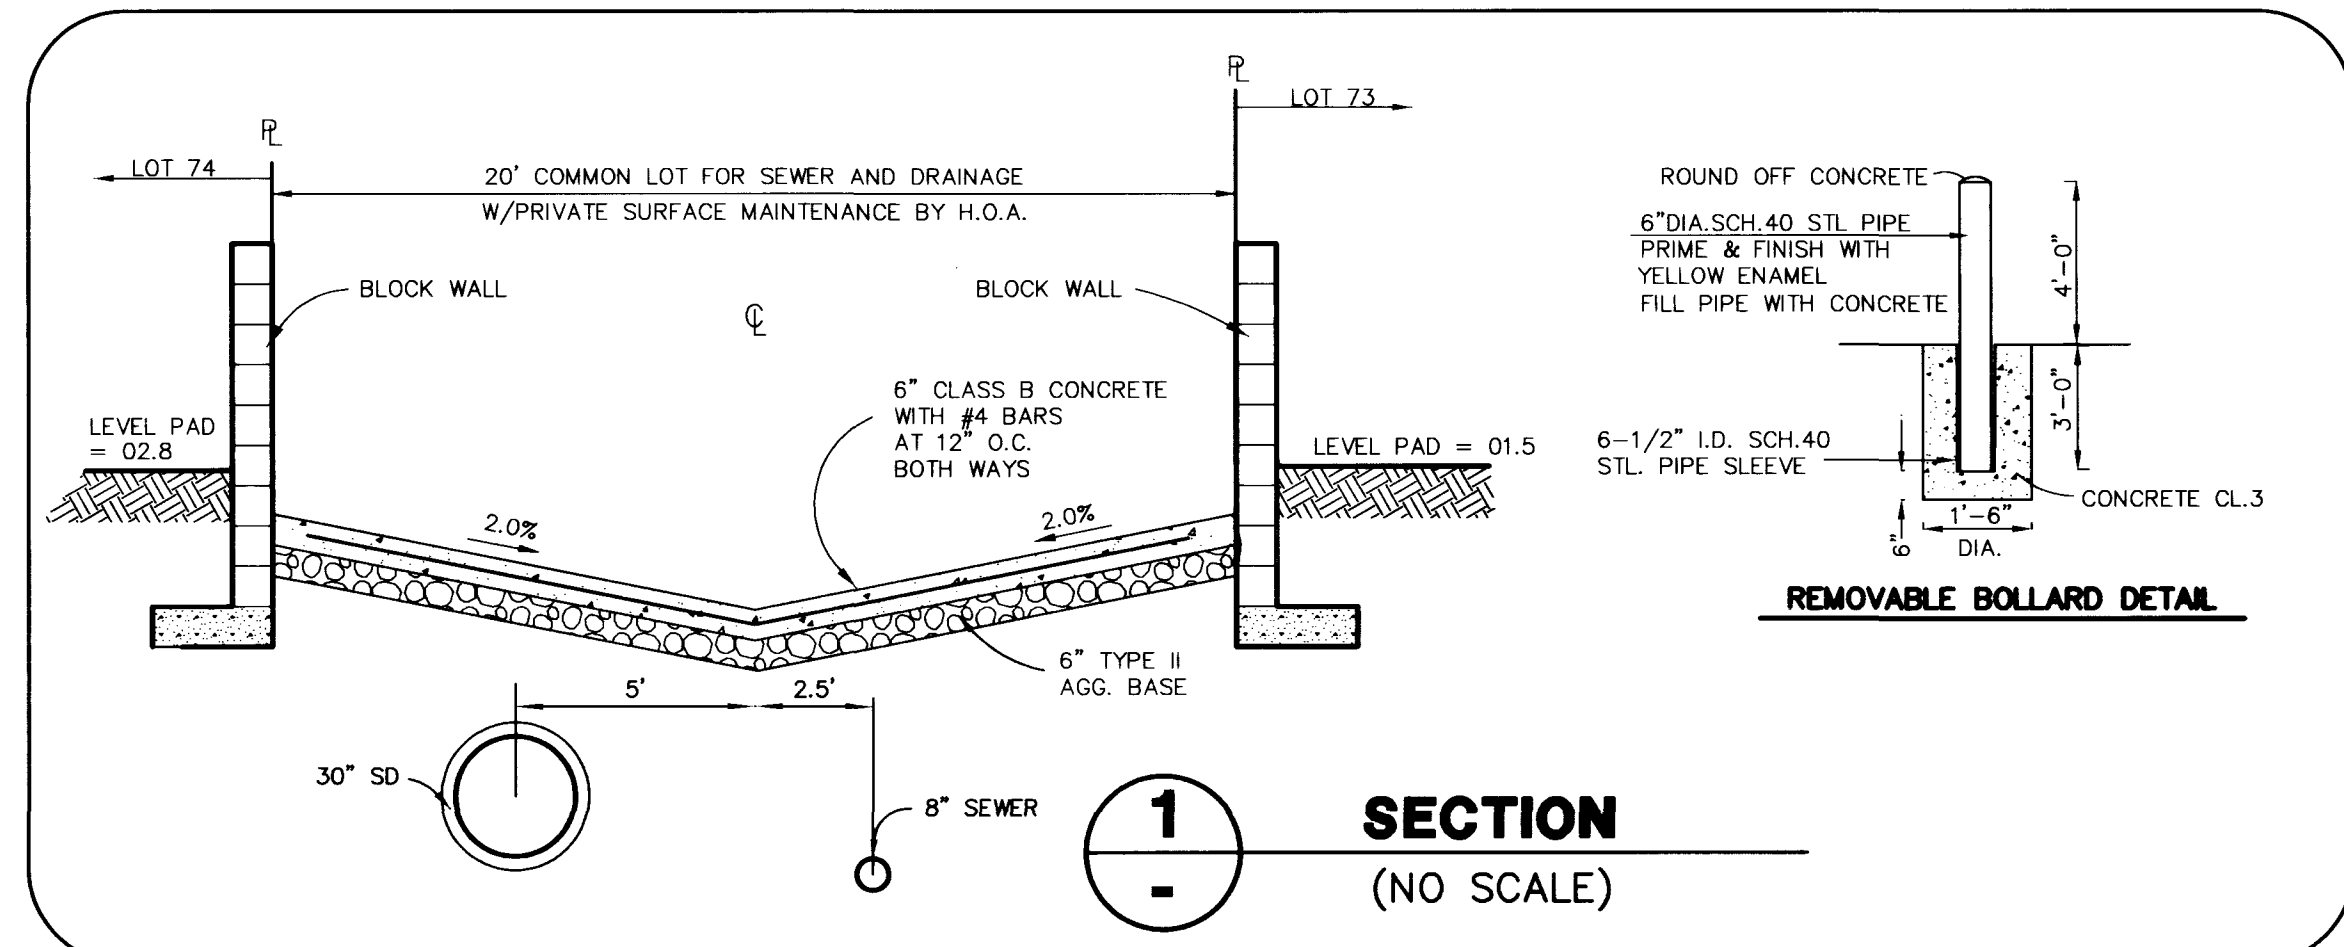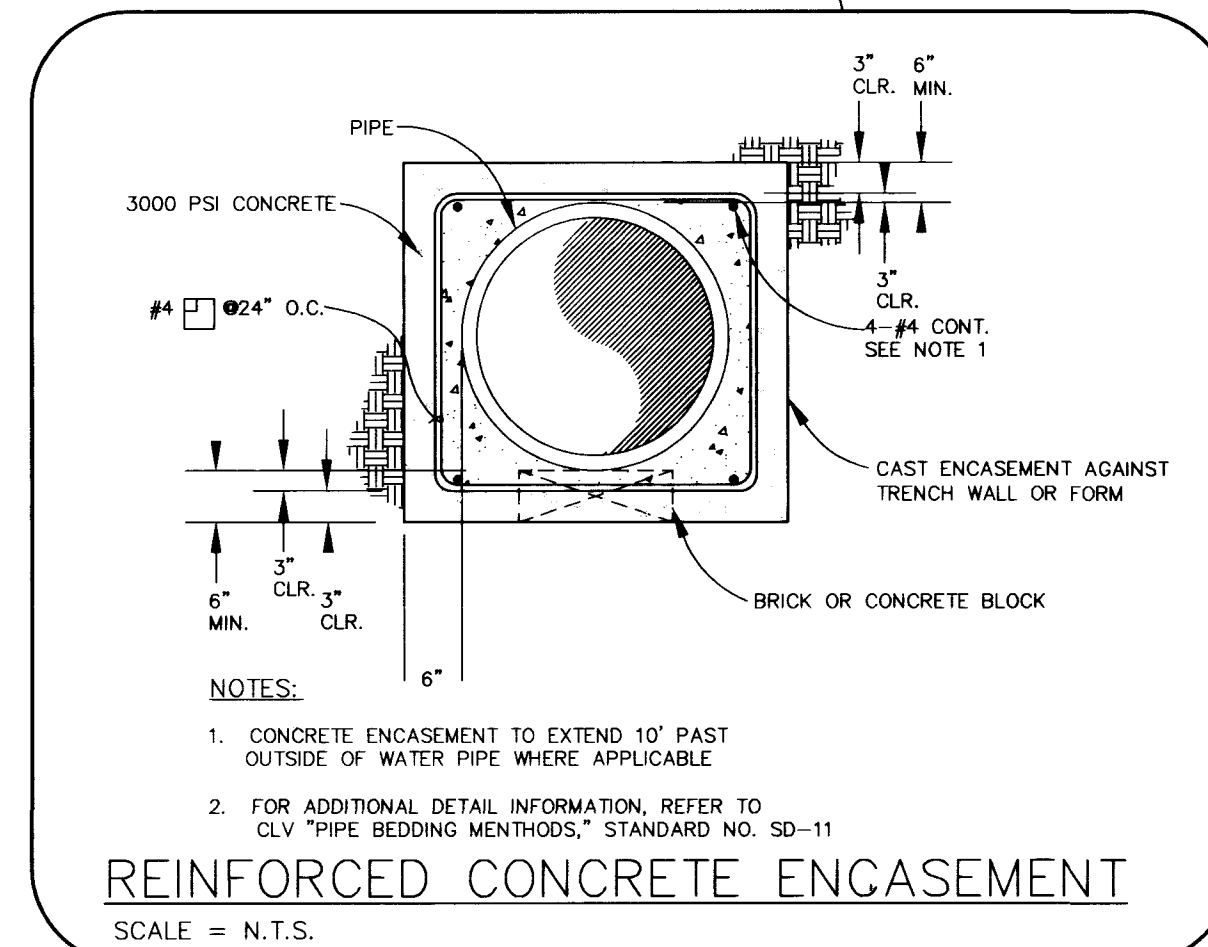

G. C. WALLACE, INC.
 Engineering/Architecture
 888 SOUTH RAINBOW BLVD., LAS VEGAS, NEVADA 89101
 (702) 369-1200
 Xrefs: MNO-TOP.DWG PBSJ-619.DWG 0705TE.DWG

CHRISTOPHER HOMES
SUMMERLIN VILLAGE 3, PARCEL 'O' - PHASE I
GRADING PLAN III

SHEET **14**
 OF 15 SHEETS

107Y-4510-1

