
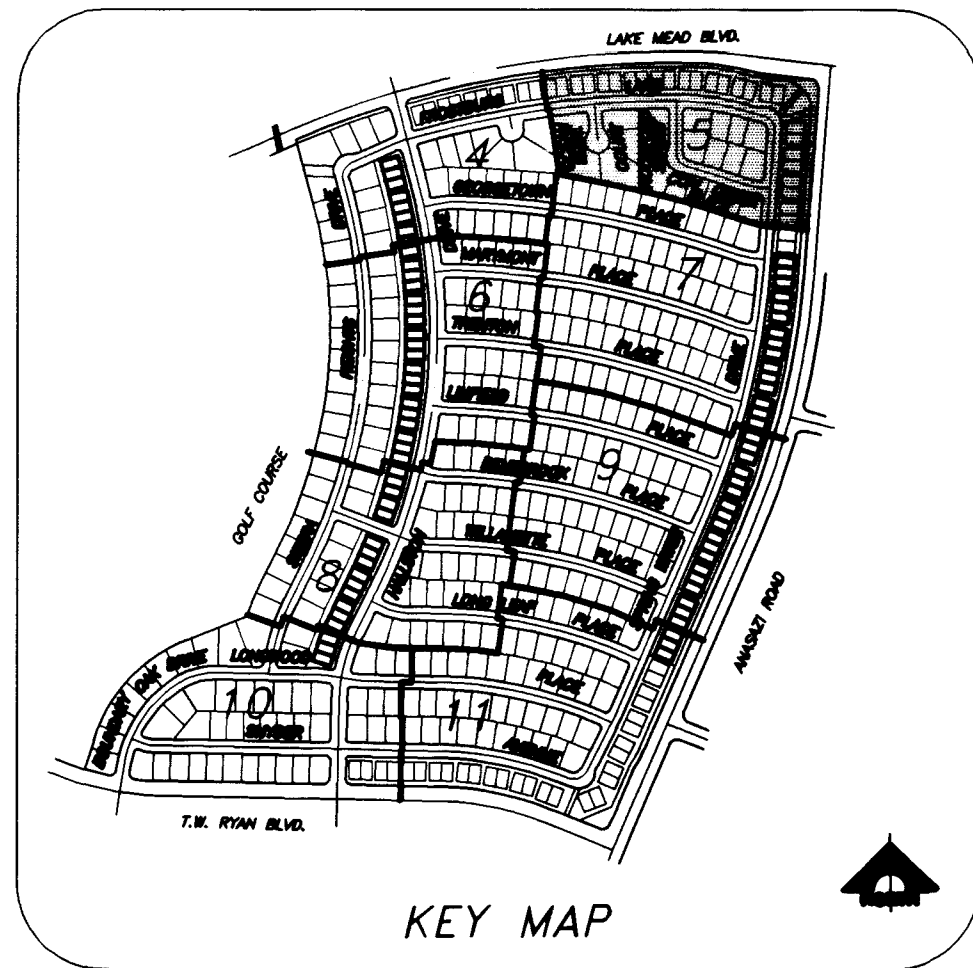


SEWER AS-BUILTS


ALL SEWER MANHOLES 48" DIAMETER UNLESS OTHERWISE NOTED

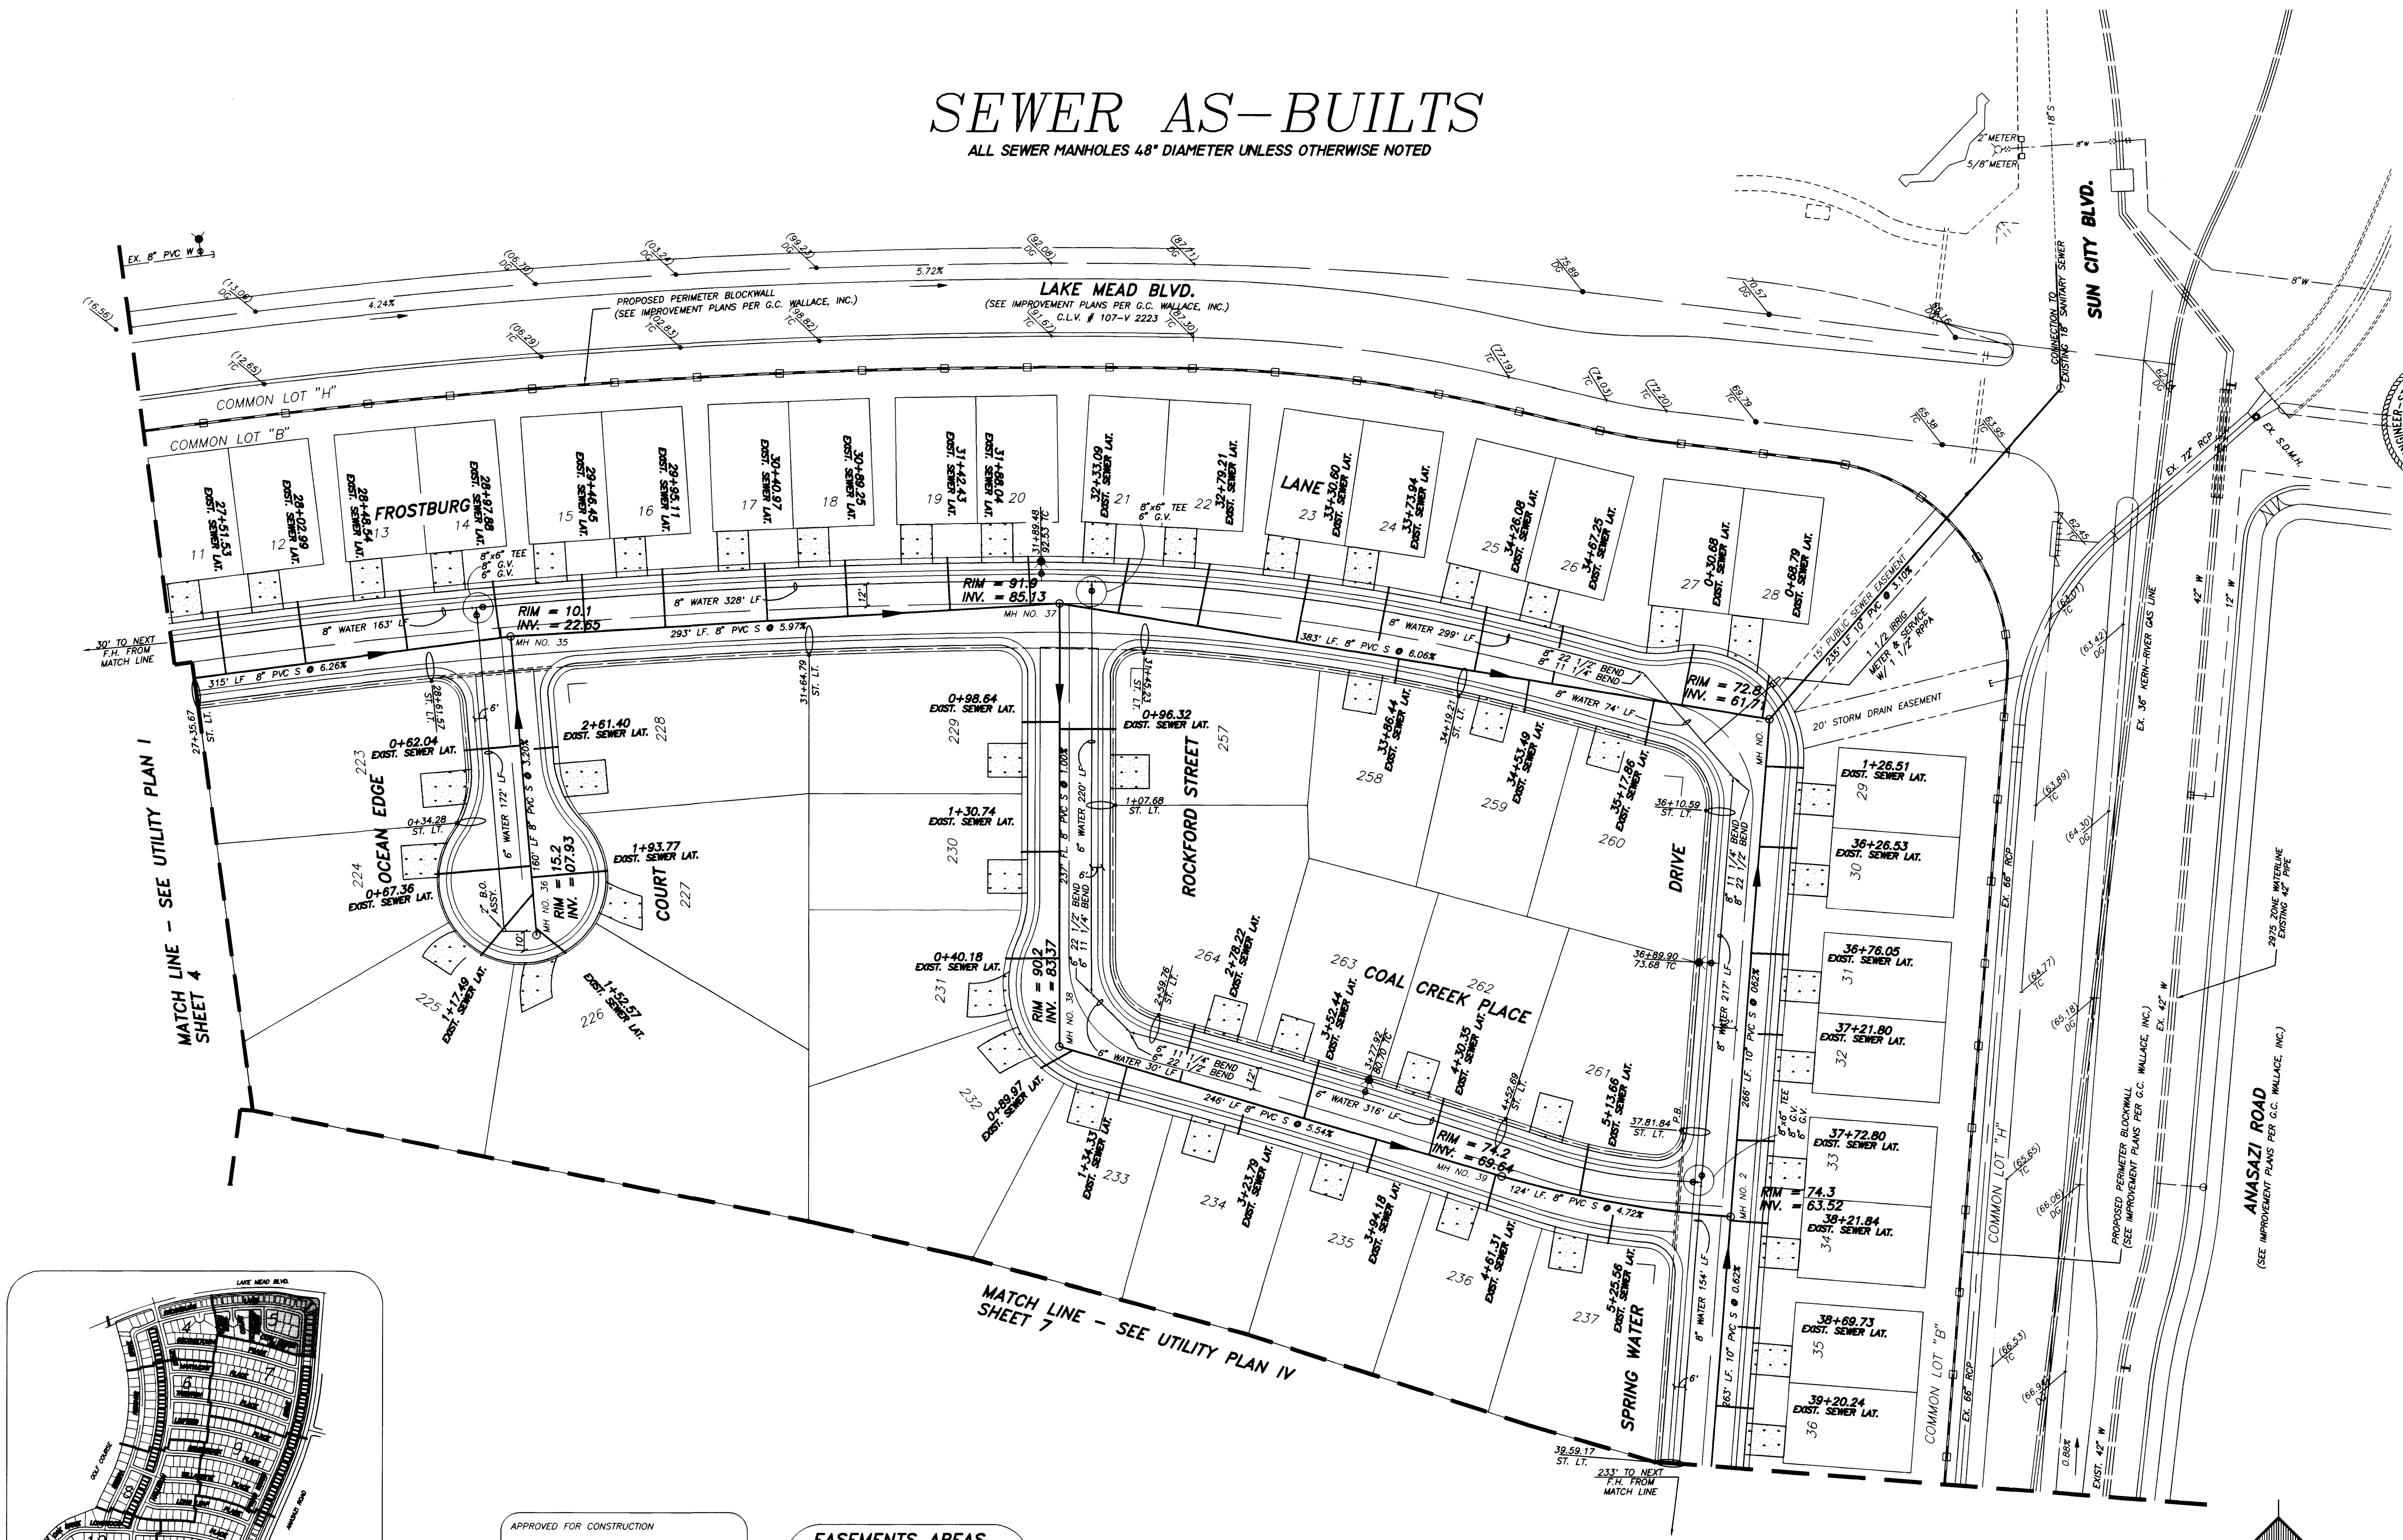

APPROVED FOR CONSTRUCTION
LAS VEGAS VALLEY WATER DISTRICT DATE

EASEMENTS AREAS
ALL PUBLIC UTILITY EASEMENTS SURFACE AREAS ARE TO BE PRIVATELY MAINTAINED BY HOME OWNERS ASSOCIATIONS.

NORTH
SCALE: 1" = 40'
"As Built" 307Y-4/41-46

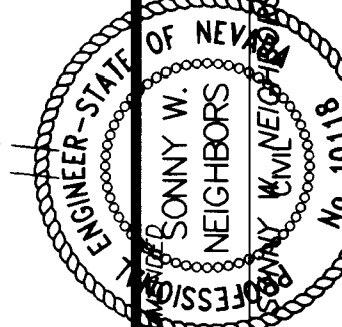

G.C. WALLACE, INC.
Engineering/Architecture
1555 SOUTH RAINBOW BLVD./LAS VEGAS, NEVADA 89102

DEL WEBB COMMUNITIES, INC.
SUN CITY LAS VEGAS UNIT NO. 46
UTILITY PLAN II

SHEET
5
OF 48 SHEETS

REV	DATE	DESCRIPTION	CLV	DATE

SEWER AS-BUILTS

ALL RIGHTS RESERVED. NO PART OF THIS PUBLICATION MAY BE REPRODUCED OR TRANSMITED IN ANY FORM OR BY ANY MEANS, ELECTRONIC OR MECHANICAL, INCLUDING PHOTOCOPYING, RECORDING, OR BY ANY INFORMATION STORAGE AND RETRIEVAL SYSTEM, WITHOUT PERMISSION IN WRITING FROM THE PUBLISHER.

