



SEWER AS-BUILTS

ALL SEWER MANHOLES 48" DIAMETER UNLESS OTHERWISE NOTED

MATCH LINE - SEE UTILITY PLAN VI SHEET 9


MATCH LINE - SEE UTILITY PLAN V SHEET 8

MATCH LINE - SEE UTILITY PLAN VII SHEET 10

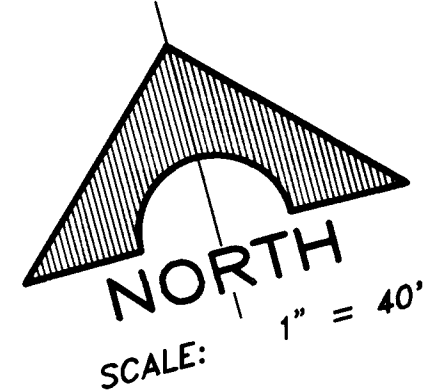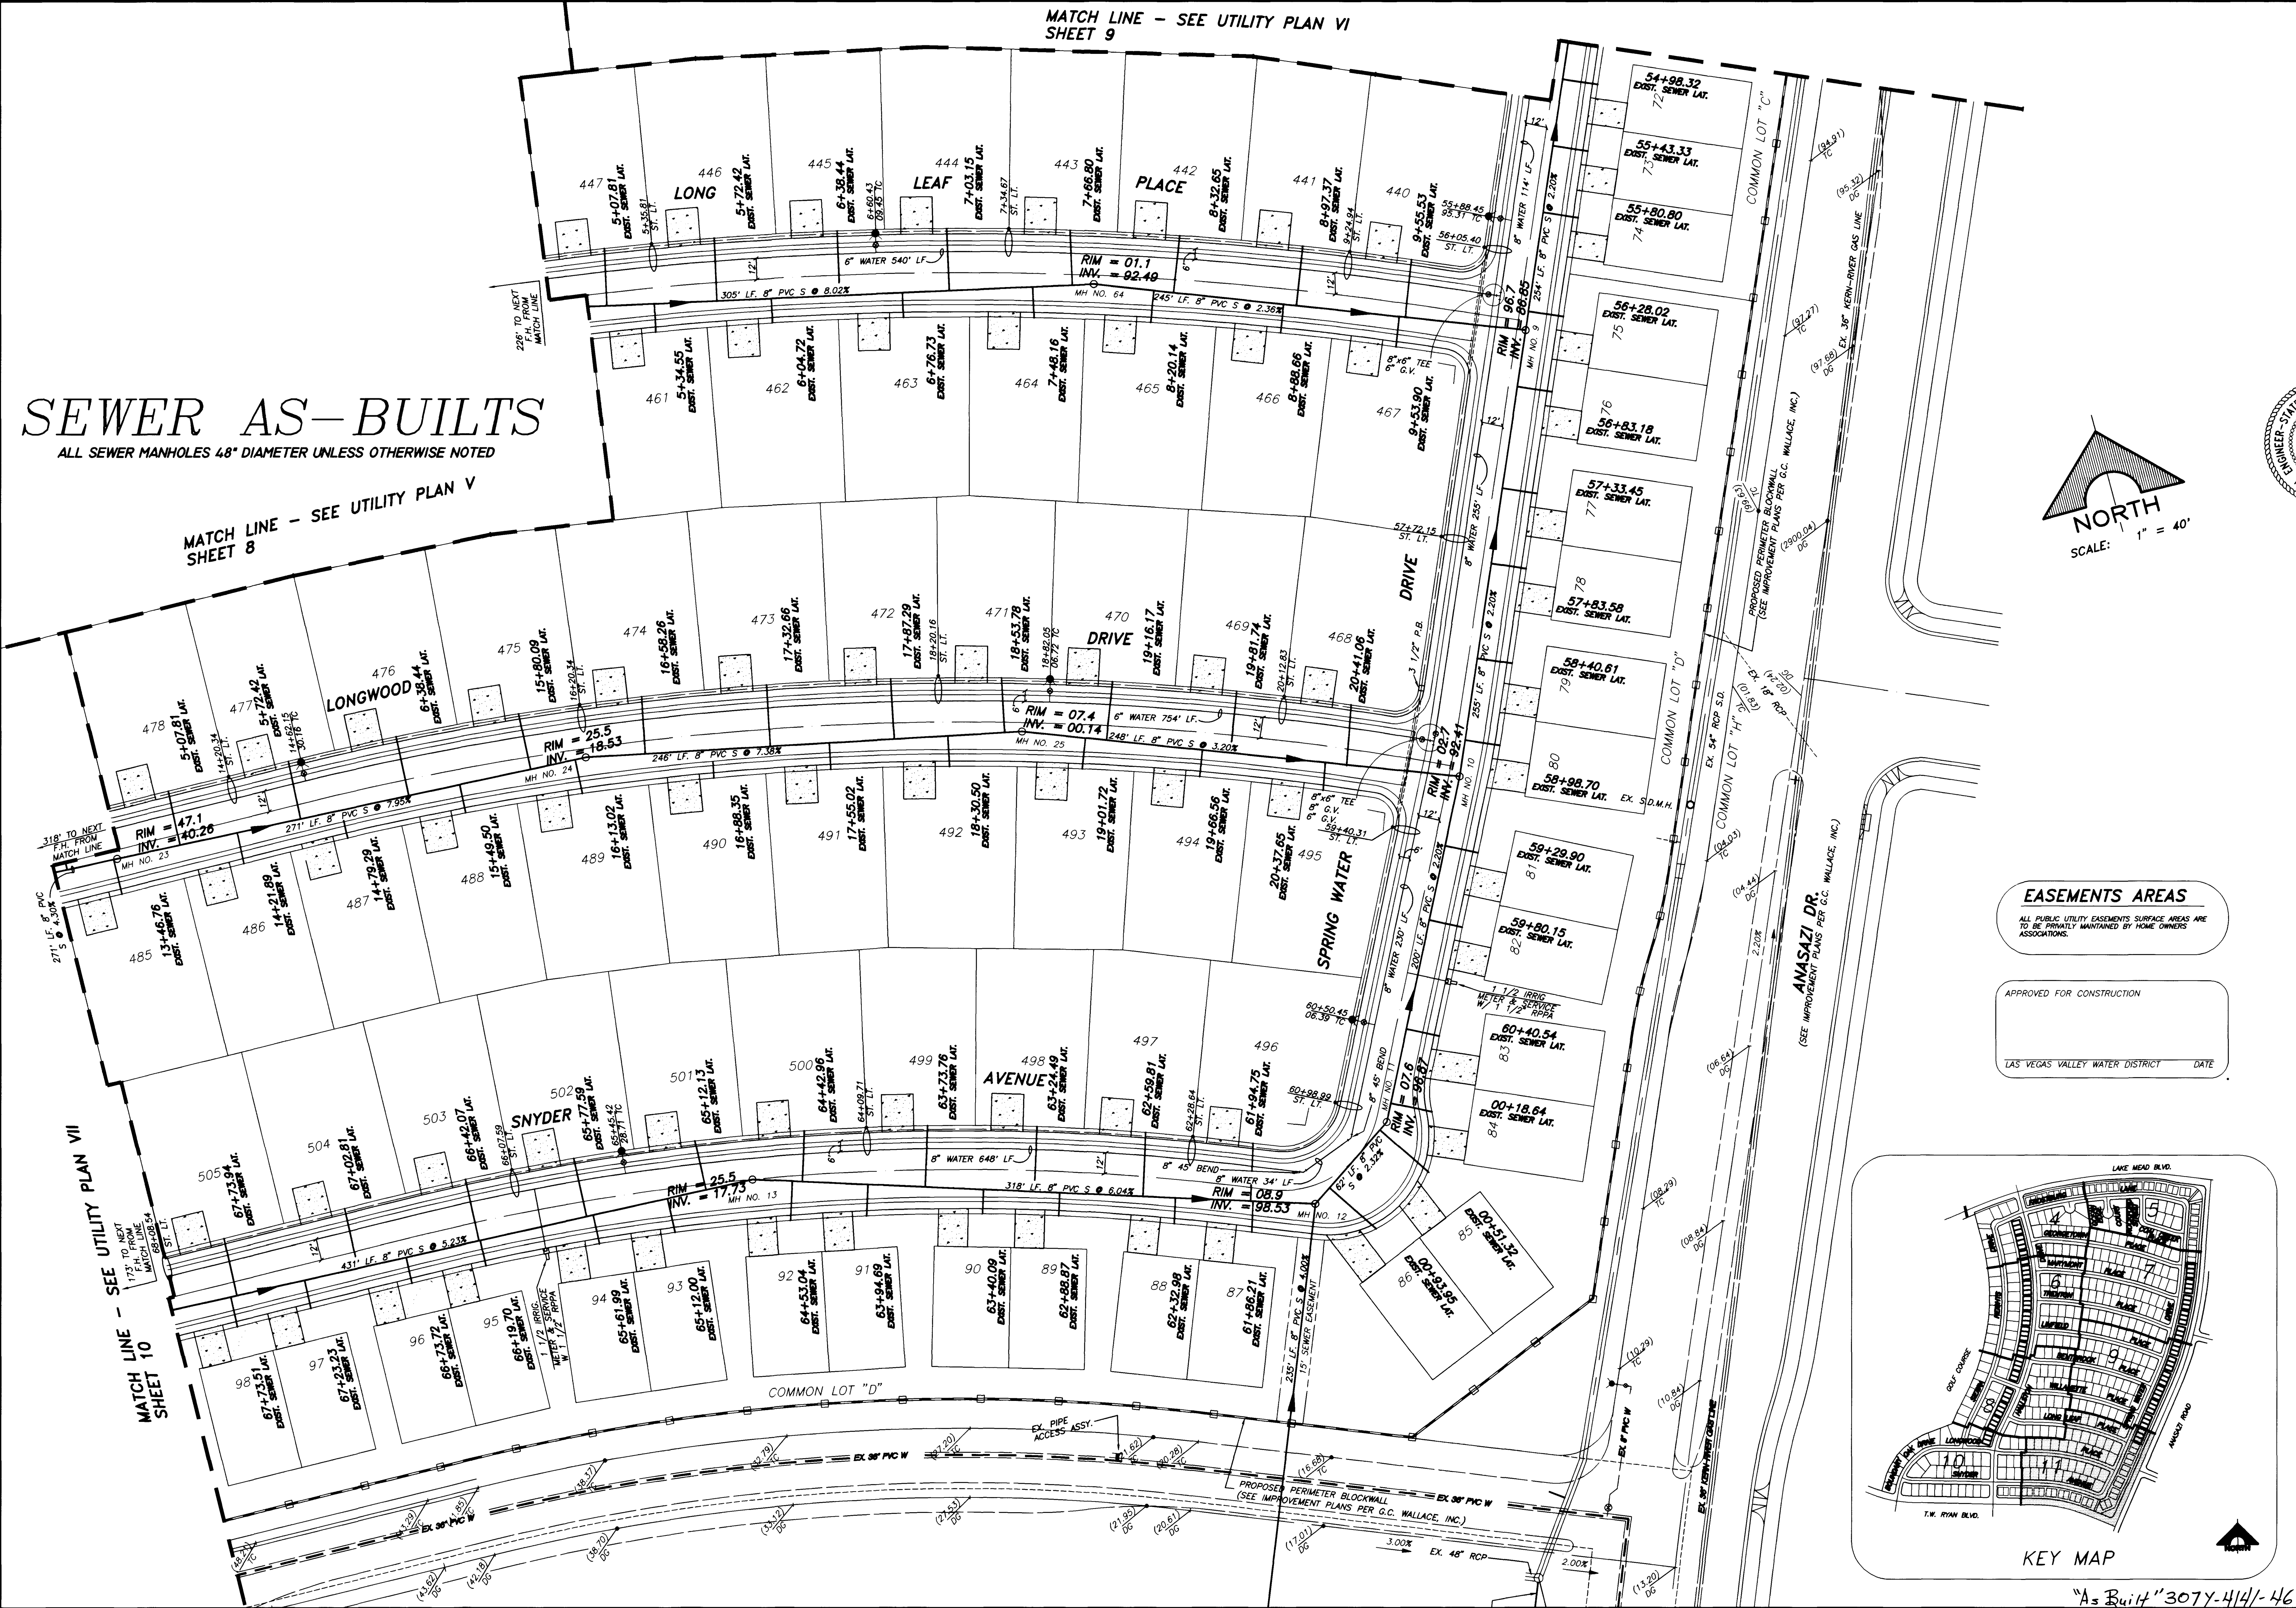

EASEMENTS AREAS
ALL PUBLIC UTILITY EASEMENTS SURFACE AREAS ARE TO BE PRIVATELY MAINTAINED BY HOME OWNERS ASSOCIATIONS.

APPROVED FOR CONSTRUCTION
LAS VEGAS VALLEY WATER DISTRICT DATE

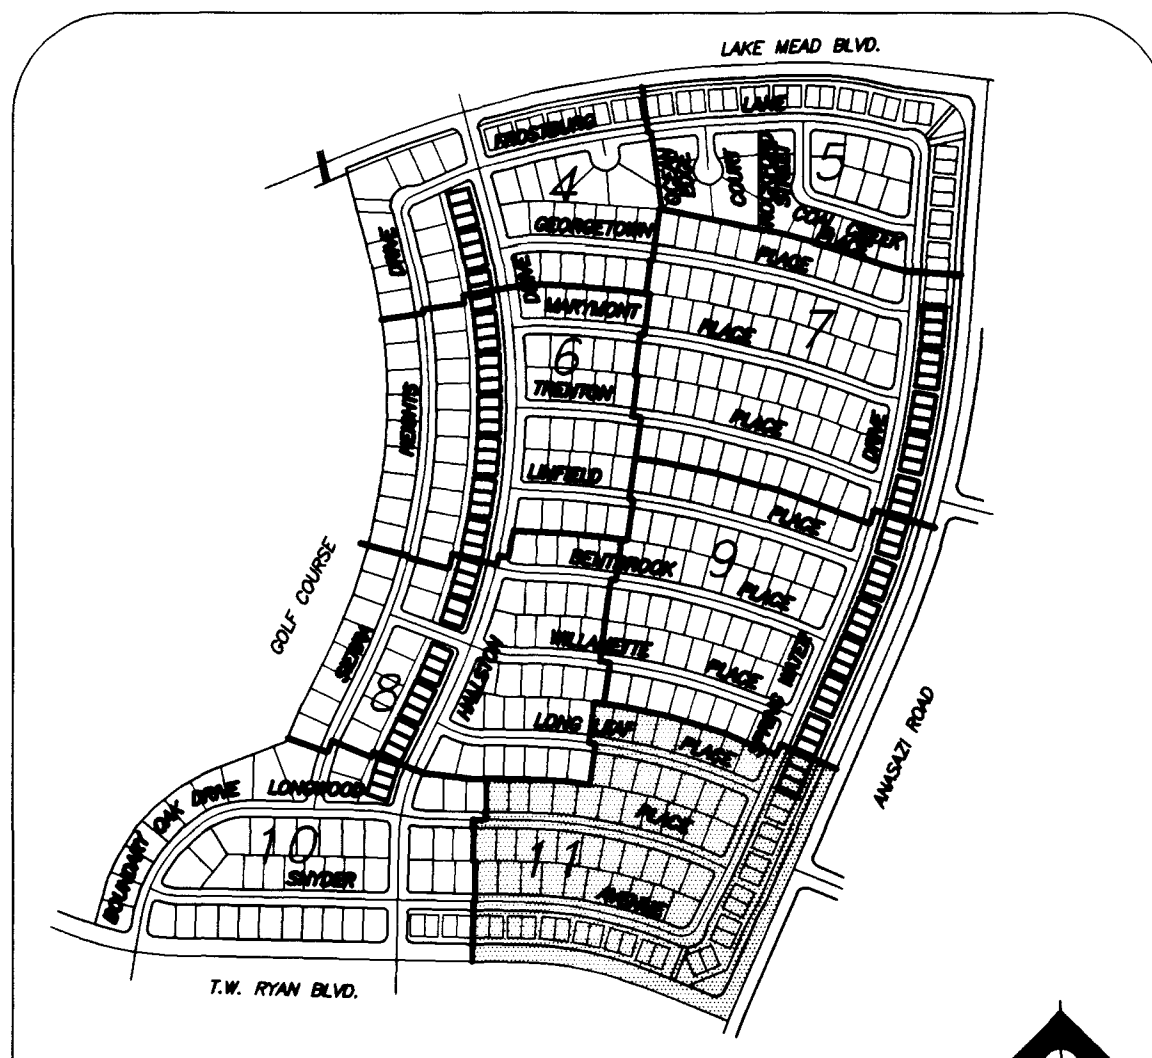

REV.	DATE	DESCRIPTION	CLBY	DATE

REGISTERED PROFESSIONAL ENGINEER
STATE OF NEVADA
G.C. WALLACE, INC.
1555 SOUTH RAINBOW BLVD./LAS VEGAS, NEVADA 89102
PE. NO. 10118

DEL WEBB COMMUNITIES, INC.
SUN CITY LAS VEGAS UNIT NO. 46
UTILITY PLAN VIII
SHEET 11 OF 48 SHEETS

"As Built" 307Y-414/-46

SEWER AS-BUILTS

ALL SEWER MAINS AND MANHOLES SHOWN BY THIS PLAN

MUCH LINE - SEE UTILITY PLAN W
SHEET 2

MUCH LINE - SEE UTILITY PLAN V
SHEET 1



SHOWS MAIN
SCALE 1" = 40'



KEY MAP



MICHAEL WALLACE, INC.
Professional Engineers

ALL WORK CONFORMS TO THE
STATE OF TEXAS ENGINEERING
ACT

SEWER PLAN 88

11