
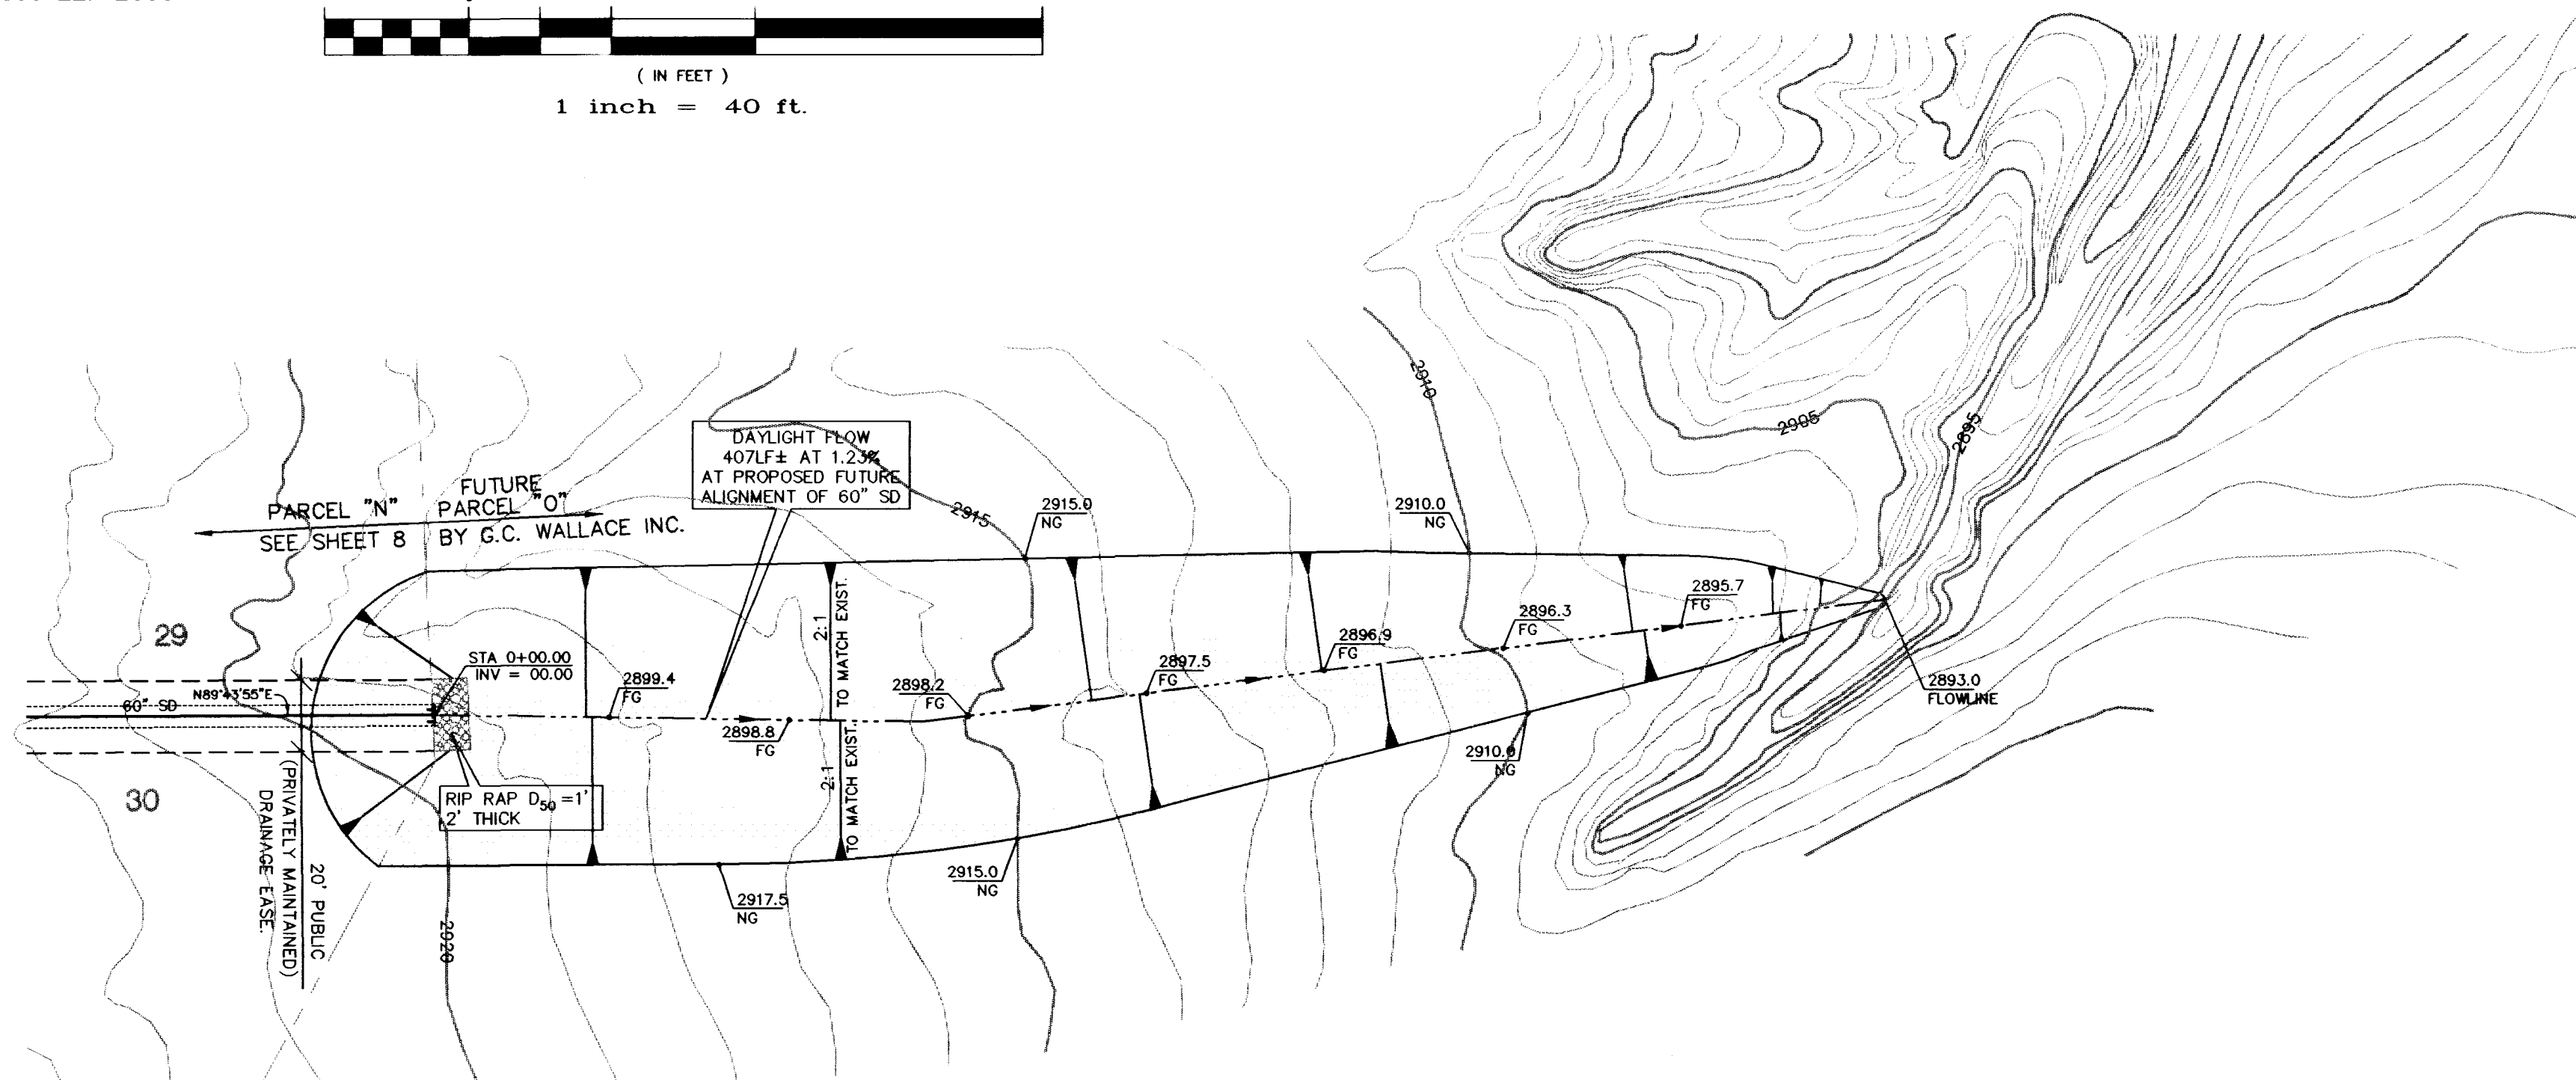




Call before you Overhead
1-702-593-6111
NEVADA POWER ENVIRONMENT AND SAFETY SERVICES DEPARTMENT

Call before you Dig
1-800-227-2600

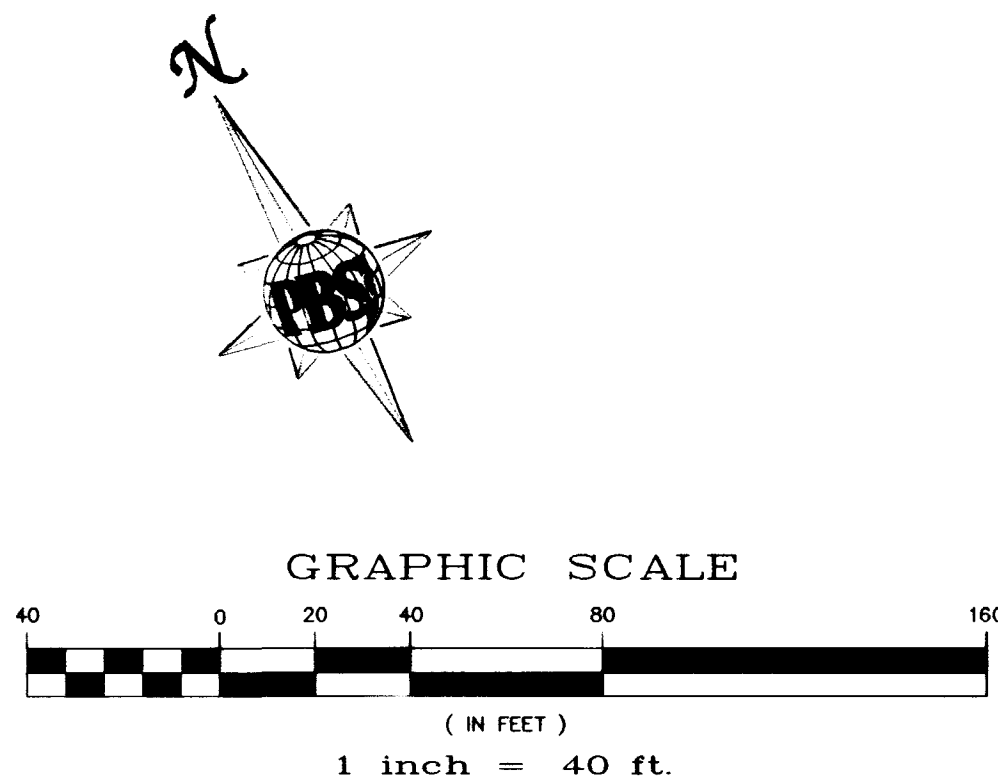

(INTERIM PLAN)
PARCEL 'O' OFFSITE DAYLIGHT PLAN
HORIZONTAL SCALE: 1" = 40'

NOTE:
INTERIM CONDITIONS TO BE CONSTRUCTED ONLY IF CONSTRUCTION SCHEDULES BETWEEN PARCEL "N" (TALON POINTE) AND PARCEL "O" WILL NOT ACCOMMODATE FULL STORM DRAIN BUILDOUT.

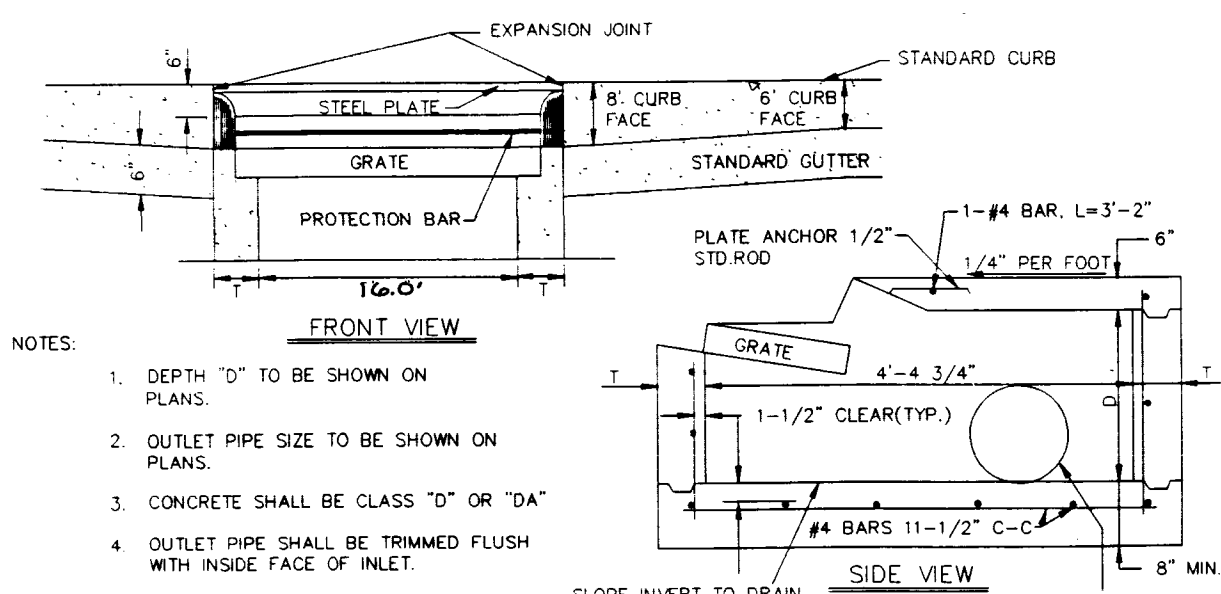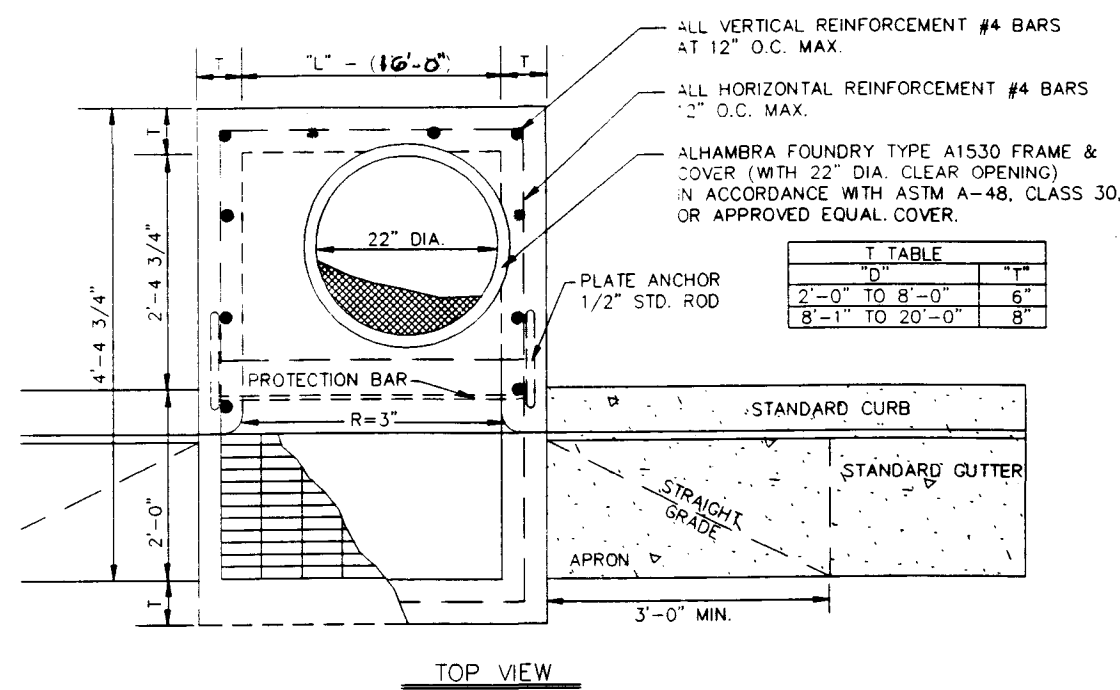


NOTES:


- DEPTH "D" TO BE SHOWN ON PLANS.
- OUTLET PIPE SIZE TO BE SHOWN ON PLANS.
- CONCRETE SHALL BE CLASS "D" OR "DA"
- OUTLET PIPE SHALL BE TRIMMED FLUSH WITH INSIDE FACE OF INLET.
- FOR GRATE DETAIL SEE C.C. DWG. NO. 416.
- FOR REBAR SIZE & PLACEMENT SEE C.C. DWG. NO. 413.

MODIFIED TYPE "C" DROP INLET


NO SCALE

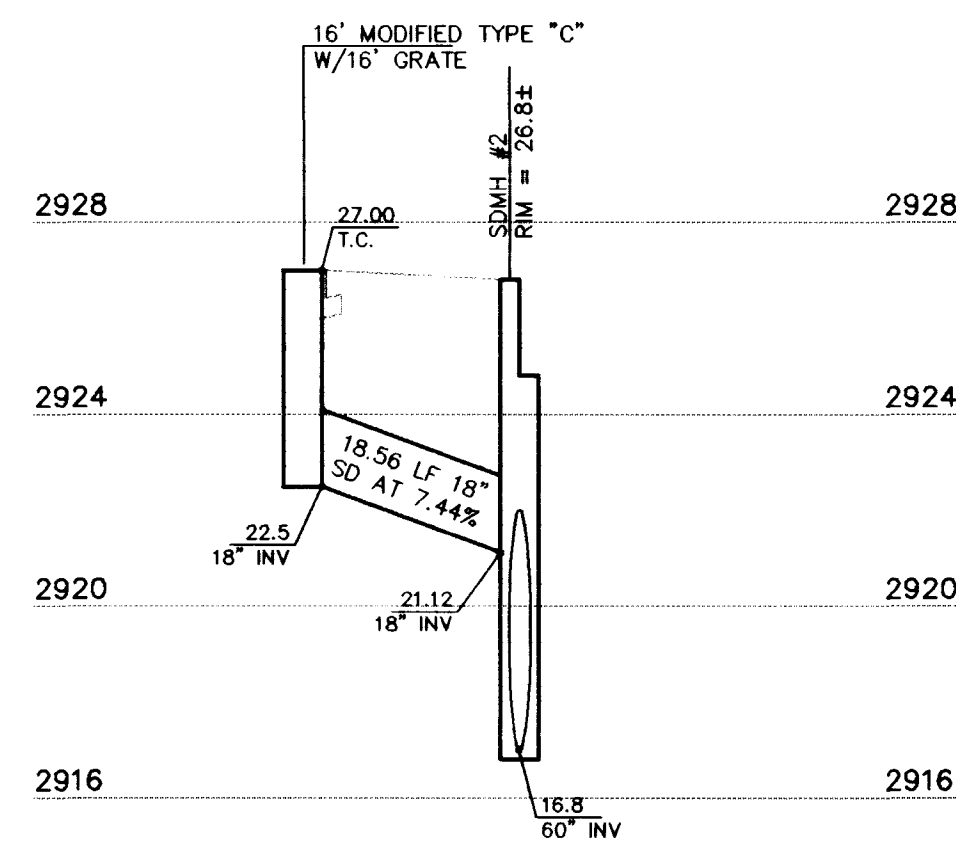


STORM DRAIN LATERAL
HORIZONTAL SCALE: 1" = 20'
VERTICAL SCALE: 1" = 4'

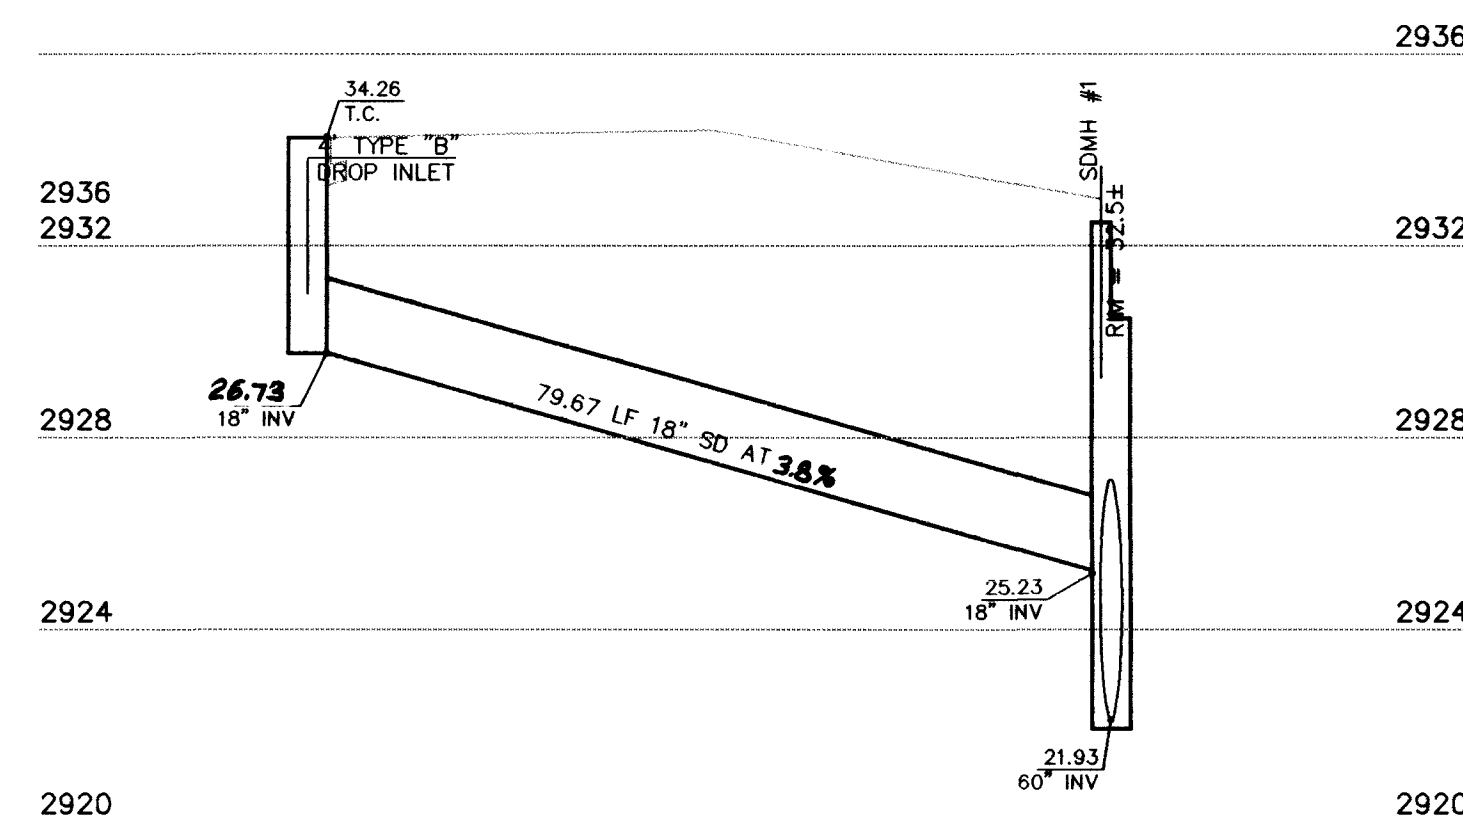


STORM DRAIN LATERAL
HORIZONTAL SCALE: 1" = 20'
VERTICAL SCALE: 1" = 4'

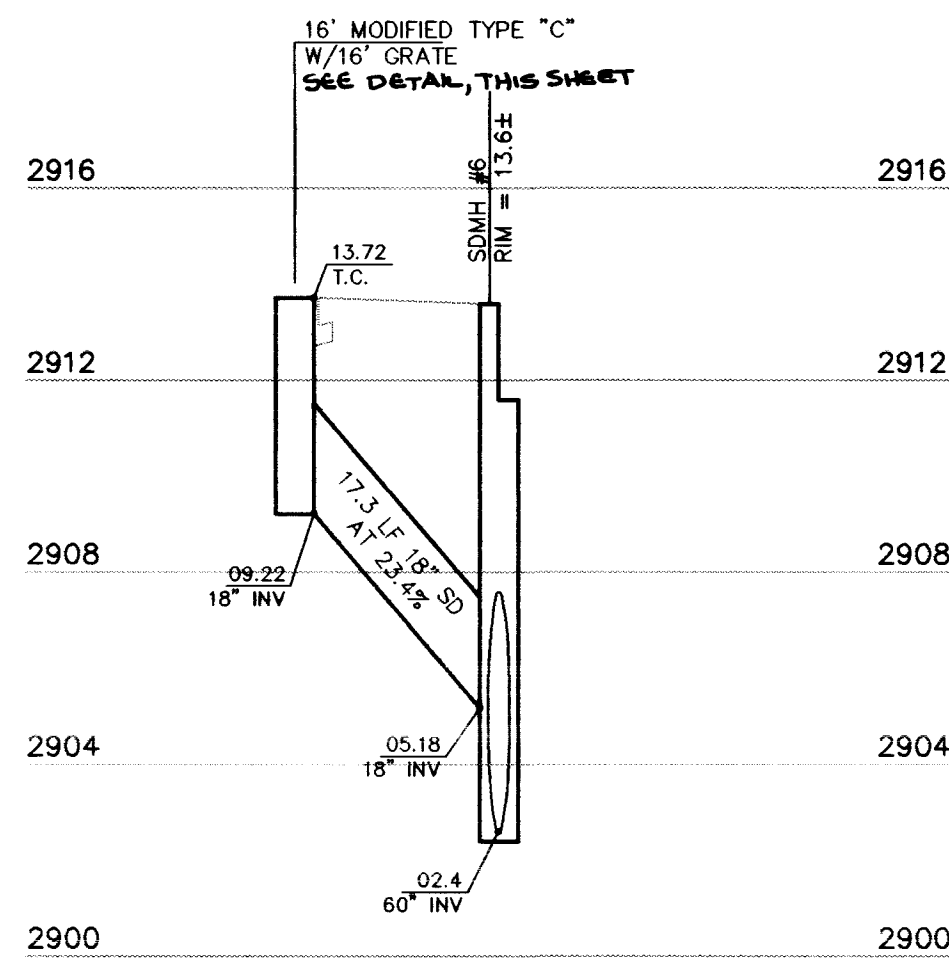

STORM DRAIN LATERAL
HORIZONTAL SCALE: 1" = 20'
VERTICAL SCALE: 1" = 4'

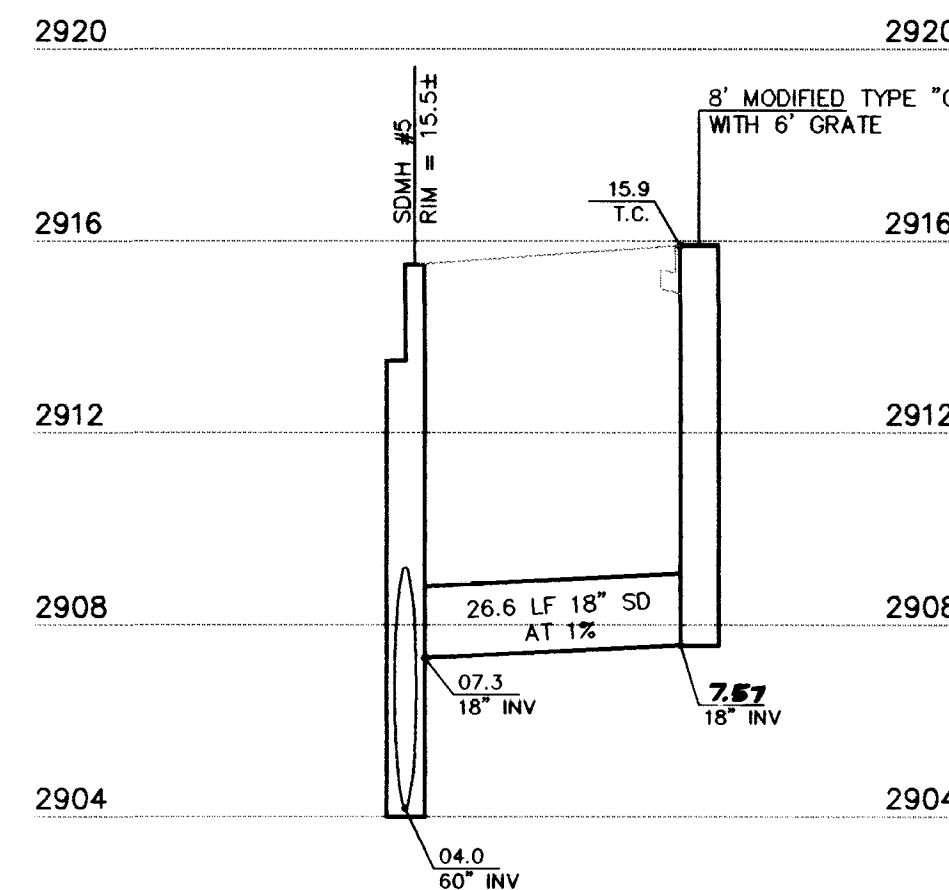

STORM DRAIN LATERAL
HORIZONTAL SCALE: 1" = 20'
VERTICAL SCALE: 1" = 4'

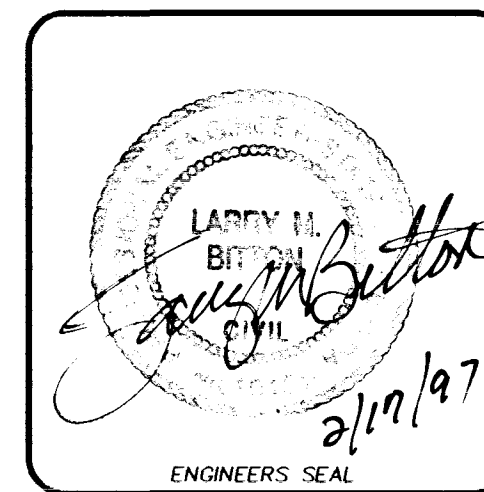

POST, BUCKLEY, SCHULZ & JERNIGAN
901 N. Green Valley Parkway
Suite 100
Las Vegas, NV 89121
Phone: 702/563-2774
Fax: 702/563-7200

J.M. PETERS
NEVADA

18" STORM DRAIN LATERAL PROFILES and OFFSITE (PARCEL 'O') 60" STORM DRAIN DAYLIGHTING PLAN

Job Number	Drawn by	Scale	Checked by	AS SHOWN	File No.	Date	DATE
5878	BR	1" = 20'	BR	1" = 20'	878IMP	OCT 1996	
Sheet Number	9 OF 9						

Date Init. Appr.

REVISIONS

No.

ENGINEERING • PLANNING • SURVEYING • CONSTRUCTION SERVICES

J.M. PETERS

18" STORM DRAIN LATERAL PROFILES and OFFSITE (PARCEL 'O') 60" STORM DRAIN DAYLIGHTING PLAN

Job Number	Drawn by	Scale	Checked by	AS SHOWN	File No.	Date	DATE
5878	BR	1" = 20'	BR	1" = 20'	878IMP	OCT 1996	
Sheet Number	9 OF 9						

PLAT DATE

