

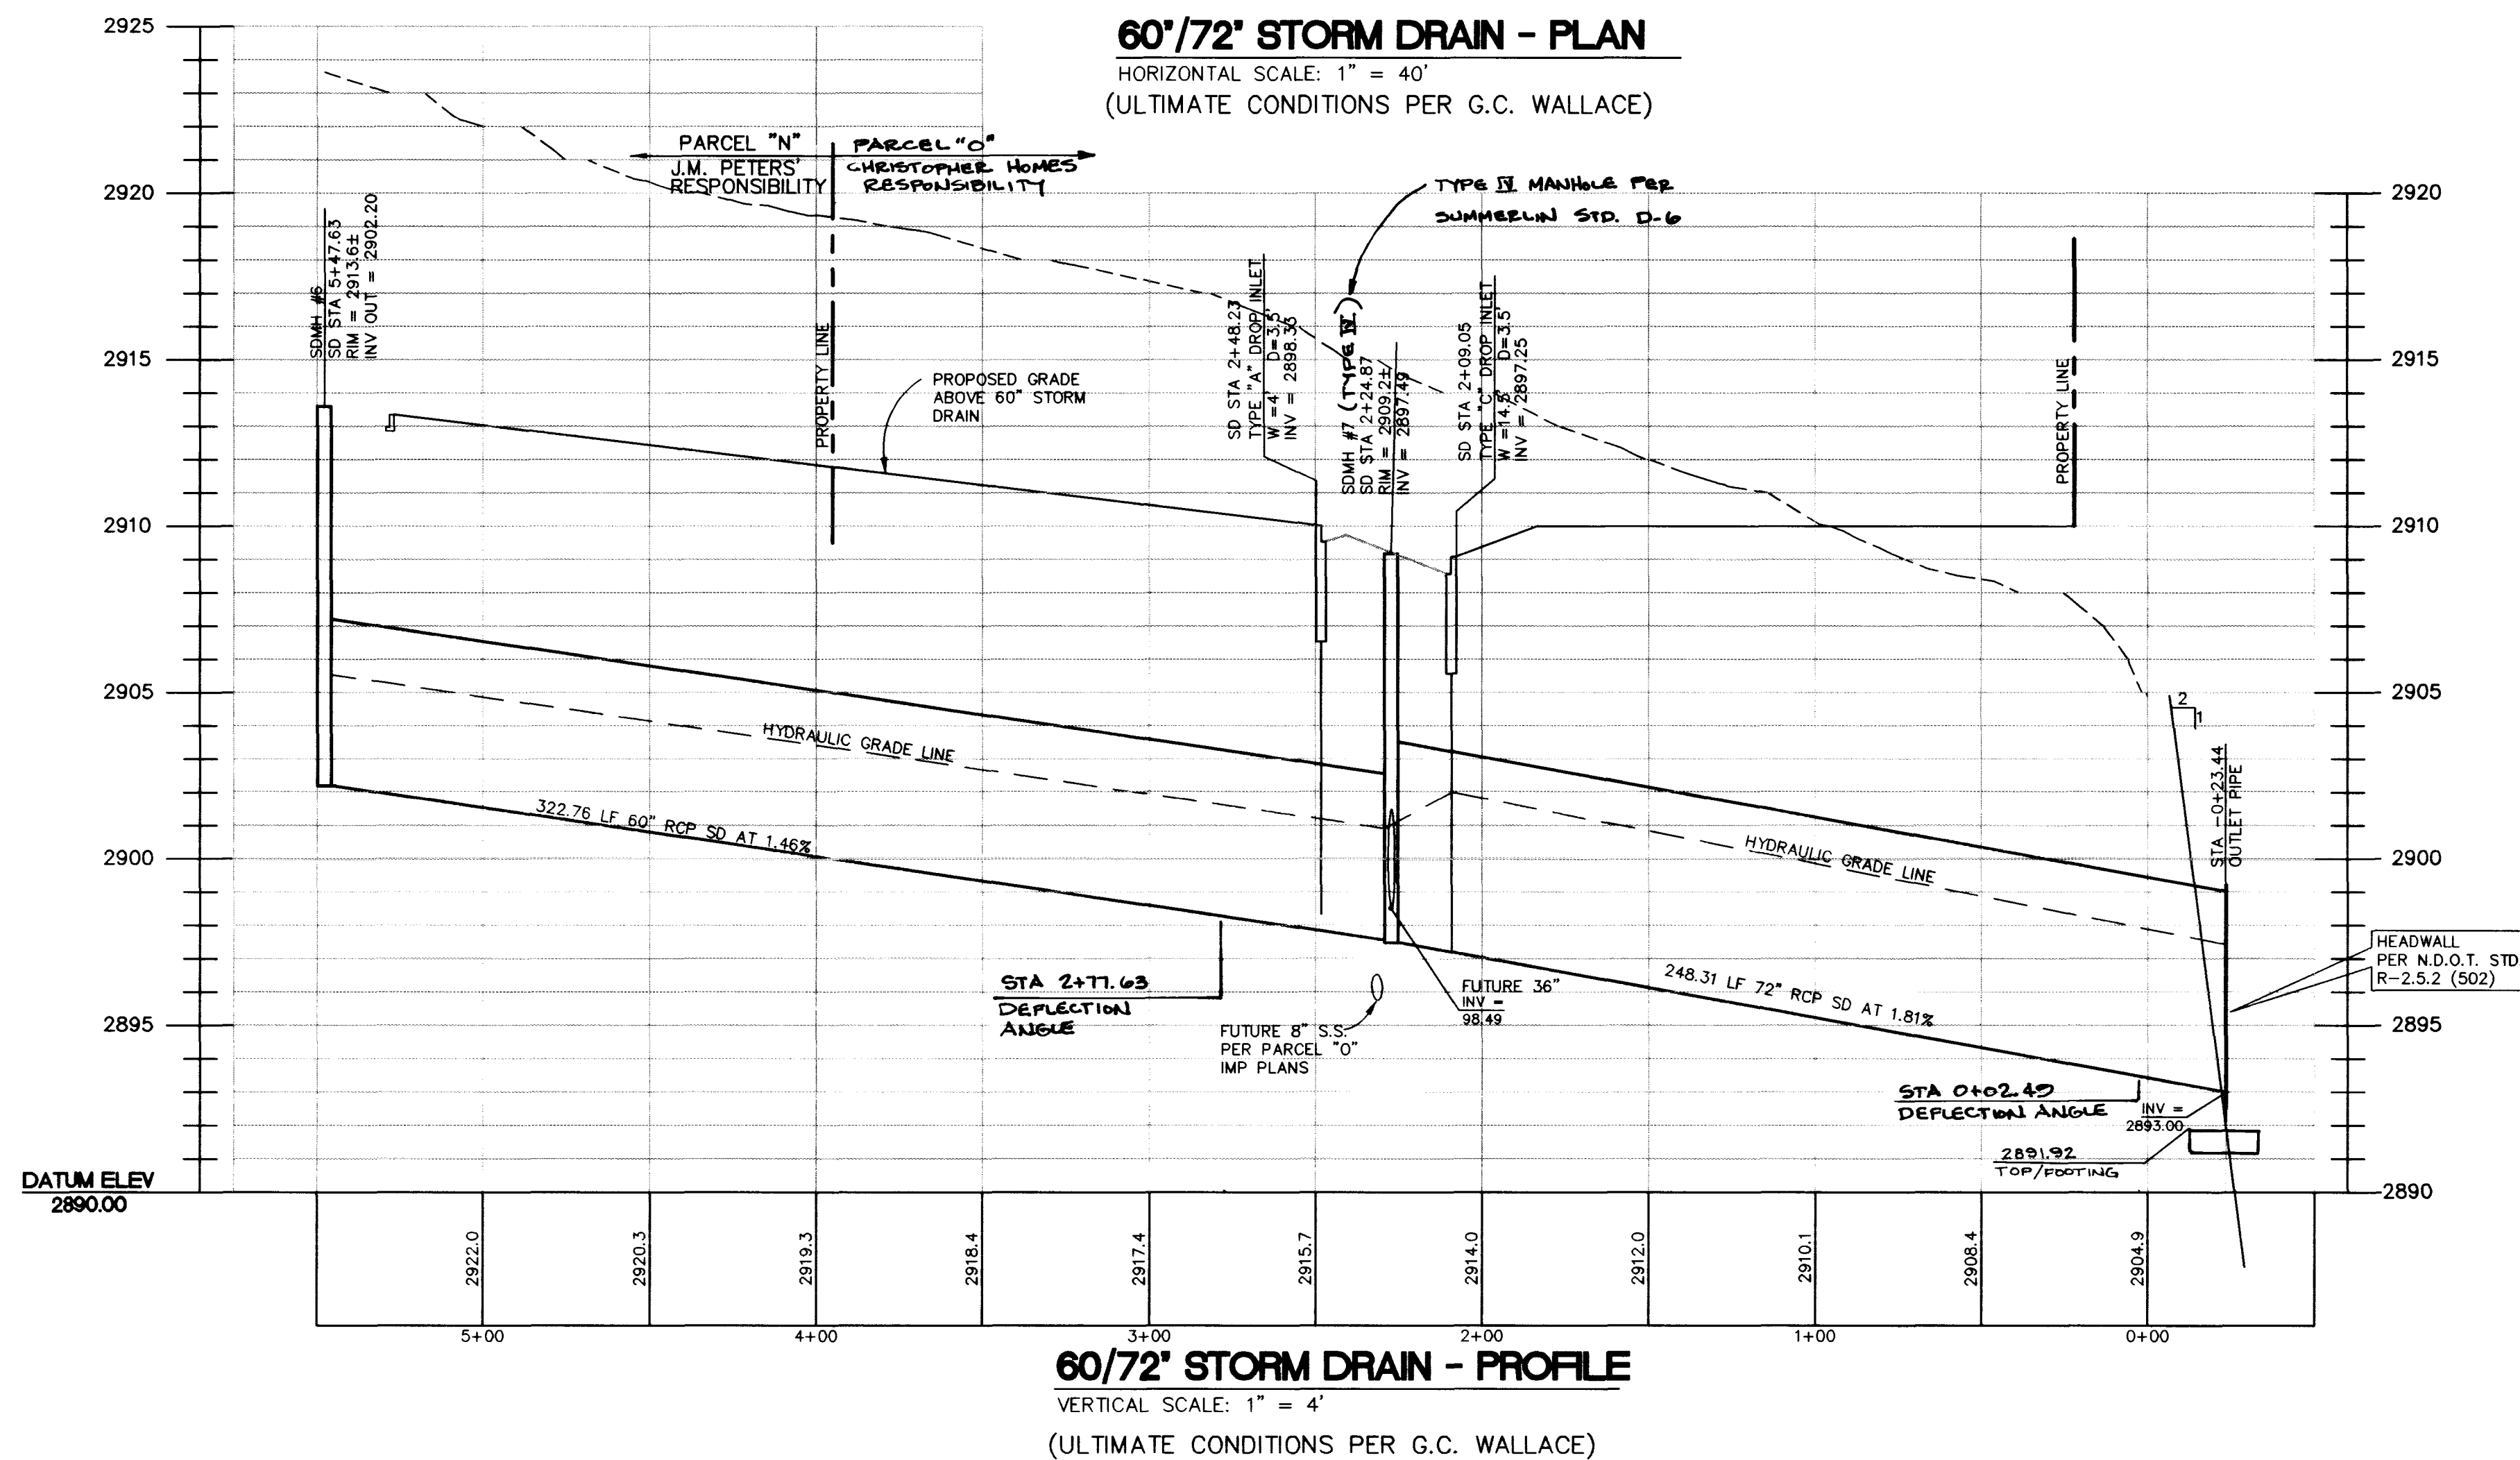
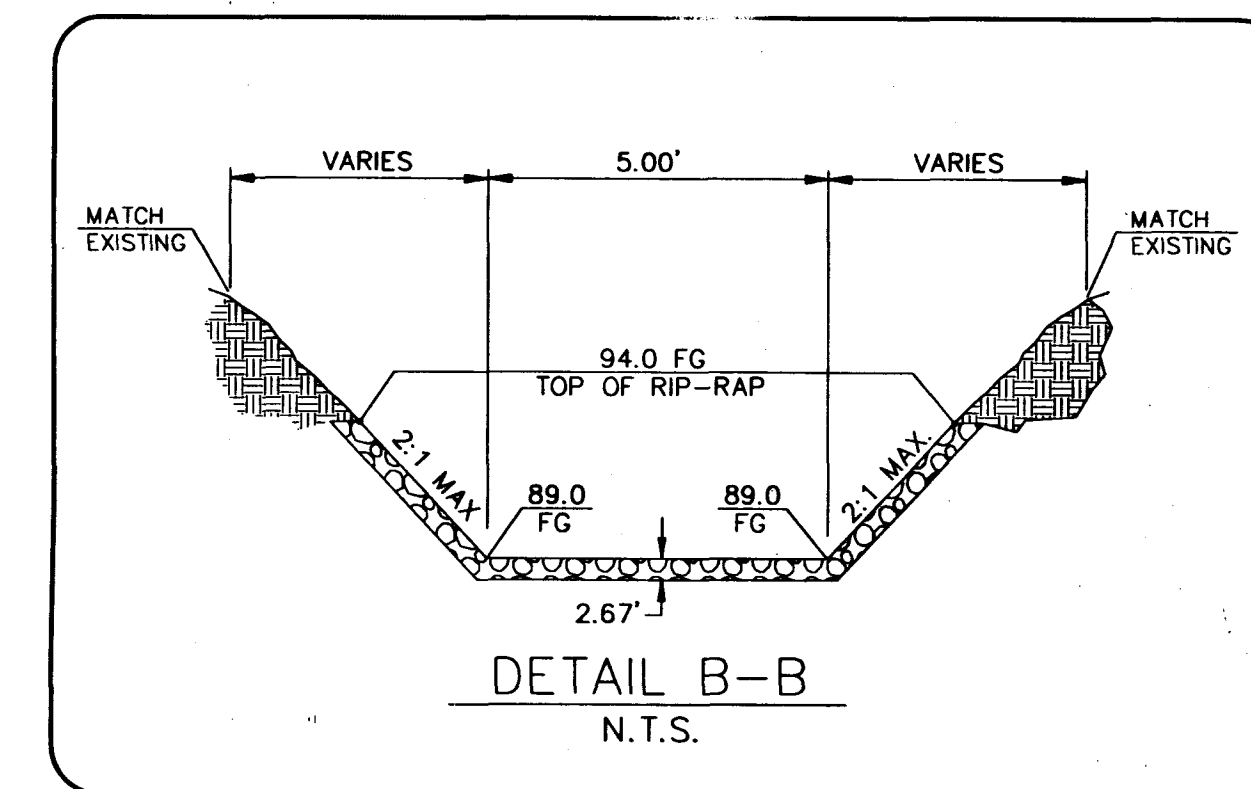
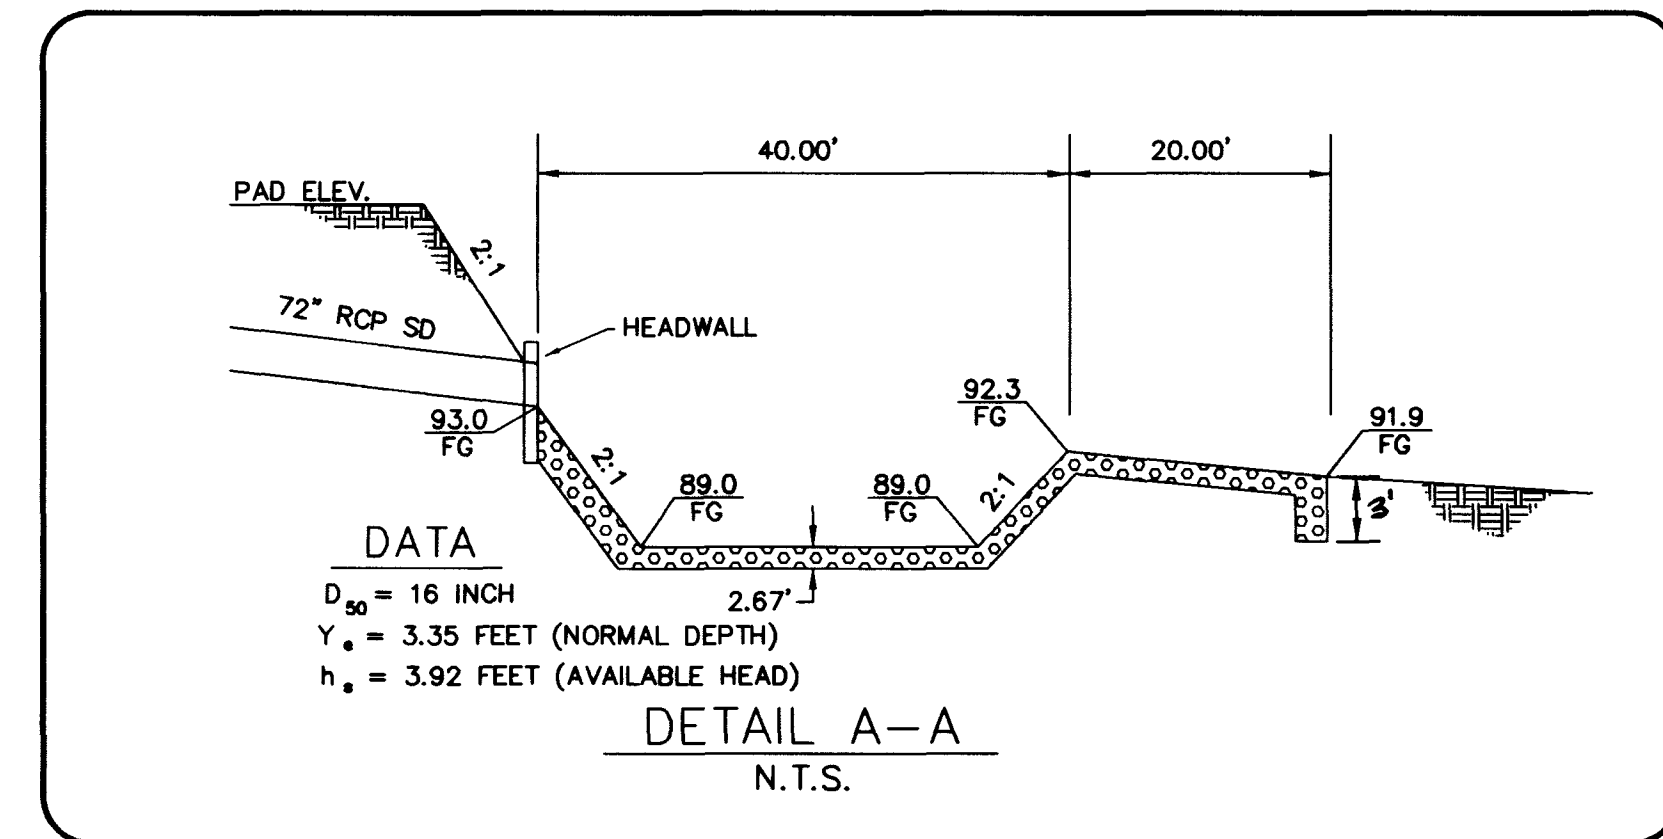


B761-09A Mon Mar 10 18:30:45 1997 PB55J - Ms. Lisa

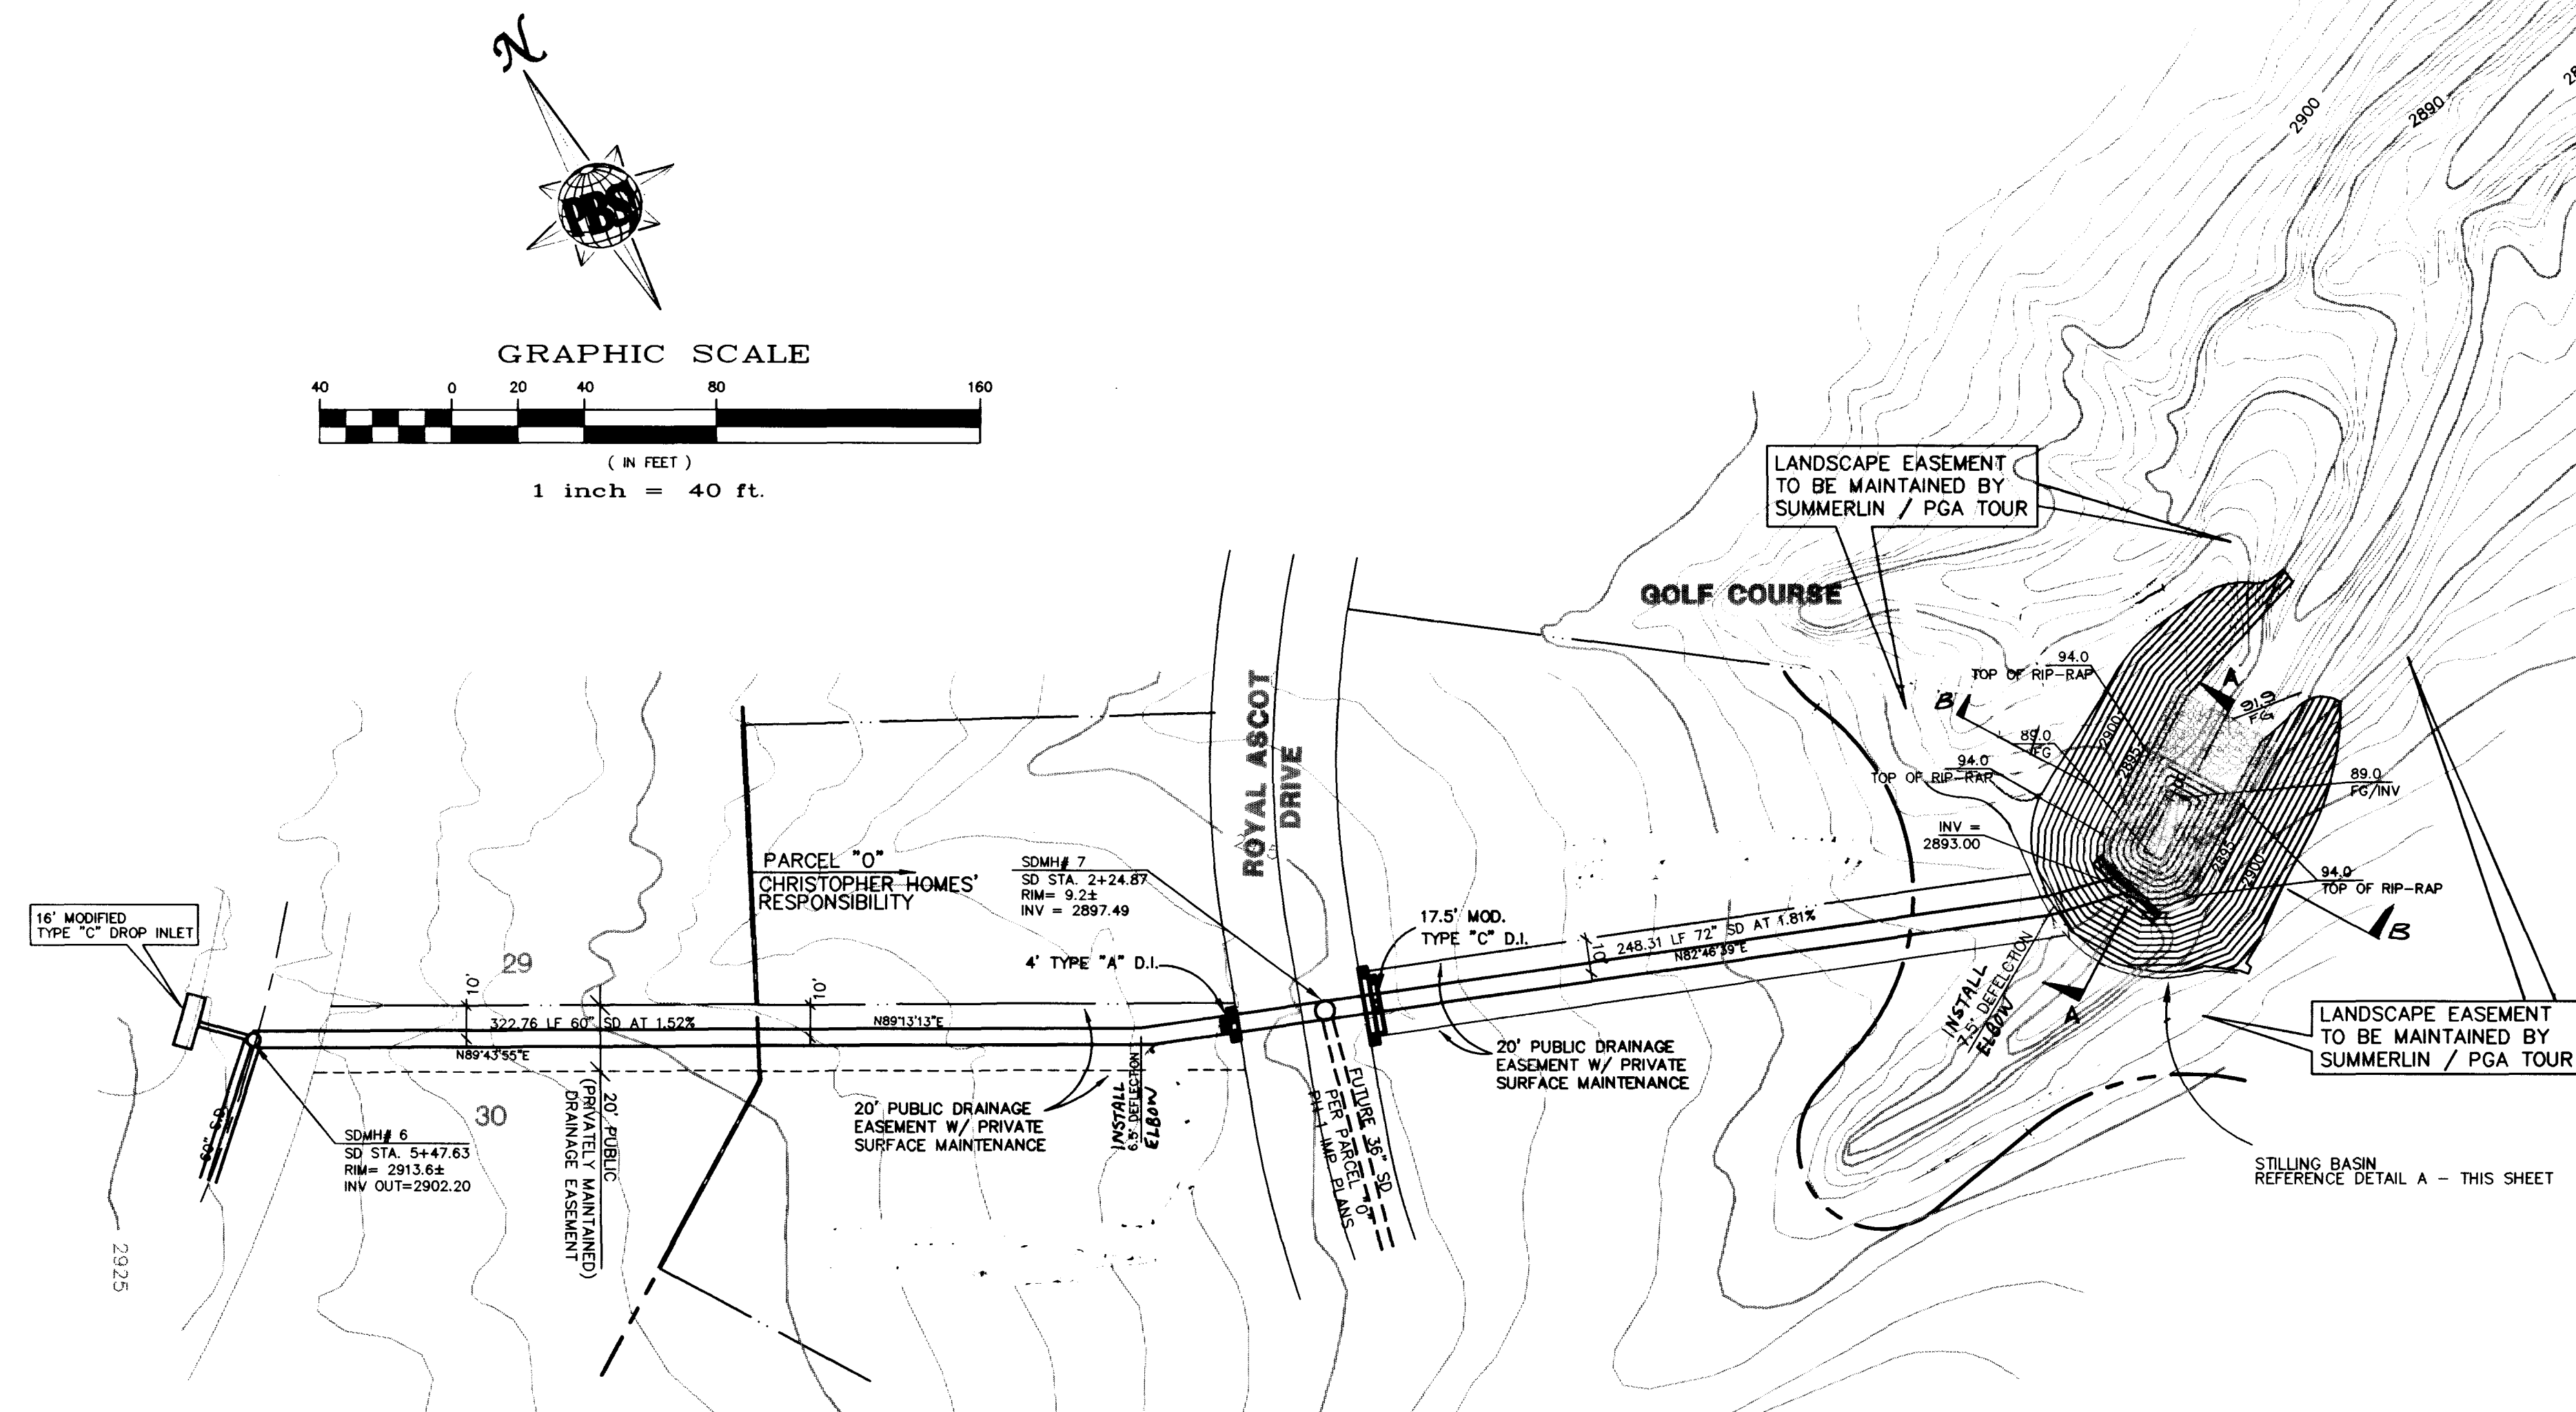

Call before you Dig
1-800-227-2600

Call before you Overhead
1-702-593-6111
NEVADA POWER ENVIRONMENT AND
SAFETY SERVICES DEPARTMENT

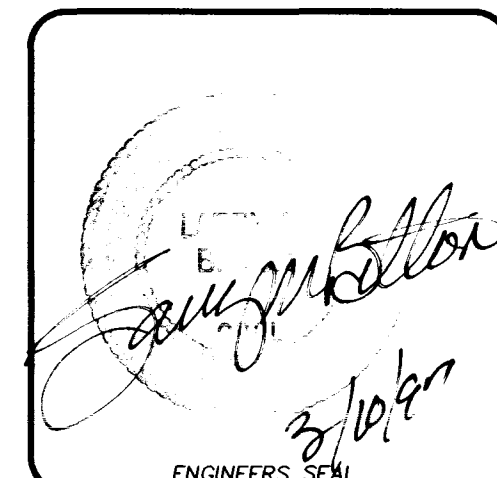

POST
BUCKLEY
SUNSHINE
JENNAN

901 N. Green Valley Parkway
Suite 100 Nevada 89104
Telephone 702/263-7275
Facsimile 702/263-7200

ENGINEERING - PLANNING - SURVEYING - CONSTRUCTION SERVICES

J.M. PETERS
NEVADA

OFFSITE (PARCEL O) 60/72 inch
STORM DRAIN PLAN AND PROFILE

Drawn by	Scale	AS SHOWN	File No.	8781MP
5878	1 inch = 40 feet	1 inch = 40 feet	1 inch = 40 feet	1 inch = 40 feet
Sheet Number	Date	File No.	File No.	File No.
9A OF 9	FEB 97	1 inch = 40 feet	1 inch = 40 feet	1 inch = 40 feet

PLAT DATE

327X-4492-1

