


FOR CONTINUATION SEE SHEET U2

VIEW NAME: T104

FILE NAME: 7149MP2.DWG

FOR CONTINUATION SEE SHEET U5

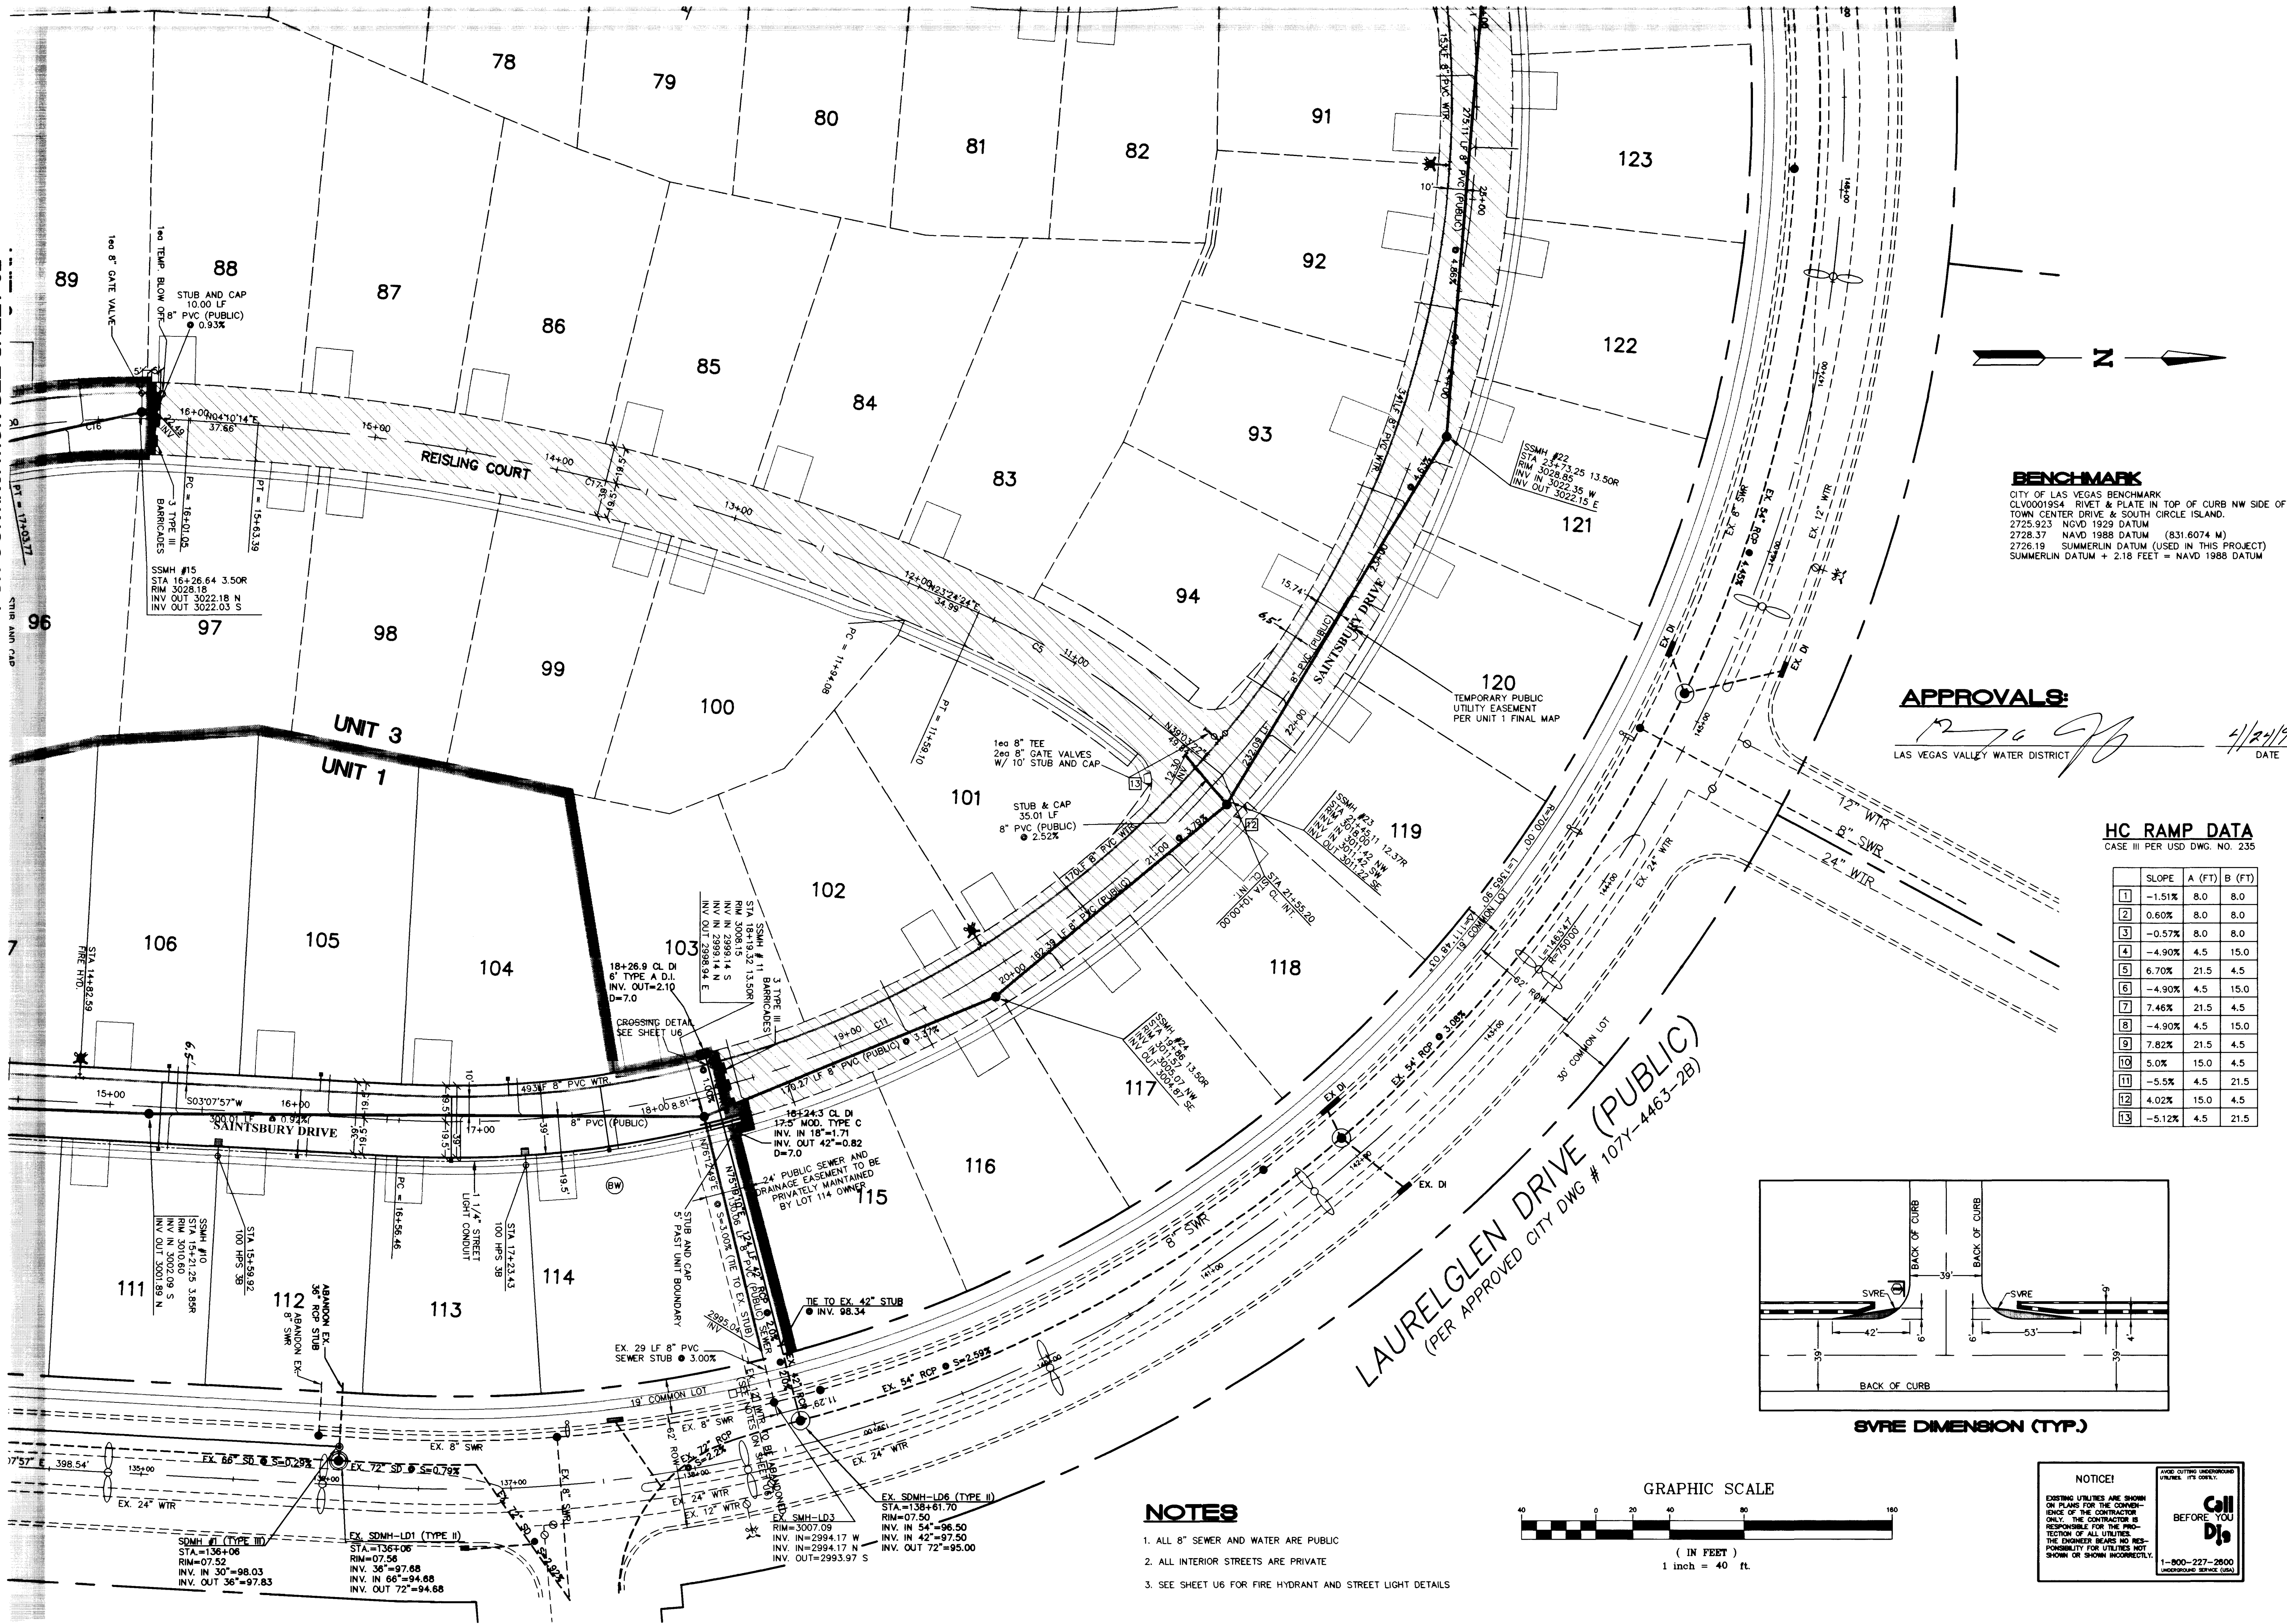


BENCHMARK
CITY OF LAS VEGAS BENCHMARK
CLV0001954: RIVET & PLATE IN TOP OF CURB NW SIDE OF
TOWN CENTER DRIVE & SOUTH CIRCLE ISLAND
2725.923 NGVD 1929 DATUM
2728.37 NAVD 1988 DATUM (831.6074 M)
2726.19 SUMMERLIN DATUM (USED IN THIS PROJECT)
SUMMERLIN DATUM + 2.18 FEET = NAVD 1988 DATUM

APPROVALS:

LAS VEGAS VALLEY WATER DISTRICT


HC RAMP DATA
CASE III PER USD DWG. NO. 235

	SLOPE	A (FT)	B (FT)
1	-1.51%	8.0	8.0
2	0.60%	8.0	8.0
3	-0.57%	8.0	8.0
4	-4.90%	4.5	15.0
5	6.70%	21.5	4.5
6	-4.90%	4.5	15.0
7	7.46%	21.5	4.5
8	-4.90%	4.5	15.0
9	7.82%	21.5	4.5
10	5.0%	15.0	4.5
11	-5.5%	4.5	21.5
12	4.02%	15.0	4.5
13	-5.12%	4.5	21.5

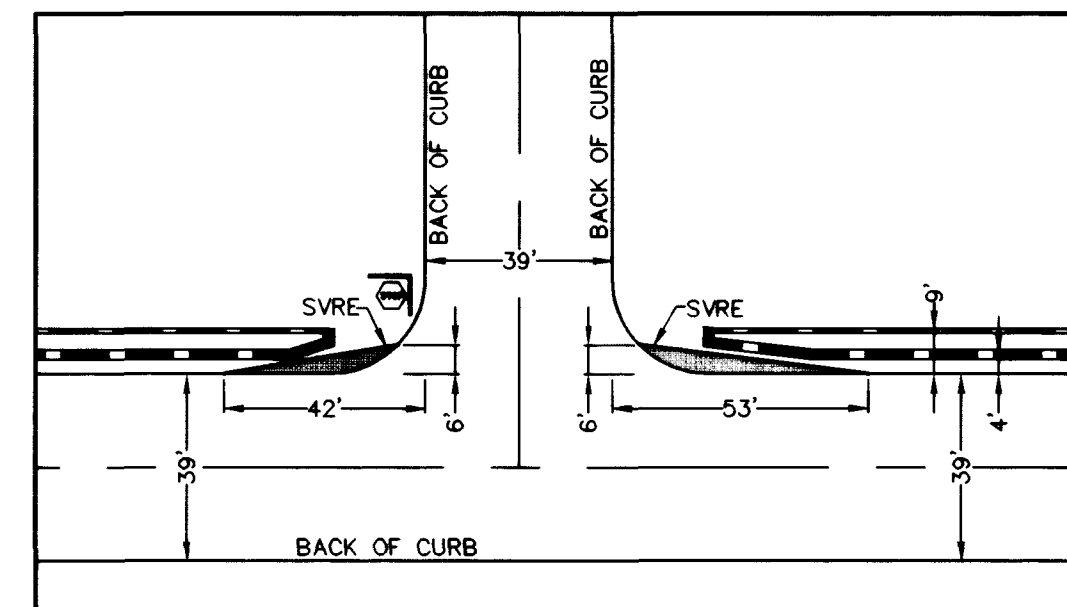

SVRE DIMENSION (TYP.)

GRAPHIC SCALE

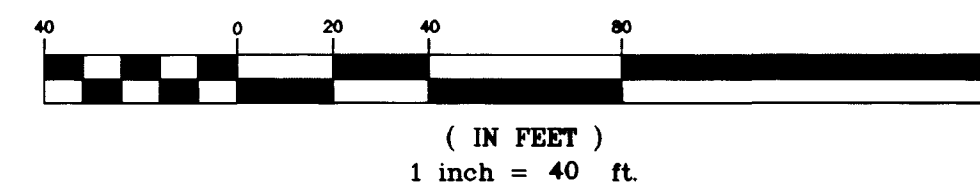

NOTES

- ALL 8" SEWER AND WATER ARE PUBLIC
- ALL INTERIOR STREETS ARE PRIVATE
- SEE SHEET U6 FOR FIRE HYDRANT AND STREET LIGHT DETAILS

ENGINEERING
COMPANY

50 So. Jones #202, Las Vegas, NV, 89107
Telephone: (702) 677-1300

ALPHA &

CHRISTOPHER HOMES

9500 HILLWOOD DRIVE
LAS VEGAS, NEVADA 89134
(702) 360-3200

**UTILITY PLAN
SOUTHEAST**

**VINEYARDS UNIT 1
THE ARBORS @ SUMMERLIN**


DRAWN BY: 2-17-98

DESIGNED BY: 2-17-98

CHECKED BY: 2-17-98

PROJECT NO: 714905

SCALE:
1"=40'

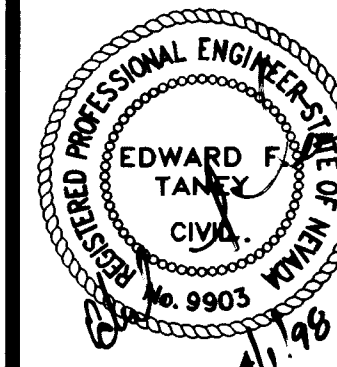

SHEET

U4

11 OF 20 SHEETS

DRAWING NO.

307Y-45461

