



FOR CONTINUATION SEE SHEET U5

FOR CONTINUATION SEE SHEET U2

FILE NAME: 7149IMP2.DWG

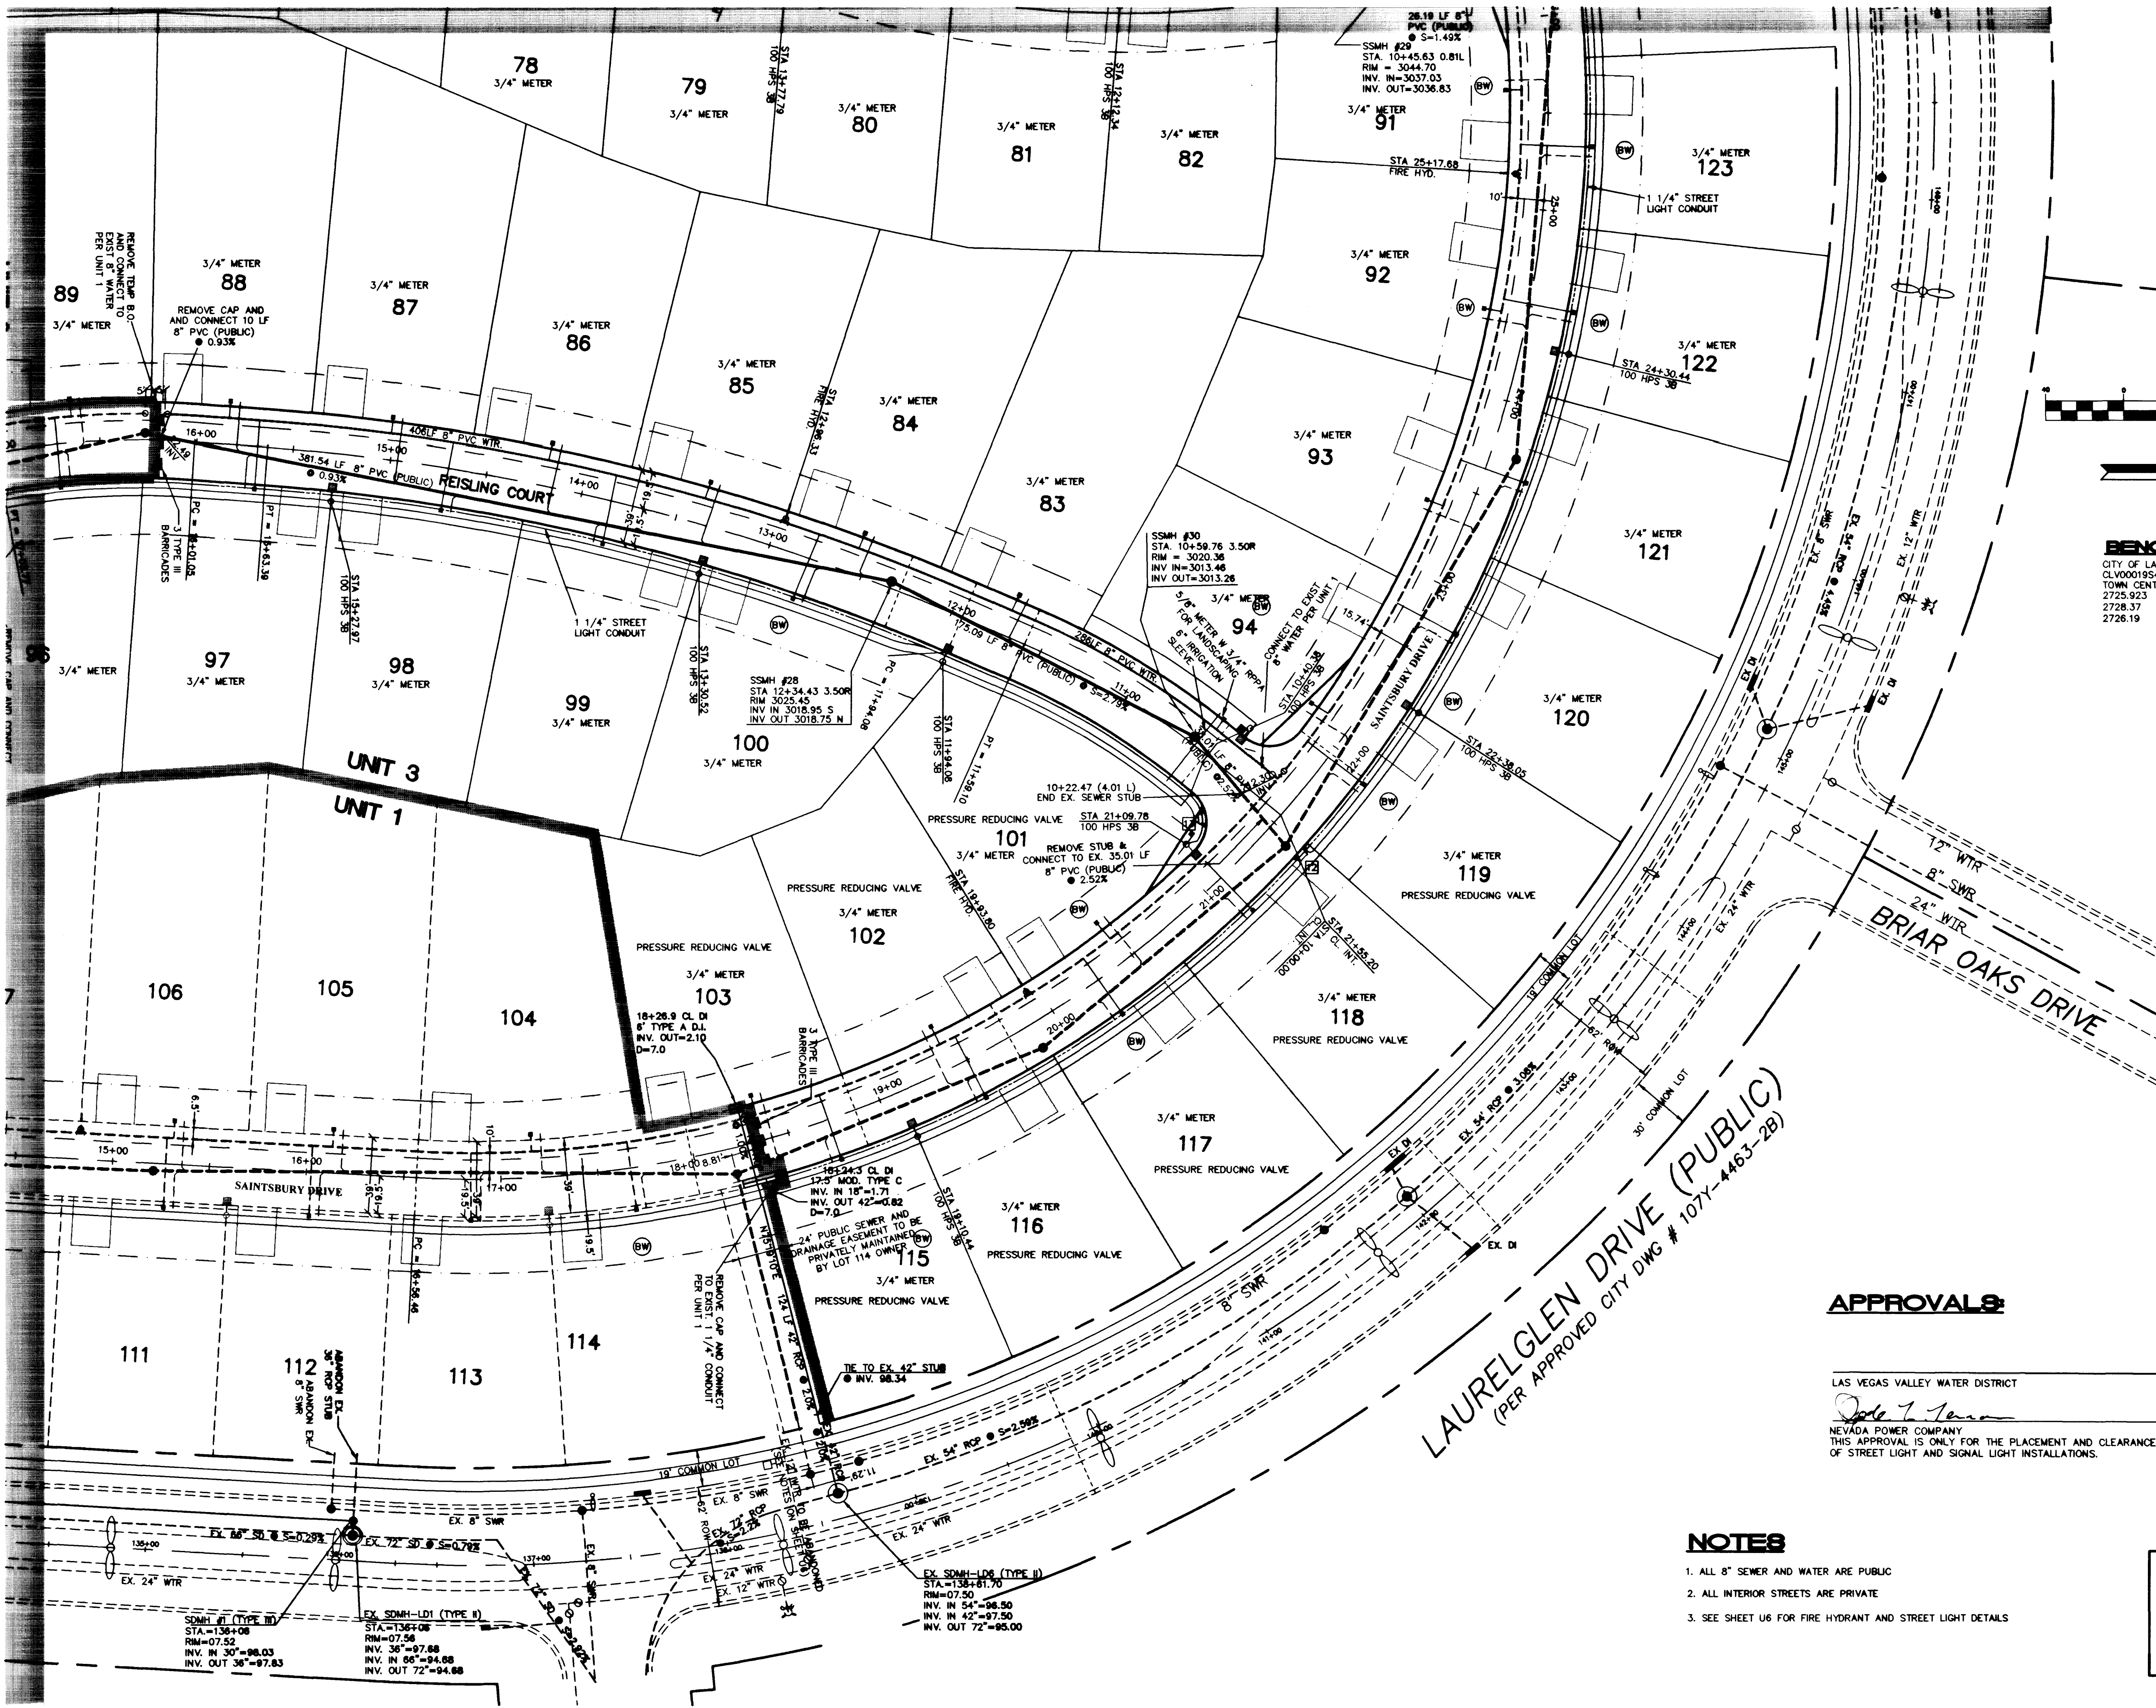

SERVICE LATERALS FOR LOTS 94 THROUGH 103, AND 115 THROUGH 138 WILL BE TAPPED ON EXISTING MAIN BY OWNER'S CONTRACTOR, UNDER DIRECTION OF THE LAS VEGAS VALLEY WATER DISTRICT.

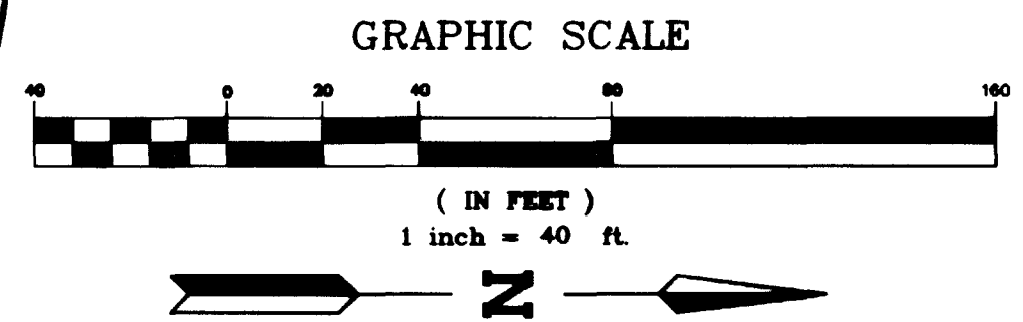

BENCHMARK
CITY OF LAS VEGAS BENCHMARK
CLV0001954 RIVET & PLATE IN TOP OF CURB NW SIDE OF TOWN CENTER DRIVE & SOUTH CIRCLE ISLAND.
2725.923 NAVD 1929 DATUM
2728.37 NAVD 1988 DATUM (831.6074 M)
2726.19 SUMMERLIN DATUM (USED IN THIS PROJECT)

HC RAMP DATA
CASE III PER USDW. NO. 235

	SLOPE	A (FT)	B (FT)
1	-1.51%	8.0	8.0
2	0.60%	8.0	8.0
3	-0.57%	8.0	8.0
4	-4.90%	4.5	15.0
5	6.70%	21.5	4.5
6	-4.90%	4.5	15.0
7	7.46%	21.5	4.5
8	-4.90%	4.5	15.0
9	7.82%	21.5	4.5
10	5.0%	15.0	4.5
11	-5.5%	4.5	21.5
12	4.02%	15.0	4.5
13	-5.12%	4.5	21.5

APPROVALS

LAS VEGAS VALLEY WATER DISTRICT
[Signature] DATE 7/14/98
NEVADA POWER COMPANY
THIS APPROVAL IS ONLY FOR THE PLACEMENT AND CLEARANCE OF STREET LIGHT AND SIGNAL LIGHT INSTALLATIONS.

NOTES

- ALL 8" SEWER AND WATER ARE PUBLIC
- ALL INTERIOR STREETS ARE PRIVATE
- SEE SHEET U6 FOR FIRE HYDRANT AND STREET LIGHT DETAILS

NOTICE!

EXISTING UTILITIES ARE SHOWN ON PLANS FOR THE CONSIDERANCE OF THE CONTRACTOR. THE CONTRACTOR IS RESPONSIBLE FOR THE PROTECTION OF ALL UTILITIES. THE ENGINEER BEARS NO RESPONSIBILITY FOR UTILITIES NOT SHOWN OR SHOWN INCORRECTLY.

BEFORE YOU DIG

1-800-227-2600

ENGINEERING COMPANY		50 So. Jones #202, Las Vegas, NV, 89107 Telephone: (702) 877-1300	
ALPHA &		CHRISTOPHER HOMES	
UTILITY PLAN SOUTHEAST		VINEYARDS UNIT 3 THE ARBORS @ SUMMERLIN	
DRAWN BY: EET	7.7.98	DESIGNED BY: RCY	7.7.98
CHECKED BY:	7.7.98	PROJECT NO:	714905
SCALE: 1"=40'		SHEET U4	
11 OF 15 SHEETS		DRAWING NO. 3074-4546-3	

