


FOR CONTINUATION SEE SHEET U5

FOR CONTINUATION SEE SHEET U2

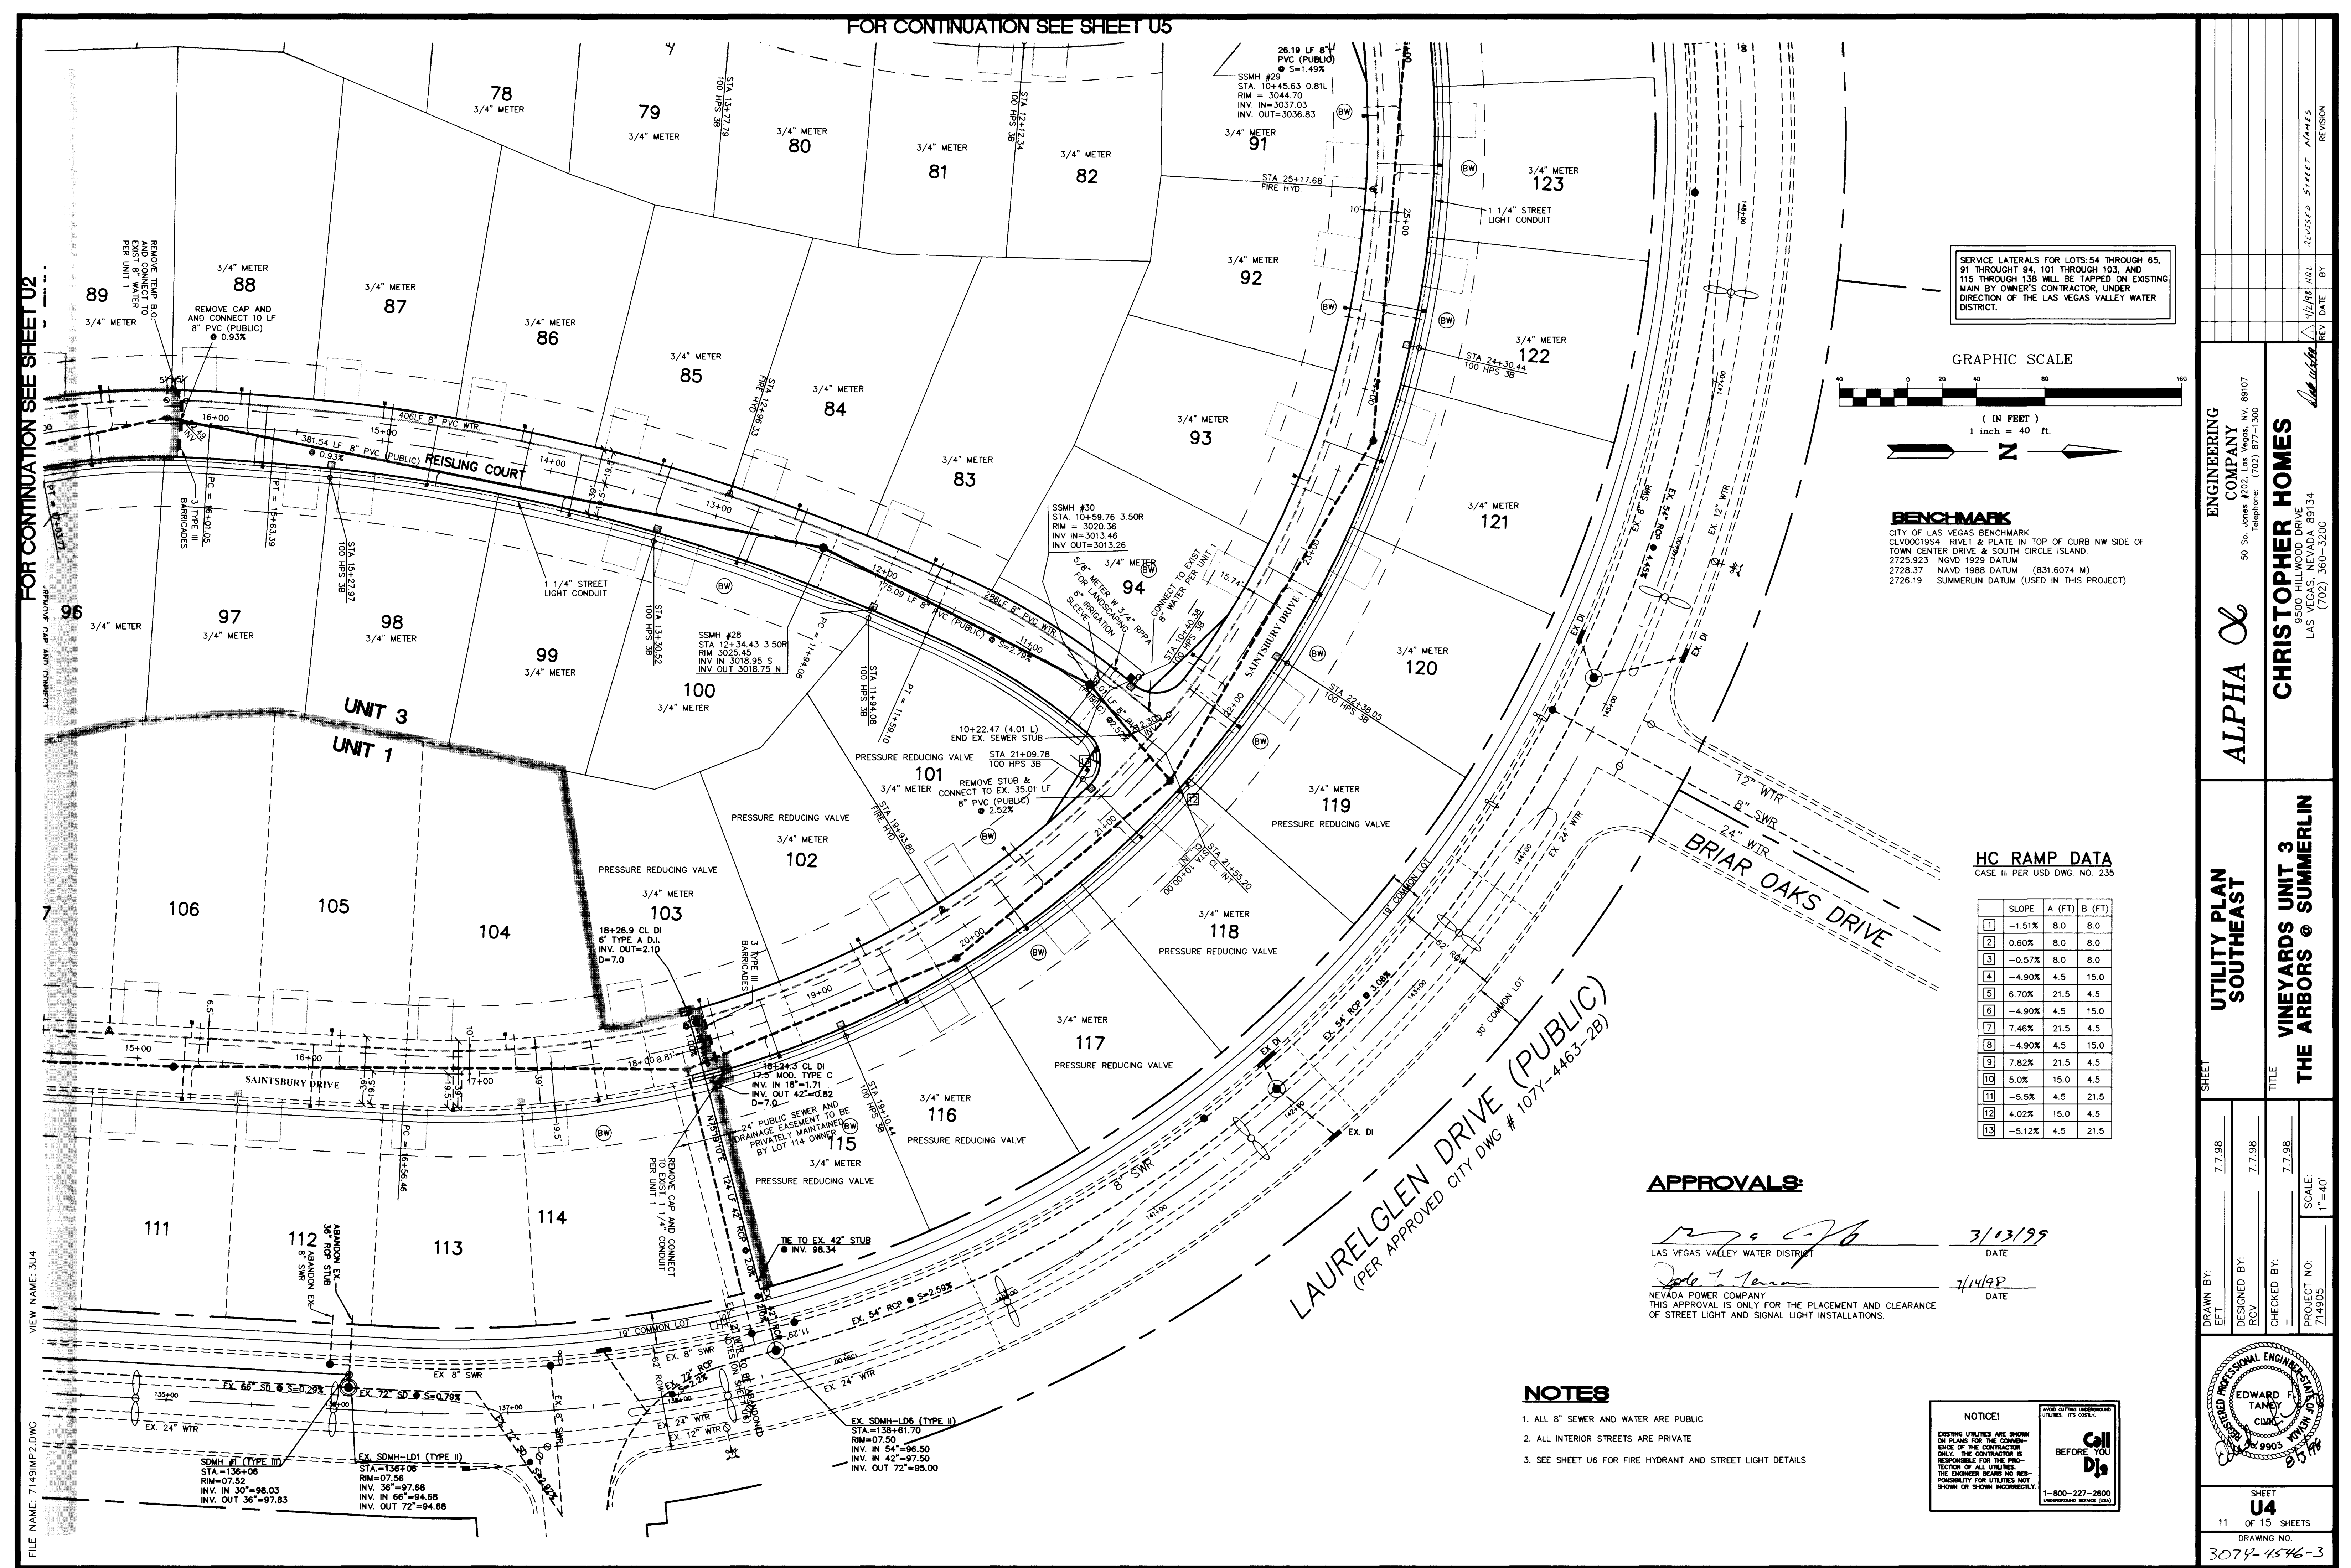

ENGINEERING COMPANY
50 So. Jones #202, Las Vegas, NV 89107
Telephone: (702) 877-1300

ALPHA

UTILITY PLAN
SOUTHEAST

CHRISTOPHER HOMES
9500 HILLWOOD DRIVE
LAS VEGAS, NEVADA 89134
(702) 360-3200

VINEYARDS UNIT 3
THE ARBORS @ SUMMERLIN

DRAWN BY: 7.7.98

DESIGNED BY: 7.7.98

CHECKED BY: 7.7.98

PROJECT NO: 714905

SCALE: 1"=40'

SHEET
U4
11 OF 15 SHEETS
DRAWING NO.
3074-4546-3

