


PANEL 'L1' SCHEDULE											
50 AMPS/42 CIRCUIT CAPACITY, SURFACE MOUNTED PANEL 120/208V, 3PH, 4W, 60 HZ MIN. INTERRUPTING RATING 10,000 RMS							TYPE: ITE NLAB OR EQUAL				
POLE	AMP TRIP	NO. POLES	WIRE & CONDUIT	REC.	LTS.	MISC.	LOAD SERVED	LOAD (VA)			
								A	B	C	
1	20	1	2#12/2C			1	LIGHTING CONTACTOR, SEE E-1	1440			
2	20	1	2#12/2C		12		GEN. LIGHTING	770			
3	20	1	2#12/2C			1	CONTACTOR TIMER, SEE E-1		500		
4	20	1	2#12/2C				SPARE				
5	30	1	2#10/2C	1			HAND DRYER			2300	
6	20	1	2#12/2C			2	BF-1 & BF-2			960	
7	30	1	2#10/2C			1	HAND DRYER	2300			
8	20	1	2#12/2C		16		OUTDOOR CLG. LTS.	86			
9	20	1	2#12/2C		4		EXT/EMERGENCY		144		
10	20	1	2#12/2C		6		OUTDOOR WALL MTD. LTS.		366		
11	20	1	2#12/2C	8			C.O.			1800	
12	20	1	2#12/2C				SPARE				
13	75	3	4#14/2C				SUB-PANEL L2	320			
14											
15										320	
16											
17											320
18											
19											
20											
21											
22											
23											
24											
25											
26											
27											
28											
29											
30											
31											
32											
33											
34											
35											
36											
37											
38											
39											
40											
41											
42											
WATTS/PHASE								8446	4130	9880	
TOTAL CONNECTED LOAD +25% LCL								28520			
LOAD AMPS @ 120/208 VOLTS								60.6 AMPS			

PANEL 'L2' SCHEDULE										
75 AMPS/30 CIRCUIT CAPACITY, SURFACE MOUNTED PANEL 120/208V, 3PH, 4W, 60 HZ MIN. INTERRUPTING RATING 10,000 RMS							TYPE ITE NLAB OR EQUAL			
POLE	AMP TRIP	NO. POLES	WIRE & CONDUIT	REC.	LTS.	MISC.	LOAD SERVED	LOAD (VA)		
								A	B	C
1	20	1	2#12/2C			1	BF-3 & ROOF C.O. W/PAGE	300		
2	30	1	2#10/2C			1	ICE MAKER	300		
3		1	2#12/2C		12		GEN. LIGHTING		160	
4	20	1	2#12/2C	8			C.O.		1080	
5	20	1	2#12/2C	8			C.O.			1260
6	20	1	2#12/2C		1		EXT/EMERGENCY			300
7							SPARE			
8							SPARE			
9	20	1	2#12/2C	8			C.O.			1440
10							SPARE			
11										
12										
13										
14										
15										
16										
17										
18										
19										
20										
21										
22										
23										
24										
25										
26										
27										
28										
29										
30										
WATTS/PHASE								3400	240	3000
TOTAL CONNECTED LOAD +25% LCL								9340		
LOAD AMPS @ 120/208 VOLTS								26.0 AMPS		

LIGHT FIXTURE SCHEDULE				
MARK		MANUFACTURER & MODEL NO.	LAMP	REMARKS
A	☒	KENALL MOD. #37748-120V-25-EL FOR DAMP LOCATION	4 F03278	(3) FIXTURES / BATTERY EMERGENCY LIGHTING PACK
B	☒	KENALL MOD. #3785-120V-	1 F03278	
C	☒	KENALL MOD. #2530-70 84 14 4-1/2 FOR WET LOCATION, VANDAL PROOF, CLG. MTD.	1 70 HPS	
D	☒	KENALL MOD. #2430-38 84 14 3-1/4 LIGHT FIXTURE FOR WET LOCATION, VANDAL PROOF	1 38W/20 120V-A-P-F	SWITCH THRU PHOTO CELL / BY-PASS SWITCH
E	☐	KENALL MOD. #230-50W-HPS, 120V-NP VANDALL PROOF WALL MOUNTED	1 50 HPS	SWITCH THRU PHOTO CELL / BY-PASS SWITCH
F	EXIT	KENALL MOD. #6504-120V-EL-W WITH BATTERY PACK	INCLUDED	COMPLETE / BATTERY SYSTEM FOR EMERGENCY
G	☐	KENALL MOD. #230-35W-HPS, 120V-NP VANDALL PROOF WALL MOUNTED	1 35 HPS	SWITCH THRU PHOTO CELL / BY-PASS SWITCH

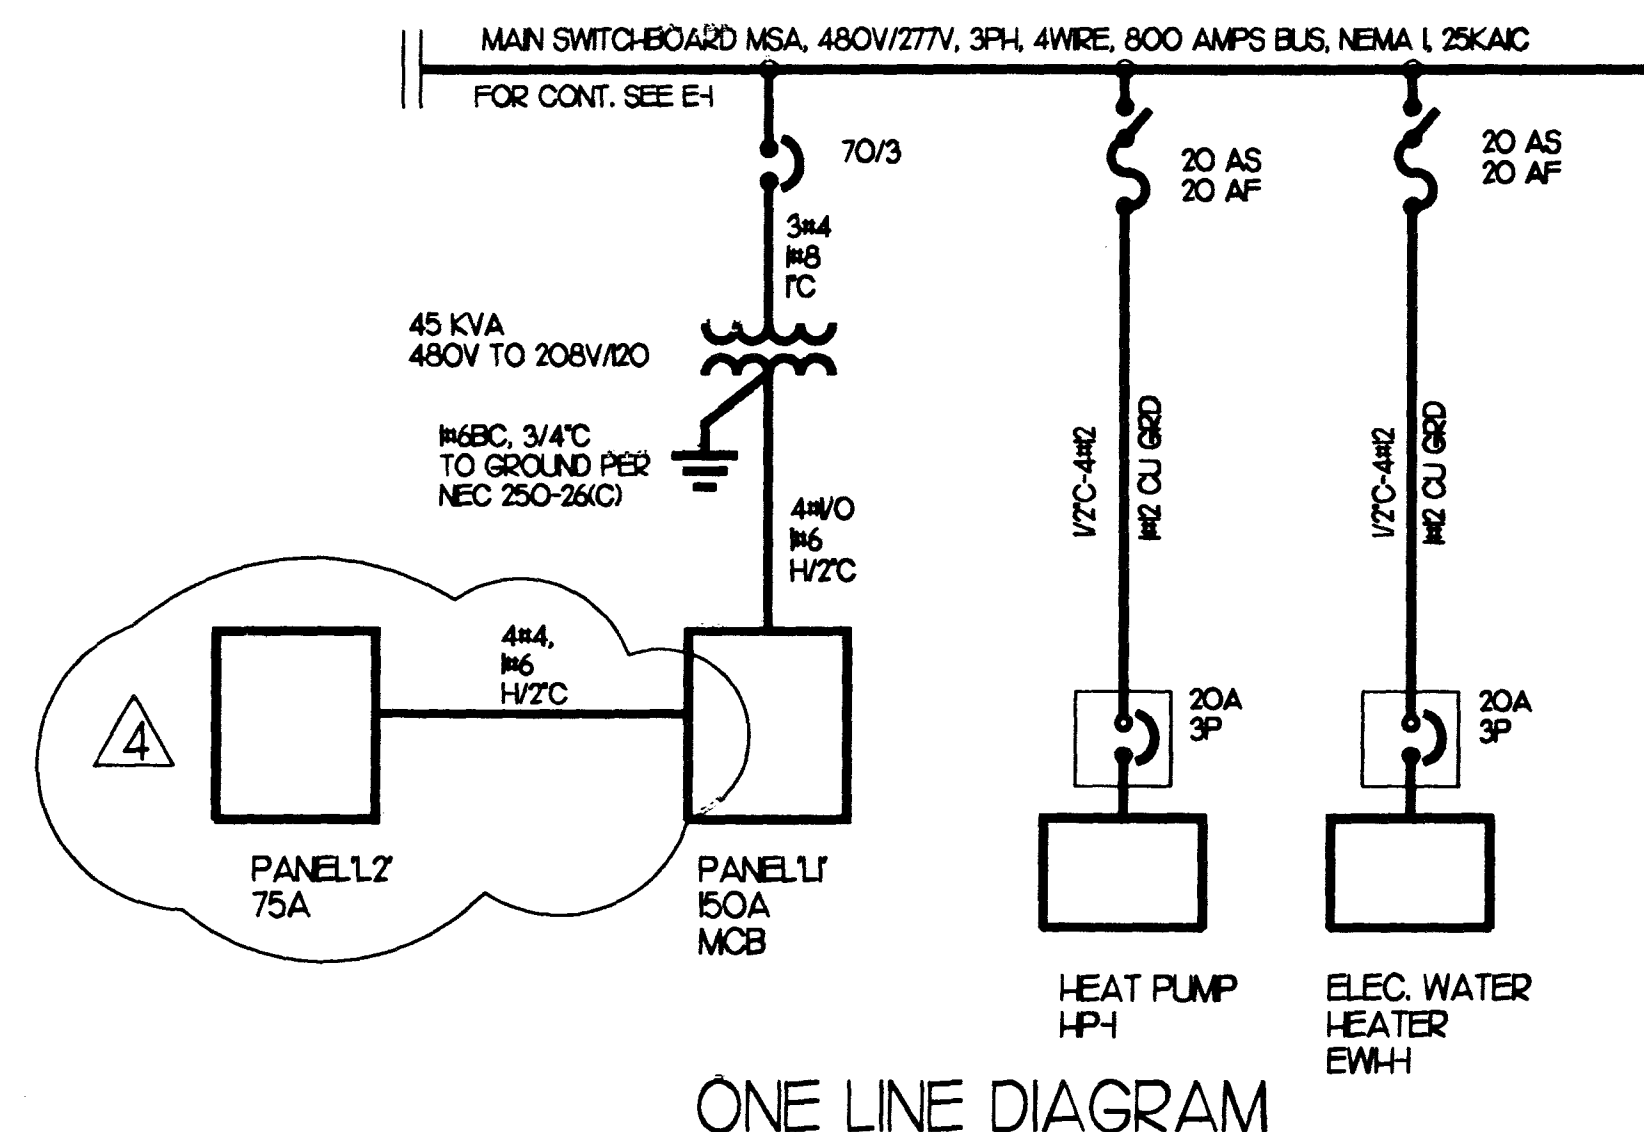

GENERAL ELECTRICAL NOTES

- ALL EQUIPMENT SHALL BE INSTALLED ACCORDANCE WITH APPLICABLE CODE AND MANUFACTURER RECOMMENDATION. THE CONTRACTOR SHALL VERIFY ALL DIMENSIONS WITH THE ARCHITECT AND OWNER PRIOR TO CONSTRUCTION.
- ALL WORK SHALL BE PERFORMED IN ACCORDANCE WITH THE 1993 NEC, ALL STATES AND LOCAL CODES, ORDINANCES AND MODEL ENERGY CODE.
- WIRING #10 OR SMALLER TO BE TYPE THW OR THHN. WIRING #8 OR LARGER TO BE TYPE THN OR THWN. ALL CONDUCTORS TO BE COPPER.
- PANEL BOARD SHALL BE AS MANUFACTURED BY SQUARE D, ITE, GE OR EQUAL.
- ALL DISCONNECT SWITCH SHALL BE RATED FOR GENERAL DUTY UON.
- STARTERS AND RELATED WIRING IF REQUIRED FOR AC UNIT SHALL BE INSTALLED BY ELECTRICAL CONTRACTOR. OVERLOAD UNITS SHALL BE INSTALLED AS PER GIVEN NAME PLATE DATA ON EQUIPMENT.
- ANY FEES ASSOCIATED WITH THE CONSTRUCTION AND INSPECTION SHALL BE BORNE BY CONTRACTOR IN ORDER TO DELIVER TO THE OWNER A FINISHED BUILDING READY FOR OCCUPANCY AND 100% OPERATION.
- METER AND PANEL BOARD SHALL BE LABELED WITH RESPECT TO THEIR TITLE, VOLTAGE, AND PHASE, IE, 120/208 VOLTS, 3 PHASE, 4 WIRES OR 277/480 VOLTS, 3-PHASE, 4 WIRES. LABELS SHALL BE PHENOLIC PLASTIC WITH WHITE LETTERS AND BLACK BACKGROUND. LABELS SHALL BE PERMANENTLY AFFIXED TO EQUIPMENT.
- PANEL BOARDS SHALL CONTAIN A TYPE WRITTEN DIRECTORY WITH PLASTIC COVER AFFIXED TO THE INSIDE DOOR.
- CONTRACTOR SHALL SUBMIT 4 COPIES OF SHOP DWG AND SUBMITTALS TO THE OWNER FOR APPROVAL BEFORE ORDERING THE MATERIALS.
- ANY COST INCURRED DUE TO LACK OF COORDINATION AMONG TRADES SHALL BE BORNE BY THE CONTRACTOR.
- TRADES NAMES ARE GIVEN TO CLARIFY TYPE OF PRODUCT AND QUALITY DESIRED. SUBSTITUTION MAY BE MADE PENDING APPROVAL OF THE A/E UNLESS OTHERWISE NOTED.
- CONTRACTOR SHALL VERIFY SERVICE VOLTAGE FROM UTILITY COMPANY AND BALANCE PANEL AS REQUIRED.
- ALL REMOTE EQUIPMENT IN REMOTE AREAS SHALL HAVE DISCONNECT SWITCH AT EACH PIECE OF EQUIPMENT.
- REFER TO MECHANICAL DWGS. FOR THE LOCATION OF THERMOSTAT, UNITS, AND OTHER SPECIAL EQUIPMENT. CONTRACTOR IS RESPONSIBLE FOR THE INSTALLATION OF ALL CONDUITS, JUNCTION BOXES, AND DISCONNECT SWITCHES FOR MECHANICAL EQUIPMENT AND FIRE AND SMOKE ALARM CONTROL PANEL. COORDINATE WITH FIRE ALARM CONTRACTOR.
- ALL EQUIPMENT SHALL BE LISTED AND LABELED BY A NATIONALLY RECOGNIZED TESTING LABORATORY AND SHALL BE INSTALLED AS PER LABELLING. (FOR EXAMPLE: MAXIMUM FUSE SIZE MEANS FUSE PROTECTION REQUIRED)
- NO OUTLET BOX SHALL EXCEED 15" AFF, EXCEPT ABOVE COUNTER AND OTHERWISE NOTED. JUNCTION BOXES SHALL BE INSTALLED FOR ALL TELEPHONE AND THERMOSTAT OUTLETS, PLASTER RINGS, OPEN BACK BOXES OR MOUNTING PLATES ONLY SHALL NOT BE PERMITTED UNLESS SPECIFICALLY ALLOWED BY THE REGULATING AGENCY.
- COORDINATE AND INCLUDE THE WIRING OF TELEPHONE OUTLETS AND SERVICE. PROVIDE GROUND WIRE AND GROUNDING PER TELEPHONE CO. REQUIREMENTS.
- THE CONTRACTOR SHALL BE HELD FULLY RESPONSIBLE FOR THE PROPER RESTORATION OF ALL SURFACES REQUIRING PATCHING, PLASTERING, PAINTING AND/OR OTHER REPAIRS DUE TO THE INSTALLATION OF ELECTRICAL WORK UNDER THE TERMS OF THIS SPECIFICATION. CLOSE ALL OPENINGS, REPAIR ALL SURFACES, ETC., AS REQUIRED.
- ALL WIRING SHALL BE RUN IN CONDUIT OR MI OR MC CABLE (PER CITY ELEC CODE ORDINANCE #3854 SECTION 23C).

DATE

10/18/97

REVISIONS

BUILDING ELECTRICAL REVISION

1

BUILDING ELECTRICAL REVISION

1

ARCHITECTURAL SERVICES

DESIGNED BY: A.C.

DRAWN BY: J.L.

DATE: 9-5-97

W.A. #

FLD. BK.

PLOT SCALE: NONE

DEPARTMENT OF PUBLIC WORKS

PROJECT

Rainbow Park Toilet Building

SHEET TITLE

SYMBOLS SCHEDULES NOTES & DIAGRAM

SHEET

36

650.30-7

DWGNO

32


12-128

6. STRENGTH AND STIFFNESS OF THE BRIDGE

[illegible][illegible]

Source: U.S. Census Bureau, *Marriage, Divorce, Remarriage in the 1990s*, Current Population Reports, 1995, Table 10.

REVENUE	100	100	100
EXPENSES	100	100	100
NET INCOME	100	100	100

 

1. ALL REQUESTS SHALL BE REVIEWED ACCORDING WITH FOLLOWING SCS
POLICY: www.scs.edu/policies

© 2004 by The McGraw-Hill Companies, Inc. All rights reserved. No part of this publication may be reproduced, stored in a retrieval system, or transmitted, in any form or by any means, electronic, mechanical, photocopying, recording, or by any information storage or retrieval system, without prior written permission from The McGraw-Hill Companies, Inc.

**6. AL. INFORMATION OFFICE SHALL MAINTAIN THE CONFIDENTIALITY AND
A RECORD OF ALL INFORMATION RECEIVED FROM ANY SOURCE AND SHALL**

1. THE STATE OF TEXAS, COUNTY OF DALLAS, ss. I, JAMES M. HARRIS, Clerk of the County Court, do hereby certify that the within and foregoing is a true and correct copy of the original as the same appears from the records of said County Court.

2010-2011

13. **CONDUCTIVE POLYMER** A polymer of $\text{CH}_2=\text{CH}-\text{N}^+\text{R}_2$ and N^+R_2 is

© 2004 Blackwell Publishing Ltd, *Journal of Internal Medicine* 255: 103–110

© 2000 Blackwell Science Ltd *Journal of Internal Medicine* 247: 395–402

12. STATE OF MISSISSIPPI, COUNTY OF BALTIMORE OF BARBERSVILLE, MISS.

CONCLUSIONS AND FURTHER CONSIDERATIONS

IN NO EVENT SHALL THE COMPANY BE RESPONSIBLE FOR ANY LOSS OF PROFITS AND/OR

1. 2019年12月31日，甲公司“应付账款”科目贷方余额为100万元，其中明细科目贷方余额有80万元，借方余额有20万元；“预付账款”科目借方余额为20万元，其中明细科目借方余额有15万元，贷方余额有5万元。不考虑其他因素，甲公司12月31日资产负债表“应付账款”项目应填列的金额为（ ）万元。

MUSIC VIDEOS ARE THE NEW RECORDS FOR TEEN-AGE BOYS

© 2000 Blackwell Science Ltd *Journal of Internal Medicine* 247: 399–406

THE UNIVERSITY OF CHICAGO PRESS
CHICAGO, ILLINOIS 60607

U.S. MAIL PERMIT NO. 5746 WASHINGTON, D.C. 20540
POSTAGE WILL BE PAID BY ADDRESSEE

Downloaded from <http://ajphaphysocpharm.sagepub.com/> at 10:06 11 November 2014

.....

DEPARTMENT OF PUBLIC WORKS

Rainbow Park Toilet Building

STRENGTH
STRENGTH
STRENGTH

EB-1

100

1990

100