
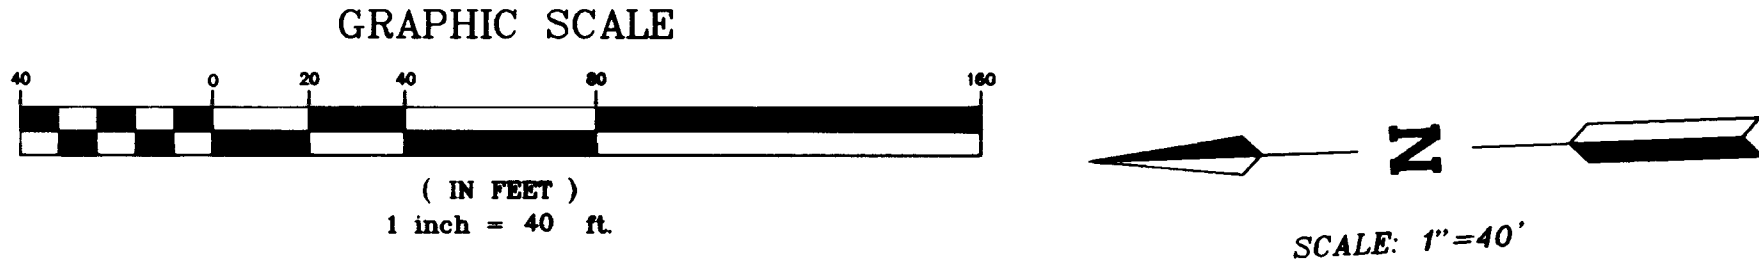


C:\maps\1520\1520T51.dwg Mon Sep 28 08:26:25 1998

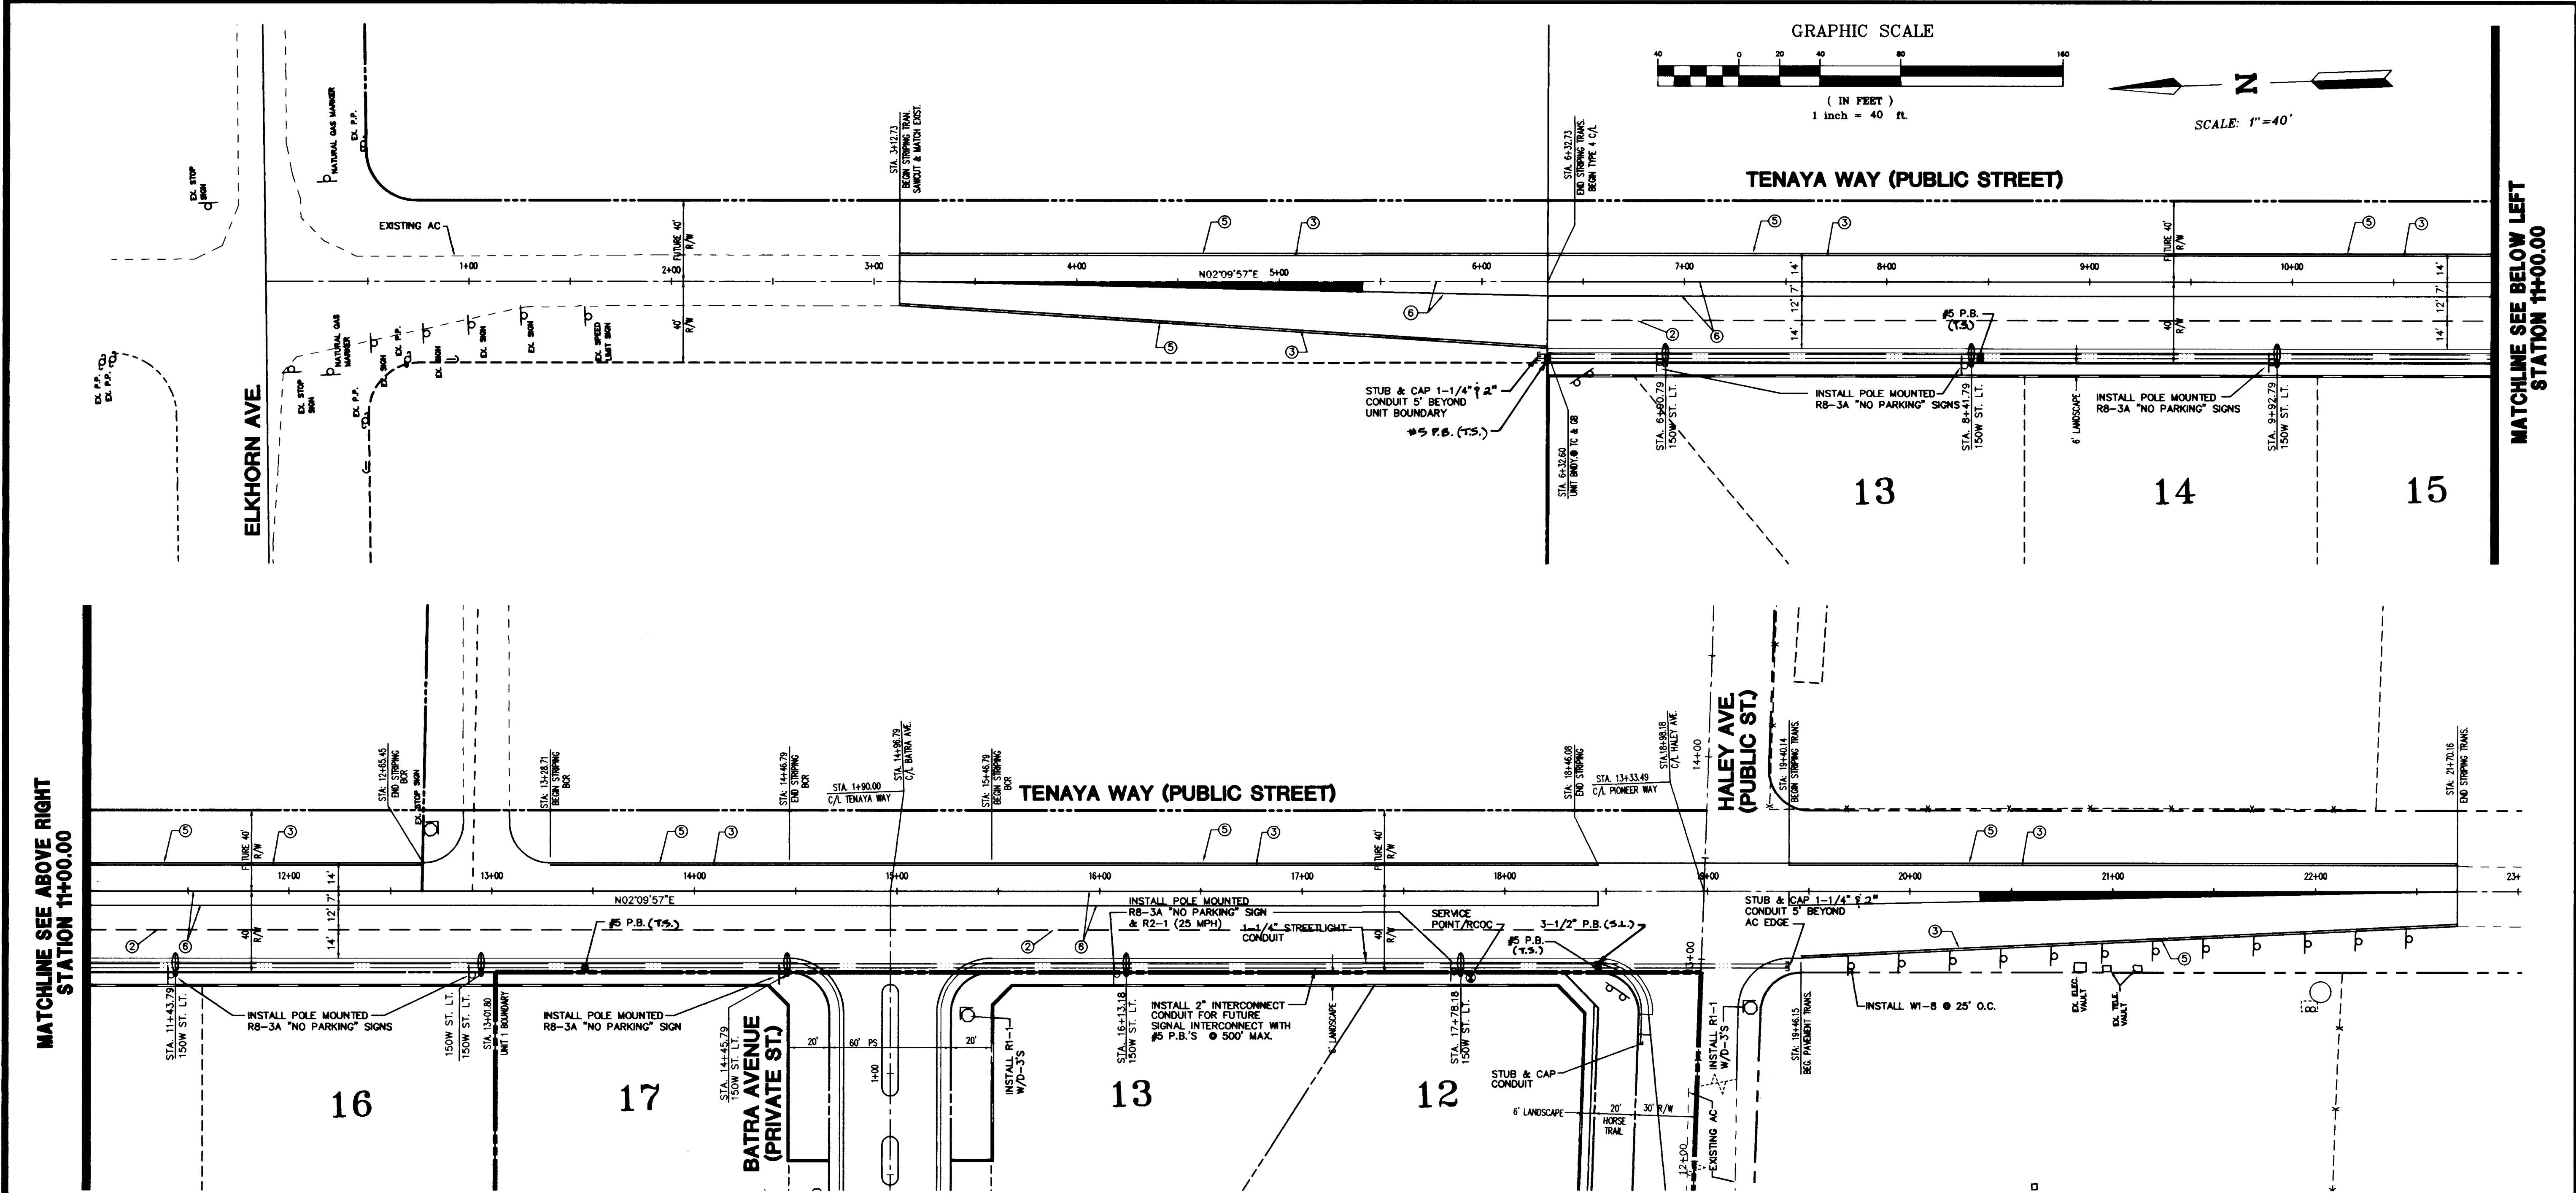

CONSTRUCTION NOTES

1. INSTALL TYPE 1 LANE DELINEATION (UNIFORM STD. DWG. NO. 244)
2. INSTALL TYPE 4 LANE DELINEATION (UNIFORM STD. DWG. NO. 244A)
3. INSTALL WHITE 4-INCH EDGE LINE (PAINT)
4. INSTALL NEW SIGNS (AS SHOWN ON PLANS)
5. EDGE OF PAVEMENT
6. FORM PAINTED ISLAND PER UNIFORM STD. DWG. 245 (3)

LEGEND

- 150W STREET LIGHT
1-1/4" STREET LIGHT CONDUIT
2" INTERCONNECT CONDUIT
SERVICE POINT/ROOC
PULLBOX (SIZE PER PLAN)
TRAFFIC SIGNAGE (TYPE PER PLAN)
R1-1 W/D-3'S

BASIS OF BEARINGS

THE BASIS OF BEARING FOR THIS SURVEY IS THE SOUTH LINE OF THE SOUTHEAST QUARTER OF THE NORTHWEST QUARTER OF SECTION 22, TOWNSHIP 19 SOUTH, RANGE 60 EAST, M.D.M., CITY OF LAS VEGAS, CLARK COUNTY NEVADA, AS SOUTH 84°59'10" EAST, AS SHOWN ON FILE 85, PAGE 38 OF SURVEYS IN THE OFFICE OF THE CLARK COUNTY, NEVADA.


REFERENCE SURVEY:
RECORD OF SURVEY FILE 86, PAGE 38 O.R.
CITY OF LAS VEGAS ANNEXATION ORD. # 4003

BENCHMARK

CLV BM # 48 11V9022W6
RIVET & PLATE ON POWER-TRANS. PAD, 7535 W. DEER SPRINGS ROAD, 500' EAST OF BUFFALO DRIVE.
ELEV.= 727.8646 (METERS)
ELEV.= 2388.0020 (U.S. SURVEY FEET)
NAVD 88 DATUM

STREETLIGHT NOTES

1. ALL STREETLIGHTING WIRE IS 2-#1-1-#8 THW IN 1-1/4" CONDUIT UNLESS NOTED OTHERWISE.
2. ALL PULLBOXES ARE No. 3-1/2" UNLESS NOTED OTHERWISE.
3. INSTALL 2-#4, 1-#6 1-1/4" CONDUIT. DO NOT CONNECT TO CIRCUIT AT EITHER END.

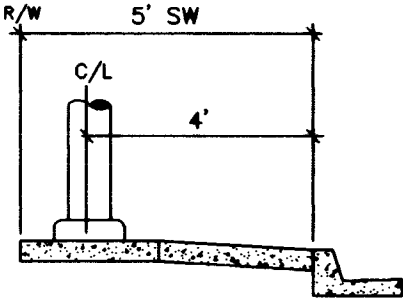

STREET LIGHT DETAIL

PUBLIC R/W ONLY

STREET LIGHT NOTE

ALL HAND HOLE COVERS MUST BE INSTALLED, POLE CAPS POURED, AND PULL BOX LIDS BOLTED DOWN PRIOR TO ENERGIZING CIRCUIT. ALL WIRE MUST HAVE THW INSULATION.

Call before you Overhead
1-702-593-6111
NEAR POWER ENVIRONMENT & SAFETY SERVICES DEPARTMENT

Call before you Dig.
1-800-227-2600

THE DEVELOPERS OF NEVADA 7448 WEST SAHARA AVENUE LAS VEGAS, NEVADA 89117 (702) 222-1410		SIGNAGE, STRIPING AND STREETLIGHTING PLAN		SHEET 12-11-97	
SHENANDOAH UNIT 1		TITLE		DRAWN BY: ROCKY	
DESIGNING FOR THE FUTURE PLANNERS • CONSULTING ENGINEERS • SURVEYORS 7948 WEST SAHARA AVENUE • LAS VEGAS, NEVADA 89117 • (702) 248-6415		SCALE: 1" = 40' HOR.		DESIGNED BY: ROCKY/SHEN	
REV DATE BY		PROJECT NO: 885 5590		CHECKED BY: GREG RIBERO	
REVISION		9-28-98		PROF. ENGINEER KATHY R. SMITH No. 6987 KVS	
207 Y-4573-1		20 OF 31 SHEETS		DRAWING NO.	

