
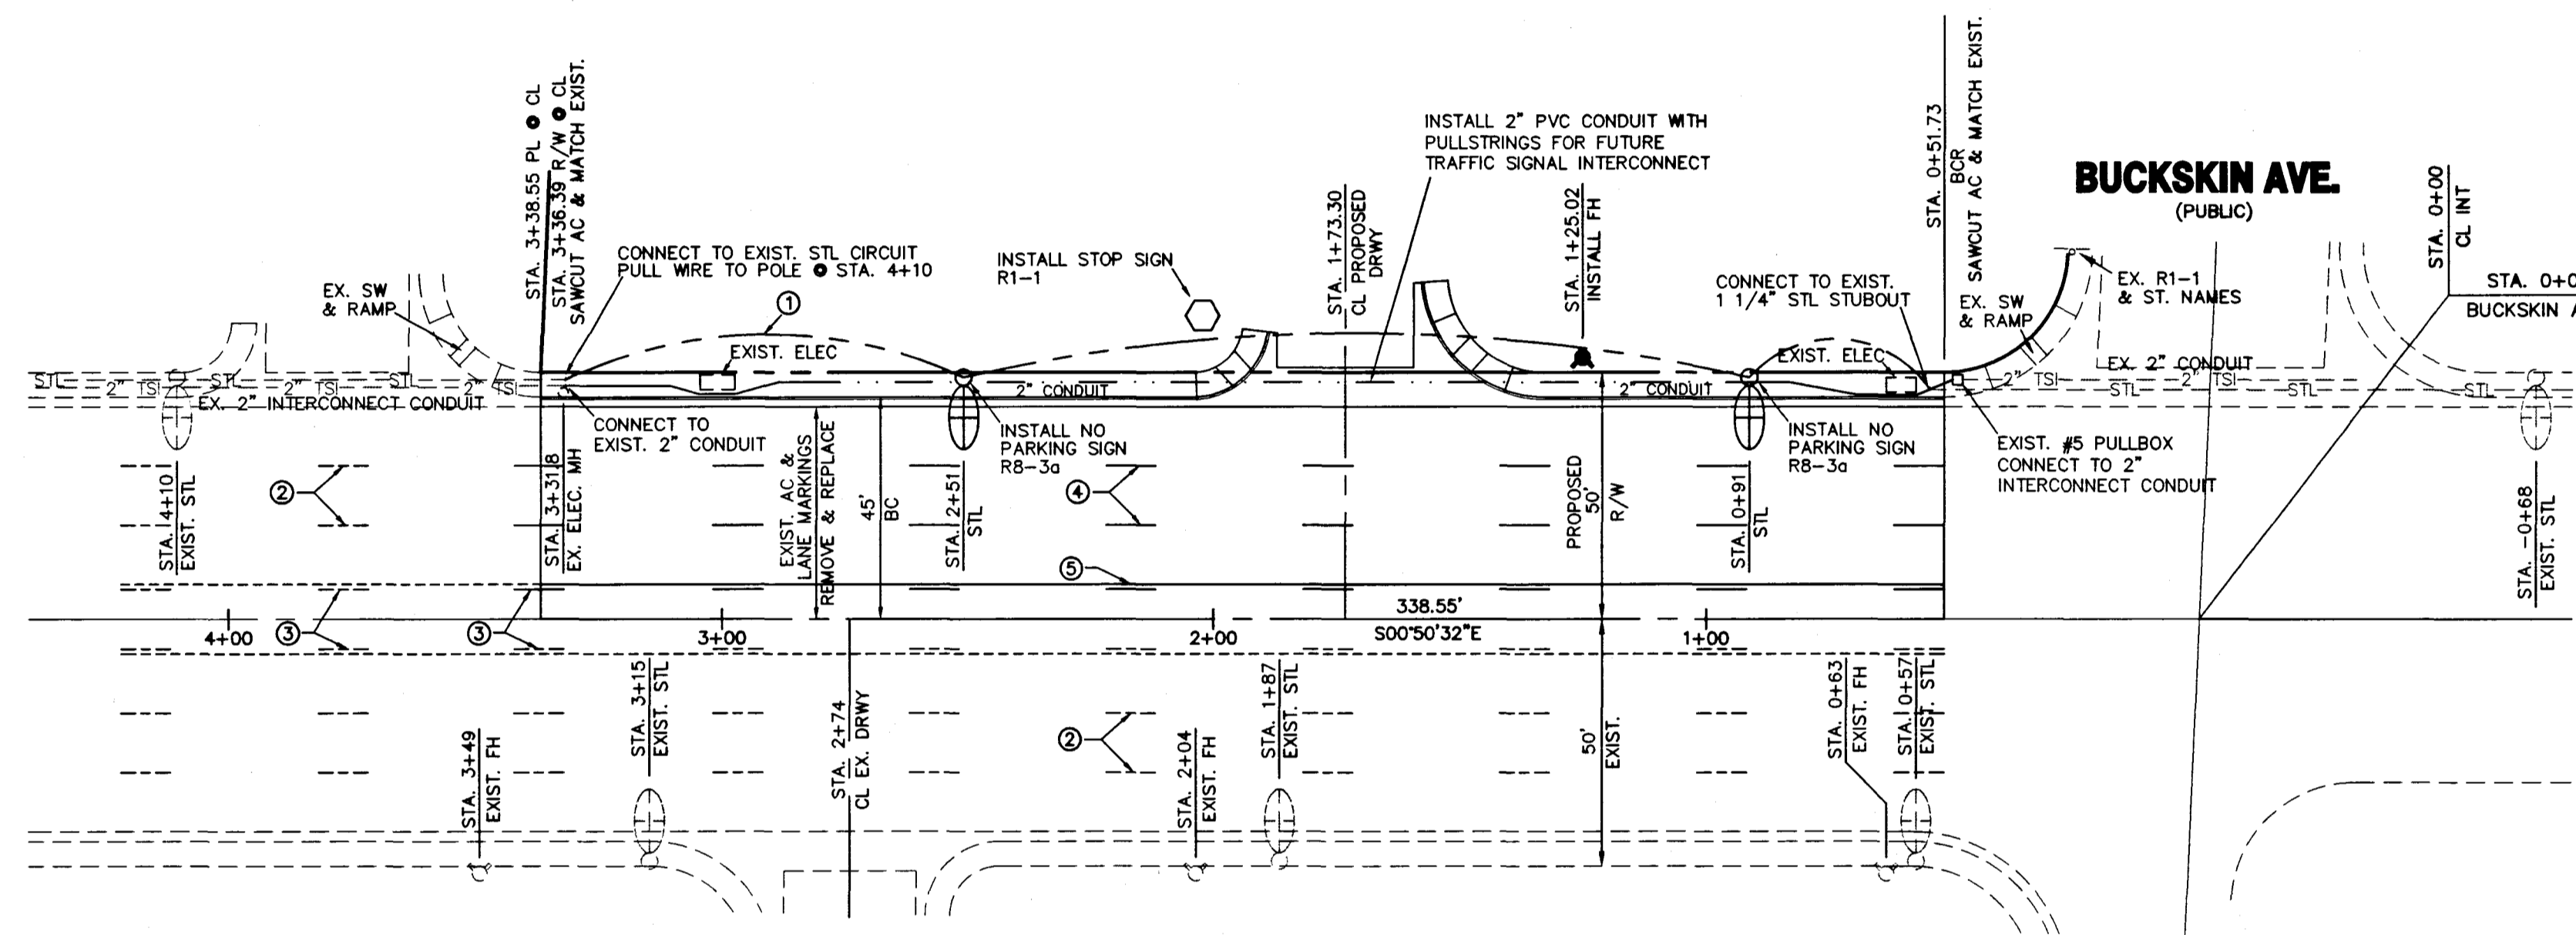
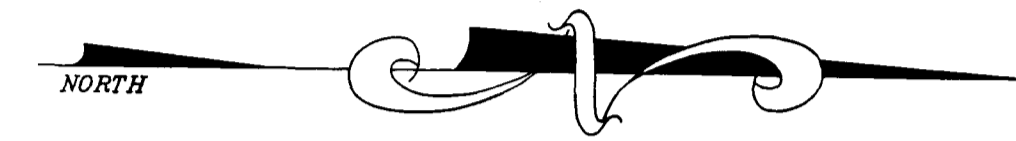


Avoid cutting underground utility lines. It's costly.  
**Call before you Dig.**  
 1-800-227-2600

**BENCHMARK**  
 RIVET & PLATE IN TOP OF CURB, 50' SOUTH OF  
 FIRE HYDRANT, 3300 BUFFALO DRIVE. BENCHMARK  
 NO. 1LV0015WM6. ELEVATION = 2361.48' NAVD88

**BASIS OF BEARINGS**  
 BASIS OF BEARINGS BEING THE EAST LINE OF NORTHEAST  
 QUARTER (NE 1/4) OF THE SOUTHEAST QUARTER (SE 1/4)  
 OF THE SOUTHEAST QUARTER (SE 1/4) OF SECTION 9,  
 TOWNSHIP 20 SOUTH, RANGE 60 EAST, M.D.M., CLARK COUNTY  
 NEVADA, AS SHOWN ON MAP RECORDED ON OCTOBER 5, 1994,  
 IN BOOK 64, PAGE 26, OF PLATS, OFFICIAL RECORDS, CLARK  
 COUNTY, NEVADA; WHICH BEARS SOUTH 00°50'32" EAST.

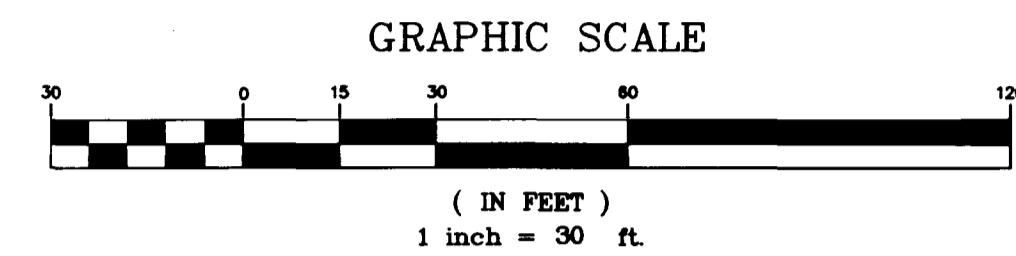

**BUFFALO DRIVE**  
 (PUBLIC)

**BUCKSKIN AVE.**  
 (PUBLIC)

**CONSTRUCTION NOTES**


- ① 1 1/4" PVC CONDUIT
- ② EXIST. TYPE 5 LANE LINE
- ③ EXIST. TYPE 2 CENTERLINE
- ④ EXIST. TYPE 5 LANE LINE TO BE REMOVED  
INSTALL NEW TYPE 5 LANE LINE
- ⑤ EXIST. TYPE 2 CENTERLINE TO BE REMOVED  
INSTALL NEW TYPE 2 CENTERLINE

**STREETLIGHT QUANTITIES**

250 WATT HPS LUMINAIRE	2 EA
2" PVC CONDUIT	282 LF

**STREETLIGHT NOTES**

ALL STREET LIGHTING INSTALLATIONS SHALL CONFORM TO THE LATEST ISSUE OF THE STANDARD DETAILS AND SPECIFICATIONS OF THE CITY OF LAS VEGAS, AND SHALL ALSO CONFORM TO THE UNIFORM STANDARD SPECIFICATIONS FOR PUBLIC WORKS CONSTRUCTION OF OFF-SITE IMPROVEMENTS, CLARK COUNTY AREA, LATEST EDITION, UNLESS OTHERWISE NOTED. ALL HAND HOLE COVERS MUST BE INSTALLED, POLE CAPS POURED AND PULL BOX LIDS BOLTED DOWN PRIOR TO ENERGIZING CIRCUIT. ALL WIRE MUST HAVE THW INSULATIONS.

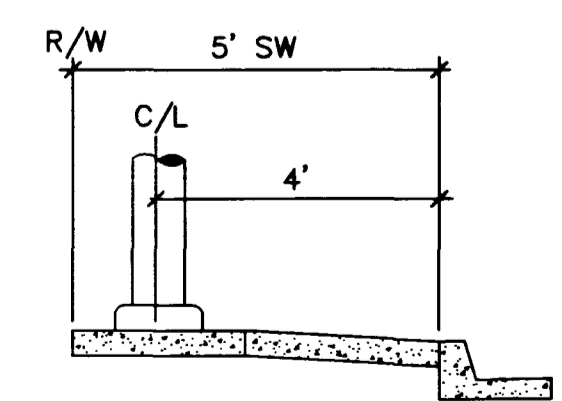

**STREET LIGHT DETAIL**


**DON HERMAN CONSTRUCTION**  
 3305 SPRING MOUNTAIN ROAD #86  
 LAS VEGAS, NEVADA 89102  
 (702) 395-8615

**ROBERT J. LANGAN**  
**ENGINEERING**  
 8725 W. Sahara Avenue - Suite 2C  
 LAS VEGAS, NEVADA 89128  
 (702) 241-0800

**SIGNAGE, STRIPING AND STREETLIGHTING PLAN**

**SILVER CARE**  
**WILLOW CREEK AT BUFFALO**

DRAWN BY: R. J. LANGAN	DESIGNED BY: R. J. LANGAN	CHECKED BY: R. J. LANGAN	PROJECT NO: DHCS88-001
DATE: 5/7/98	DATE: 5/7/98	DATE: 5/7/98	SCALE: 1" = 30' HOR. 1" = 3' VER.

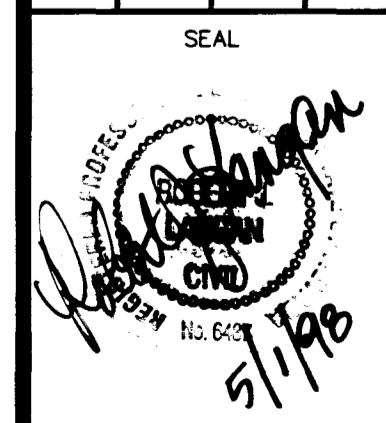

SHEET  
**TS1**  
 8 OF 8 SHEETS  
 DRAWING NO.  
**107-V2.860**

10/1/2011  
 before  
 1-800-827-8822

**BENCHMARK**  
 1744171.00  
 1744171.00

**BASE OF FINISHES**  
 1744171.00  
 1744171.00



**BUFFALO DRIVE**

- CONSTRUCTION NOTES**
- 1. SEE PLAN FOR ALL
  - 2. SEE SPEC FOR ALL
  - 3. SEE SPEC FOR ALL
  - 4. SEE SPEC FOR ALL
  - 5. SEE SPEC FOR ALL

**STREETLIGHT QUANTITIES**  
 12 12' 0" HIGHS  
 12 12' 0" HIGHS

**STREETLIGHT NOTES**  
 1. SEE SPEC FOR ALL  
 2. SEE SPEC FOR ALL  
 3. SEE SPEC FOR ALL



PROJECT NO. SHEET NO.	DATE SCALE	DRAWN BY CHECKED BY	PROJECT NAME SHEET NAME
10/1/2011 1-800-827-8822	12.00' 12.00'	[Signature] [Signature]	BUFFALO DRIVE BUFFALO DRIVE