


Avoid cutting underground utility lines. It's costly.
Call before you Dig
 1-800-227-2600


Avoid overhead power line contact.
Call before you OVERHEAD
 1-702-593-6111

BENCHMARK
 CLV BM NO. 7, STA. 1LV9017NES
 BLM BRASS CAP AT DURANGO DRIVE AND GRAND TETON DRIVE.
 ELEVATION = 2541.392 (NAVD 88)

NOTES:
 1. ALL STATIONING IS BASED ON SEWER LENGTHS FROM MANHOLE TO MANHOLE.
 2. ALL WORK PERFORMED WITHIN CLARK COUNTY RIGHT OF WAY REQUIRES A CLARK COUNTY PERMIT.

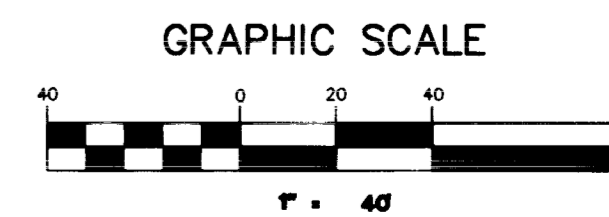

SOUTHWEST COMMUNITIES, INC.
 950 BROADBENT BOULEVARD
 HENDERSON, NEVADA 89014
 CITY OF LAS VEGAS, NEVADA

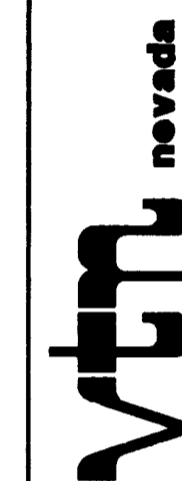

CONSULTING ENGINEERS • PLANNERS • LAND SURVEYORS
 2727 SOUTH RAINBOW BOULEVARD
 LAS VEGAS, NEVADA 89102-5148 PHONE (702) 873-7550 FAX (702) 362-2597

PLAN AND PROFILE
GRAND TETON DRIVE
STA. 110+00.00 TO STA. 117+94.68
SPRING MOUNTAIN RANCH
(OFFSITE SEWER - ALTERNATE "B")



SEAL
 THOMAS F. HAYES
 CIVIL ENGINEER
 No. 9426
 APR 1997

NO. 5069
 BY dtb
 DATE APRIL 1997
 SCALE HORIZ. 1" = 40'
 VERT. 1" = 4'
 SHEET 11 OF 14 SHEETS



3074-4518-05-B

523

  DATE: 10/15/88 BY: J. W. HARRIS, JR.



GRAND TETON DRIVE

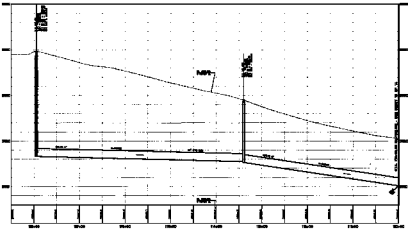 

Call 120-00-00
Call 120-00-00
OVERHEAD

CONSTRUCTION
BY THE U.S. BUREAU OF RECONSTRUCTION
RECONSTRUCTION DIVISION
WASH. D.C. 20540

NOTES
1. REFER TO DRAWING
2. REFER TO DRAWING
3. REFER TO DRAWING

CONSULTING ENGINEERS, INC.
 1000 WEST 10TH AVENUE
 DENVER, COLORADO 80202
 PHONE (303) 733-1100

DATE: 10/15/88
 DRAWN BY: J. W. HARRIS, JR.
 CHECKED BY: J. W. HARRIS, JR.
 APPROVED BY: J. W. HARRIS, JR.

VTI
 VETERINARY TECHNOLOGICAL INSTITUTE

PLAN AND PROFILE
 GRAND TETON DRIVE
 STA. 10+00.00 TO STA. 17+04.00
 SPRING MOUNTAIN RANGE
 SPRING MOUNTAIN RANGE
 SPRING MOUNTAIN RANGE

11

10/15/88

10/15/88

10/15/88

60

10/15/88