


**GOLF COURSE SEWER CROSSING PLAN AND PROFILE** 1  
27

SCALE: HORIZ. 1" = 40'  
VERT. 1" = 4'

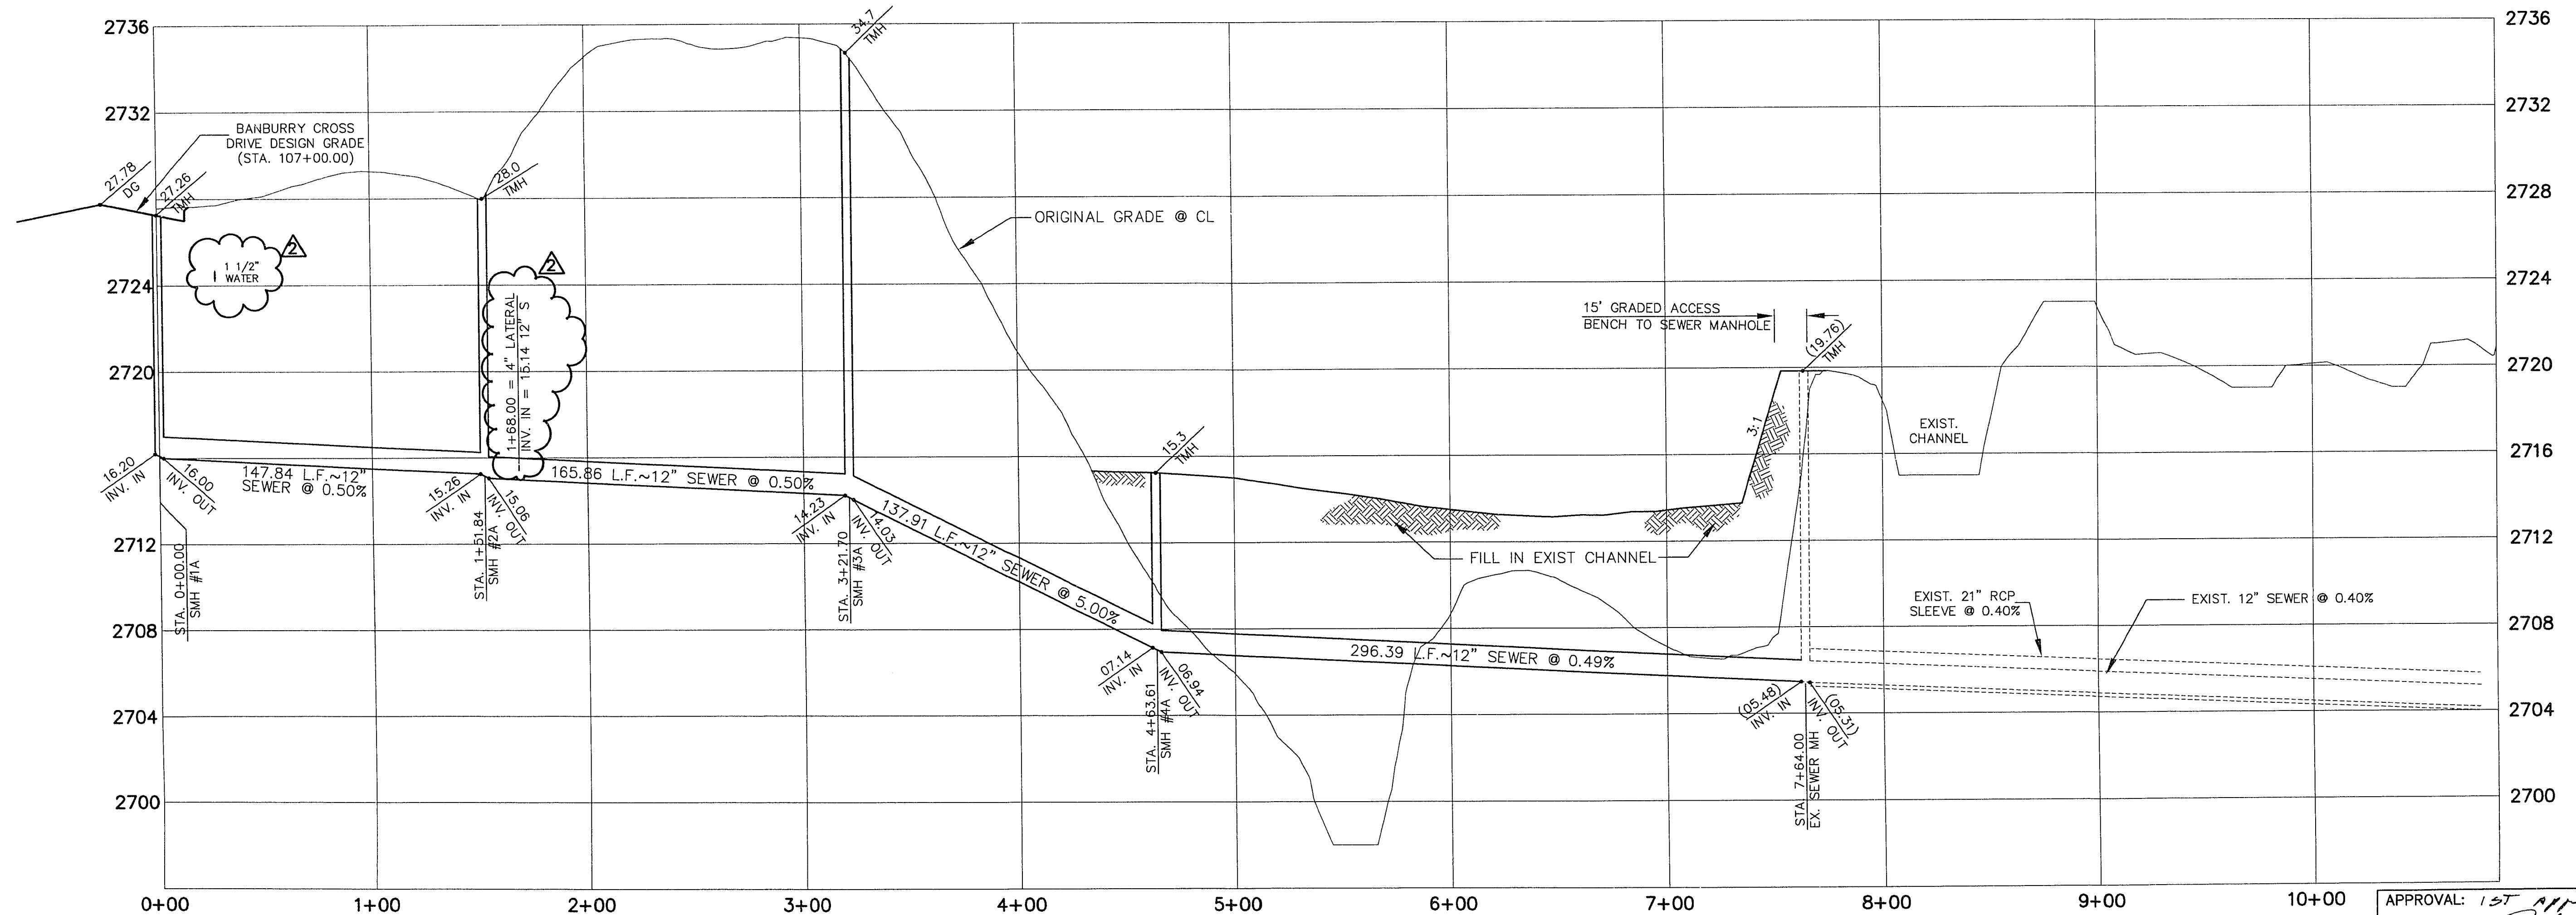

APPROVAL: 15T APR 6-13-25  
 [Signature] 7/16/26  
 LAS VEGAS VALLEY WATER DISTRICT DATE

<p>RECOMMENDED ENGINEER OF RECORD</p> <p align="center"> </p> <p align="center"> <b>BERT A. HUGHES</b>        CIVIL ENGINEER        No. 10259     </p>	<p>REVISIONS</p> <table border="1" style="width: 100%; border-collapse: collapse;"> <tr> <th>NO.</th> <th>DATE</th> <th>DESCRIPTION</th> </tr> <tr> <td>2</td> <td>7/16/26</td> <td>ADD RESTROOM SEWER LATERAL TO HOLE #5 RESTROOM</td> </tr> <tr> <td>1</td> <td>7/16/26</td> <td>REV. RESTROOM &amp; SEWER LATERAL LOCATIONS AND EXTEND WATER AND POWER SERVICES FROM EXIST. STUDS</td> </tr> </table>	NO.	DATE	DESCRIPTION	2	7/16/26	ADD RESTROOM SEWER LATERAL TO HOLE #5 RESTROOM	1	7/16/26	REV. RESTROOM & SEWER LATERAL LOCATIONS AND EXTEND WATER AND POWER SERVICES FROM EXIST. STUDS
NO.	DATE	DESCRIPTION								
2	7/16/26	ADD RESTROOM SEWER LATERAL TO HOLE #5 RESTROOM								
1	7/16/26	REV. RESTROOM & SEWER LATERAL LOCATIONS AND EXTEND WATER AND POWER SERVICES FROM EXIST. STUDS								
<p><b>G. C. WALLACE, INC.</b>        Engineering/Architecture</p>										
<p><b>SUMMERLIN VILLAGE 3 ROUGH GRADING UTILITY SERVICE EXTENSION PROFILES</b></p>										
<p>SHEET <b>27</b> OF 47</p>										

JOB NO. 62003.203

S.T.S. V3MG-27.DWG, 05/29/96

24-2-110 Revised 107-V2355