



AIR OUTLETS SCHEDULE		
TYPE	DESCRPTIONS	MFR / MODEL NO.
ER	EXHAUST REGISTER, BAR GRILLE W/ 1/2" SPACING HEAVY DUTY STEEL CONSTRUCTION & FRAME H	KRUEGER NO. 1815 RHD45 OR EQUAL.

FAN SCHEDULE										
NO.	MFR/MODEL NO	TYPE	CFM	TSP	WATTS	RPM	V-PH-HZ	WT.	SERVICE	LOCATION
EF-1	DAYTON 2D073	CEILING	500	0.25	280	1050	115-1-60	48	WOMEN	CEILING
EF-2	DAYTON 2D073	CEILING	500	0.25	280	1050	115-1-60	48	MEN	CEILING
NOTES: 1. ALL EXHAUST FANS SHALL BE COMPLETE WITH ROOF CAP, FLASHING, EXHAUST DUCT. 2. EF-1, EF-2 SHALL BE CONTROLLED BY PROGRAMMABLE TIME CLOCK.										

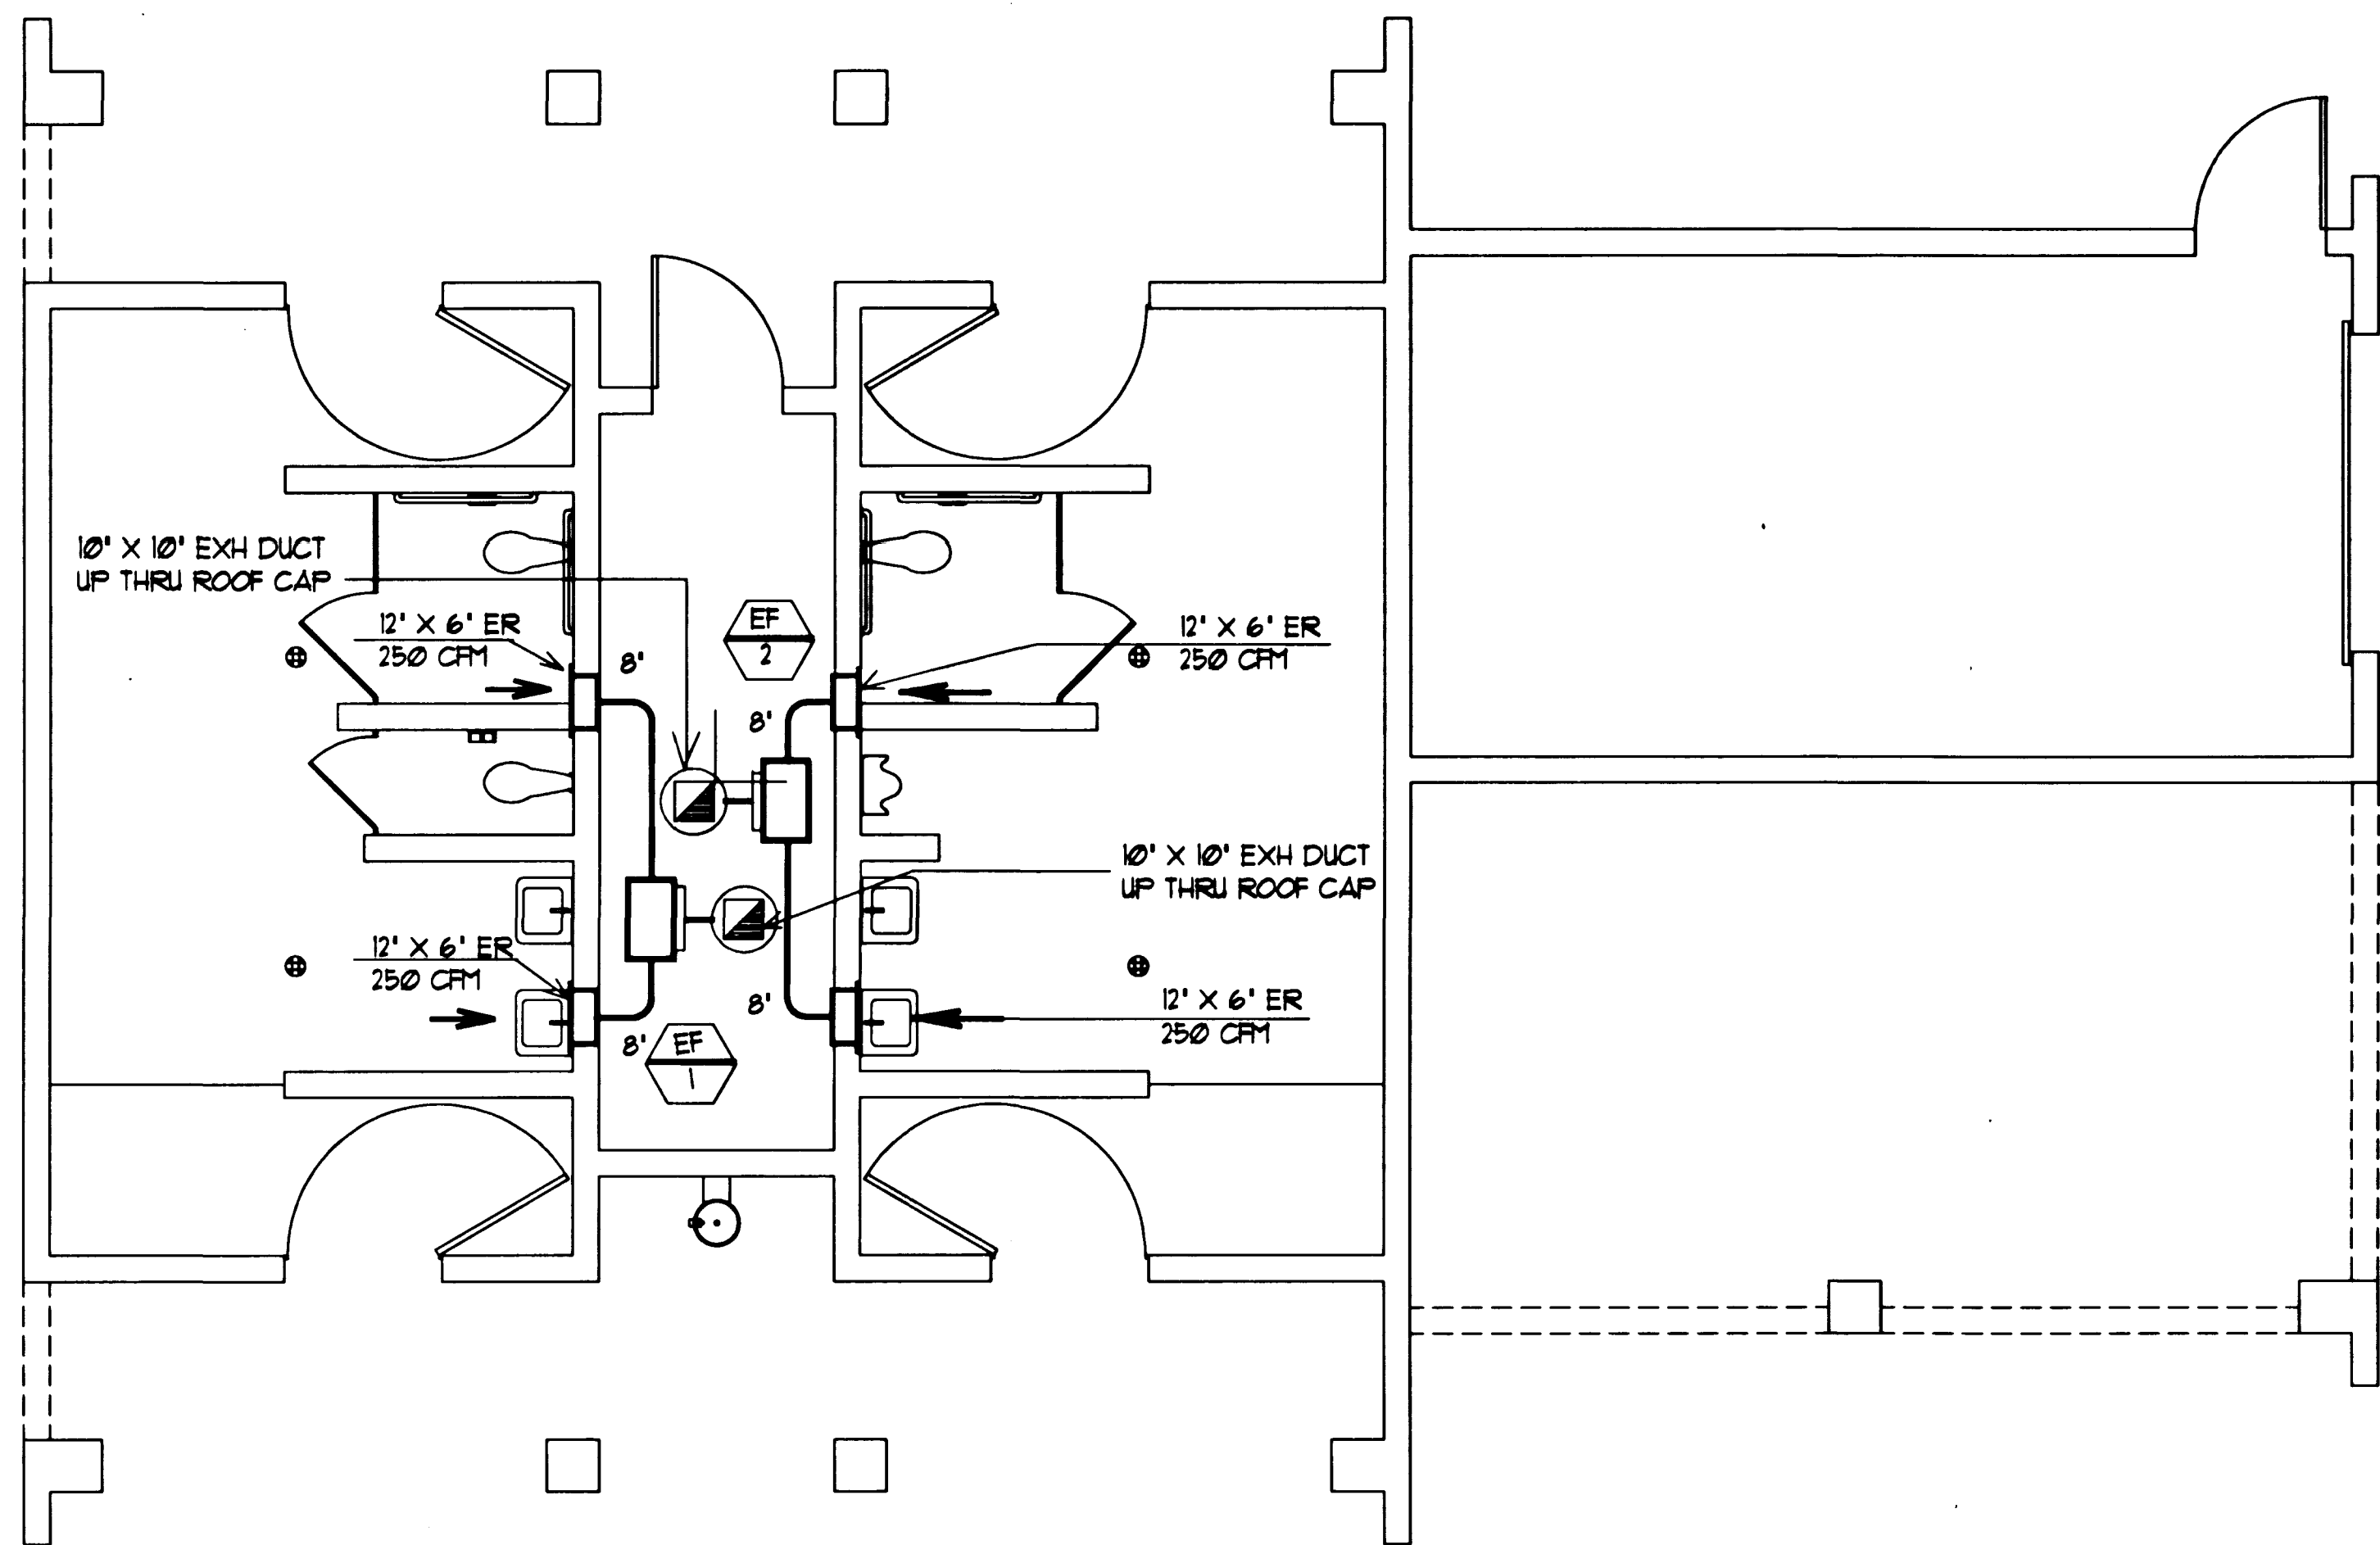

SYMBOL LIST

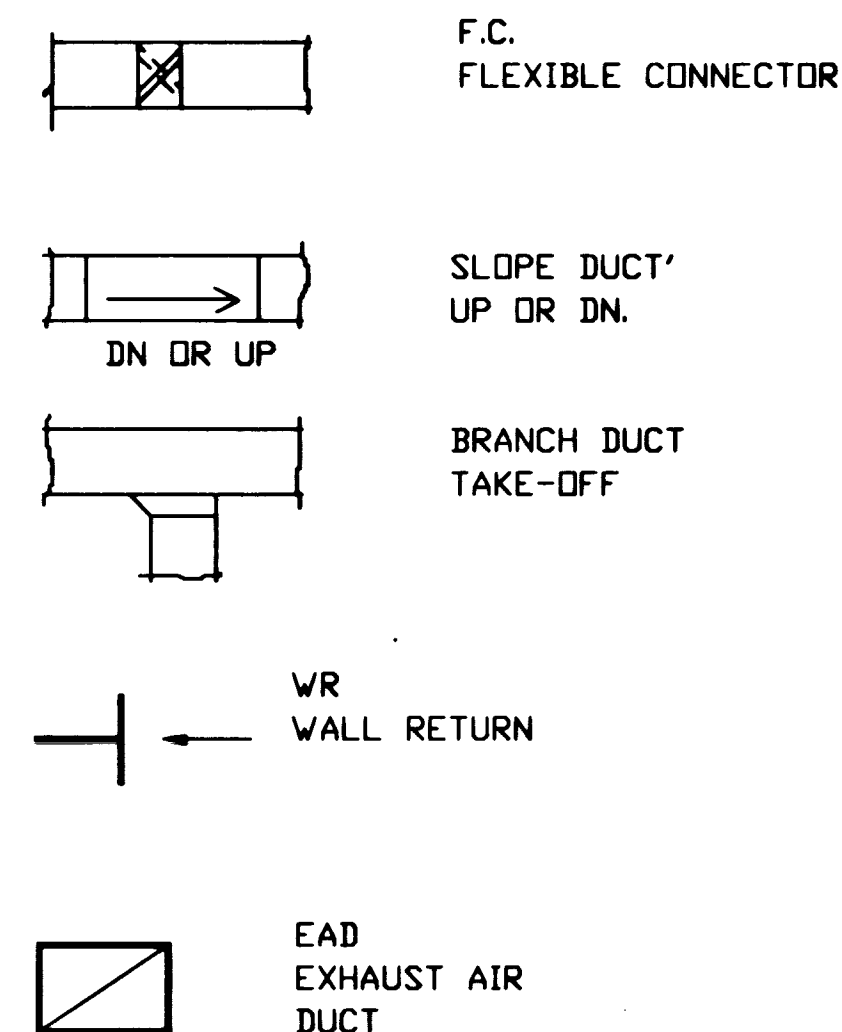

GENERAL NOTES:

- ALL WORK SHALL BE IN ACCORDANCE WITH 1994 UBC, UMC, UPC & NFPA, 1993 NEC AND 1992 MEC. ALL LATEST RULES, REGULATION AND ORDINANCES OF THE CITY OF LAS VEGAS AND STATE OF NEVADA.
- HVAC CONTRACTOR SHALL BE RESPONSIBLE FOR ALL PERMITS AND FEES RELATED TO HIS TRADE.
- ALL NEW DUCTWORK WILL BE CONSTRUCTED AND SUPPORTED UNDER LATEST EDITION OF SMACNA AND 1994 UMC.
- ALL DUCT SHALL BE INSTALLED TO CLEAR LIGHTS AND BUILDING STRUCTURES.
- SUBMIT SIX COPIES OF SHOP DRAWINGS AND SUBMITTALS FOR REVIEW AND APPROVAL BEFORE ORDERING MATERIALS.
- COORDINATE WITH THE ELECTRICIAN FOR POWER CONNECTION .
- PROVIDE THE OWNER (3) THREE COPIES OF SERVICE AND MAINTENANCE MANUAL..

DATE:	REVISIONS:	DRAWN BY: HL	DESIGN BY: AC	ARCHITECTURAL SERVICES 
DATE: 7/97	DATE: 7/97	DATE: 7/97	DATE: 7/97	
DATE: 7/97	DATE: 7/97	DATE: 7/97	DATE: 7/97	
DATE: 7/97	DATE: 7/97	DATE: 7/97	DATE: 7/97	
DEPARTMENT OF PUBLIC WORKS PROJECT: Torrey Pines Park & Ball Field		SHEET TITLE: BALL FIELD - VENTILATION FLOOR PLAN		SHEET NO. 72 
DRAWING NO. 000.01		000.01		

