



AIR OUTLETS SCHEDULE		
TYPE	DESCRPTIONS	MFR / MODEL NO.
ER	EXHAUST REGISTER, BAR GRILLE W/ 1/2" SPACING HEAVY DUTY STEEL CONSTRUCTION & FRAME H	KRUEGER NO. 1815 RHD45 OR EQUAL.

FAN SCHEDULE										
NO.	MFR/MODEL NO	TYPE	CFM	TSP	WATTS	RPM	V-PH-HZ	WT.	SERVICE	LOCATION
EF-1	DAYTON 2D073	CEILING	500	0.25	280	1050	115-1-60	48	WOMEN	CEILING
EF-2	DAYTON 2D073	CEILING	500	0.25	280	1050	115-1-60	48	MEN	CEILING
NOTES: 1. ALL EXHAUST FANS SHALL BE COMPLETE WITH ROOF CAP, FLASHING, EXHAUST DUCT. 2. EF-1, EF-2 SHALL BE CONTROLLED BY PROGRAMMABLE TIME CLOCK.										

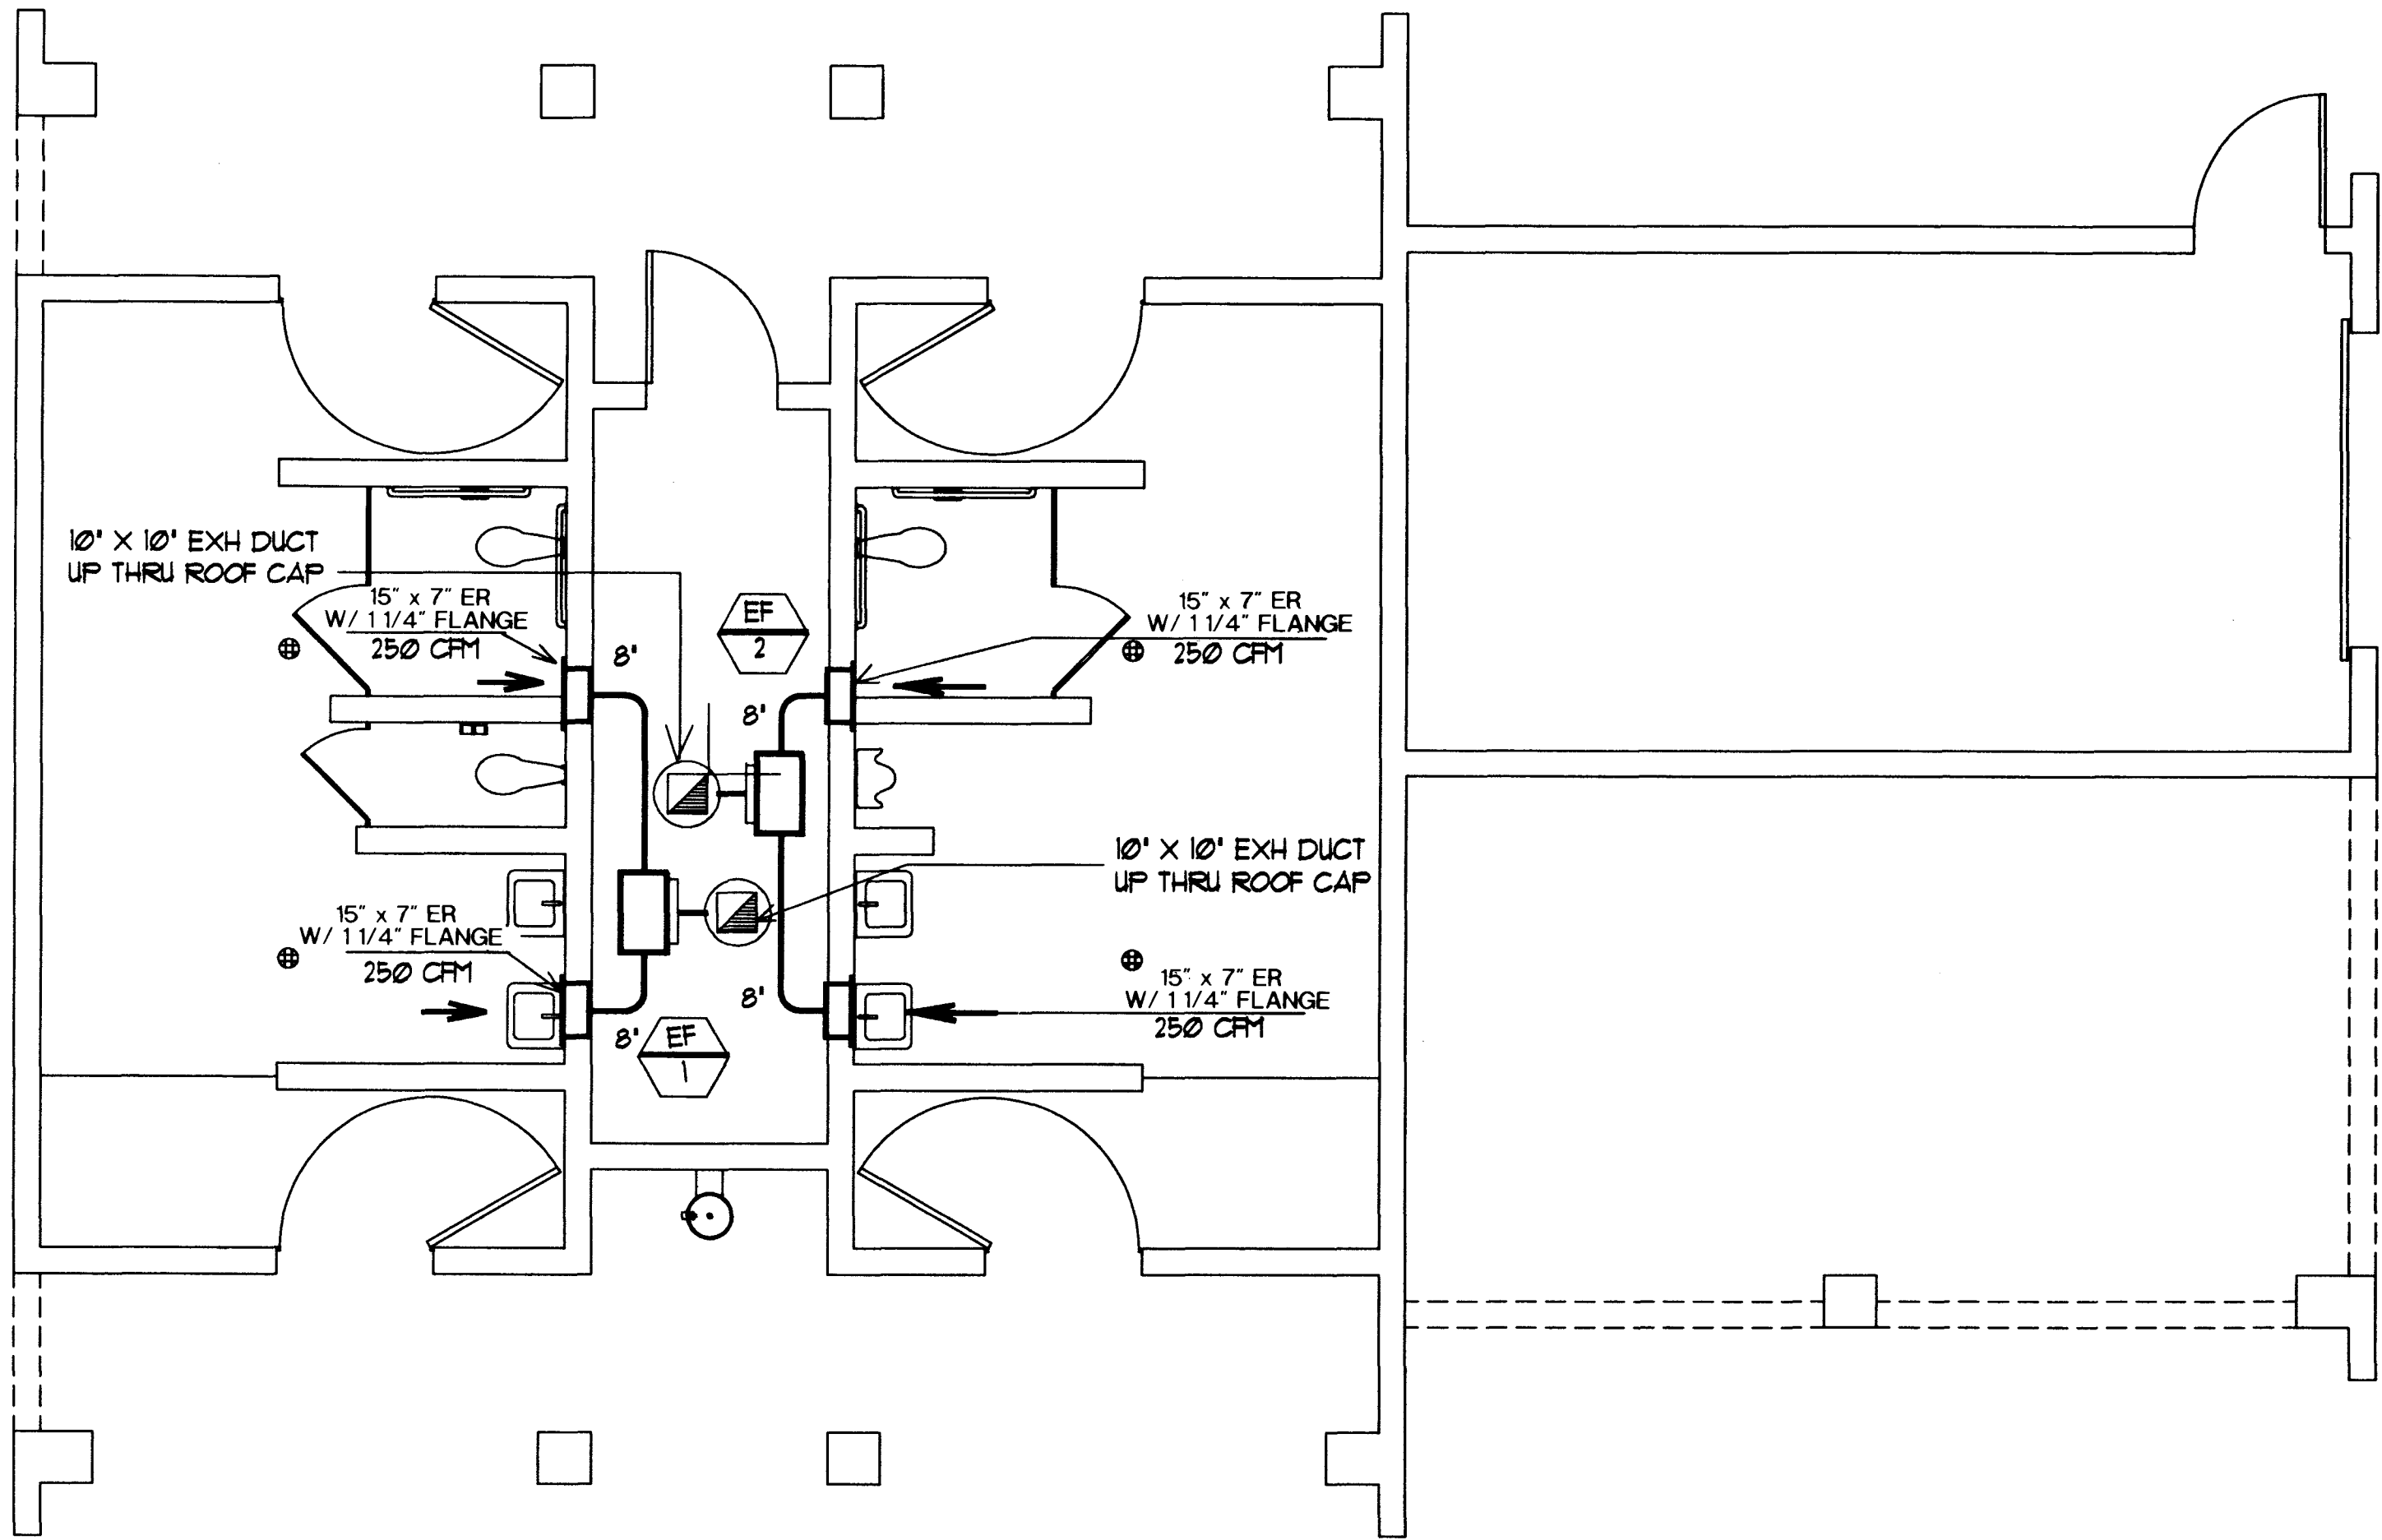


SYMBOL LIST

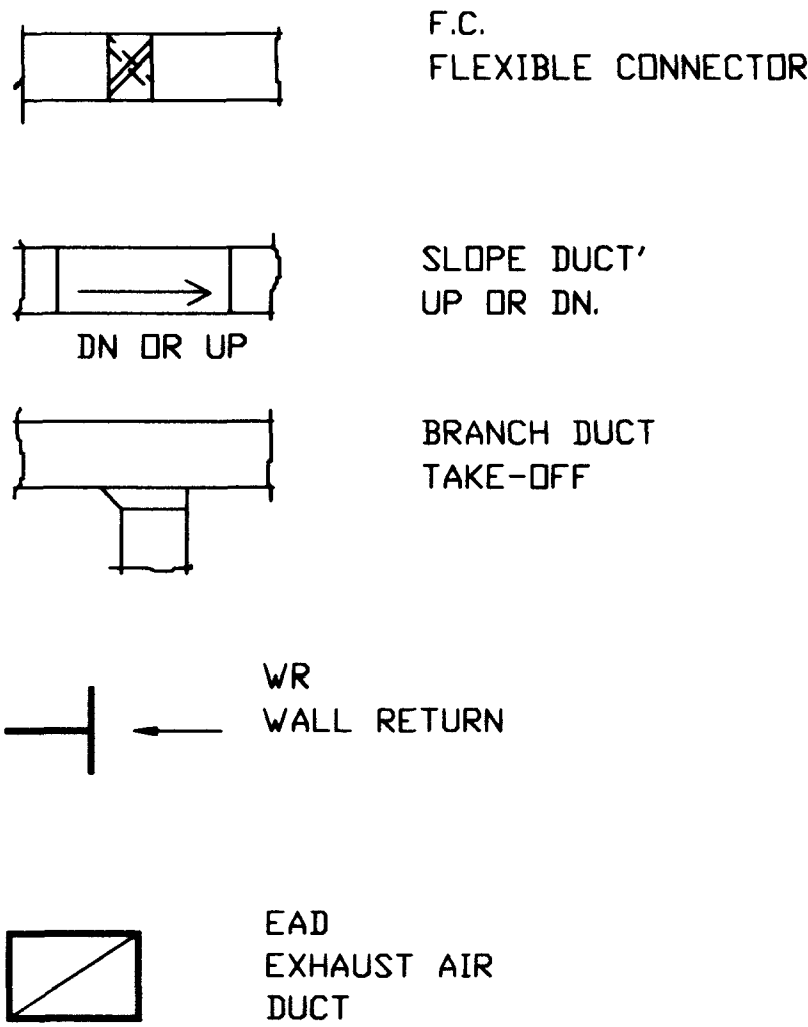

- GENERAL NOTES:
- ALL WORK SHALL BE IN ACCORDANCE WITH 1994 UBC, UMC, UPC & NFPA, 1993 NEC AND 1992 MEC. ALL LATEST RULES, REGULATION AND ORDINANCES OF THE CITY OF LAS VEGAS AND STATE OF NEVADA.
 - HVAC CONTRACTOR SHALL BE RESPONSIBLE FOR ALL PERMITS AND FEES RELATED TO HIS TRADE.
 - ALL NEW DUCTWORK WILL BE CONSTRUCTED AND SUPPORTED UNDER LATEST EDITION OF SMACNA AND 1994 UMC.
 - ALL DUCT SHALL BE INSTALLED TO CLEAR LIGHTS AND BUILDING STRUCTURES.
 - SUBMIT SIX COPIES OF SHOP DRAWINGS AND SUBMITTALS FOR REVIEW AND APPROVAL BEFORE ORDERING MATERIALS.
 - COORDINATE WITH THE ELECTRICIAN FOR POWER CONNECTION .
 - PROVIDE THE OWNER (3) THREE COPIES OF SERVICE AND MAINTENANCE MANUAL..

DATE:		REVISIONS:		DRAWN BY: HL		DESIGN BY: AG		ARCHITECTURAL SERVICES	
DATE:		REVISIONS:		DATE: 7/91					
DATE:		REVISIONS:		DATE: 7/91					
				DEPARTMENT OF PUBLIC WORKS PROJECT: Torrey Pines Park & Ball Field SHEET TITLE: BALL FIELD - VENTILATION FLOOR PLAN SHEET NO. 11					
DRAWING NO. 650.41				79				83	

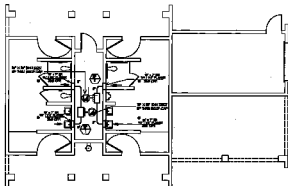

SYMBOL LIST



GENERAL NOTES

1. ALL WORK SHALL BE IN ACCORDANCE WITH 1991 LBC, LSC, LFC & LMC, PLUS SEC AND THE SEC. ALL LATEST RULES, REGULATIONS AND ORDINANCES OF THE CITY OF LOS ANGELES AND STATE OF CALIFORNIA.
2. THE CONTRACTOR SHALL BE RESPONSIBLE FOR ALL PERMITS AND FEES RELATED TO THE WORK.
3. ALL NEW EQUIPMENT SHALL BE CONTINGENT AND SUPPLEMENTED UNDER EXISTING SERVICE OF EXISTING AND NEW LBC.
4. ALL DUCT SHALL BE PROVIDED TO EXIST SERVICE AND EXISTING EQUIPMENT.
5. MAINTAIN THE LEVELS OF THE EXISTING AND EXISTING EQUIPMENT AND APPROPRIATE DUCTING INCLUDING MATERIALS.
6. COORDINATE WITH THE ARCHITECT FOR POWER CONNECTION.
7. PROVIDE THE OWNER (2) THREE COPIES OF RECORD AND ASSESSMENT DRAWING.

AIR OUTLETS SCHEDULE

TYPE	DESCRIPTION	REF / SPEC. NO.
10	CEILING EXHAUST AND DUCT TO LAY EXHAUST HEAVY DUTY STEEL CONNECTION & FLEXIBLE AIR DUCT	RECEIVER AND DUCT SHALL BE DUCT.

FAN SCHEDULE

NO.	DESCRIPTION NO.	TYPE	QPM	TOP	OUTLET	QPM	V-100-10	WT.	DELIVER	EXHAUST
17-1	EXHAUST DUCT	10000	100	100	100	100	110-1-10	10	1000	1000
17-2	EXHAUST DUCT	10000	100	100	100	100	110-1-10	10	100	1000

NOTES

1. ALL EXHAUST DUCT SHALL BE EXHAUST DUCT WITH DUCT, EXHAUST DUCT, & DUCT, DUCT SHALL BE EXHAUST DUCT WITH DUCT.