



PROJECT SITE

PROJECT LOCATION

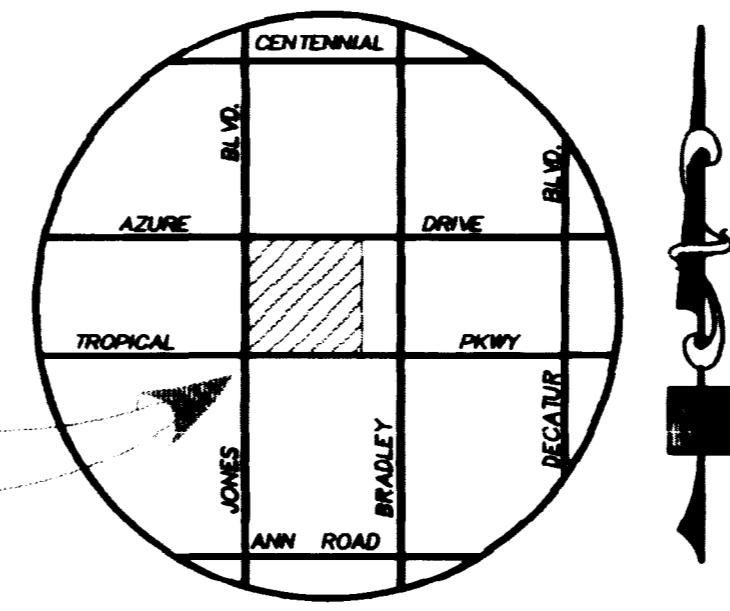

PROJECT LOCATION MAP

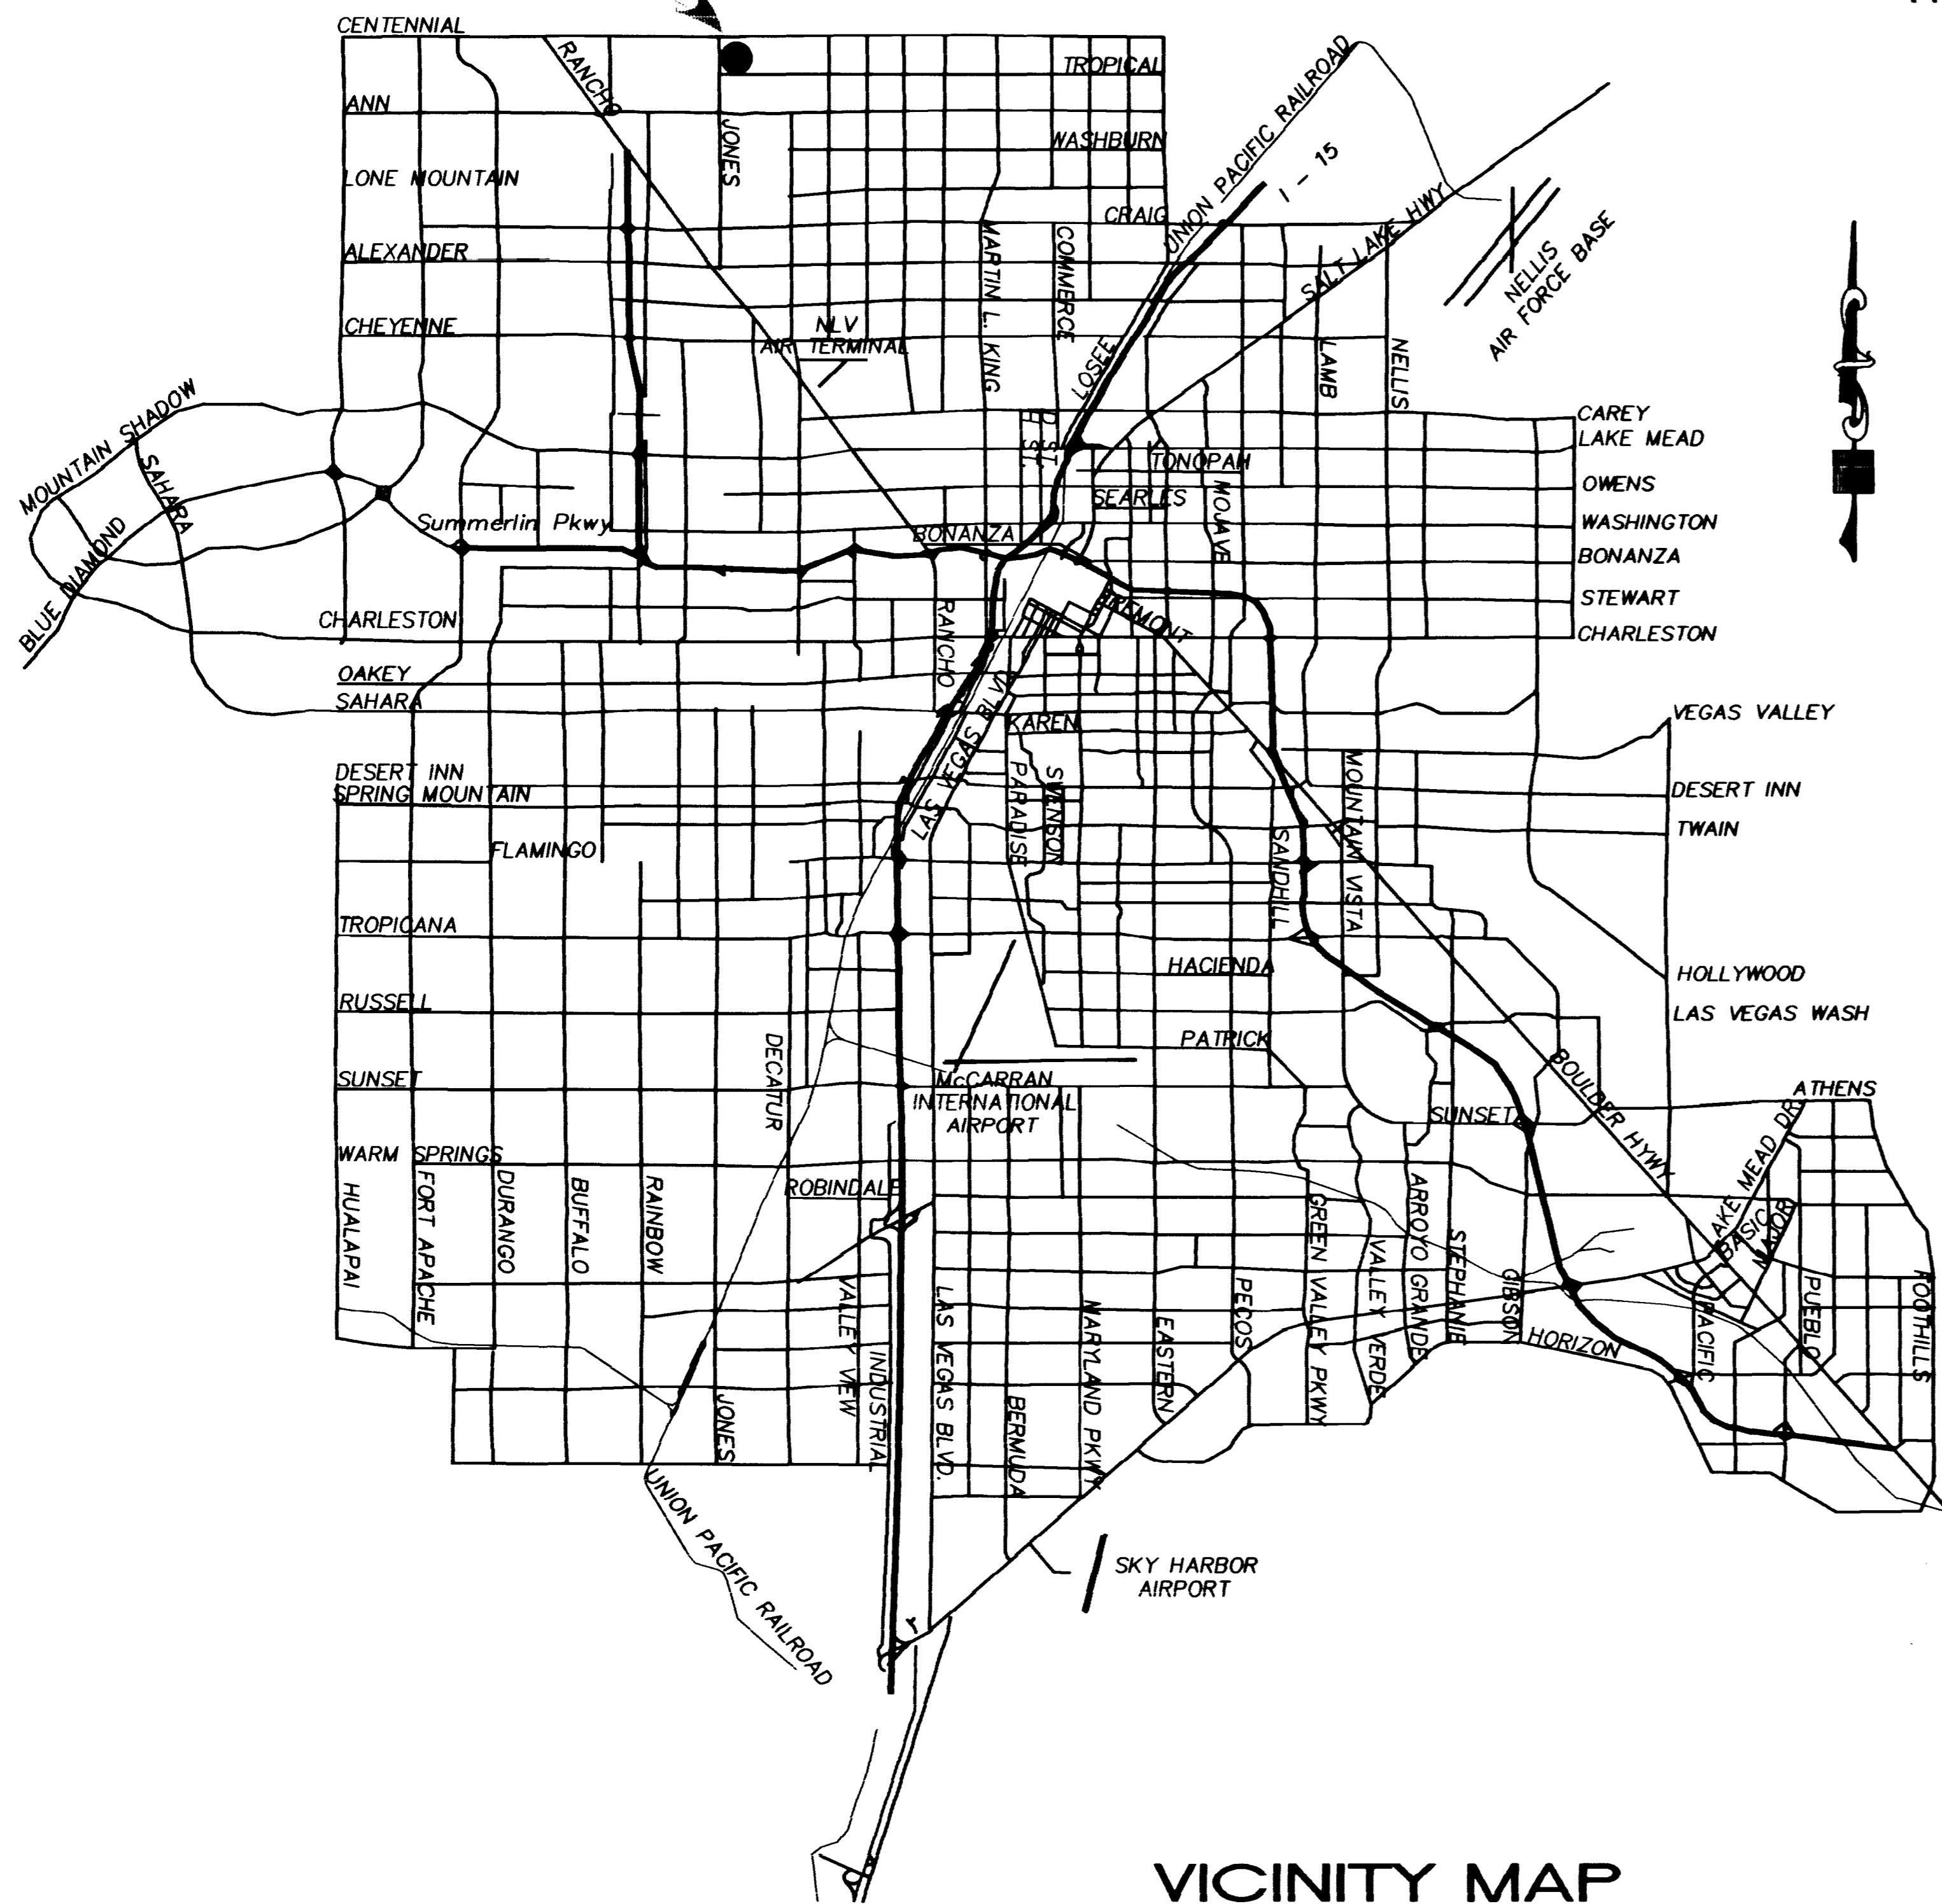

VICINITY MAP

SHEET INDEX

SHEET #	DESCRIPTION
1	C1 COVER SHEET
2	C2 VICINITY MAP SHEET
3	C3 GENERAL NOTES SHEET
4	C4 QUANTITIES AND SCHEDULE SHEET
5	HC1 HORIZONTAL CONTROL PLAN
6	HC2 HORIZONTAL CONTROL PLAN
7	HC3 HORIZONTAL CONTROL PLAN
8	UT1 UTILITY PLAN
9	UT2 UTILITY PLAN
10	UT3 UTILITY PLAN
10A	UT3A UTILITY PLAN
10AA	UT4 UTILITY PLAN
11	GR1 GRADING PLAN
12	GR2 GRADING PLAN
13	GR3 GRADING PLAN
STREET PLAN AND PROFILES	
14	PP1 JONES BOULEVARD
15	PP2 TROPICAL PARKWAY
16	PP3 TROPICAL PARKWAY
17	PP4 CALM LAGOON DR. AND FLAMING CORAL LN.
18	PP5 COCKTAIL DR., PORT OF DREAMS DR., RUM RUNNER DR.
19	PP6 RESORT RIDGE STREET
20	PP7 RESORT RIDGE STREET
21	PP8 PARADISE FALLS STREET
22	SSS STANDARD STREET SECTIONS
SANITARY SEWER PLAN AND PROFILES	
23A	SS1 TROPICAL PARKWAY
23	SS1 TROPICAL PARKWAY
24	SS2 CALM LAGOON DR. AND FLAMING CORAL LN.
25	SS3 COCKTAIL DR., PORT OF DREAMS DR., RUM RUNNER DR.
26	SS4 RESORT RIDGE STREET
27	SS5 RESORT RIDGE STREET
28	ST1 SIGNAGE, TRAFFIC AND STREET LIGHT
29	ST2 SIGNAGE, TRAFFIC AND STREET LIGHT
30	ST3 SIGNAGE, TRAFFIC AND STREET LIGHT
31	DT1 DETAIL SHEET

SYMBOLS LEGEND

SYMBOLS/LINE TYPES	TO BE CONSTRUCTED	EXISTING (SHADED 60%)
CENTERLINE		
RIGHT OF WAY		
PROPERTY LINE		
CONSTRUCTION		
CONTOUR		
CHAIN LINK FENCE		
WALL		
SEWER MAIN (12" AND SMALLER)		
SEWER MAIN (ABOVE 12")		
SEWER MAIN (ABOVE 60")		
STORM DRAIN (12" AND SMALLER)		
STORM DRAIN (ABOVE 12")		
STORM DRAIN (ABOVE 60")		
WATER MAIN (12" AND SMALLER)		
WATER MAIN (ABOVE 12")		
WATER MAIN (ABOVE 60")		
GAS		
TELEPHONE		
UNDERGROUND POWER		
OVERHEAD POWER		
STREETLIGHT CONDUIT		
TRAFFIC SIGNAL CONDUIT		
CABLE TELEVISION		
EDGE-OF-PAVEMENT		
FLOWLINE OF DITCH/CHANNEL		
CURB AND GUTTER		
SIDEWALK RAMPS		
VALLEY GUTTER		
DROP INLET		
DRIVEWAY APRON		
CUT OR FILL SLOPE		
WATER VALVE		
FIRE HYDRANT		
MONUMENT		
BUILDING		
MISC. SYMBOLS		
STUB OUT		
DIRECTION OF FLOW		
ELEVATION		
TRAFFIC SIGNAL CONTROLLER		
PULL BOX		
TRAFFIC SIGNAL LOOP DETECTORS		
AMP SERVICE POINT & METER PED.		
AMP SERVICE POINT & ROOC		
BREAK AWAY TYPE BASE		
100 W LUMINAIRE		
150 W LUMINAIRE		
200 W LUMINAIRE		
250 W LUMINAIRE		
400 W LUMINAIRE		
TRAFFIC SIGNAL POLE W/ LUMINAIRE		
TRAFFIC SIGNAL POLE		
SCHOOL FLASHER		
TRAFFIC CONTROL SIGN		
STREET NAME SIGN		
PAD ELEVATION		
NORTH ARROW		
GRAPHIC SCALE		
SECTION BUBBLE		
DETAIL BUBBLE		

<p>D. R. HORTON CUSTOM HOMES 2920 N. GREEN VALLEY PKWY. SUITE 111 HENDERSON, NV 89014 (702) 435-4888, FAX (702) 435-4990</p>		<p>HUNSAKER & ASSOCIATES PLANNING SURVEYING & ENGINEERING 401 N. BURNING DR. SUITE 100, LAS VEGAS, NEVADA 89108 (702) 248-4900</p>	
<p>VICINITY MAP AND SHEET INDEX</p>		<p>TROPICAL/JONES - UNIT 1 A.K.A. PARADISE FALLS - UNIT 1 LAS VEGAS, NEVADA</p>	
<p>QUALITY CONTROL BY: E. HORTON</p>	<p>QUALITY CONTROL BY: A. SALIDO</p>	<p>SCALE: SHOWN</p>	<p>SHEET NO. 2291-1</p>
<p>PROFESSIONAL ENGINEER STATE OF NEVADA LARRY W. HUNSAKER No. 9115</p>		<p>DRAWING NO. 107Y4592-1</p>	

P: 12291-1.LWP(VH)12291-C2.DWG Thu Feb 25 06:16:17 1999 SALCIDO

