



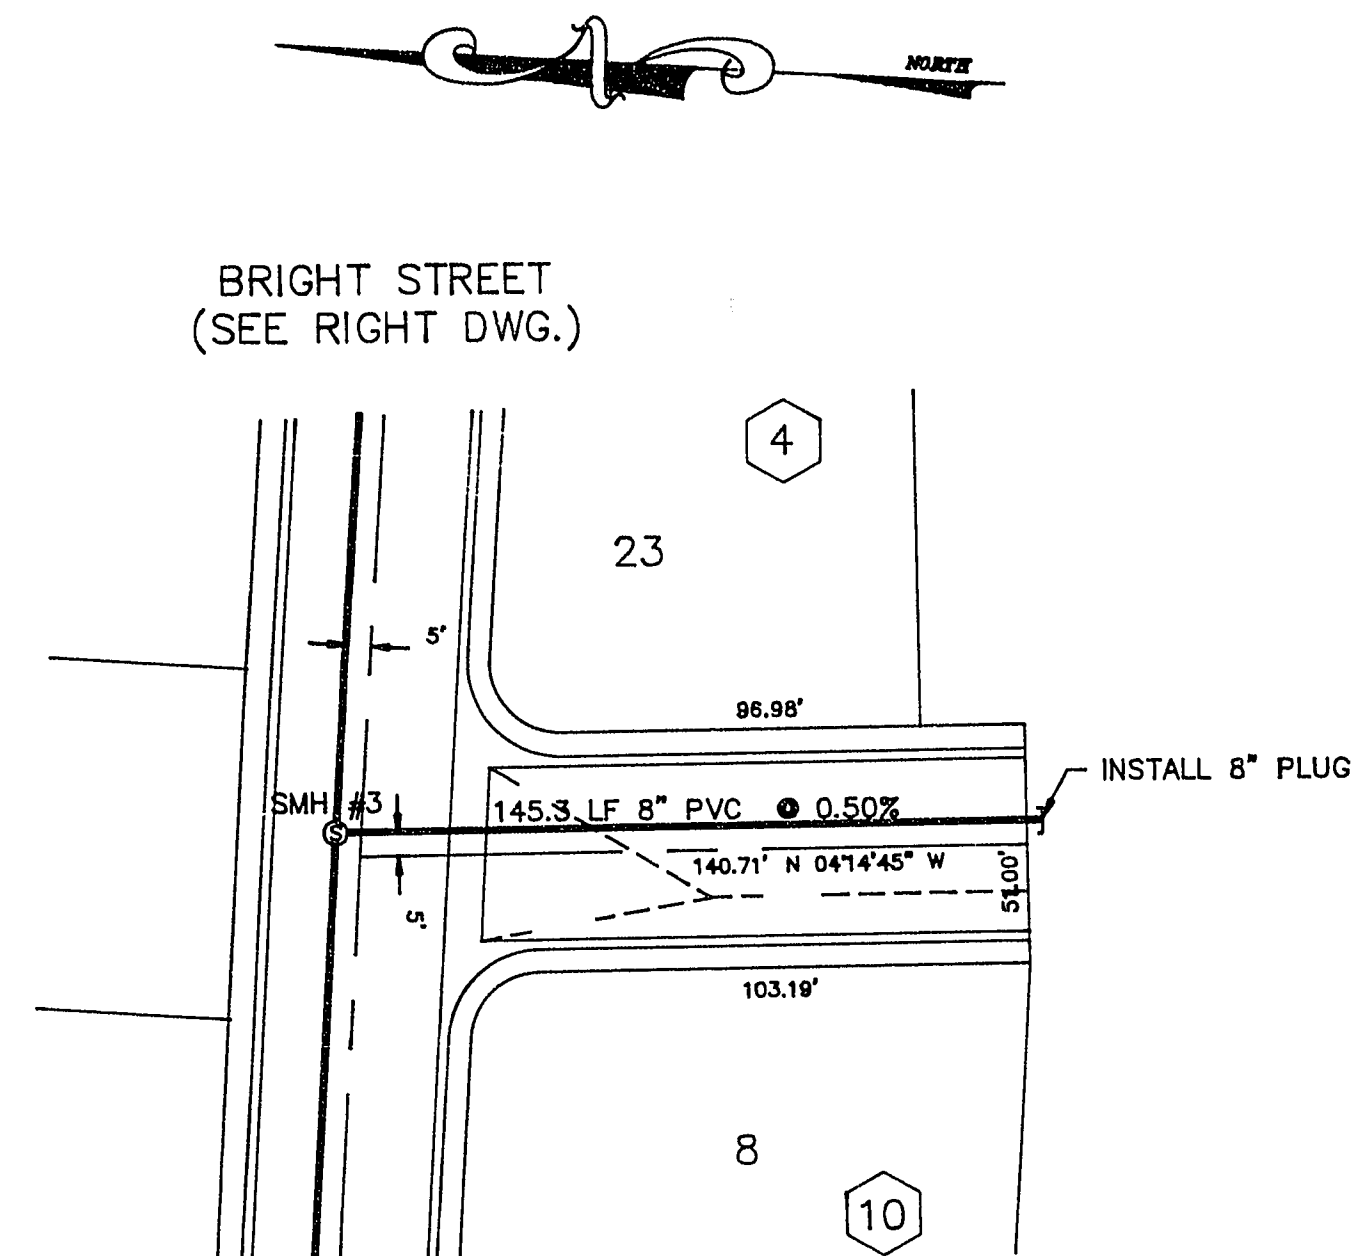

GLADIOLA DRIVE

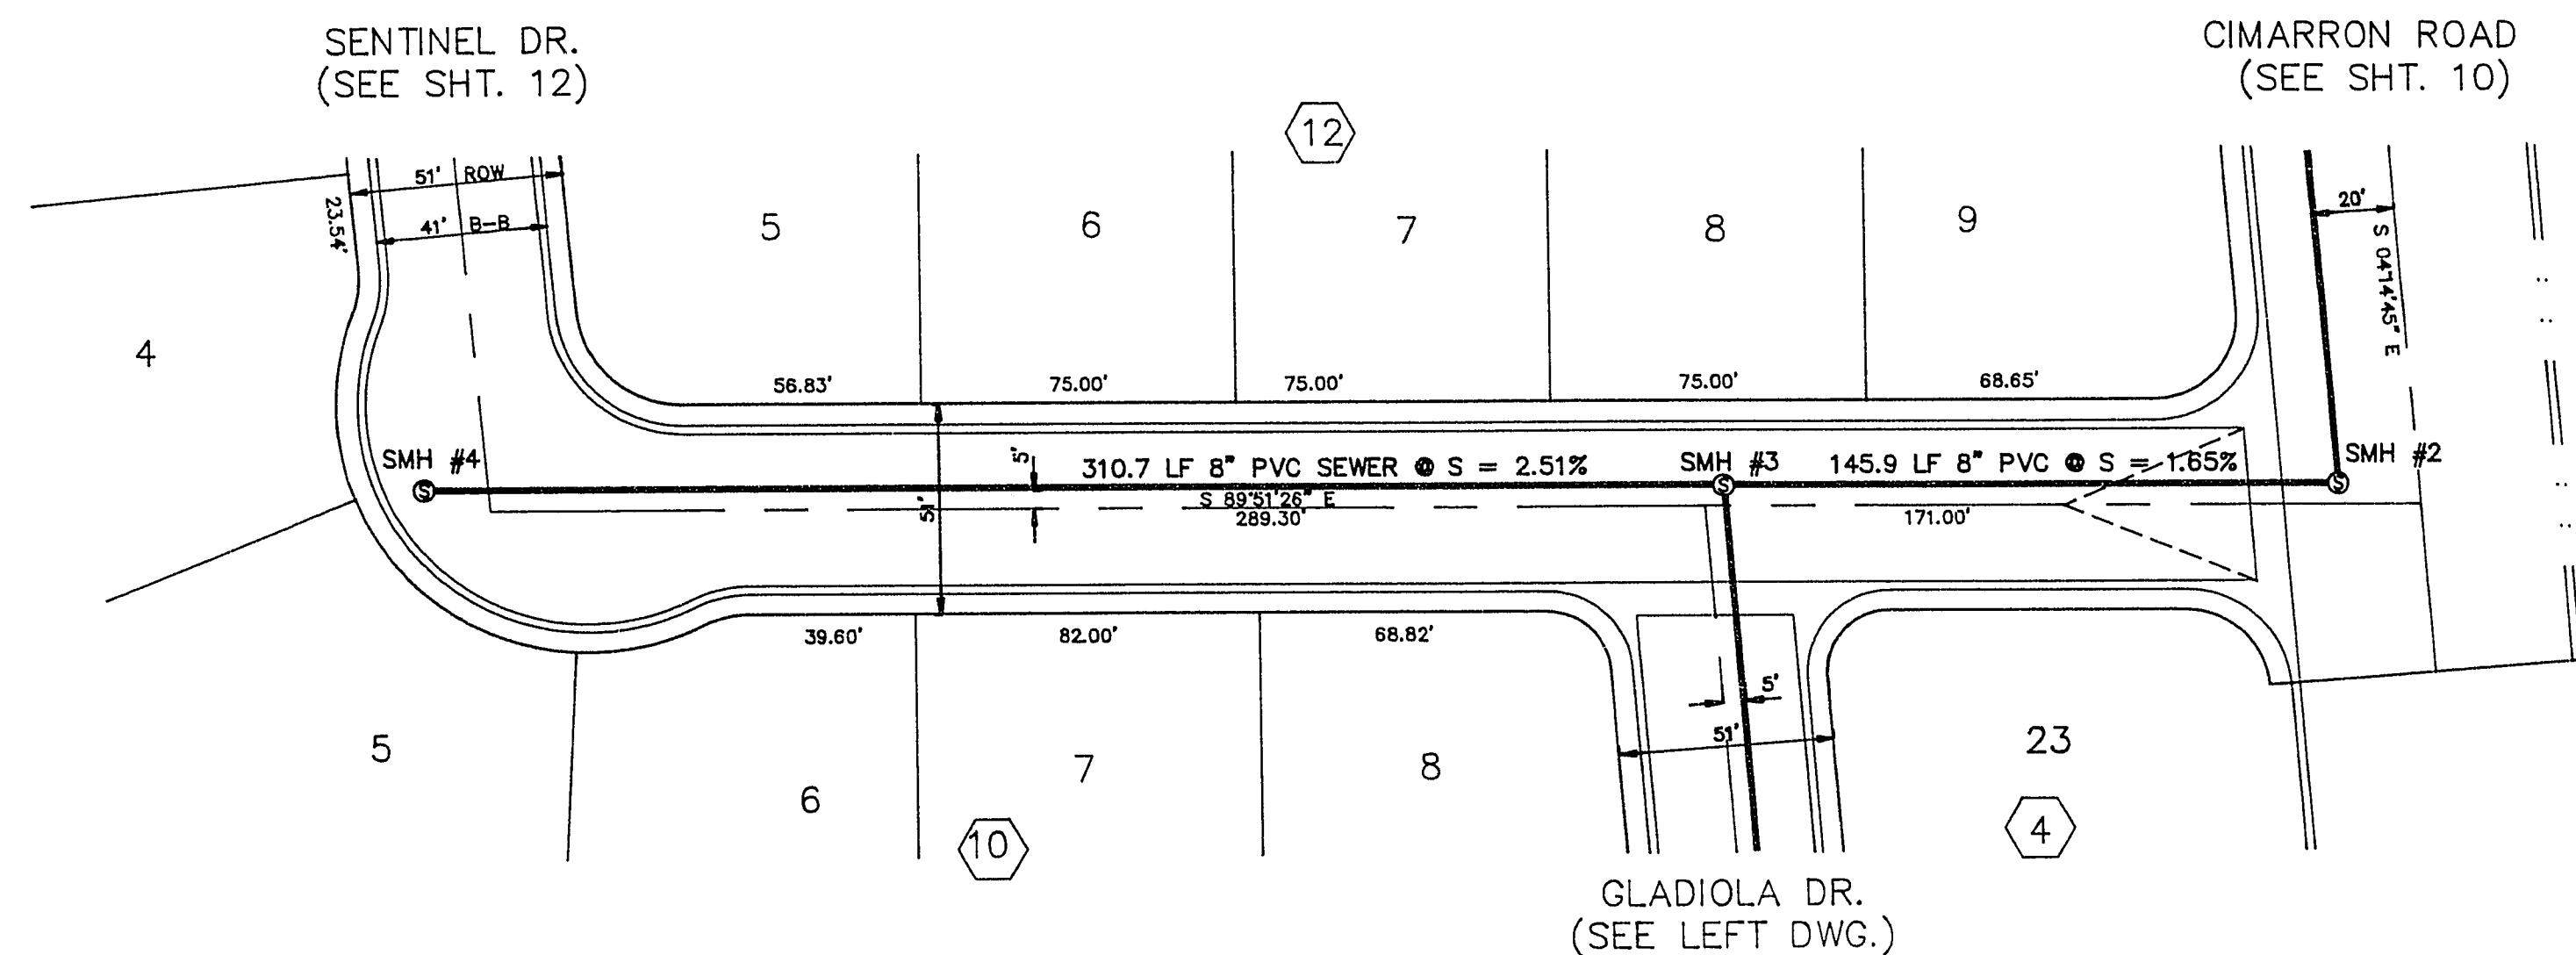


BRIGHT STREET


TYPICAL WATER/SEWER CROSSING

THE FOLLOWING ARE THE REQUIREMENTS THAT MUST BE MET WHEN THERE IS A WATER-SEWER CROSSING:

WHEN PROTECTION OF THE WATERLINE IS CONSIDERED, A MINIMUM VERTICAL DISTANCE OF 18 INCHES MUST BE MAINTAINED WHEN THE WATER LINE IS INSTALLED OVER THE SEWER/STORM LINE. IF THIS DISTANCE CANNOT BE MAINTAINED BECAUSE OF PHYSICAL OBSTRUCTIONS OR THE WATERLINE MUST BE PLACED UNDER THE SEWER/STORM LINE, THE SEWER/STORM LINE MUST BE ENCASED WITH A MINIMUM OF 4\"/>

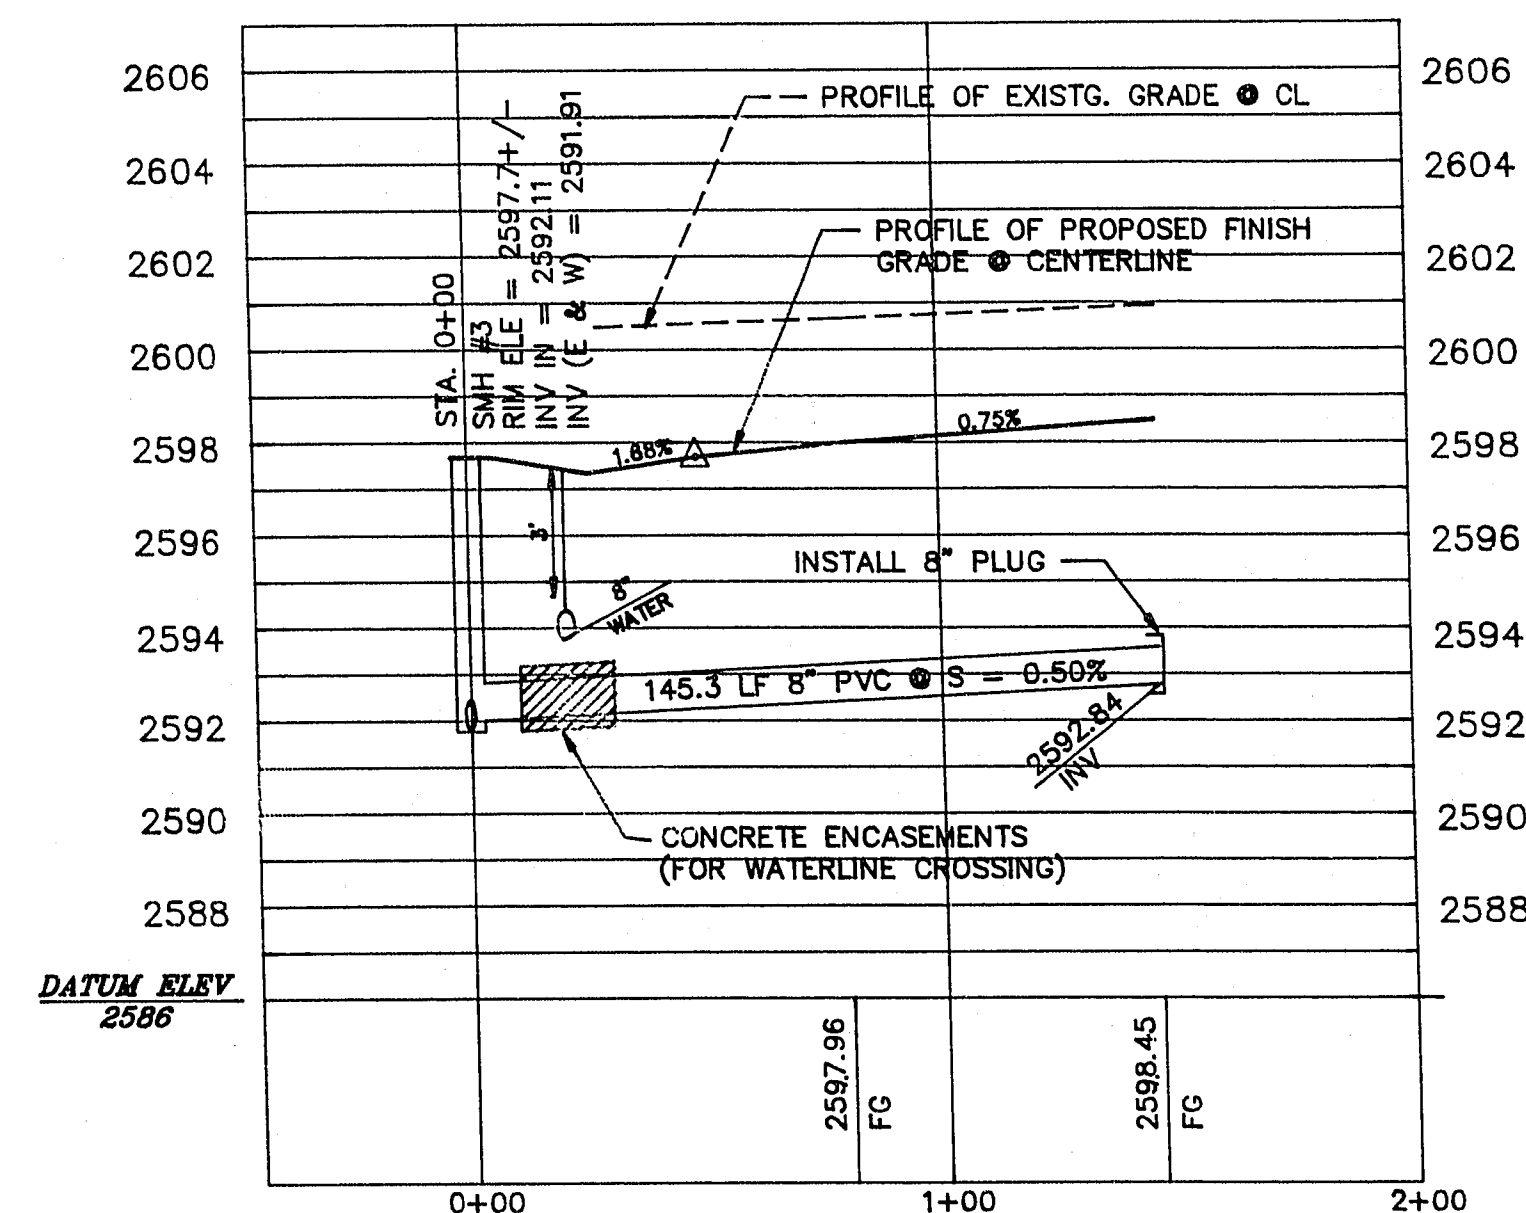

HORIZONTAL: 1" = 40'
VERTICAL: 1" = 4'

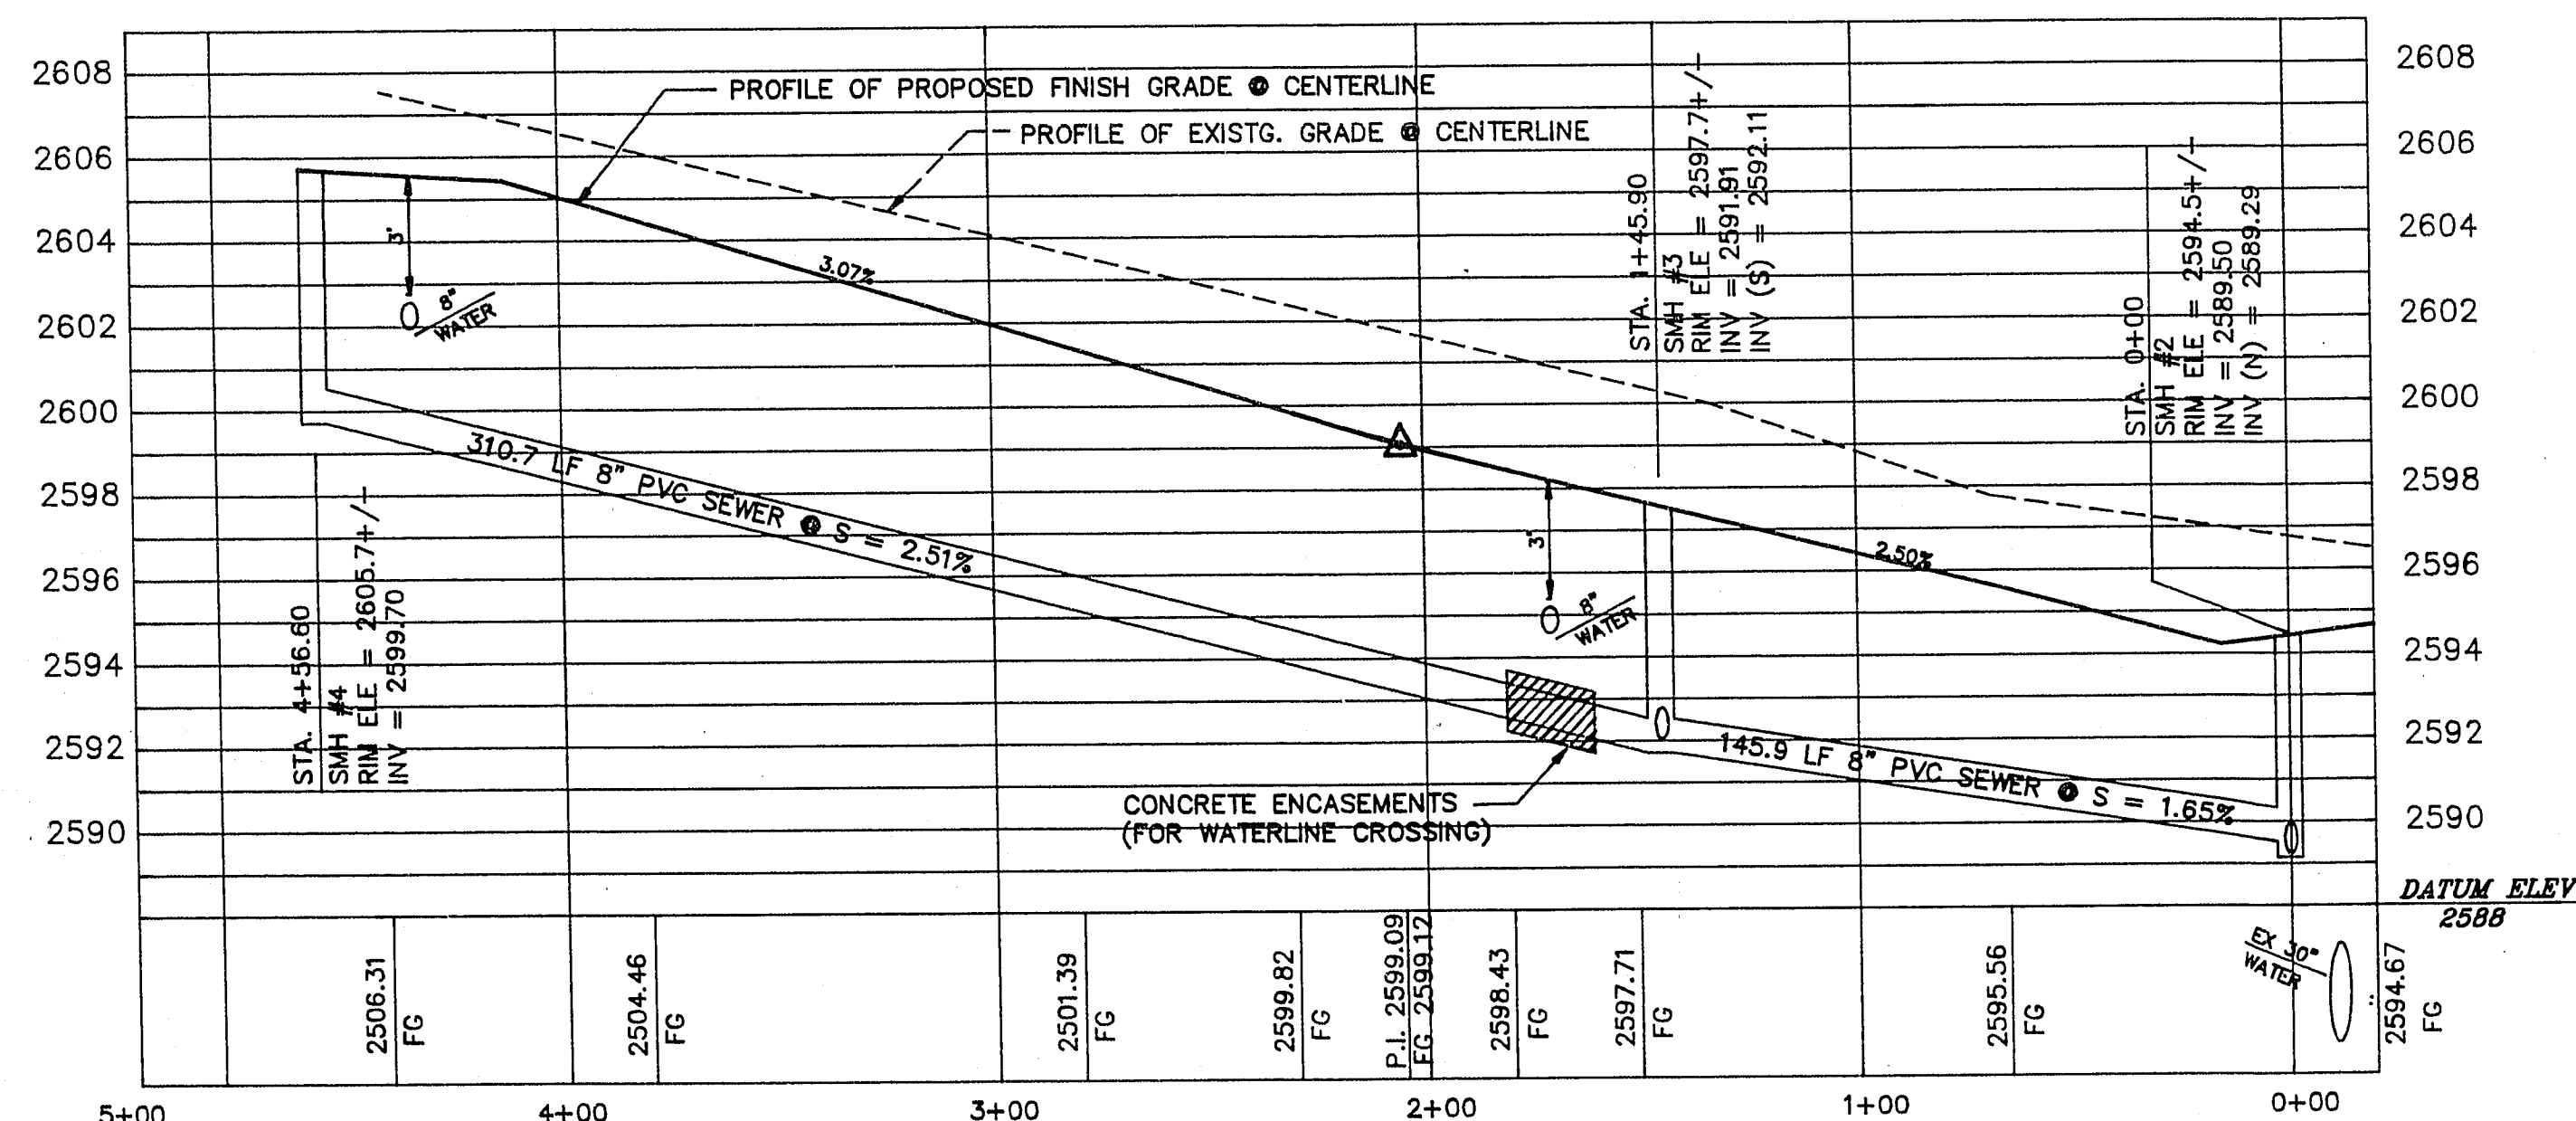

CASHIDAN
844 EAST SAHARA
LAS VEGAS, NEVADA 89104
(702) 735-7895
FAX (702) 735-6862
LAND SURVEYING
CIVIL ENGINEERING
STRUCTURAL ENGINEERING
FORENSIC ENGINEERING

VALLEY WEST XI - PHASE 4
LAS VEGAS, NEVADA
SEWER PLAN AND PROFILE
GLADIOLA DR/ BRIGHT ST.

PROJECT TITLE

APPROVAL

REVISION

DATE

NO.

DATE
JULY 26, 1991
JOB NO.
91-818
SCALE
1" = 40'
DRAWN
R.O.A./
DESIGNED
C.O.S.
CHECKED
E.J.F.
SHEET

13 OF 16

307Y-3/70-XI-4

29-8-40