


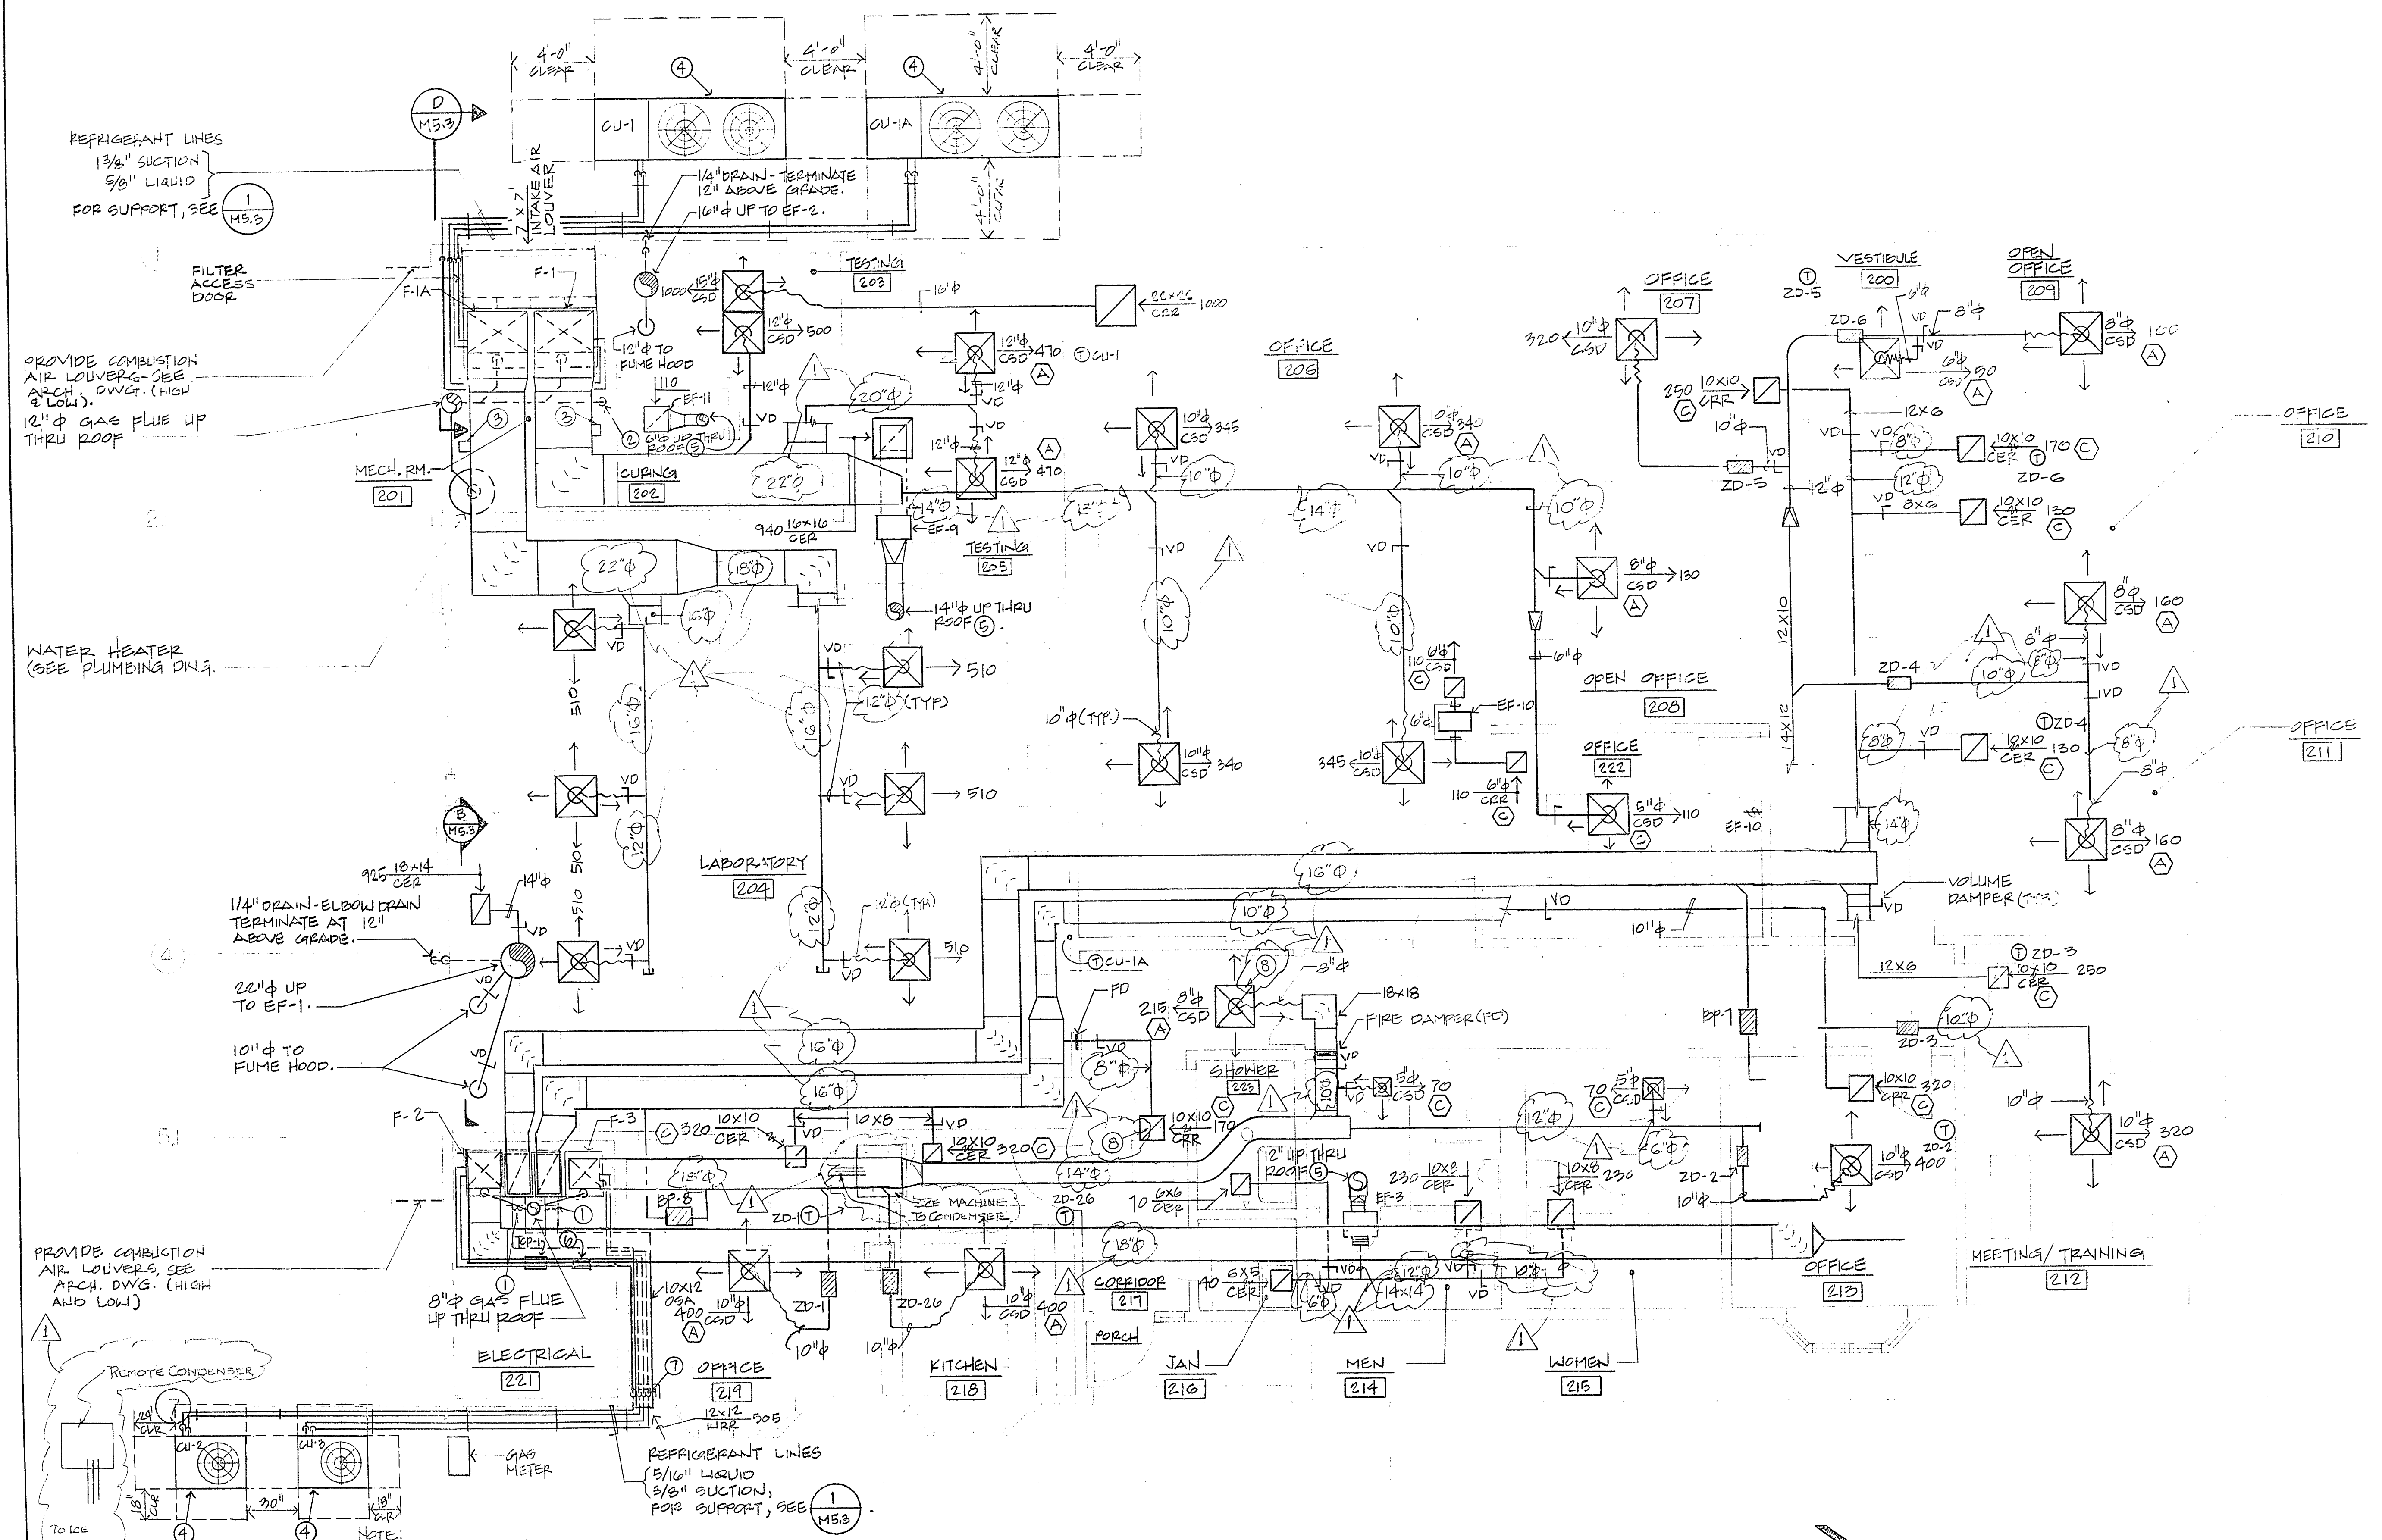

REFRIGERANT LINES
1 3/8" SUCTION
5/8" LIQUID
FOR SUPPORT, SEE
MS.3

PROVIDE COMBUSTION
AIR LOUVER-SEE
ARCH. DWG. (HIGH
& LOW).
12" Ø GAS FLUE UP
THRU ROOF

WATER HEATER
(SEE PLUMBING DWG.)

1/4" DRAIN-ELBOW DRAIN
TERMINATE AT 12"
ABOVE GRADE.
22" Ø UP
TO EF-1.
10" Ø TO
FUME HOOD.

PROVIDE COMBUSTION
AIR LOUVER-SEE
ARCH. DWG. (HIGH
AND LOW)

REMOTE CONDENSER
TO ICE
MACHINE

- NOTE:
- 10"X10" OUTSIDE AIR DUCT W/ 25.0 SEE SECTION A FOR SIMILAR ARRANGEMENT MS.3
 - 3/4" DRAIN - TERMINATE TO FLOOR DRAIN
 - DUCT SMOKE DETECTOR
 - CONDENSING UNIT MOUNTED ON 6" HIGH CONCRETE CURB.
 - TERMINATE ABOVE ROOF WITH ROOF CAP.
 - (2) COMFORT MANAGER W/ 24V TRANSFORMERS
 - REFRIGERANT LINES IN PUPPED OUT WALL.
 - INSTALL CEILING FIRE DAMPER RUSKIN 180 OR APPROVED EQ. REFER TO 1/A.1.

FLOOR PLAN
SCALE: 1/4" = 1'-0"

POGEMEYER DESIGN GROUP ENGINEERS PLANNERS SURVEYORS 1140 ALMOND TREE LANE, SUITE 306 LAS VEGAS, NEVADA 89104 (702) 735-5108	
FLOOR PLAN WEST SERVICE CENTER PHASE 1 QUALITY CONTROL Kennedy Jenks Consultants Architectural Division	JOB NUMBER 91012 DESIGNED BY M21 DRAWN BY RB CHECKED BY WT DATE 01.18.93 SHEET NUMBER 51 of 78 M2.1 OF



CHAMBERLAIN/PAINTER, INC.
Consulting Engineers
657 Mission St. 415 982-1833
SAN FRANCISCO, CALIF. 94105