



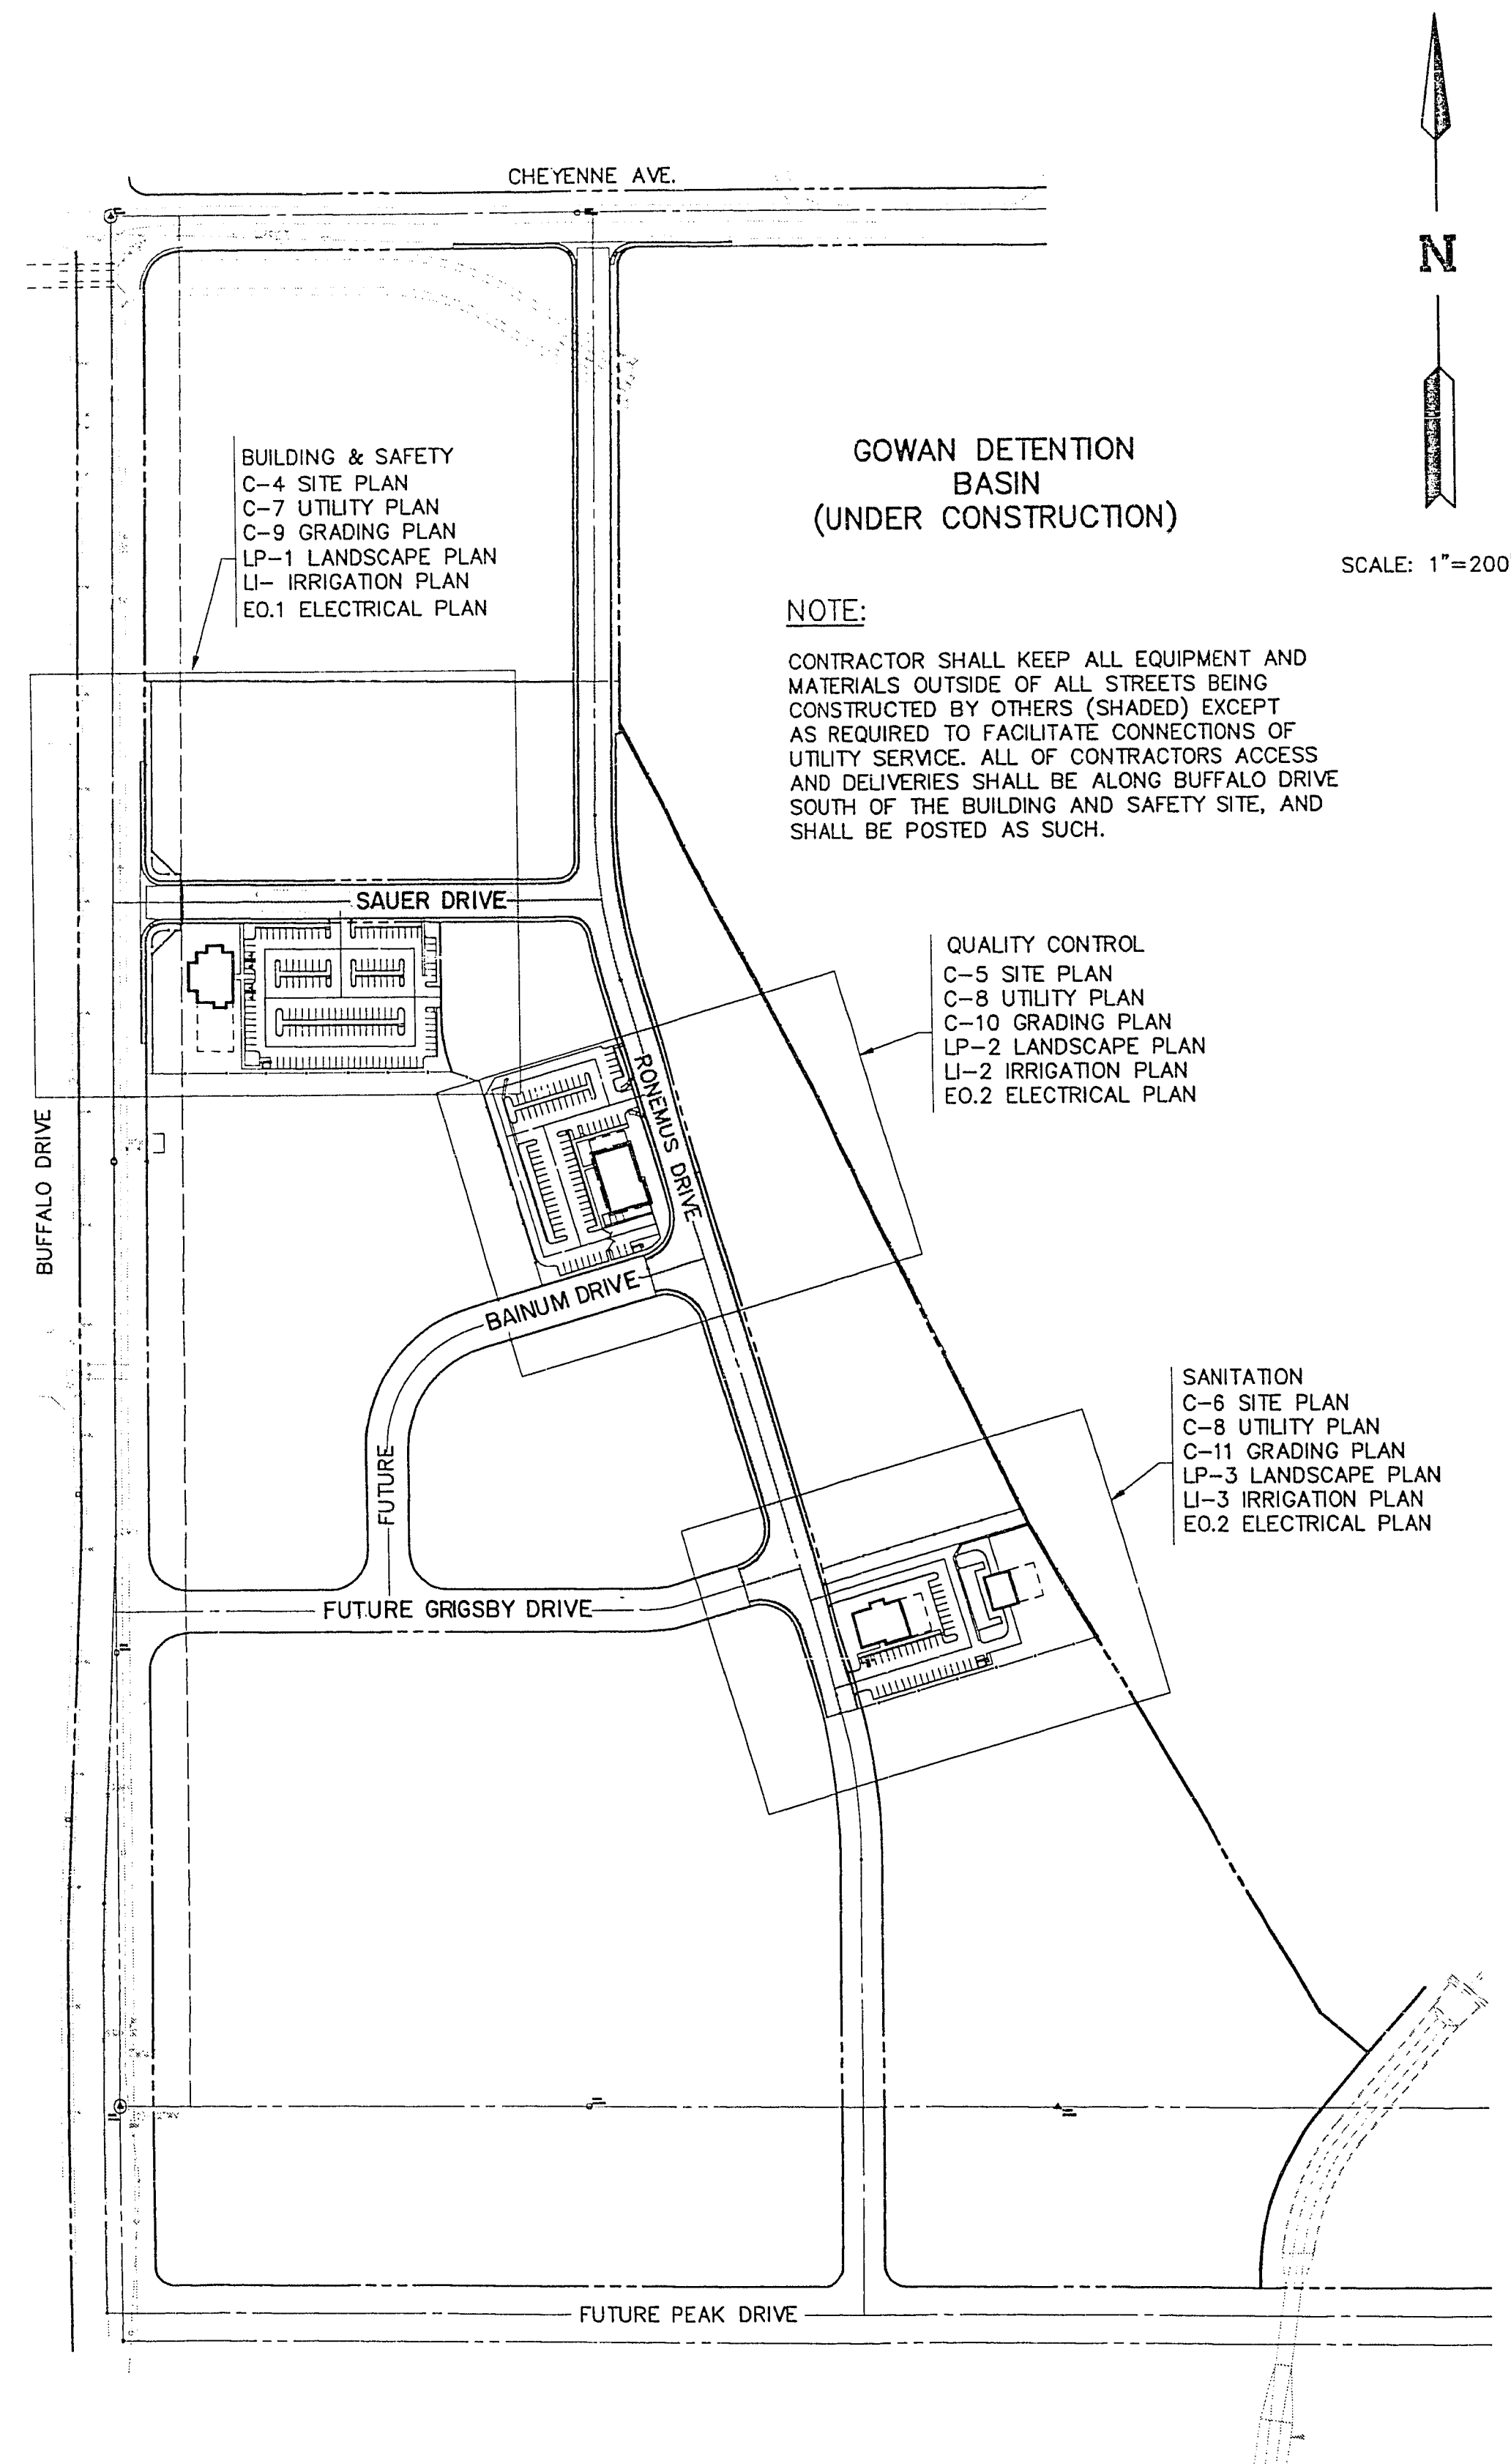

SHEET INDEX

C-1	COVER SHEET
C-2	GENERAL NOTES
C-3	INDEX SHEET
C-4	SITE PLAN BUILDING & SAFETY
C-5	SITE PLAN QUALITY CONTROL
C-6	SITE PLAN SANITATION
C-7	UTILITY PLAN BUILDING & SAFETY
C-8	UTILITY PLAN QUALITY CONTROL & SANITATION
C-9	GRADING PLAN BUILDING & SAFETY
C-10	GRADING PLAN QUALITY CONTROL
C-11	GRADING PLAN SANITATION
C-12	DETAIL SHEET
LP-1	LANDSCAPING BUILDING & SAFETY
LP-2	LANDSCAPING QUALITY CONTROL
LP-3	LANDSCAPING SANITATION
LP-4	DETAILS
LI-1	IRRIGATION BUILDING & SAFETY
LI-2	IRRIGATION QUALITY CONTROL
LI-3	IRRIGATION SANITATION
LI-4	IRRIGATION DETAILS
A1.1	FLOOR PLAN BUILDING & SAFETY
A1.2	ROOF PLAN, CEILING PLAN
A1.3	EXTERIOR ELEVATIONS
A1.4	INTERIOR ELEVATIONS
A2.1	FLOOR PLAN QUALITY CONTROL
A2.2	ROOF PLAN & CEILING PLAN
A2.3	EXTERIOR ELEVATIONS
A2.4	INTERIOR ELEVATIONS
A3.1	FLOOR PLAN SANITATION SITE
A3.2	ROOF PLAN, CEILING PLAN & SECTIONS
A3.3	EXTERIOR ELEVATIONS
A3.4	INTERIOR ELEVATIONS
A5.1	FINISH SCHEDULES
A6.1	DOOR SCHEDULES & DETAILS
A7.1	DETAILS
A7.2	WINDOW SCHEDULES & DETAILS
A7.3	DETAILS
A4.1	FLOOR PLAN SANT. STORAGE
S-0	STRUCTURAL NOTES
S1.1	FOUNDATION PLAN BUILDING & SAFETY
S2.1	FOUNDATION PLAN QUALITY CONTROL
S2.2	FRAMING PLAN QUALITY CONTROL
S3.1	FOUNDATION PLAN SANITATION
S3.2	FRAMING PLAN SANITATION
S4.1	FND. & FRMG. PLAN-SAN. STOR. BLDG.
S1.2	FRAMING PLAN BUILDING & SAFETY
S5.1-3	DETAILS
M1.1	FLOOR PLAN BUILDING & SAFETY
M2.1	FLOOR PLAN QUALITY CONTROL
M3.1	FLOOR PLAN SANITATION
M4.1	FLOOR PLAN SANITATION STORAGE
M5.1	SYMBOLS SCHEDULES & DETAILS
M5.2	SCHEDULES
M5.3	SECTIONS & DETAILS
P0.1	SITE PLANS QUALITY CONTROL & SANITATION
P0.2	SITE PLANS BUILDING & SAFETY
P1.1	FLOOR PLAN BUILDING & SAFETY
P2.1	FLOOR PLAN QUALITY CONTROL
P3.1	FLOOR PLAN SANITATION BLDG.
P4.1	FLOOR PLAN SANITATION STORAGE
P5.1	SYMBOLS SCHEDULES NOTES & DETAILS
E0.1	SITE PLAN BUILDING & SAFETY
E0.2	SITE PLAN QUALITY CONTROL & SANITATION
E1.1	FLOOR PLAN LIGHTING BUILDING & SAFETY
E1.2	FLOOR PLAN POWER/SIGNAL
E2.1	FLOOR PLAN LIGHTING QUALITY CONTROL
E2.2	FLOOR PLAN POWER/SIGNAL
E3.1	FLOOR LIGHTING - SANITATION BLDG.
E4.1	FLOOR PLAN SANITATION STORAGE
E5.1	SYMBOLS & NOTES
E5.2	FIXTURE SCHEDULE/DETAILS
E5.3	ONE LINE DIAGRAMS
E5.4	DETAILS
E5.5	PANELS SCHEDULES
E5.6	PANELS SCHEDULES
E3.2	FLOOR PLAN POWER SIGNAL SANT.

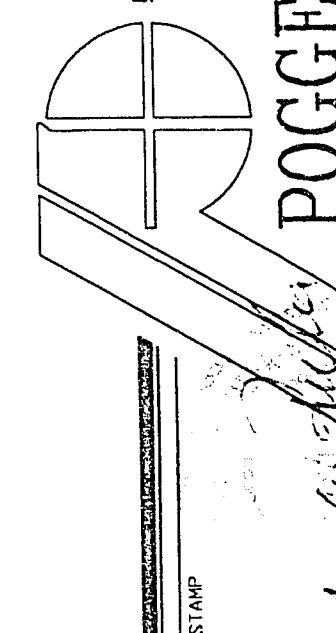

POGGEMEYER DESIGN GROUP
ENGINEERS PLANNERS SURVEYORS
1140 ALMOND TREE LANE, SUITE 305 LAS VEGAS, NEVADA 89104 (702) 735-5103

INDEX SHEET
WEST SERVICE CENTER
PHASE 1

JOB NUMBER	91012
DESIGNED BY	GP
DRAWN BY	EC
CHECKED BY	TP
DATE	8-7-92

SHEET NUMBER	3 of 78
C-3	
	3 of 12

AS-BUILT

DRAWING NO. 522-V52