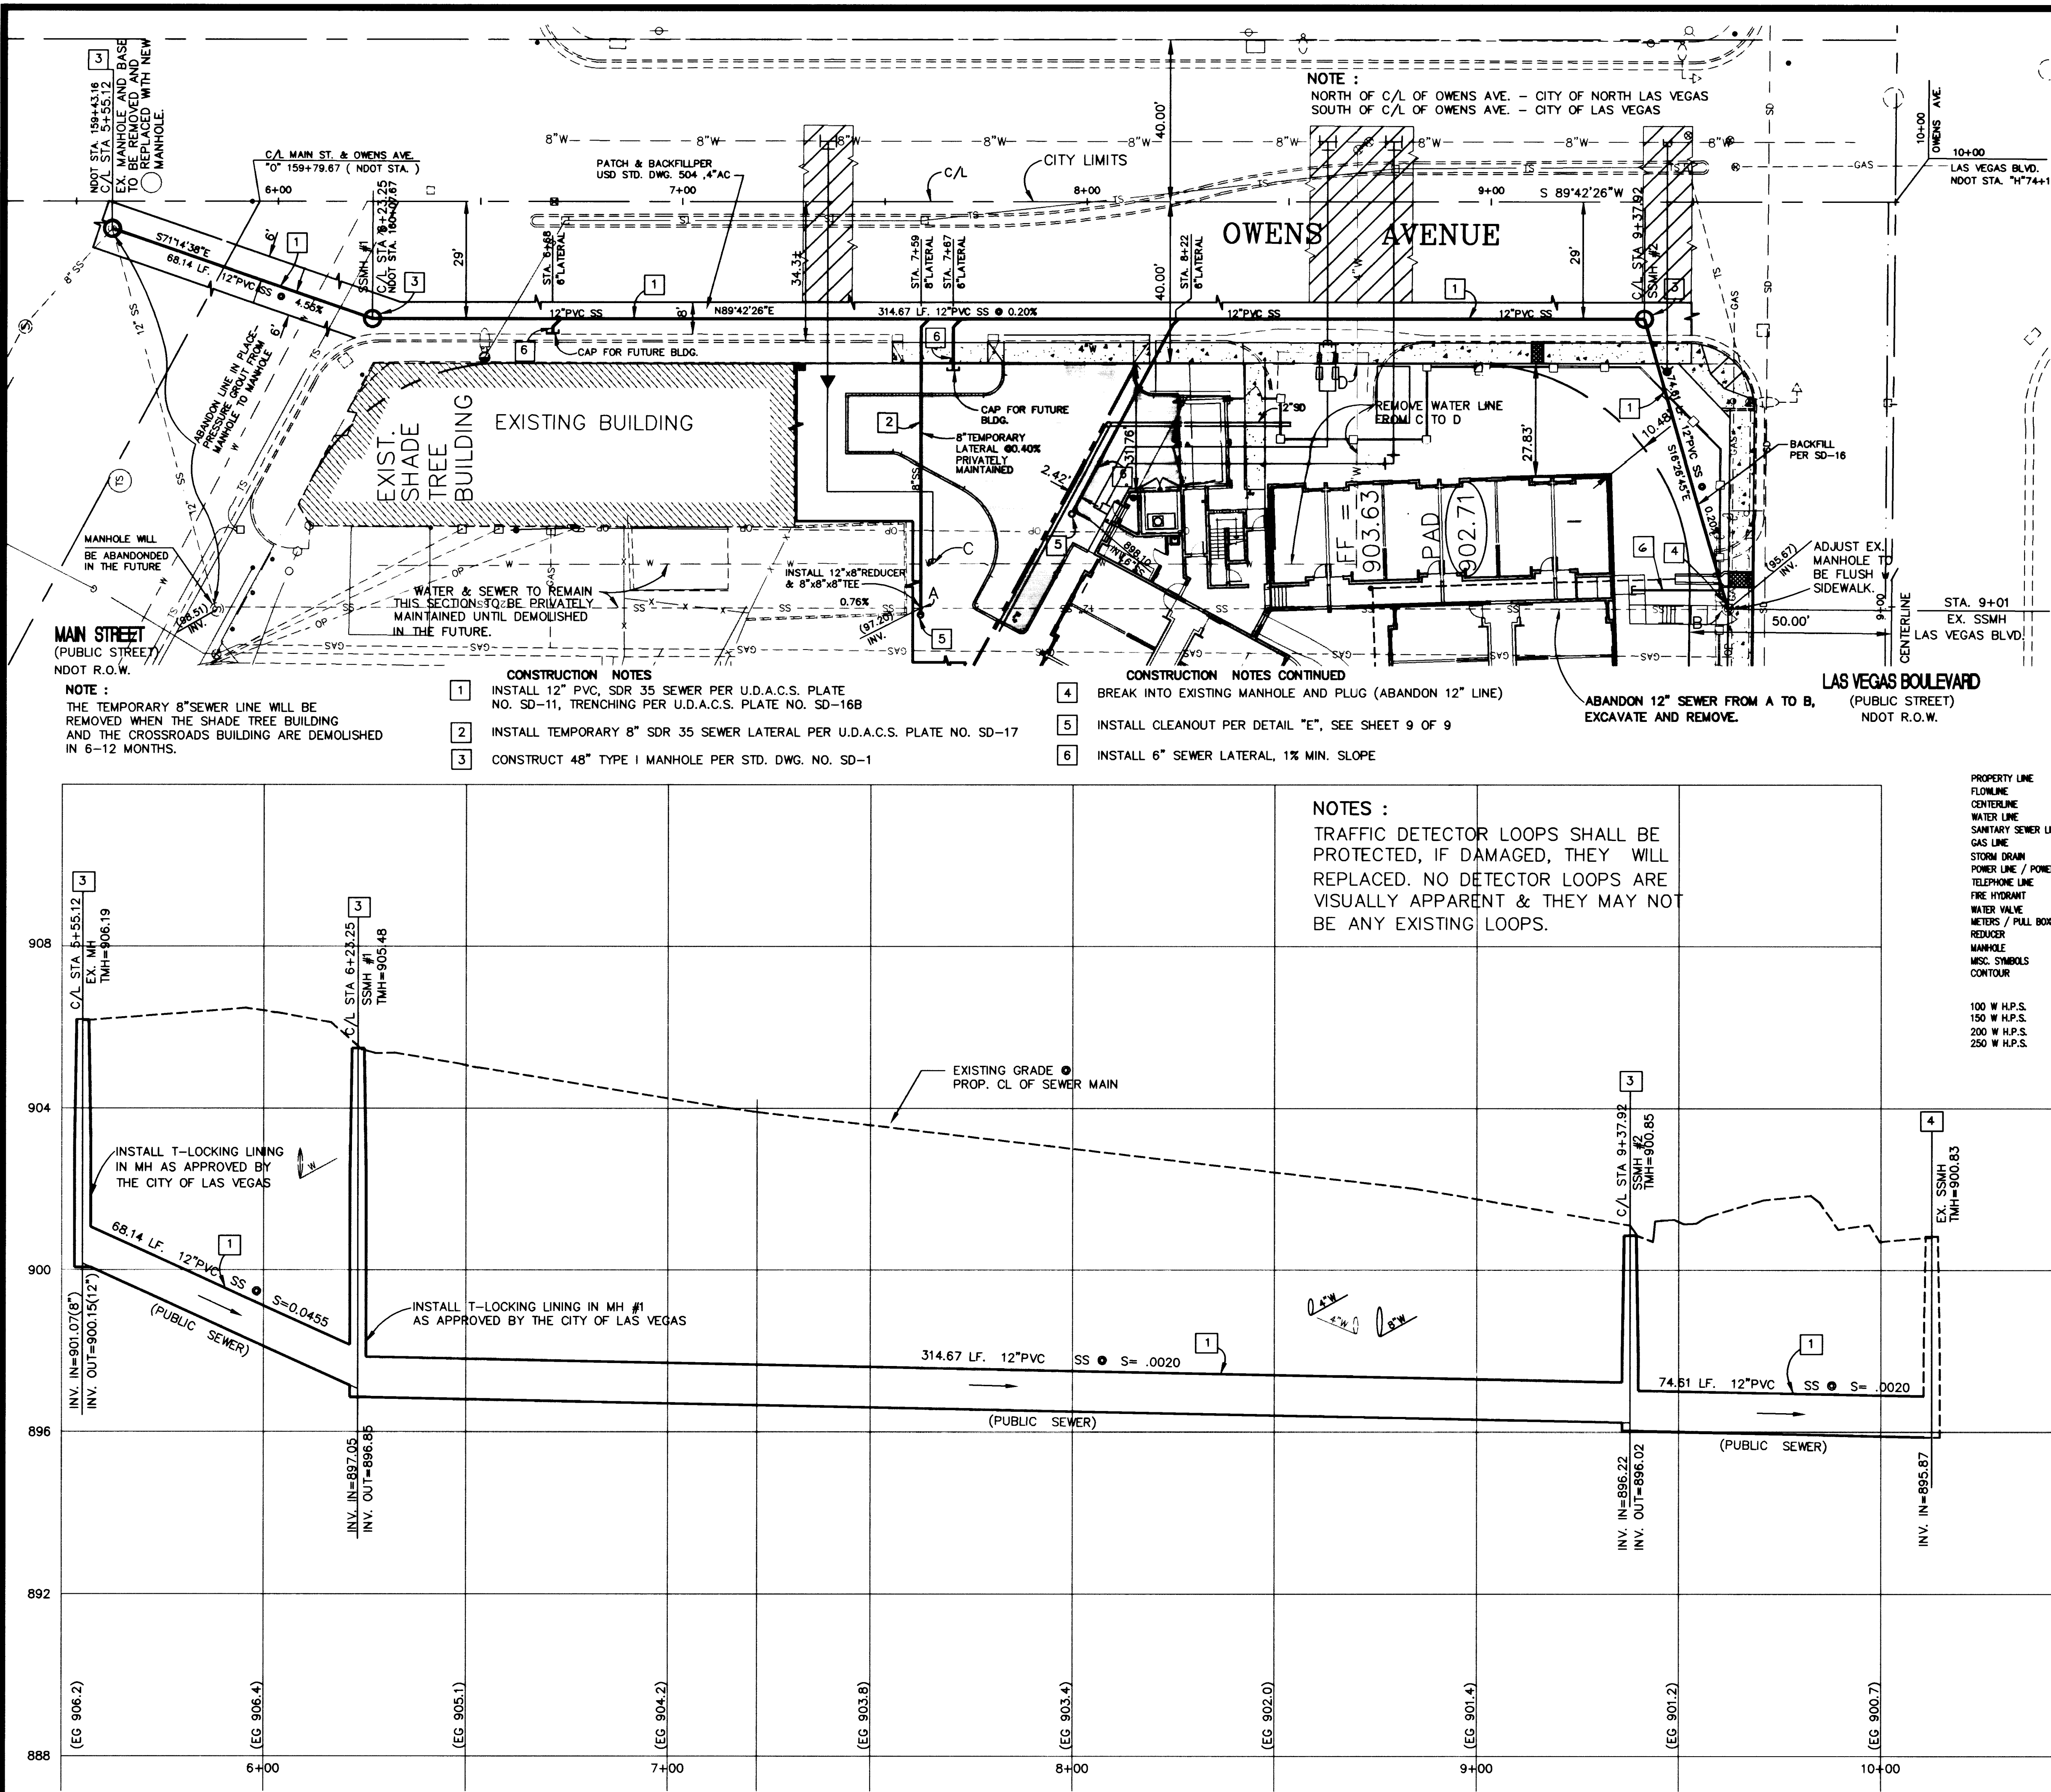


BASIS OF BEARINGS

S 00°10'16"W BEING THE CENTERLINE OF LAS VEGAS BOULEVARD AS PER RECORD OF SURVEY FILE 67, PAGE 24, CLARK COUNTY RECORDER'S OFF, CLARK COUNTY, NEVADA

BENCHMARK

2LV01 22SSE6 BEING A RIVET & PLATE IN TOP OF CURB, NE RETURN OWENS AVE. AND MAIN STREET.

ELEV. 1904.91'(580.62 METERS) NAVD88

AVOID CUTTING UNDERGROUND UTILITY LINES. IT'S COSTLY.
Call before you Dig- 1-800-227-2600
UNDERGROUND SERVICE ALERT (U.S.A.)

AVOID OVERHEAD POWER LINE CONTACT
Call before you OVERHEAD 1-702-593-6111
NEVADA POWER ENVIRONMENT AND SAFETY SERVICES DEPARTMENT

MARTIN & MARTIN ASSUMES NO RESPONSIBILITY FOR EXISTING UTILITY LOCATIONS AND ELEVATIONS. THE UTILITIES SHOWN ON THIS DRAWING HAVE BEEN PLOTTED FROM THE BEST AVAILABLE INFORMATION. IT IS, HOWEVER, THE CONTRACTOR'S RESPONSIBILITY TO FIELD VERIFY THE LOCATION AND ELEVATION OF ALL UTILITIES PRIOR TO THE COMMENCEMENT OF ANY CONSTRUCTION. CONTRACTOR TO FIELD VERIFY ALL EXISTING SITE CONDITIONS PRIOR TO CONSTRUCTION. IF A CONFLICT EXISTS BETWEEN WHAT IS SHOWN ON THESE DRAWINGS AND WHAT EXISTS IN THE FIELD, THE CONTRACTOR IS TO NOTIFY THE ARCHITECT OR ENGINEER IMMEDIATELY.

LEGEND

TO BE CONSTRUCTED	EXISTING	TO BE CONSTRUCTED	EXISTING
PROPERTY LINE	---	SCREEN / RETAINING WALL	N/A
FLOWLINE	---	OVERHEAD POWER	N/A
CENTERLINE	---	TRAFFIC SIGNAL BOX	N/A
WATER LINE	---	GRADE BREAK	N/A
SANITARY SEWER LINE	---	WIRE FENCE	N/A
GAS LINE	---	FINISH FLOOR	FF=0.00
STORM DRAIN	---	BUILDING	
POWER LINE / POWER POLE	---	FINISH GRADE	
TELEPHONE LINE	---	DRIVEWAY APRON	
FIRE HYDRANT		CUT OR FILL SLOPE	
WATER VALVE		A.C. PAVING	
METERS / PULL BOXES		TYPE "1" CURB & GUTTER	
REDUCER		TYPE "A" CURB	
MANHOLE		CONCRETE	
MISC. SYMBOLS		STUB OUT	
CONTOUR			

100 W.H.P.S.
150 W.H.P.S.
200 W.H.P.S.
250 W.H.P.S.

ST. VINCENT'S HELP.
808 SOUTH MAIN STREET
LAS VEGAS, NEVADA 89101
(702) 385-2862

MARTIN & MARTIN
1909 SOUTH JONES BLVD., SUITE B
LAS VEGAS, NEVADA 89102
PHONE (702) 248-8000 FAX (702) 248-8070

SAINT VINCENT'S H.E.I.P. ONE & TWO HOUSING UNITS

SEWER PLAN AND PROFILE OWENS STREET

DESIGNED BY: E. WIRREY
CHECKED BY: K. ANDERSON
PROJECT NO.: 1609.01

DATE: 12/16/97
DATE: 12/16/97
DATE: 12/17/97

SCALE: 1" = 20' HOR

SHEET 7 OF 8 SHEETS
C.L.V. DRAWING NO. 107V2848

7-15-98

