
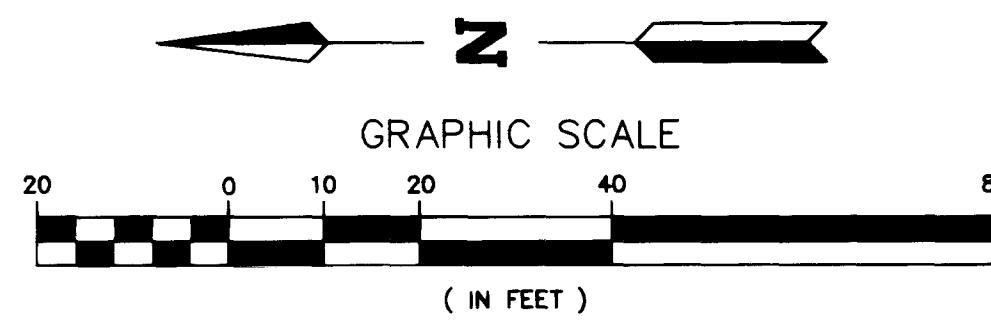


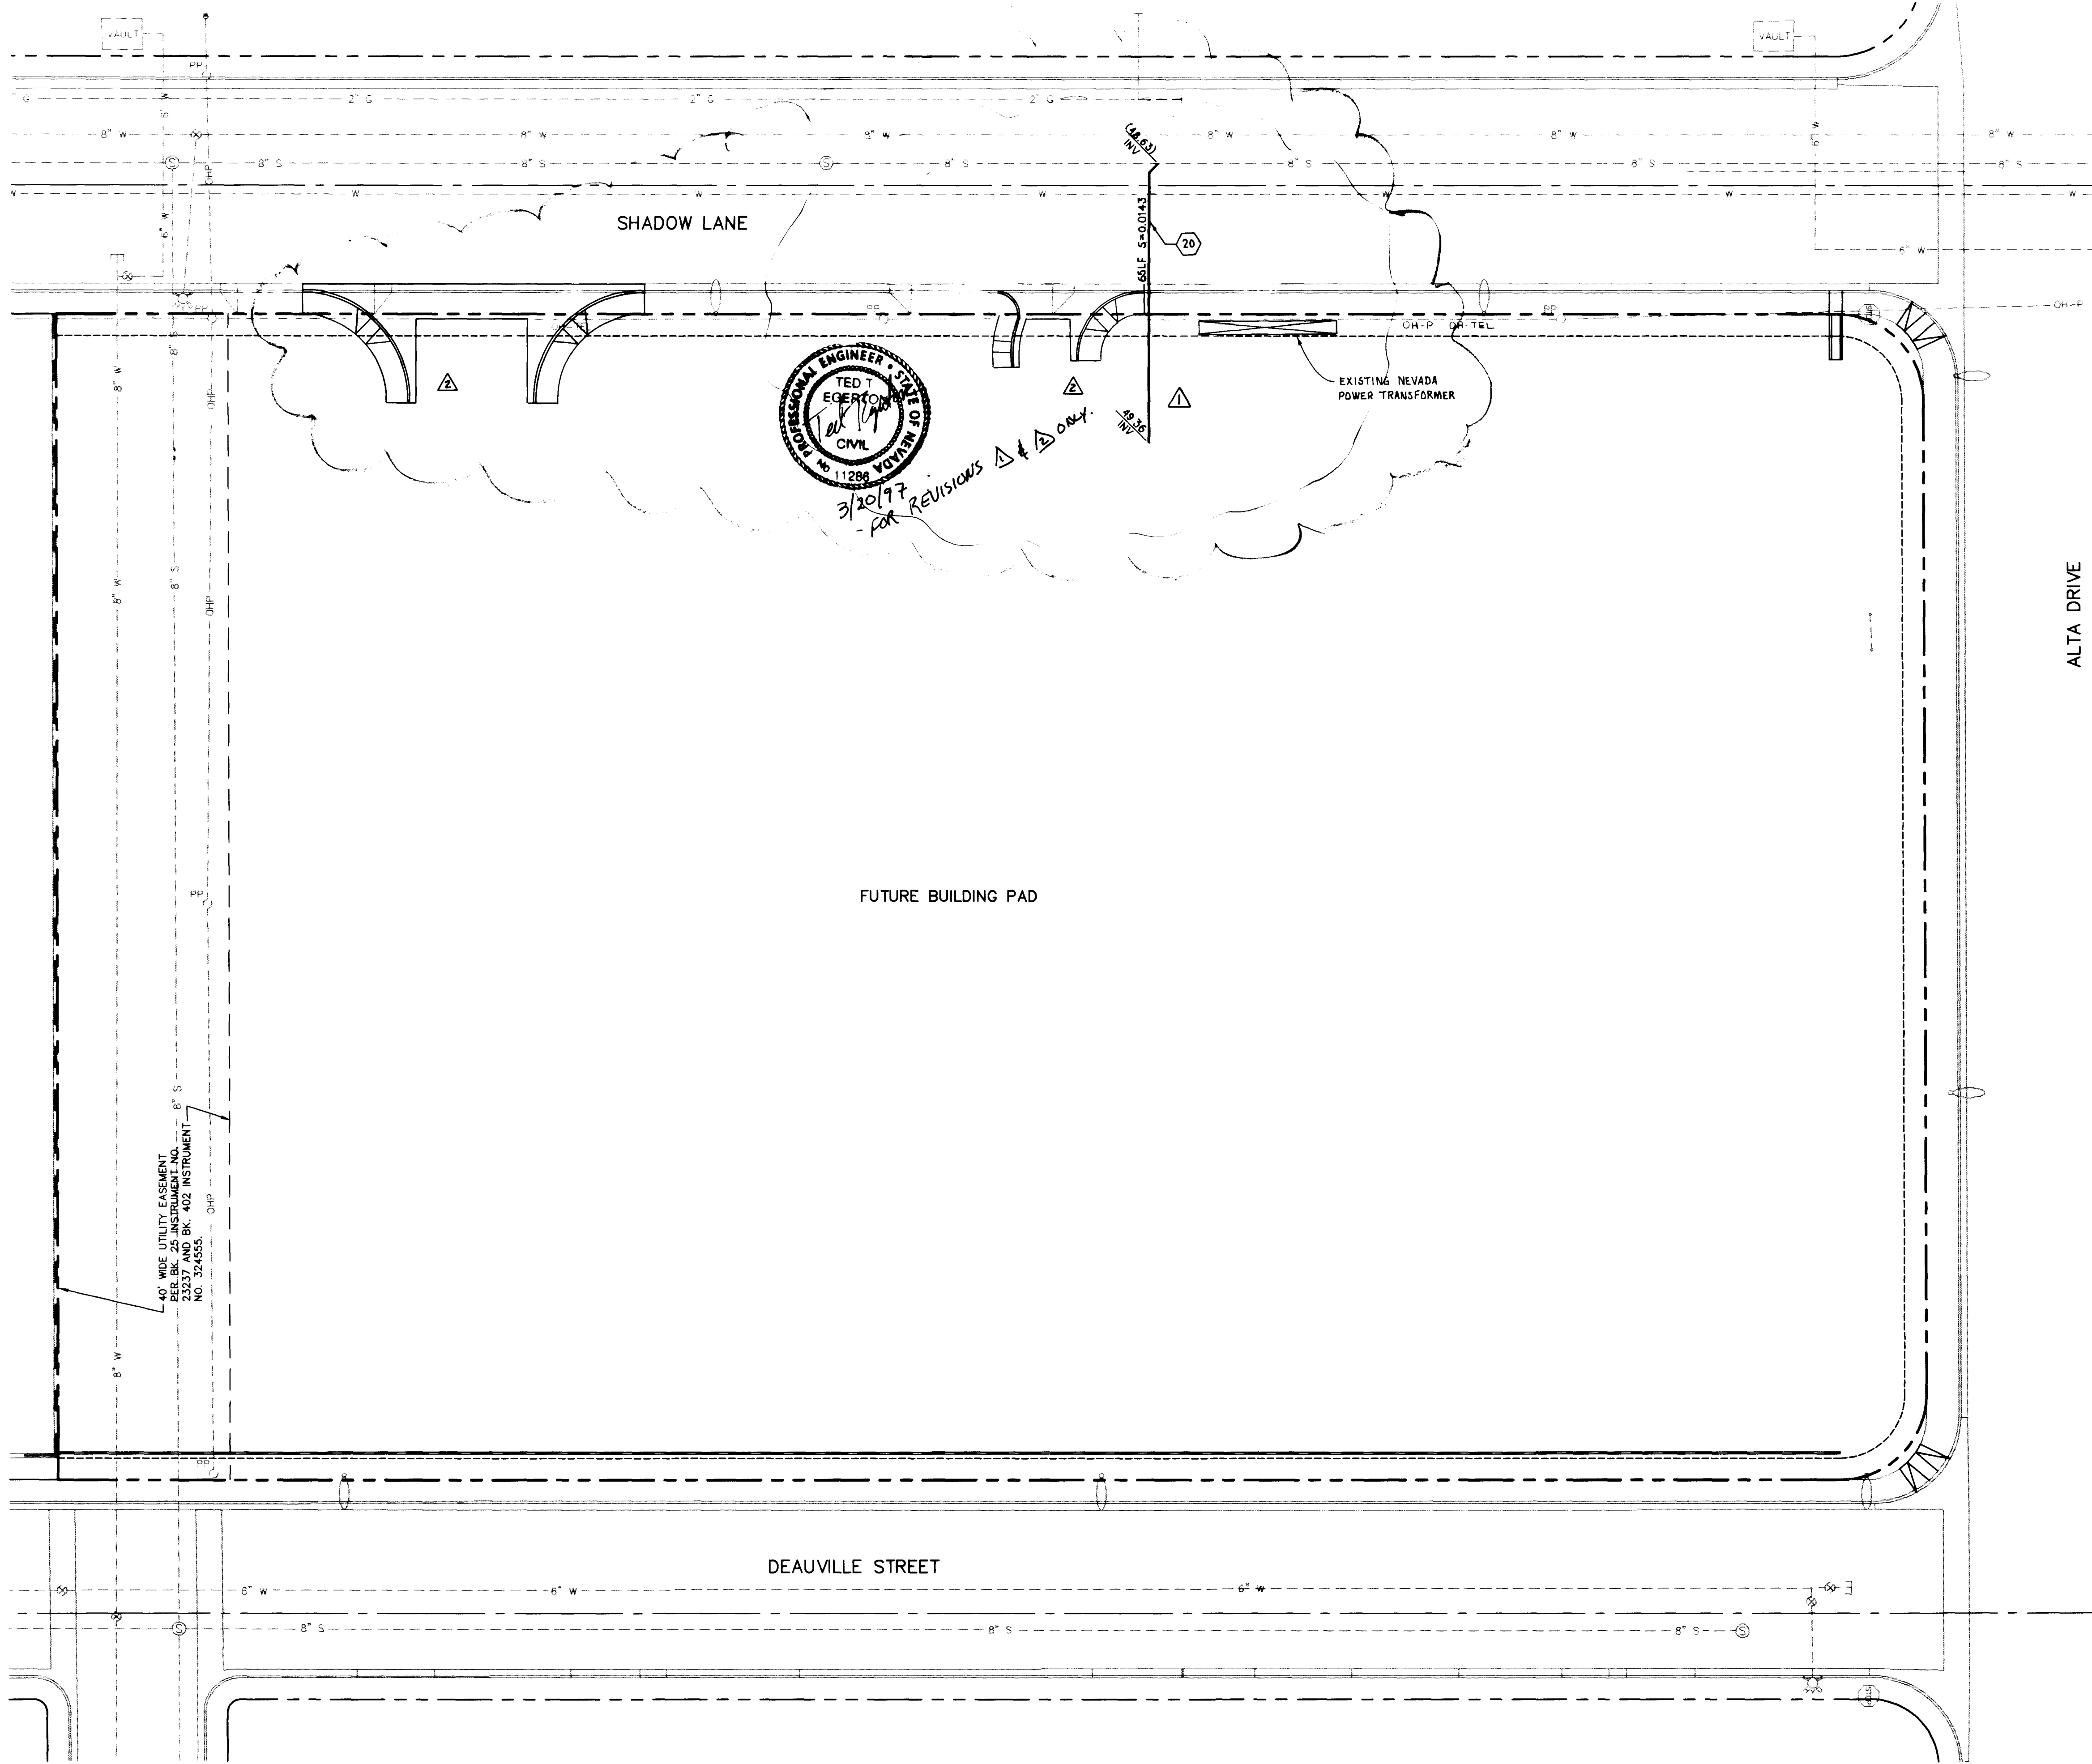

UTILITY LEGEND

- (20) 6" PVC SEWERLINE
- (21) CLEANOUT

NOTE
ON-SITE WATER TO BE INSTALLED DURING BUILDING CONSTRUCTION.


Avoid cutting underground utility lines. It's costly.

Call before you Dig.

1-800-227-2600

UNDERGROUND SERVICE ALERT (USA)


NO.	DESCRIPTION	DATE	APP'D
1	EASTERN DRIVEWAY SHADOW LANE	12/29/94	
2	RELOCATION BY LOTUS ENGINEERS	1/10/95	
3	PRELIM REVISIONS DUE TO UTILITY	2/22/95	
4	CONFLICT BY LOTUS ENG.		

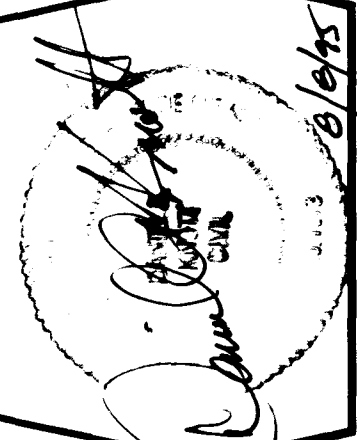


DATE :	9/12/94
DRAWN BY :	
DESIGNED BY :	
CHECKED BY :	
JOB NO. :	012-9401
SCALE :	AS SHOWN

P.L. KNOTT ENGINEERING, LTD.
4820 ALPINE PLACE, SUITE C-102 • LAS VEGAS, NEVADA 89107
(702) 870-3778 • FAX (702) 870-2844

THE RIBEIRO CORPORATION
SHADOW QUAIL PARK
UTILITY PLAN

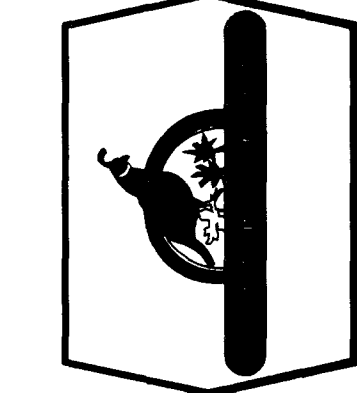

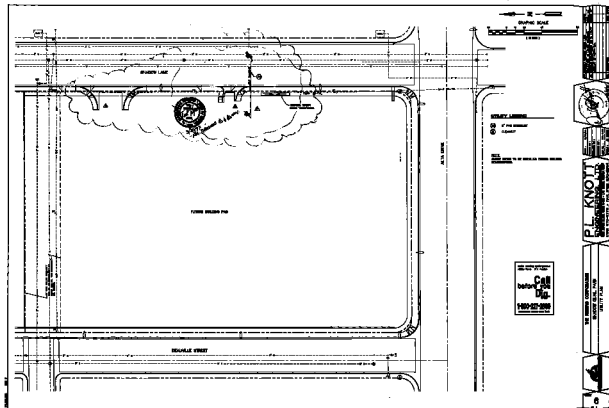

Call before you Dig.
1-800-485-5888

PL. KNOW
PLANNING
DESIGN
CONSTRUCTION

THE ENGINEERING CORPORATION
BLIND SPOT, AND
QUALITY PLAN

