
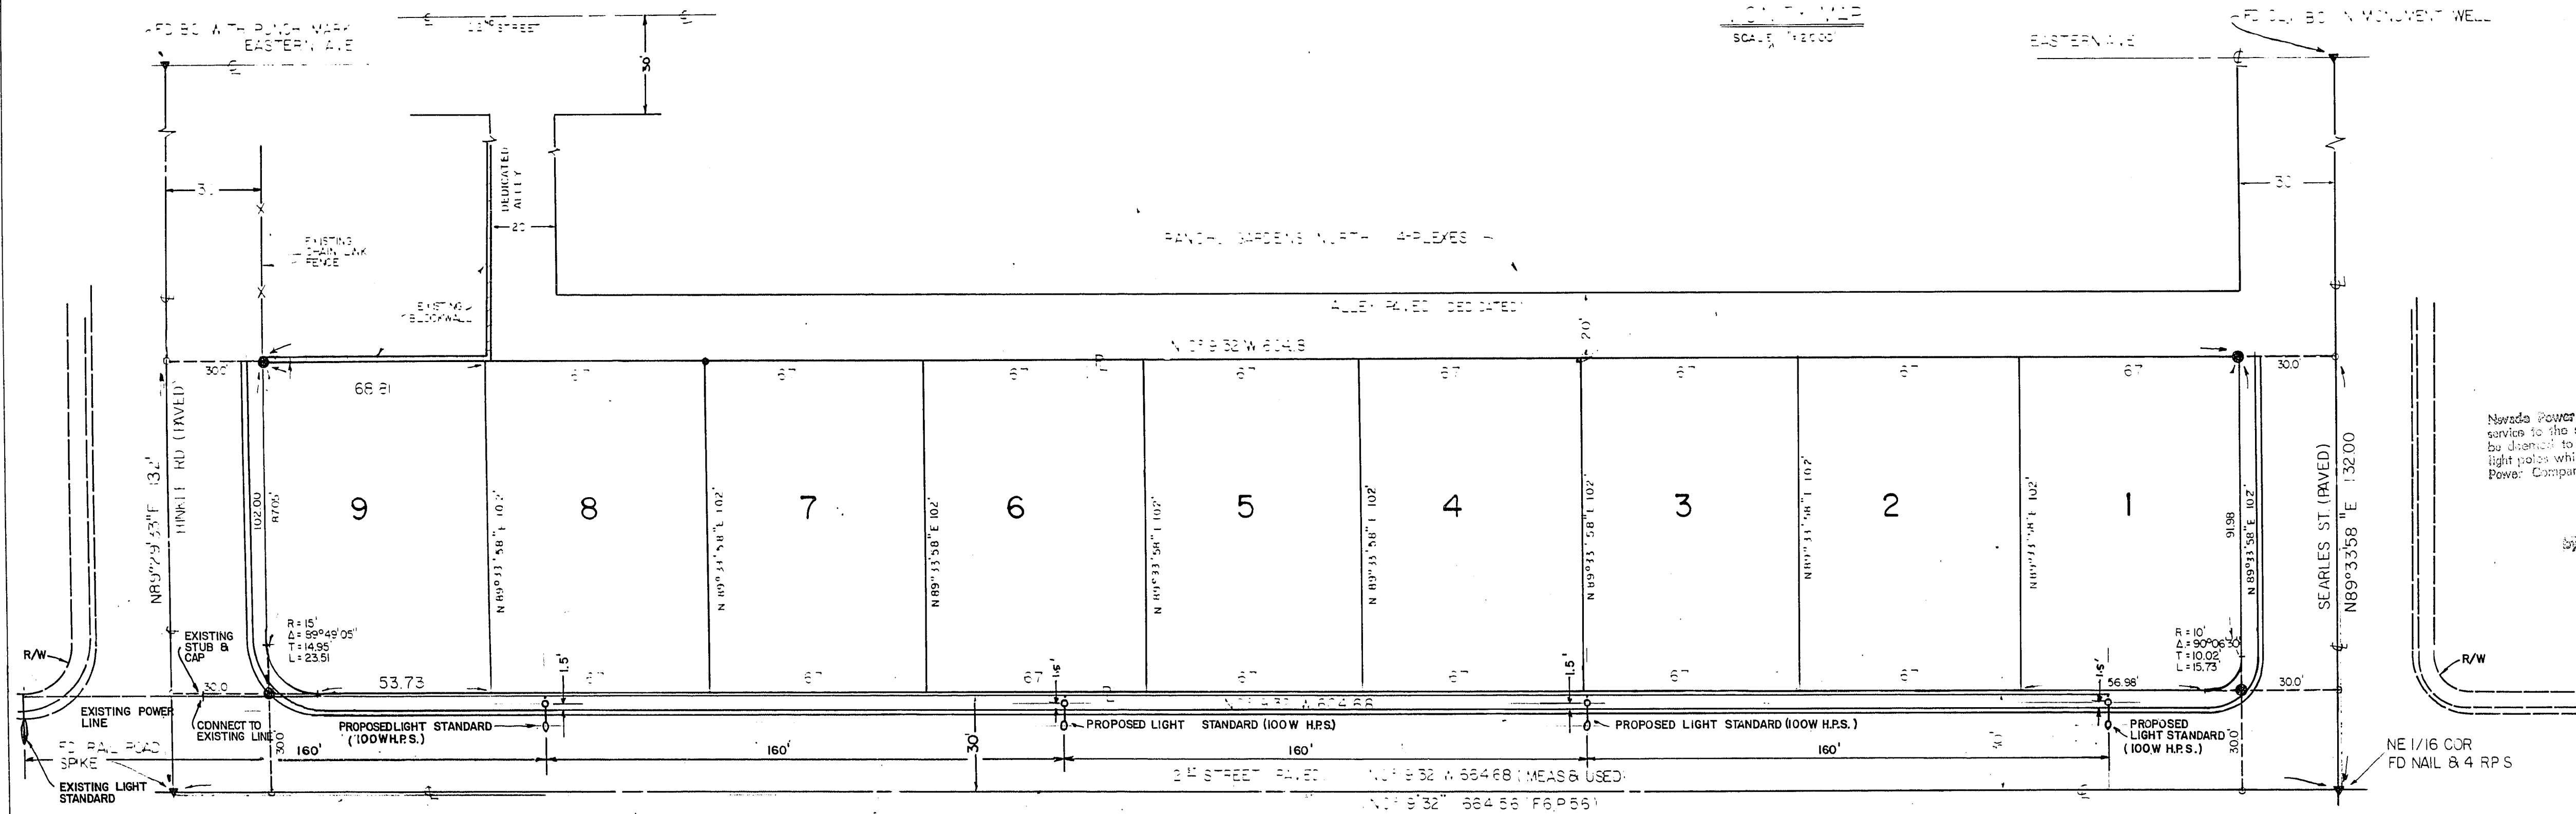
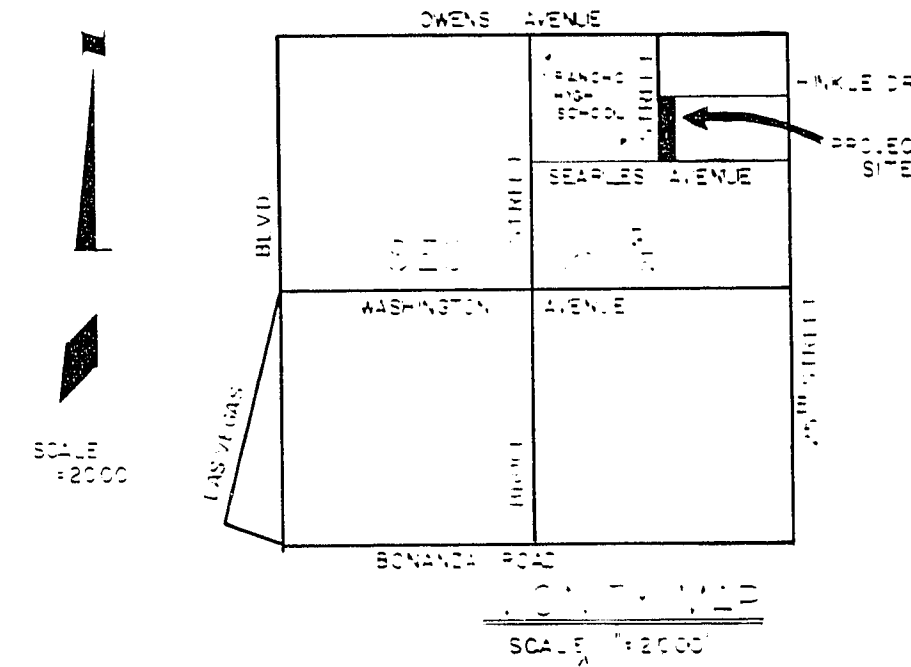


1. STREET LIGHTING STANDARDS SHALL BE AS SHOWN BY DW.G.S No.400.I PAGE 40 OF THE UNIFORM STANDARD DW.G.S AND MUST CONFORM TO SECTIONS 400 AND 405 AND ANY OTHER APPLICABLE SECTIONS OF THE UNIFORM STANDARD SPECIFICATIONS.
2. ALL STREET LIGHTING INSTALLATIONS SHALL CONFORM TO THE NEW STREET LIGHTING SPECIFICATIONS, FOR HIGH PRESSURE SODIUM LUMINAIRES, ADOPTED BY THE C.L.V. MAY 20, 1977 AND EFFECTIVE JUNE 1, 1977.

STRATTON GARDENS

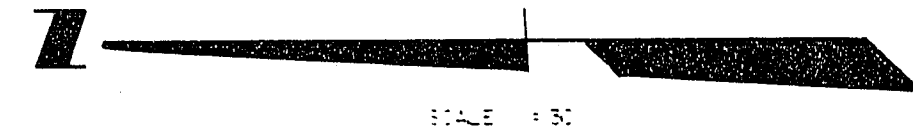

Nevada Power Company approves the point of service to the street light system. This shall not be deemed to consent to the placement of the light poles which may be in conflict with Nevada Power Company's prior rights and/or facilities.

12-29-19
(Date)
Michael C. Coleman
NEVADA POWER COMPANY

APPROVALS

<i>James H. Ferris</i>	12-24-79
SUPERVISOR OF ELECTRICAL SERVICES, GEORGE FERRIS	DATE
<i>James H. Ferris</i>	12/24/79
ELECTRICAL COORDINATOR, GEORGE FERRIS	DATE
<i>Mike B. Belman</i>	12/23/79
NEVADA POWER COMPANY	DATE
<i>Mike B. Belman</i>	
CITY ENGINEER, GARY HOLLER	DATE
<i>NA</i>	
C.L.V. FIELD OPERATIONS ENGINEER,	DATE
<i>Don Deacon</i>	7-30-79
C.L.V. QUALITY CONTROL ENGINEER, DON DEACON	DATE

LEGAL DESCRIPTION

WEST 1320 FT OF THE SOUTH 660 FT
NE 1/4, NE 1/4, SEC 26, T20S, R6E,
M.D.B.M. CLARK COUNTY, NEVADA.


BASIS OF BEARING

© 21st STREET N 0°19'32"W
(F6,P56)

LEGEND

● YES
▼ NO
○ MAY BE VOTED ON BY MAIL

N69-624

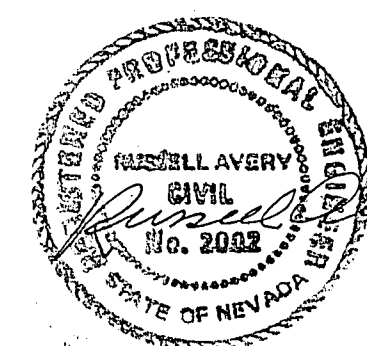

ELECTRICAL PLAN of

STRATTON GARDENS

PTN.NE1/4,NE1/4,
SEC.26,T20S,R61E,
M.D.B.&M.

SCALE	1" = 30'
DATE	12/11/78

RICK STRATTON
For 9/6 ROME FABBI
1405 VEGAS VALLEY DRIVE, 105 CASA VEGAS
LAS VEGAS, NEVADA

BY *Avery* ENGINEERING CONSULTANTS
(DIV. of AVERY CORPORATION)
1401 MARYLAND PARKWAY
LAS VEGAS, NEVADA (702) 395-3877

DWG. BY G. ACOSTA DATE 12/11/78
CHKD. BY R.F. DATE 6/6/79

REVISED DATE	9/12/80 B.A.S.
DWG NO	A9-6
SHEET	9 of 9

107-V-1134