
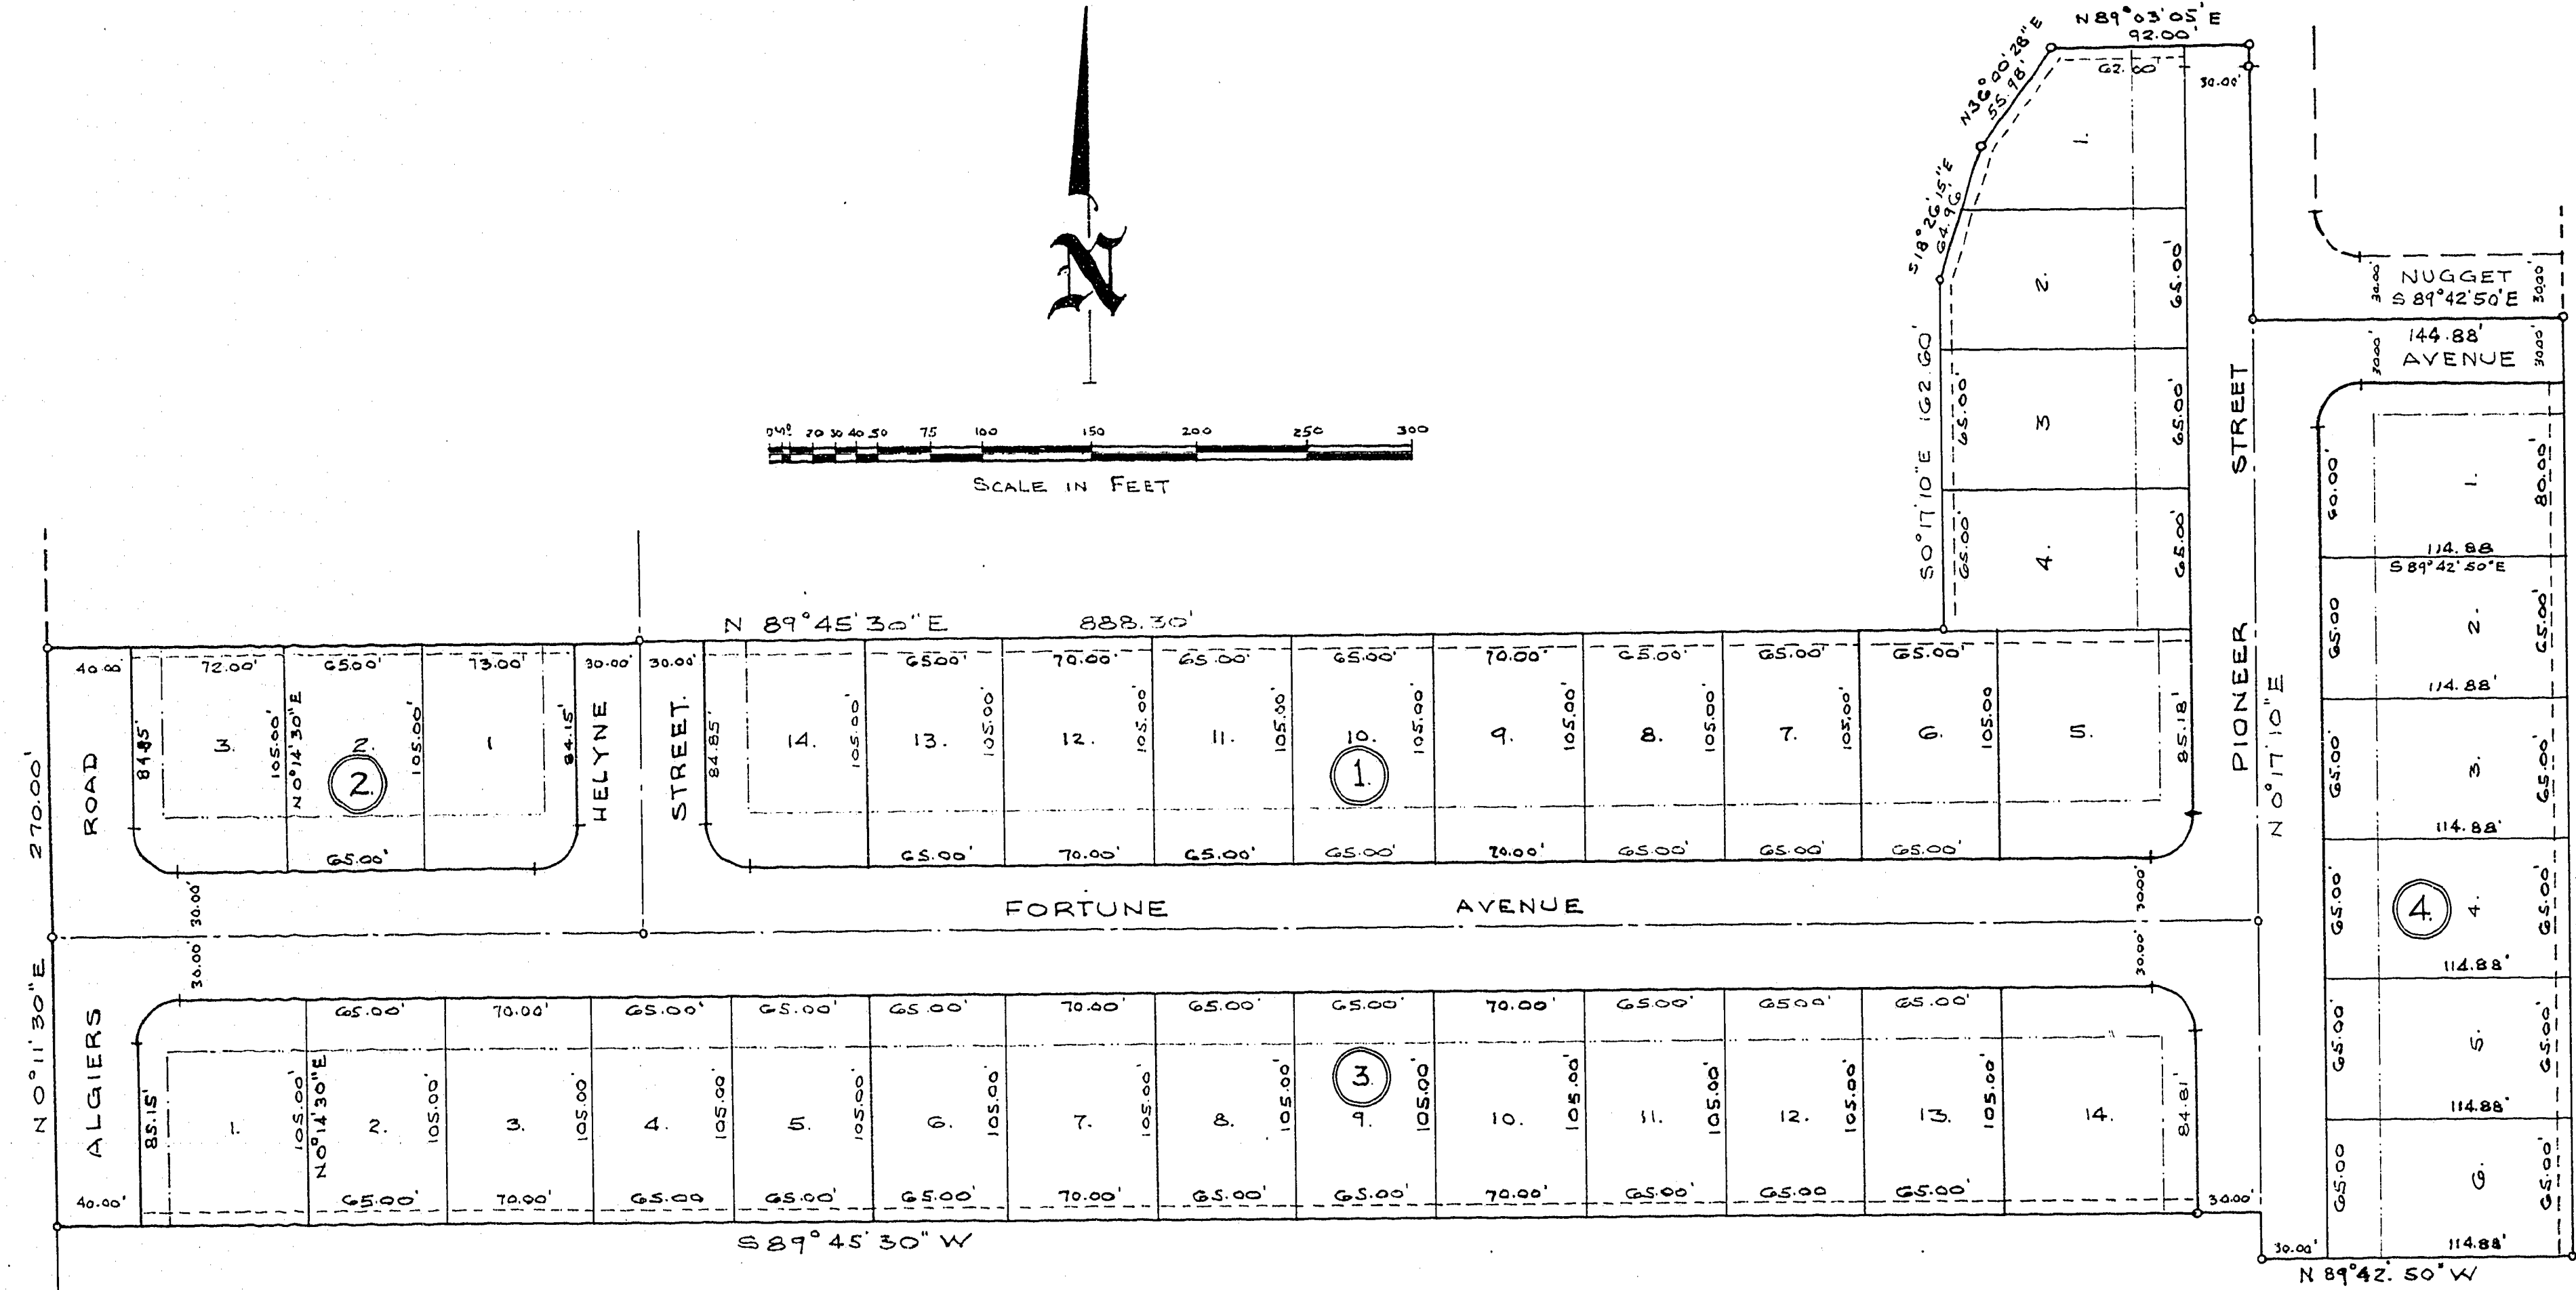


Twin Lakes Estates

Unit No. 3

BEING A PORTION OF THE NE¹/₄ OF THE SE¹/₄
OF SECTION 30, T20 S., R.61 E., M.D.B. & M.
LAS VEGAS, CLARK COUNTY, NEVADA.

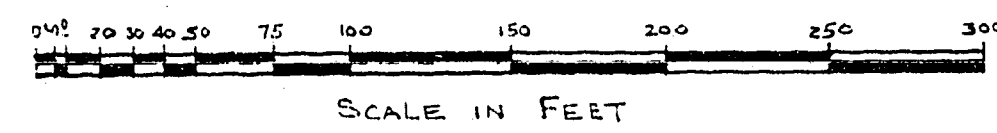

INDEX OF SHEETS

SHEET No.

1. INDEX
2. SUBDIVISION MAP
3. WATER DISTRIBUTION SYSTEM
4. POWER DISTRIBUTION & STREET LIGHTING PLAN.
5. STREET PLAN & PROFILE
6. STREET PLAN & PROFILE
7. SEWER PLAN LAYOUT
8. SEWER PLAN & PROFILE
9. SEWER PLAN & PROFILE

SUBMITTED BY

SOUTHWESTERN SUBDIVIDERS

1319 SOUTH MAIN AVENUE
LAS VEGAS, — NEVADA

ENGINEER

GEORGE YON TOBEL
NEVADA CERTIFICATE NO. 428