


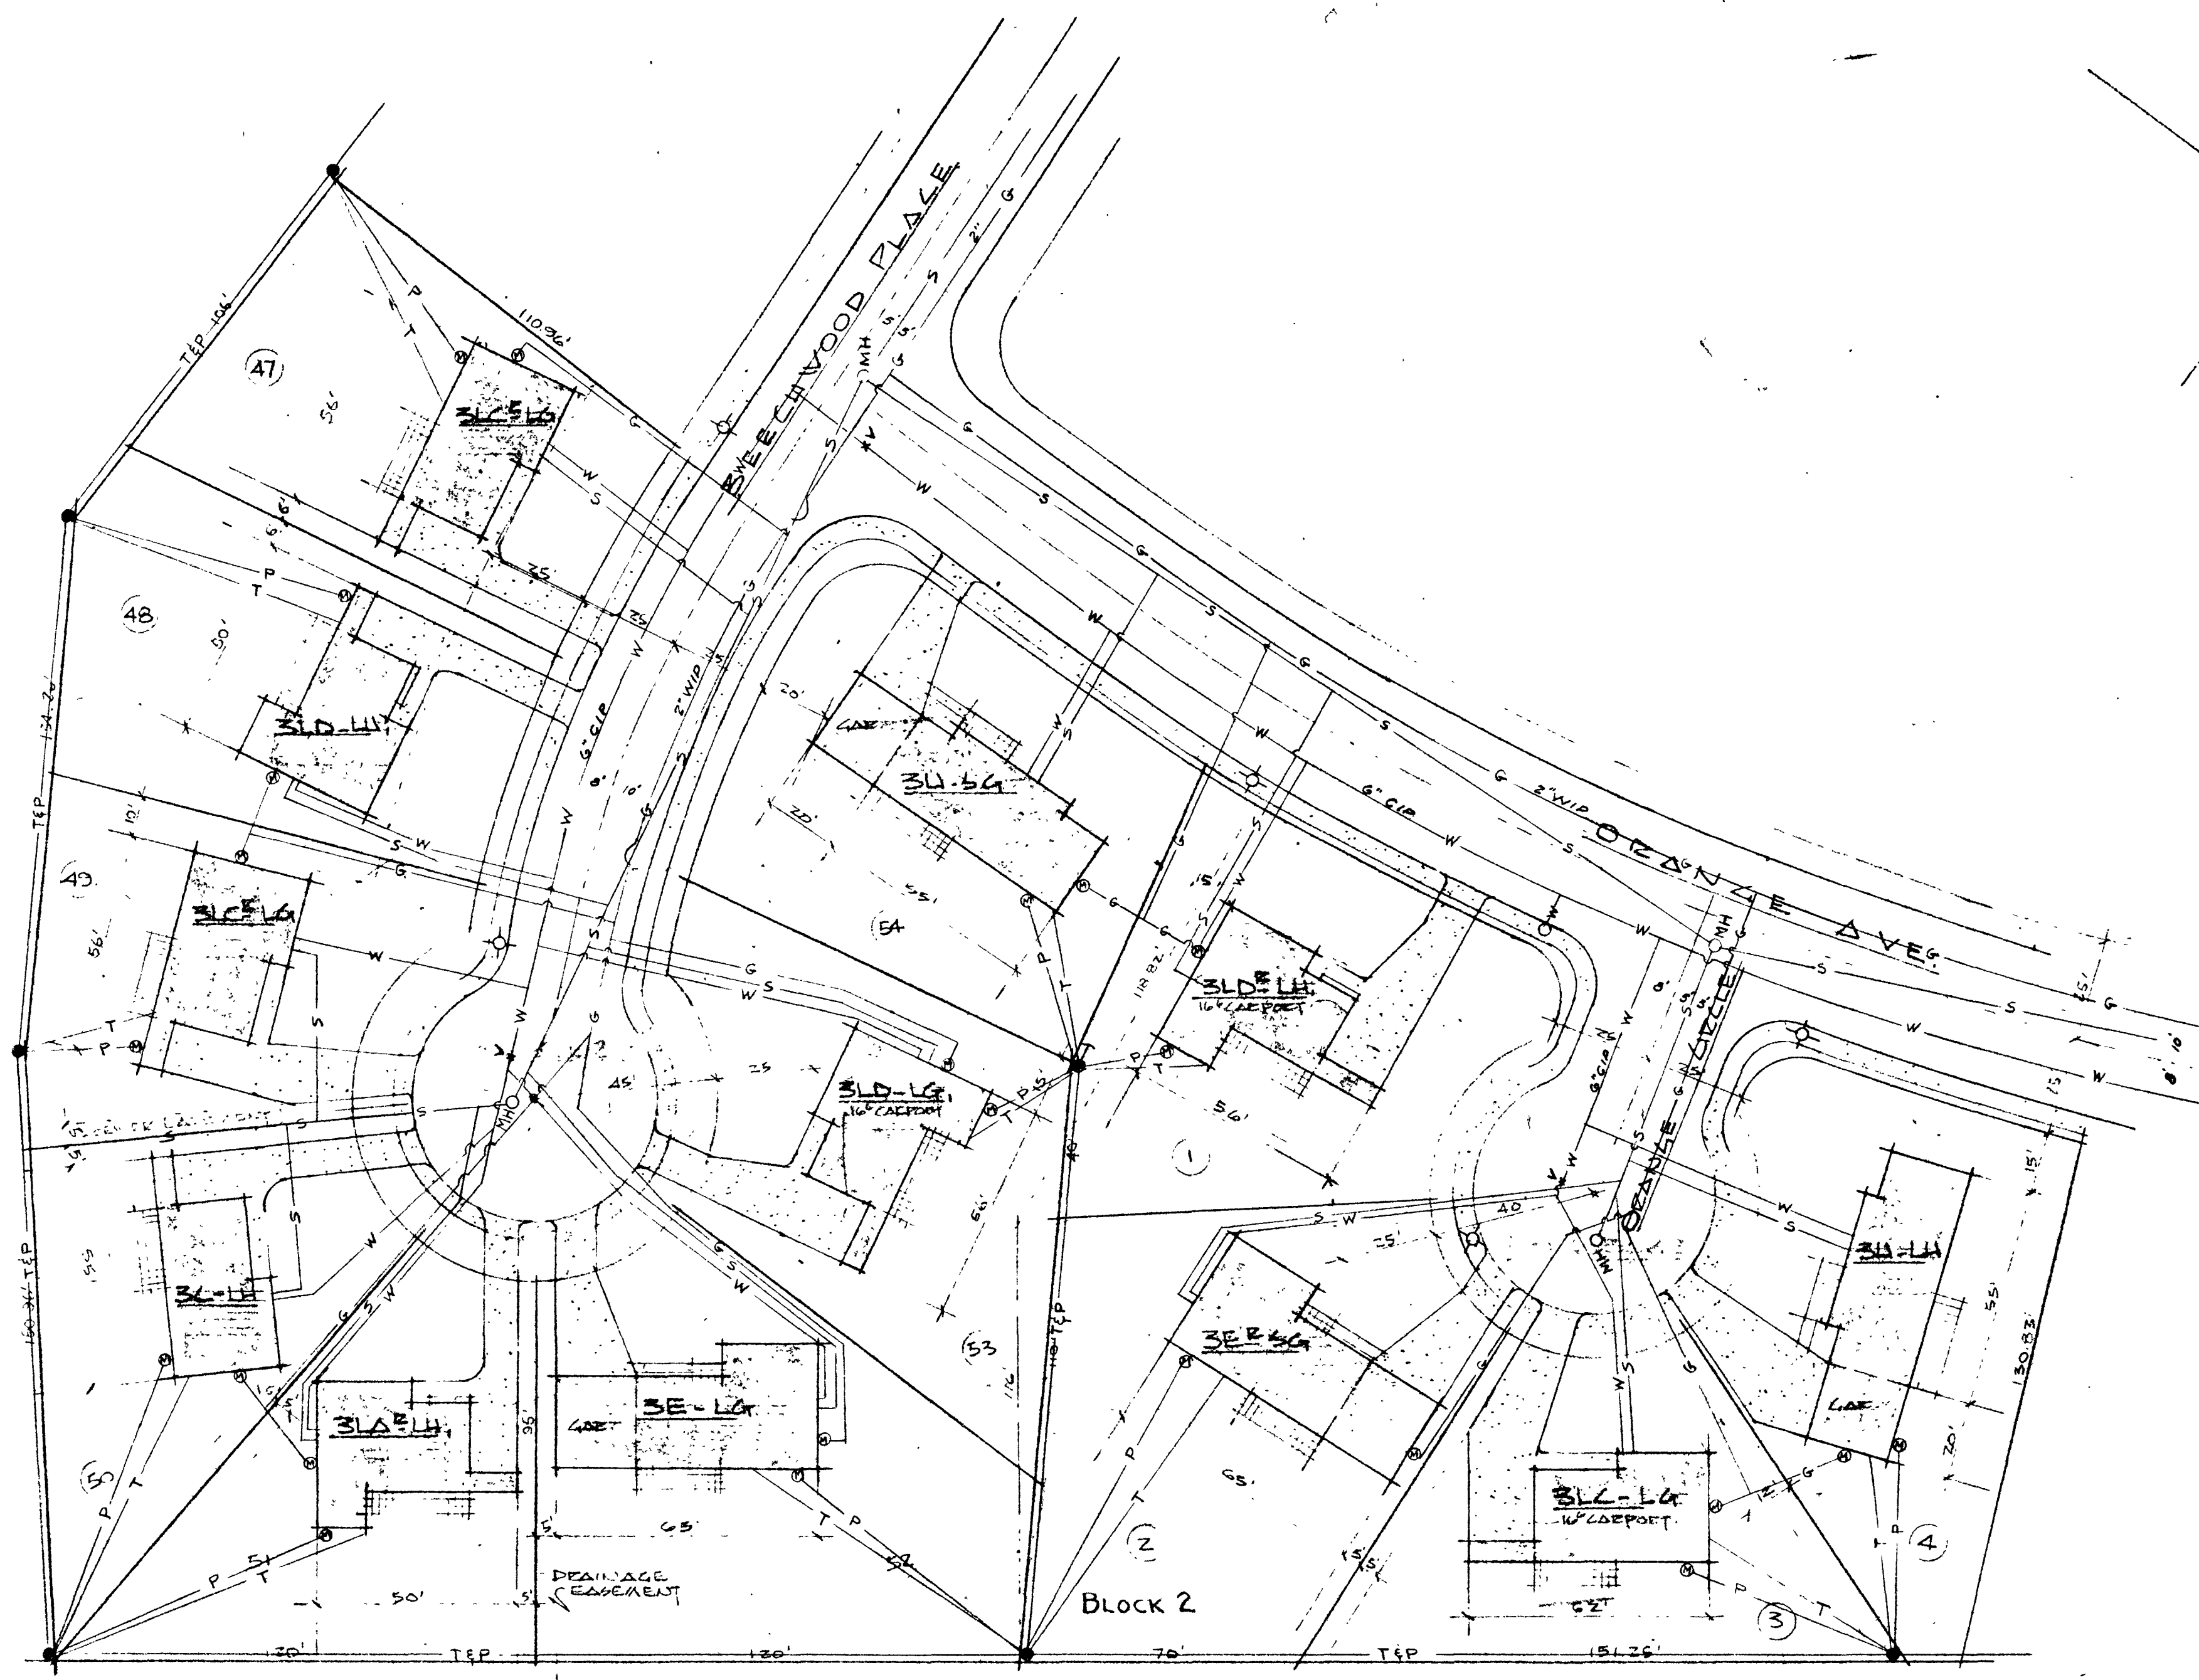

- LEGEND
- Anchored Power Pole
 - Telephone & Electric Power Pole
 - Fire Hydrant
 - Gas & Power Meter (Water not metered)
 - Sewer Manhole
 - Street Light & Standard
 - G — Gas Line
 - S — Sewer Line
 - TEP — Telephone & Electric Power Line
 - W — Water Line
 - P — Electric Power Line
 - T — Telephone Line if desired
 - V — Valve

UTILITY PLAN FOR BLOCK 2
 SCALE 1" = 30'
 SEE NOTE ON SHEET 1


U.S. HIGHWAY #95

TWIN LAKES # 1 & 2

ART L. JACOBSON ARCHITECT
 RIVERSIDE, CALIFORNIA

FOR LEEZ ASSOCIATES
 LAS VEGAS, NEVADA

DESIGN	DATE	SHEET
AK	7/20/54	18
NO.		OF
2-55		SHEETS

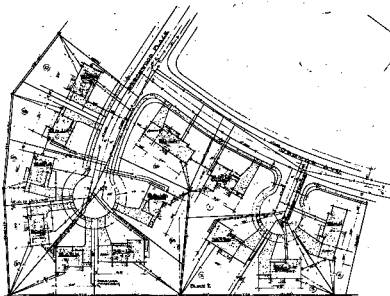

VIEW PLAN 2 - 1/2" = 1'-0"
SEE NOTES ON SHEET 1

- LEGEND
- 1 - Outdoor Tennis Pad
 - 2 - Outdoor Tennis Pad
 - 3 - Pool
 - 4 - Pool
 - 5 - Pool
 - 6 - Pool
 - 7 - Pool
 - 8 - Pool
 - 9 - Pool
 - 10 - Pool

ENCLOSURE 2

TWIN LANE 1 & 2

ART JACOBSON-ARCHITECTS
RIVERSIDE, CALIFORNIA

FOR LARRY ASSOCIATES
LOS ANGELES, CALIFORNIA

1/2" = 1'-0"
1/4" = 1'-0"
1/8" = 1'-0"
1/16" = 1'-0"