
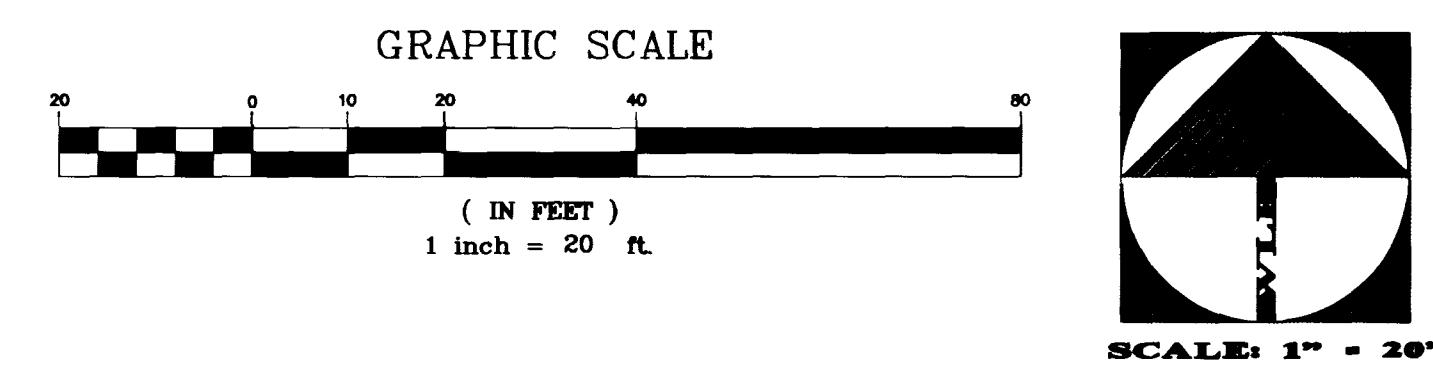


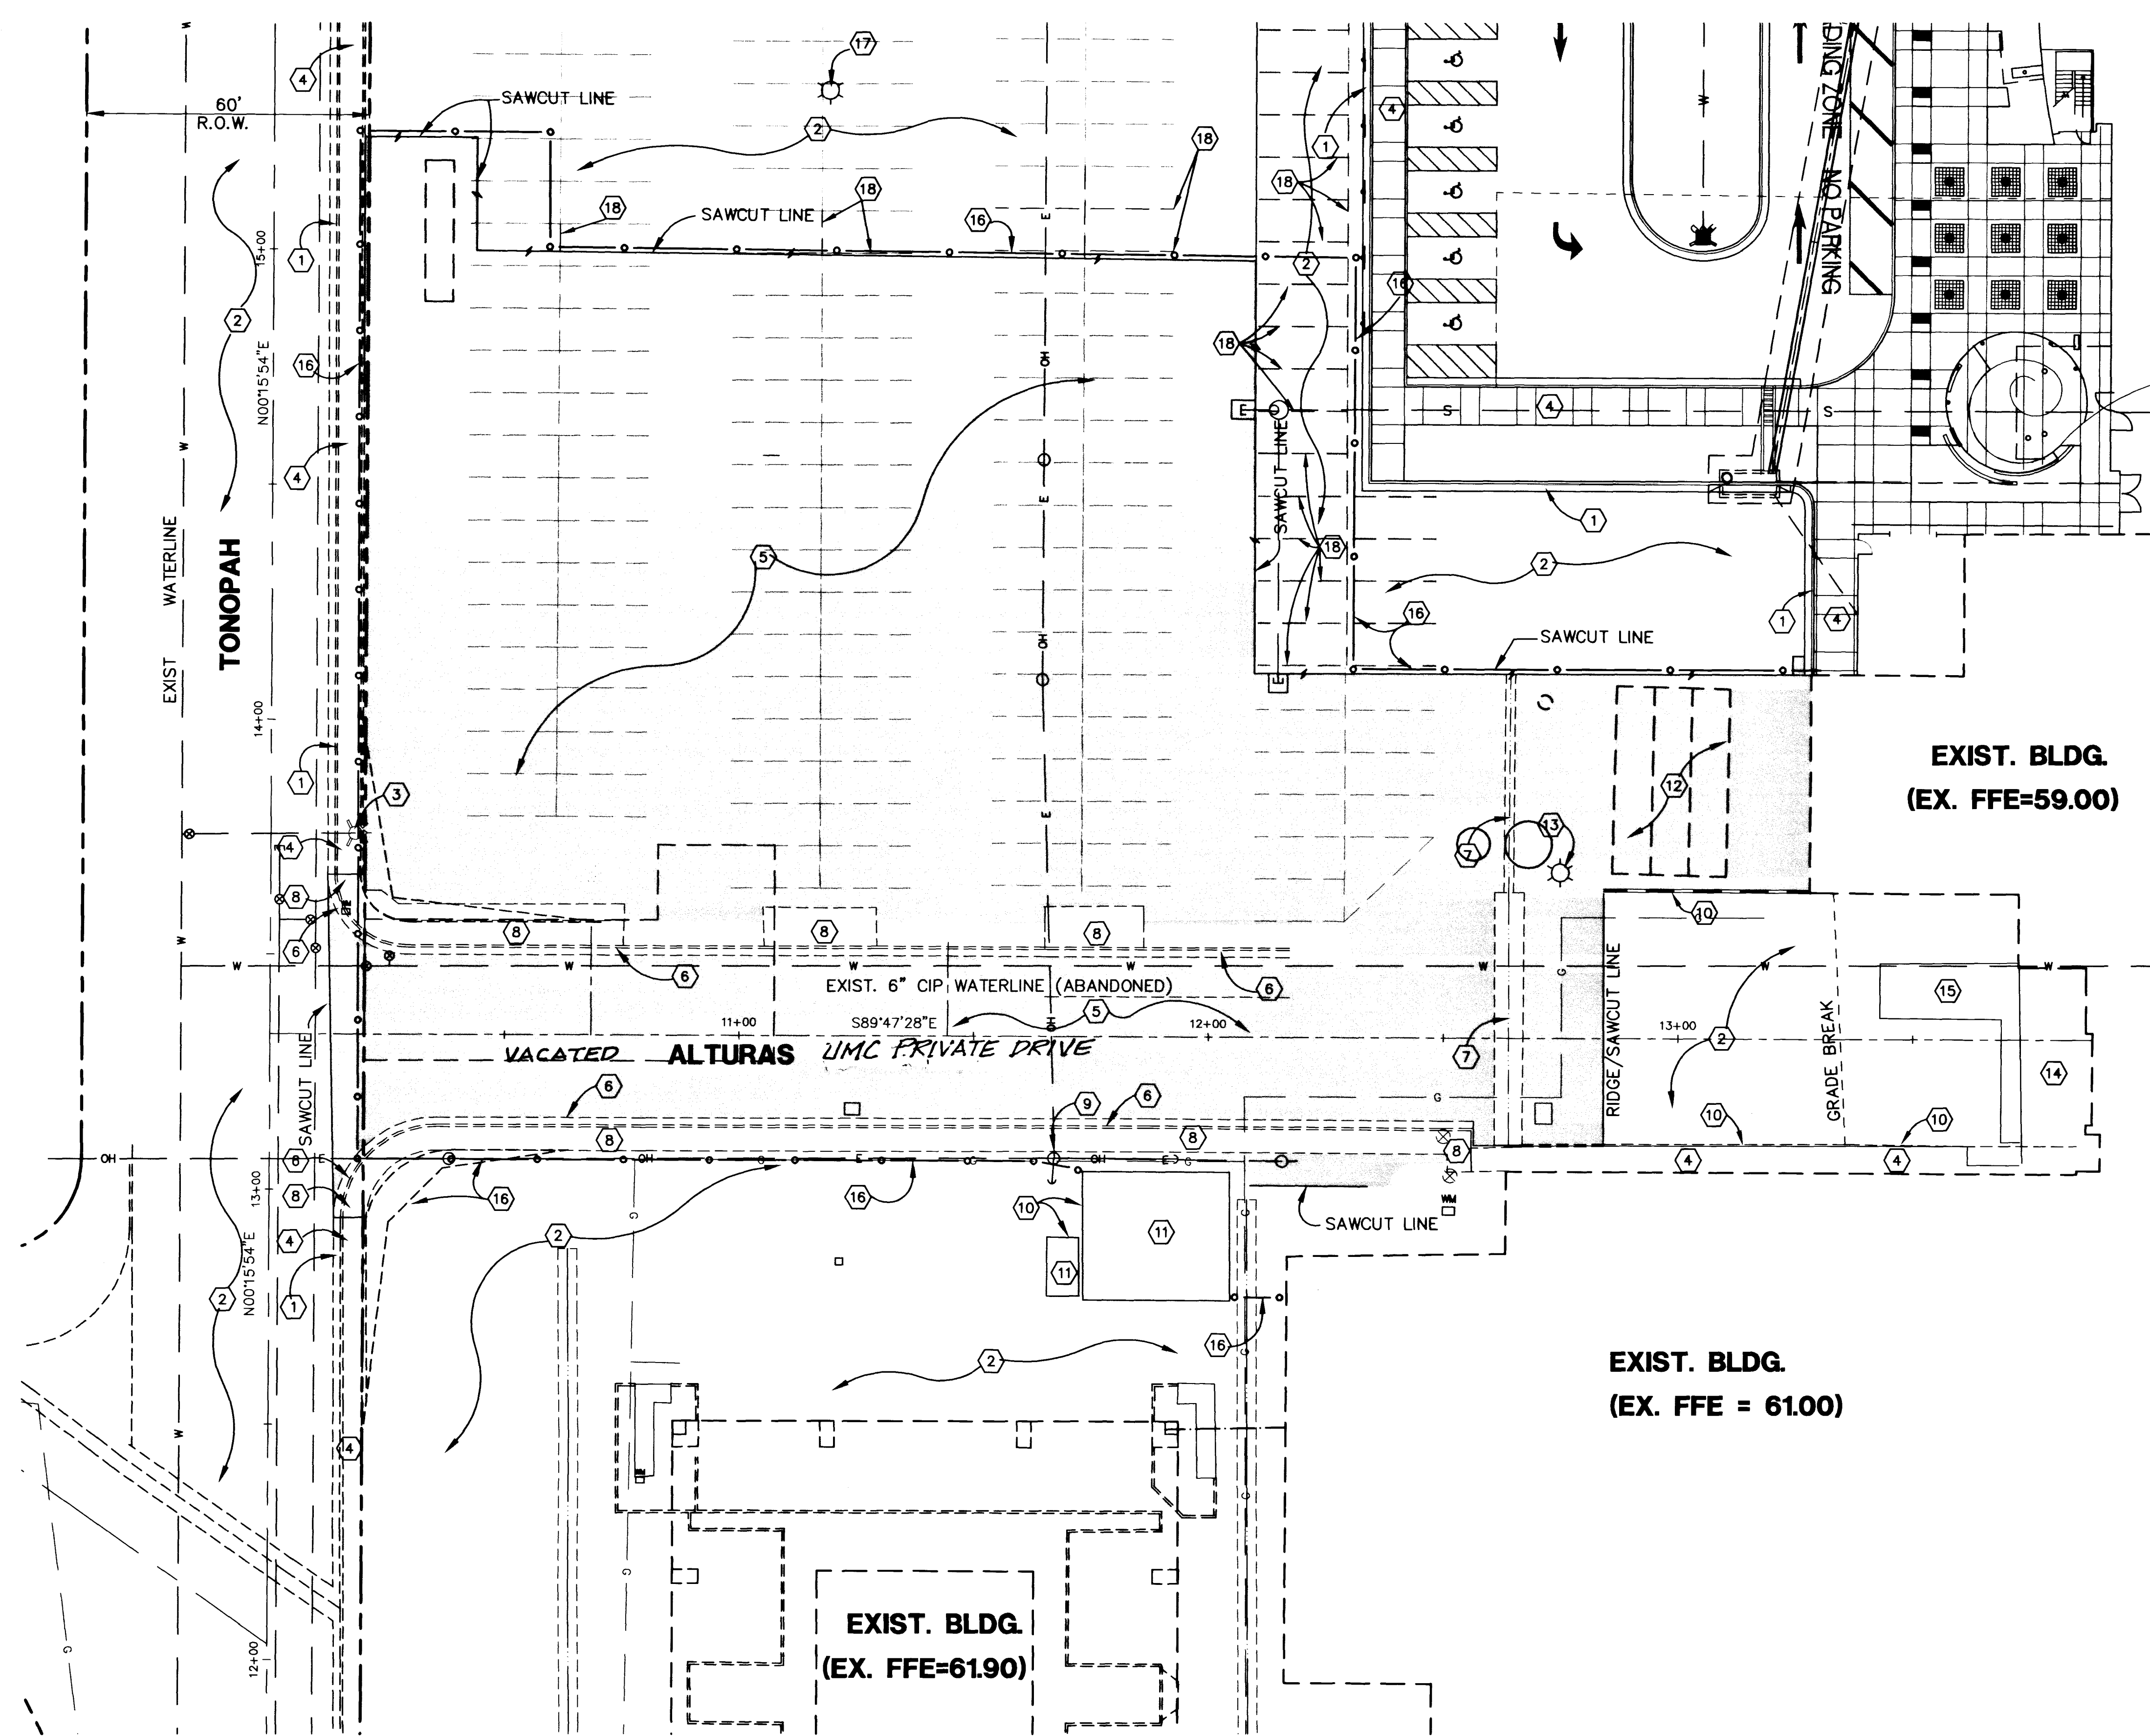

DEMOLITION NOTES:	QUANTITIES	
	PRIVATE	PUBLIC
1. EXIST. CURB & GUTTER, PROTECT IN PLACE.	N/A	N/A
2. EXIST. PAVEMENT, PROTECT IN PLACE.	N/A	N/A
3. EXIST. F.H., PROTECT IN PLACE.	N/A	N/A
4. EXIST. CONC. WALK, PROTECT IN PLACE.	N/A	N/A
5. EXIST. PAVEMENT TO BE REMOVED.	42,486 SF	3,955 SF
6. EXIST. CURB & GUTTER TO BE REMOVED.	410 LF	65 LF
7. EXIST. VALLEY GUTTER TO BE REMOVED.	100 LF	0 LF
8. EXIST. CONC. WALK TO BE REMOVED.	2,150 SF	260 LF
9. EXIST. UTILITY POLE AND GUY WIRES, PROTECT IN PLACE.	N/A	N/A
10. EXIST. WALL, PROTECT IN PLACE.	N/A	N/A
11. EXIST. ELECTRICAL TRANSFORMERS, PROTECT IN PLACE.	N/A	N/A
12. EXIST. TRAILERS TO BE RELOCATED, SEE HORIZONTAL CONTROL PLAN FOR DIMENSIONS.	3 EA	0 EA
13. EXIST. EXISTING AREA LIGHT TO BE REMOVED AND STOCKPILED, SEE SITE ELECTRICAL PLANS.	N/A	N/A
14. EXIST. LOADING DOCK, PROTECT IN PLACE.	N/A	N/A
15. EXIST. MISC. CONC. PROTECT IN PLACE.	N/A	N/A
16. TEMPORARY CONSTRUCTION FENCE.	815 LF	0 LF
17. EXIST. AREA LIGHT PROTECT IN PLACE.	N/A	N/A
18. ERADICATE EXISTING PARKING STRIPING	244 LF	0 LF

LEGEND	
DESC.	EXISTING
R/W PROPERTY LINE	---
CENTERLINE	---
CONTOURS	--- 10 ---
CONCRETE CURB	=====
FINISH FLOOR ELEV.	EXIST. FFE= 22.10
PAD ELEVATION	(21.5)
FINISH GRADE ELEVATION	(42.81)
PAVEMENT SLOPE	N/A
GRADE BREAK	N/A
WALL	=====
LUMINAIRE	(AS NOTED)
UTILITY LINE	---
WATER LINE	---
SEWER LINE	---
SEWER MANHOLE	⊙
FIRE HYDRANT	⊗
VALVE	⊗
WATER METER	⊗
PIV	⊗
FDC	⊗
RPPA	RPPA
DCDA	DCDA
REMOVE ASPHALT	=====

BENCHMARK
C.L.V. VERTICAL CONTROL NO. 9, STATION 2LV01, 33SWS
RIVET AND PLATE IN TOP OF CURB, NE RETURN
CHARLESTON BOULEVARD AND TONOPAH DRIVE.
ELEVATION 2261.91 FEET = 628.4724 METERS (NAVD 88)


SAFETY ALERT
Call before you Overhead
593-6111
UNDERGROUND SERVICE ALERT

SAFETY ALERT
Call before you Dig.
1-800-227-2600
UNDERGROUND SERVICE ALERT

BASIS OF BEARINGS
NORTH 00°15'54" EAST, BEING THE WEST LINE OF THE SOUTHWEST QUARTER (SW 1/4) OF SECTION 33, TOWNSHIP 20 SOUTH, RANGE 61 EAST, M.D.M., CITY OF LAS VEGAS, CLARK COUNTY, NEVADA, AS SHOWN ON A MAP IN FILE 51, PAGE 84 OF SURVEYS, IN THE CLARK COUNTY RECORDER'S OFFICE, CLARK COUNTY, NEVADA.

ARCH: HOLMES SABATINI ASSOCIATES 1 COMMERCE CENTER DRIVE HENDERSON, NV. 89014 (702) 436-1006	PROJECT: UMC SITE FACILITIES UNIVERSITY MEDICAL CENTER	DATE: 10/9/98	DESIGNED BY: TDA	CHECKED BY: THL	PROJECT NO.: 498096A001	SCALE: 1" = 20' (H) 1" = 2' (V)
SHEET TITLE: DEMOLITION PLAN		DRAWN BY: AJS		PROJECT: UMC SITE FACILITIES UNIVERSITY MEDICAL CENTER		DATE: 10/9/98
ARCH: HOLMES SABATINI ASSOCIATES		DESIGNED BY: TDA		CHECKED BY: THL		PROJECT NO.: 498096A001
PROJECT: UMC SITE FACILITIES UNIVERSITY MEDICAL CENTER		DRAWN BY: AJS		PROJECT: UMC SITE FACILITIES UNIVERSITY MEDICAL CENTER		DATE: 10/9/98
SHEET: C4		DRAWING NO. 107-V3071		PROJECT: UMC SITE FACILITIES UNIVERSITY MEDICAL CENTER		DATE: 10/9/98

PROFESSIONAL ENGINEER STATE OF NEVADA
TED H. LYON
CML
No. 5482
Exp. 12/31/99

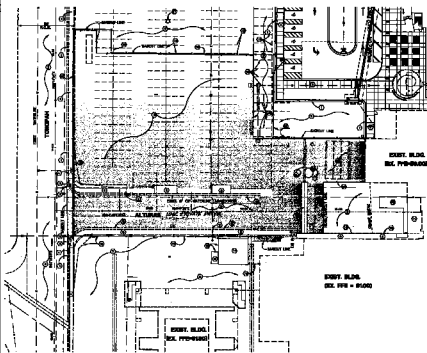

SCALE: 1" = 10' - 0"

DEMOLITION NOTES:

1. DEMOLITION LINE
2. EXIST. BLDG.
3. EX. FVB-0000
4. EX. FVB-0100
5. EX. FVB-0200
103. EX. FVB-10000

QUANTITIES:

ITEM	QUANTITY	UNIT
DEMOLITION	1000	CU YD
EX. FVB-0000	1000	CU YD
EX. FVB-0100	1000	CU YD
EX. FVB-0200	1000	CU YD
EX. FVB-10000	1000	CU YD

REVISIONS:

NO.	DATE	DESCRIPTION
1	10/1/78	ISSUED FOR CONSTRUCTION

SCALE OF DEMOLITION:

1" = 10' - 0"

DEMOLITION PLAN

WLB

WILSON & LEBLANC

UNIVERSITY MEDICAL CENTER

WLB

WILSON & LEBLANC

UNIVERSITY MEDICAL CENTER

DEMOLITION PLAN

WLB

WILSON & LEBLANC

UNIVERSITY MEDICAL CENTER