
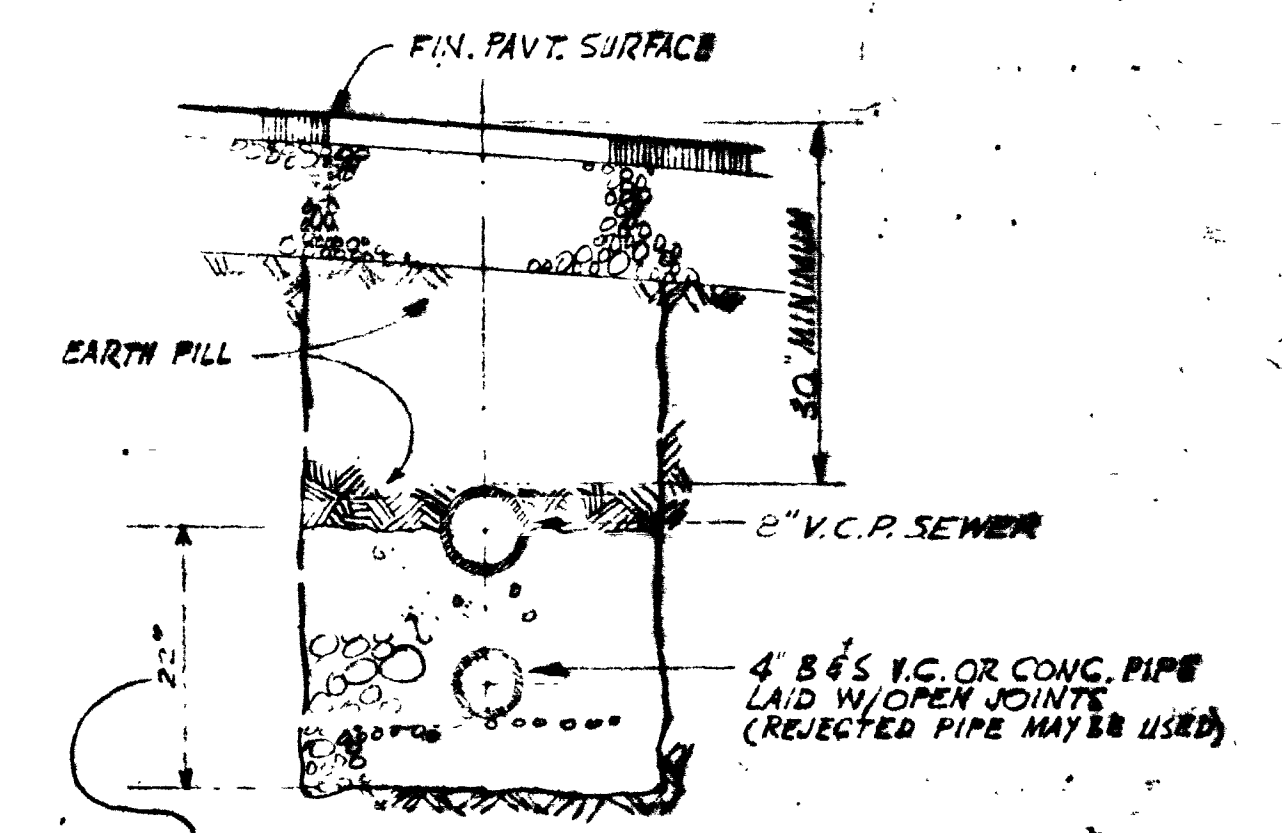


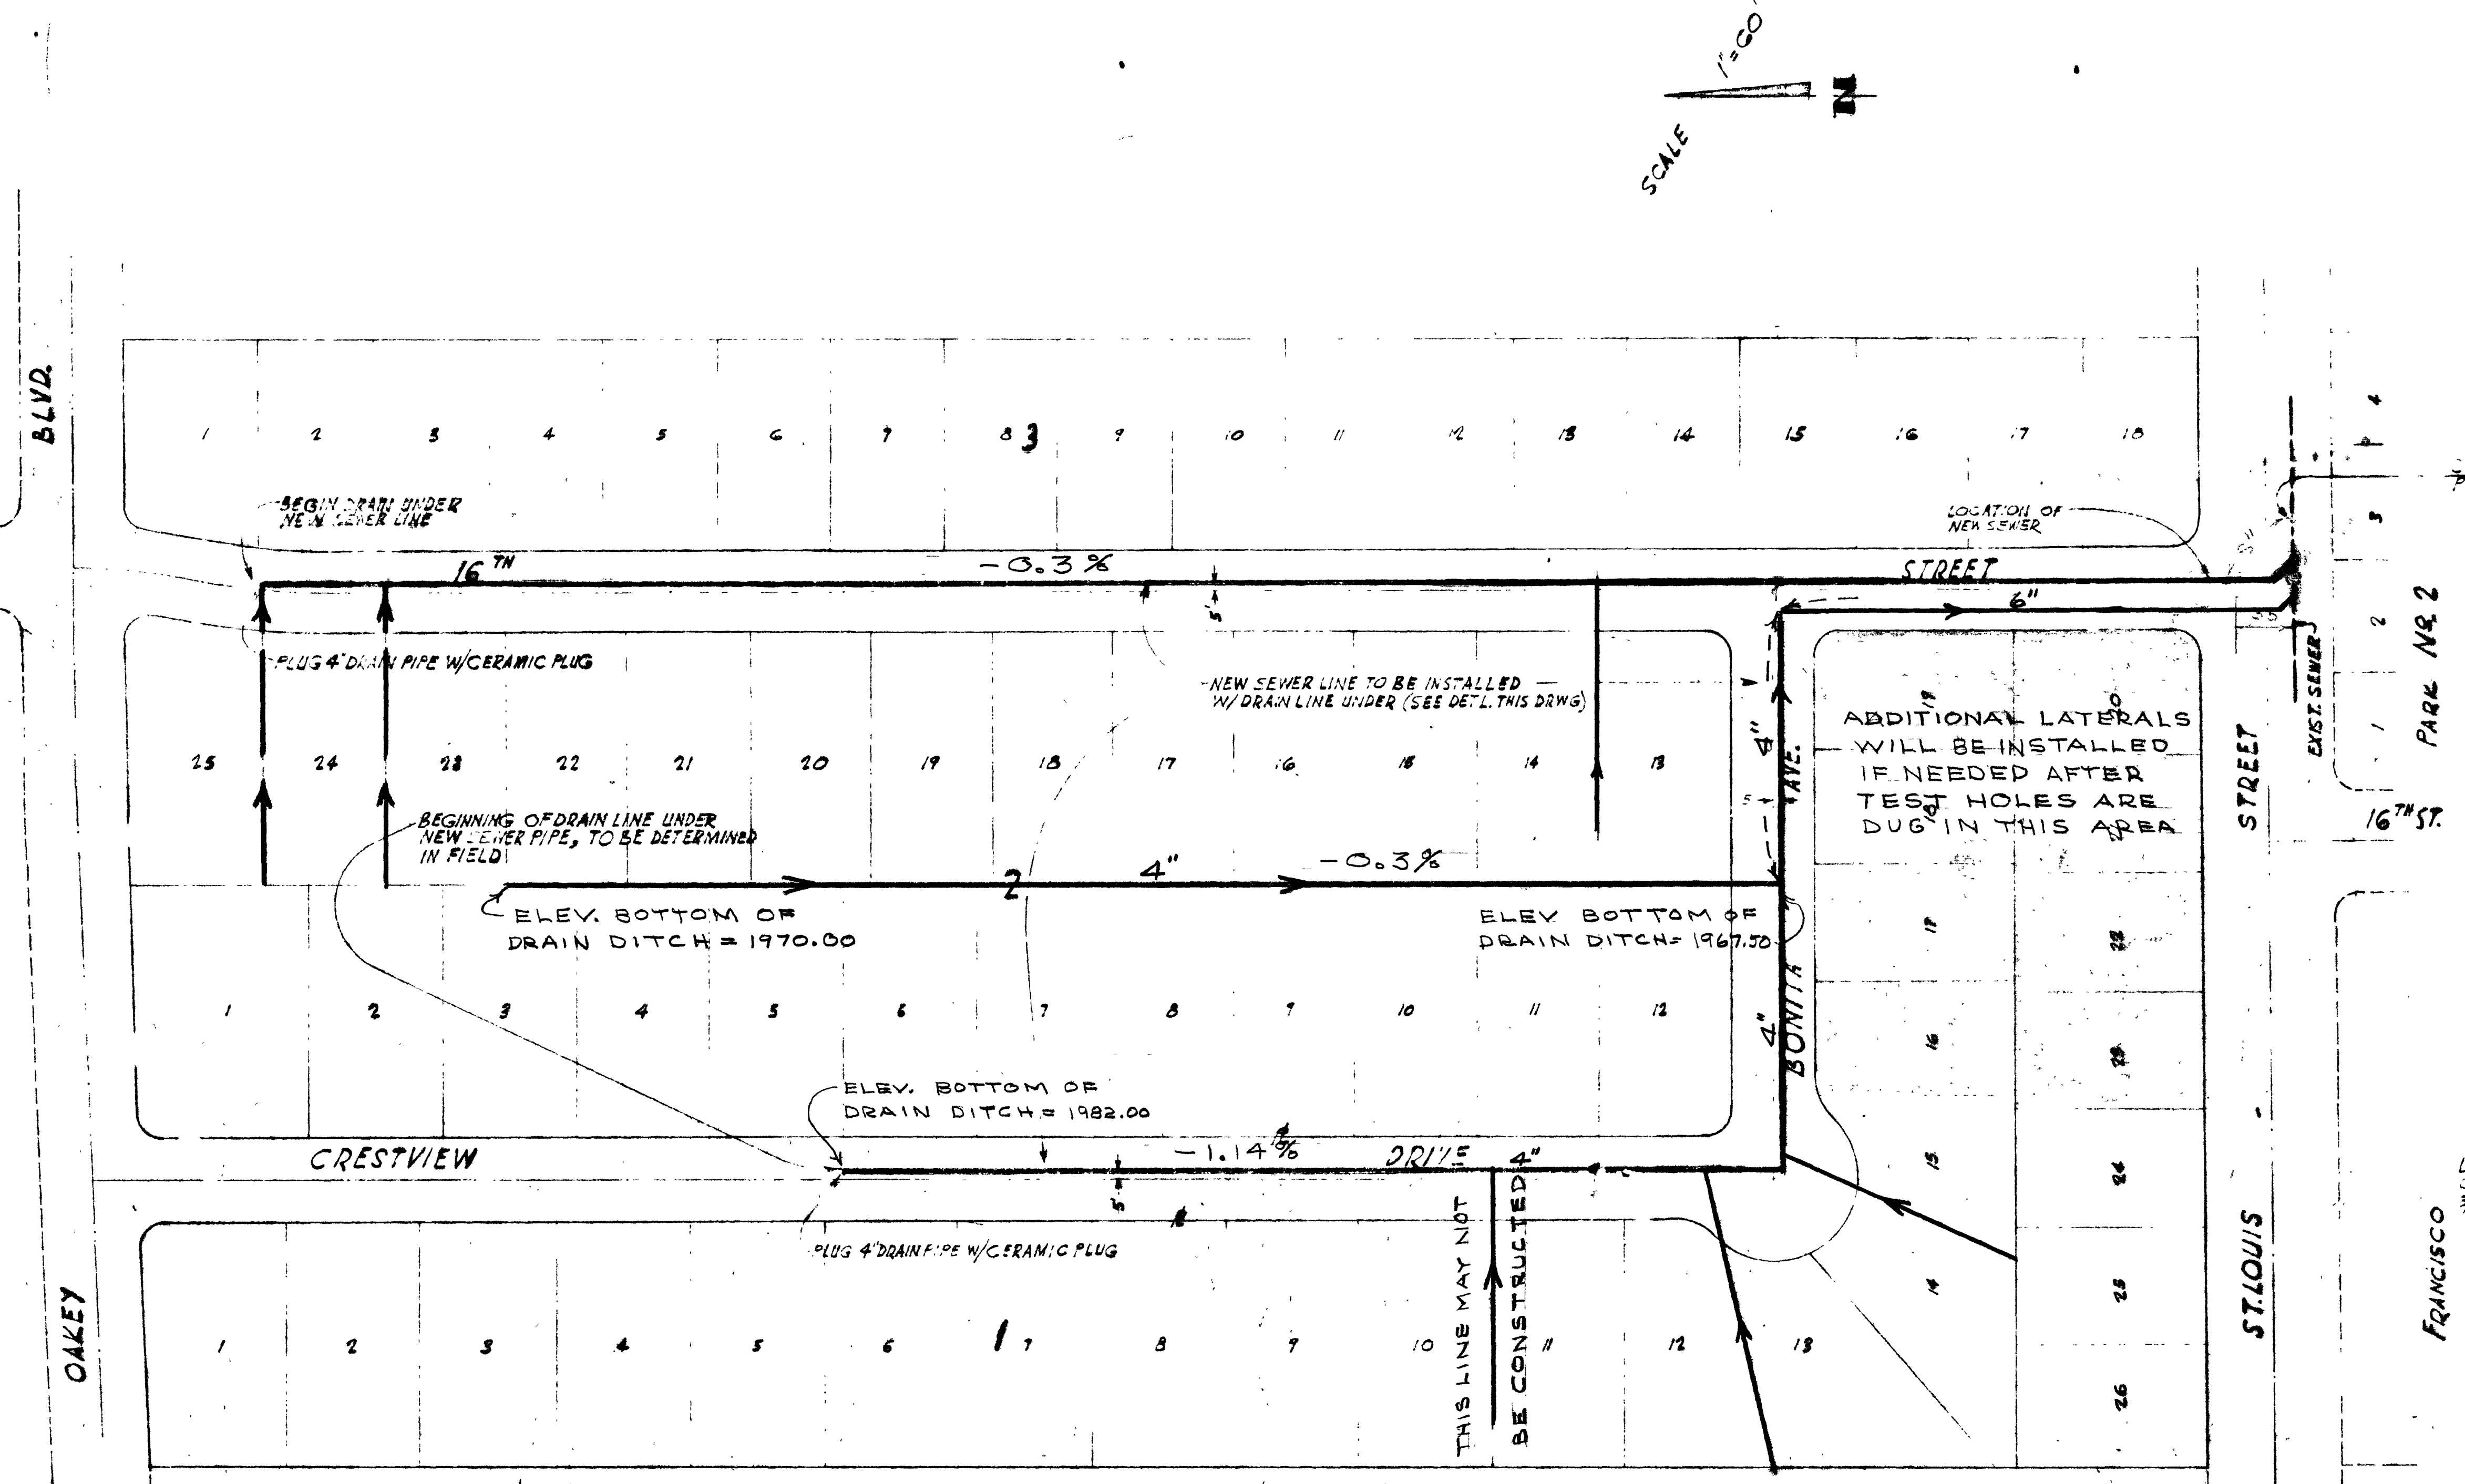

TYPICAL TRENCH SECTION
SCALE: 3/4"=1'-0"
IN STREETS ONLY
LOT DRAINS WILL BE 2'
OF LEACH ROCK WITH
BUILDING PAPER COVER

UNDERGROUND DRAINAGE PLAN
SCALE: 1"=20'

CITY OF LAS VEGAS
ENGINEERING DEPT.


Approval of this plan by the City of Las Vegas, Nevada,
does not relieve the Subdivider of responsibility for errors
in calculation, design, or planning by the Subdivider.
Engineer or Surveyor.

APPROVED AS TO DESIGN ONLY
Contractor will be responsible for
details, dimensions and conformity
to the design drawings.
Date 11-15-58
By [Signature]


REVISED 12-17-56
REVISED 11-14-56
APPROVED: [Signature]
GEORGE E. WADE
CITY ENGINEER, LAS VEGAS, NEVADA

DATE 11-15-56

PLAN & SECTION		
UNDERGROUND DRAINAGE		
FOR		
CRESTVIEW ESTATES		
CITY OF LAS VEGAS - NEVADA		
SCALE	PER LITER & SORING	DRWG. NO.
AS SHOWN	ENGINEERS	1
DATE	225 SO. HILL ST. LOS ANGELES	OF 1
MAY 1956		

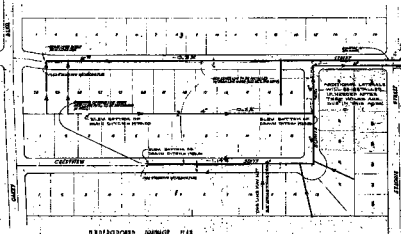

PROPOSED DRAINAGE PLAN

 

TYPICAL DRAINAGE SECTION
 IN STREETS ONLY.
 LOT DRAINAGE WILL BE 12" SP. LEACH SCREEN WITH BUILDING PAPER COVER.

**CITY OF LAS VEGAS
 ENGINEERING DEPT.**

Approved for Release by the City of Las Vegas, Nevada
 and for release to the public of the City of Las Vegas, Nevada
 in accordance with the provisions of the Nevada
 Public Access Act.

DESIGNED BY
W. H. HARRIS
 ENGINEER

RECEIVED
 ENGINEERING DEPT.
 MAY 10 1956
 W. H. HARRIS
 ENGINEER

DATE: 12-15-56

PLAN & SECTION

PROPOSED DRAINAGE

CRESTVIEW ESTATES

100% DEVELOPED
 100% IMPROVED
 100% MAINTAINED
 100% OPERATED

100% FINISHED
 100% COMPLETED
 100% DELIVERED
 100% ACCEPTED