


CITY OF LAS VEGAS NEVADA

UNION PACIFIC INDUSTRIAL DISTRICT

STREETS STORM DRAIN SYSTEM WATER SYSTEM

INDEX

SHEET NO.	DESCRIPTION
1	Title sheet - Key Map - Index
2	General Layout Plan
3	"F" Street
4	Dividend Dr.
5	Dividend Dr.
6	Discovery Dr.
7	Discovery Dr.
8	Alta Drive
9	Storm Drain Ensement
10	Claim Avenue
11	Statehood Street
12	Statehood railroad crossing
13	Details at Charleston Boulevard
14	Water line - Charleston Boulevard
15	Water Distribution System
16	Fire Alarm System
17	Details
18	Details
19	Details
20	Details
21	Details

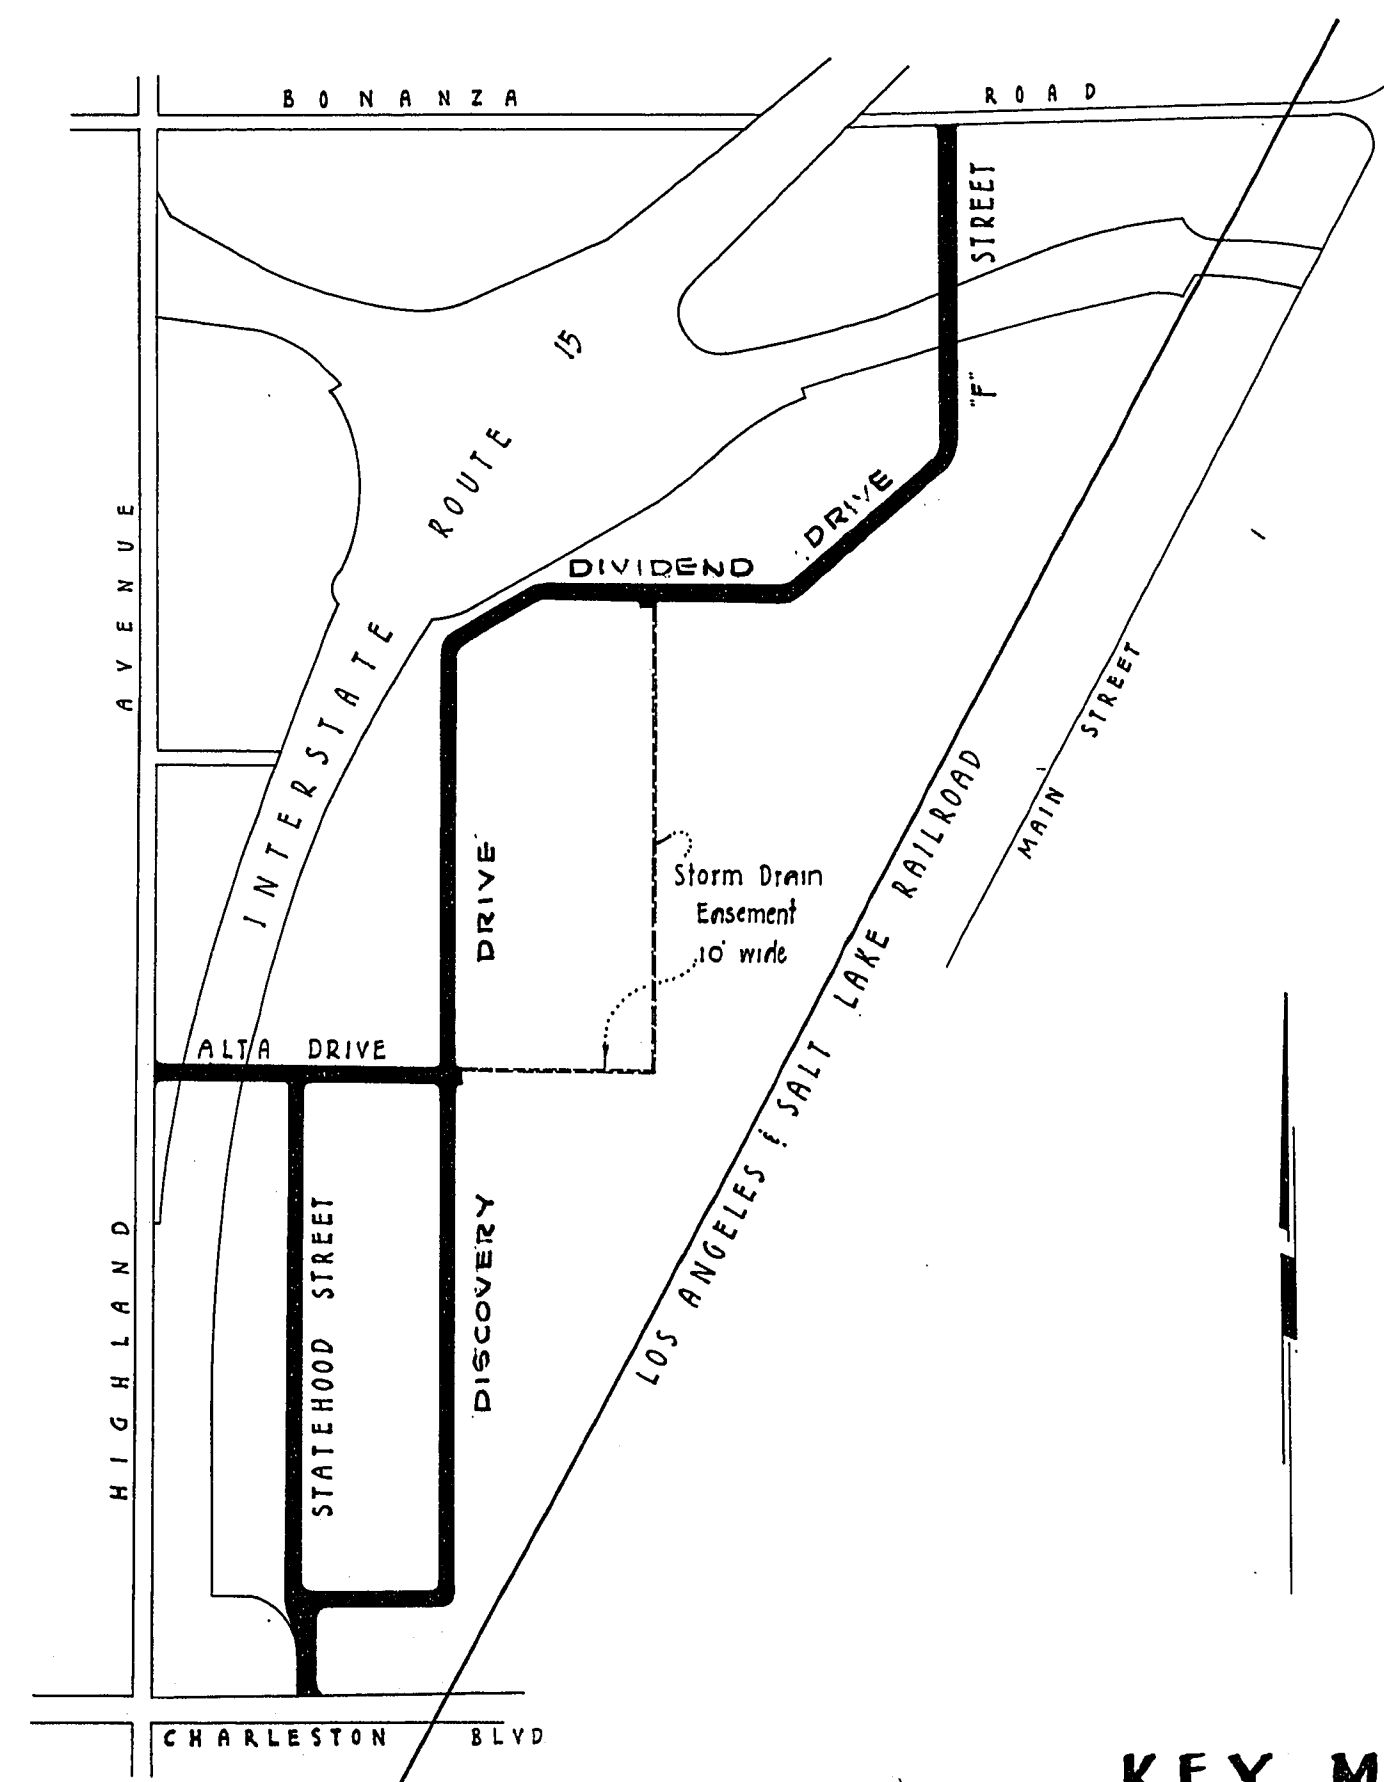

KEY MAP

AS-BUILT
JULY 23 1970

MAYOR

ORAN K. GRAGSON

COMMISSIONERS

PHILLIP M. MIRABELLI
S. GRANT STEWART
JAMES COREY
WESLEY G. HOWERY

CITY MANAGER

A. R. TRELEASE

DIRECTOR OF PUBLIC WORKS

RICHARD P. SAUER

Sewer
Water
Fire Alarm

see 307-115 (shts 1-12)
see 565-99 (shts 14-15)
see 636-32 (sht-16)

107V 799

15-4-160 Sheet 1 of 21 Sheets