

IMPROVEMENT PLANS

FOR

UNIVERSITY MEDICAL CENTER ER/ICU/CCU ADDITION

1800 W. CHARLESTON BLVD.

CITY OF LAS VEGAS

STATE OF NEVADA


DEVELOPED BY:

UNIVERSITY MEDICAL CENTER

1800 W. CHARLESTON BLVD.

LAS VEGAS, NEVADA

APN: 139-33-405-001, 193-33-410-001 THRU 027

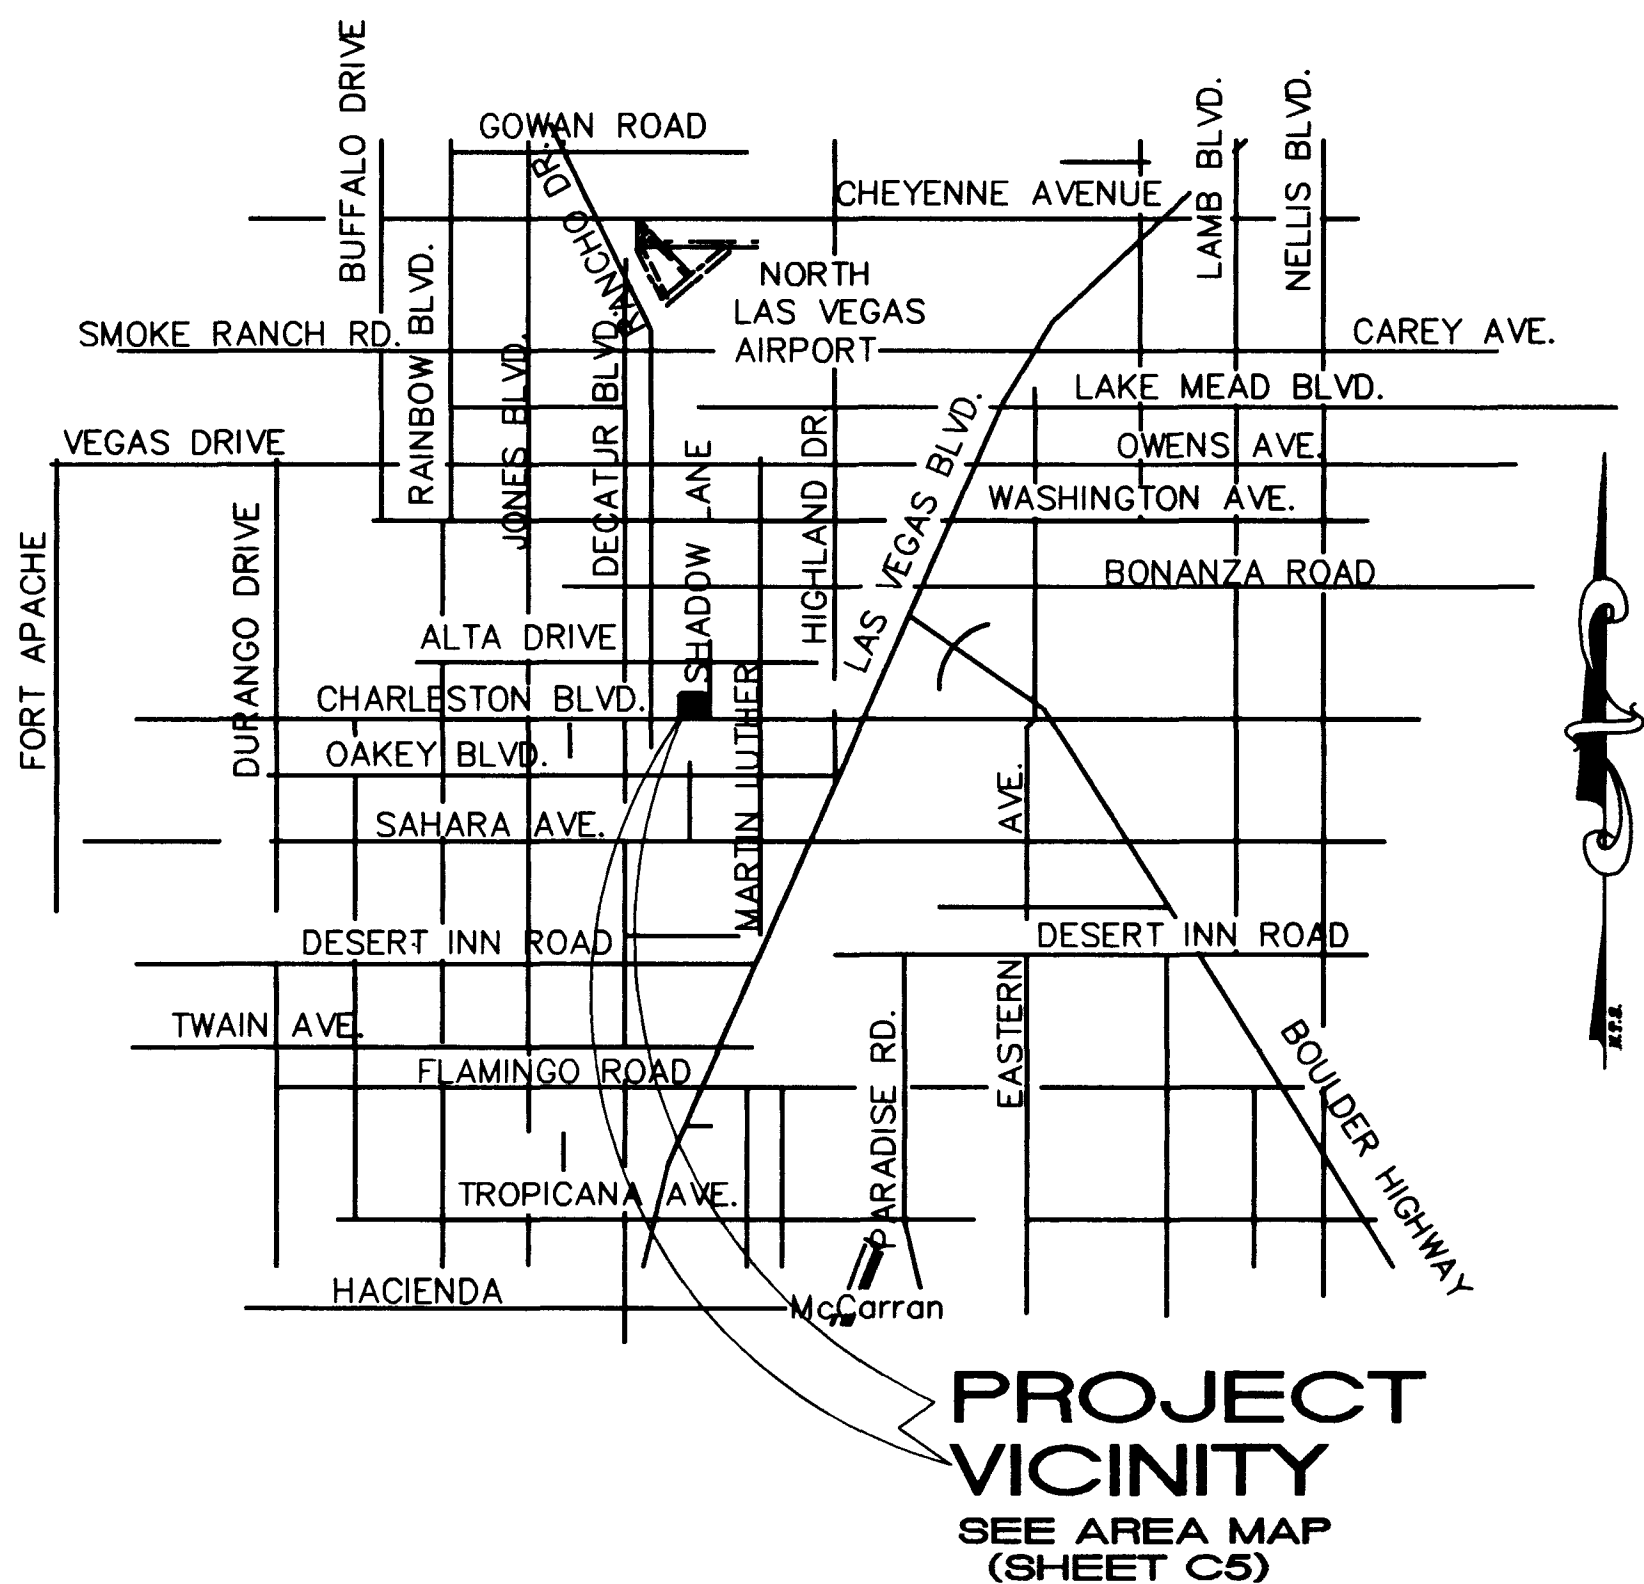

APPROVALS

Charles Kajkowski, Jr. 4-7-99
CHARLES KAJKOWSKI, JR., R.P.E. 4784 DATE
CITY PLANNING ENGINEER

Approval of these plans by the City Planning Engineer is limited to those improvements constructed in the dedicated rights-of way and/or dedicated easements. This approval does not authorize the construction of any improvements that deviate from the adopted standards and/or specifications except those specifically listed under "Deviations from Standards." The Engineer shall resolve any deviations other than those listed in "Deviations from Standards" in favor of the Uniform Standard Drawings and Specifications, Clark County Area, Nevada.

John Marshall 8-20-98
CITY FIRE MARSHALL DATE

LAS VEGAS VALLEY WATER DISTRICT DATE

W. W. 9-16-98
NEVADA POWER COMPANY DATE

Charles McQuinn 9-16-98
SOUTHWEST GAS COMPANY DATE

Nigel Smith 9-16-98
SPRINT TELEPHONE COMPANY DATE

Mitch Rosenberg 9-24-98
COMMUNITY CABLE DATE

NOTE :
THESE PLANS SHALL NOT BE, IN PART OR IN WHOLE, BE USED
FOR CONSTRUCTION UNTIL APPROVED AND SIGNED BY THE
GOVERNING AGENCIES.

Ted H. Lyon 3/2/99
TED H. LYON, P.E. No. 5426 DATE
THE WLB GROUP, INC.
2551 NORTH GREEN VALLEY PKWY. SUITE A425
HENDERSON NV. 89014
TEL. (702) 458-2551

INDEX SHEETS

- | | |
|------------------------------|--------------------------------------|
| C1. COVER SHEET | C7. GRADING PLAN SHEET |
| C2. GENERAL NOTES | C8. STORMDRAIN PLAN & PROFILE SHEET |
| C3. QUANTITIES | C9. STORMDRAIN PLAN & PROFILE SHEET |
| C4. DEMOLITION PLAN | C10. CONSTRUCTION SCHEDULE & PHASING |
| C5. HORIZONTAL CONTROL SHEET | C11. DETAIL SHEET |
| C6. UTILITY PLAN SHEET | C12. DETAIL SHEET |
| | C13. DETAIL SHEET |

REV	DATE	BY	REVISION

ARCHT: HOLMES SABATINI ASSOCIATES

1 COMMERCIAL CENTER DRIVE
HENDERSON, NV. 89014
(702) 458-1108

Engineering • Landscape Architecture
Planning • Urban Design • Surveying
2551 N. Green Valley Pkwy. Suite A425
HENDERSON, NV. 89014 (702) 458-2551

The WLB Group

COVER SHEET

SHEET TITLE:

PROJECT:
UNIVERSITY MEDICAL CENTER
ER/ICU/CCU ADDITION

Drawn by: 9/19/98

OF

Designed by: TDA

Checked by: KBA

Project No.: 497024A001

Scale: N/A

11/25/98
SHEET
C1
1 OF 13 SHEETS
DRAWING NO.
107-V2911

01. CONCRETE BRICK	07. STUCCO, PLASTER BRICK
02. STUCCO BRICK	08. STUCCO PLASTER PLANK & BOARD BRICK
03. (CONCRETE)	09. STUCCO PLASTER PLANK & BOARD BRICK
04. STUCCO PLANK	10. STUCCO PLASTER STUCCO PLANK & BOARD
05. STUCCO PLANK, BRICK	11. STUCCO BRICK
06. STUCCO PLANK BRICK	12. STUCCO BRICK