

Avoid cutting underground utility lines. It's costly.

Call before you dig.

1-800-227-2600

BENCHMARK

CCBM No. 7C115SWS
RIVET AND SQUARE ALUMINUM PLATE IN TOP OF CURB NORTHEAST CORNER OF SAHARA AVE. AND VALLEY VIEW BLVD. NEAR THE PC OF SAHARA AVE.

ELEV=657.636 METERS
=2157.594 FEET

BASIS OF BEARINGS


THE EAST LINE OF THE SE 1/4 OF SECTION 7, T 21 S, R 61 E, M.D.M., BEING THE CENTERLINE OF VALLEY VIEW BLVD., BEARS N 01°22'50"14" W AS SHOWN ON PARCEL MAP FILE 7, PAGE 5, OFFICIAL RECORDS OF CLARK COUNTY, NEVADA.

CONSTRUCTION NOTES

- ① NEW LOCATION FLOODLIGHT.
- ② NEW LOCATION ANTISYPHON VALVE.
- ③ NEW LOCATION SIGN.
- ④ NEW LOCATION AIR/WATER SERVICES.
- ⑤ NEW LOCATION SIGN.
- ⑥ NEW LOCATION FLOODLIGHT.
- ⑦ NEW LOCATION 40' HIGH SIGN.
- ⑧ NEW LOCATION ANTISYPHON VALVE.
- ⑨ NEW LOCATION 22' HIGH SIGN.

NOTES

- 1.) SEE SHEET 3 FOR SYMBOL IDENTIFICATION AND LEGEND.
- 2.) STATIONS AND OFFSETS TO NEW LOCATIONS REPRESENT THE CENTER OF ITEMS TO BE RELOCATED AFTER RELOCATION.
- 3.) CONTRACTOR TO SUBMIT TO ENGINEER FOR APPROVAL SHOP DRAWINGS DETAILING THE RELOCATION OF ITEMS SPECIFIED IN THESE CONTRACT DRAWINGS AND IN THE SPECIAL PROVISIONS. DRAWINGS TO INCLUDE FOUNDATION DETAILS, ELECTRICAL DETAILS, STRUCTURAL DETAILS, ENGINEERING CALCULATIONS, AND ANY OTHER INFORMATION NEEDED FOR COMPLETION OF WORK. LOCATION WITH REFERENCE TO RIGHT OF WAY AND PROPERTY LINES WILL ALSO BE SHOWN.
- 4.) SEE SHEET 3 FOR SYMBOL LEGEND AND IDENTIFICATION.

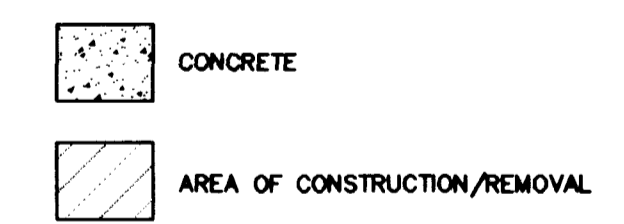

DATE	9/25/97	REVISIONS	CONSTRUCT NEW TEXACO PYLON SIGN 7A & 7B
W.A. #	W16627	DESIGN BY	ESM
SCALE (V)	N/A	DATE	MARCH 3, 1997
SCALE (H)	1"=10'	FLD. BK. #	N/A
ENGINEERING DESIGN SECTION			
CITY ENGINEER: DENNIS ANDERSON, P.E. PROJECT MANAGER: THERESA HARRAHAN, P.E.			
DEPARTMENT OF PUBLIC WORKS		PROJECT: VALLEY VIEW BOULEVARD SAHARA AVENUE FACILITIES RELOCATION PLANS	
SHEET: RELOCATION PLAN		DRAWING NO. 107-V2639 4/4	
BID #97.1730.19			