


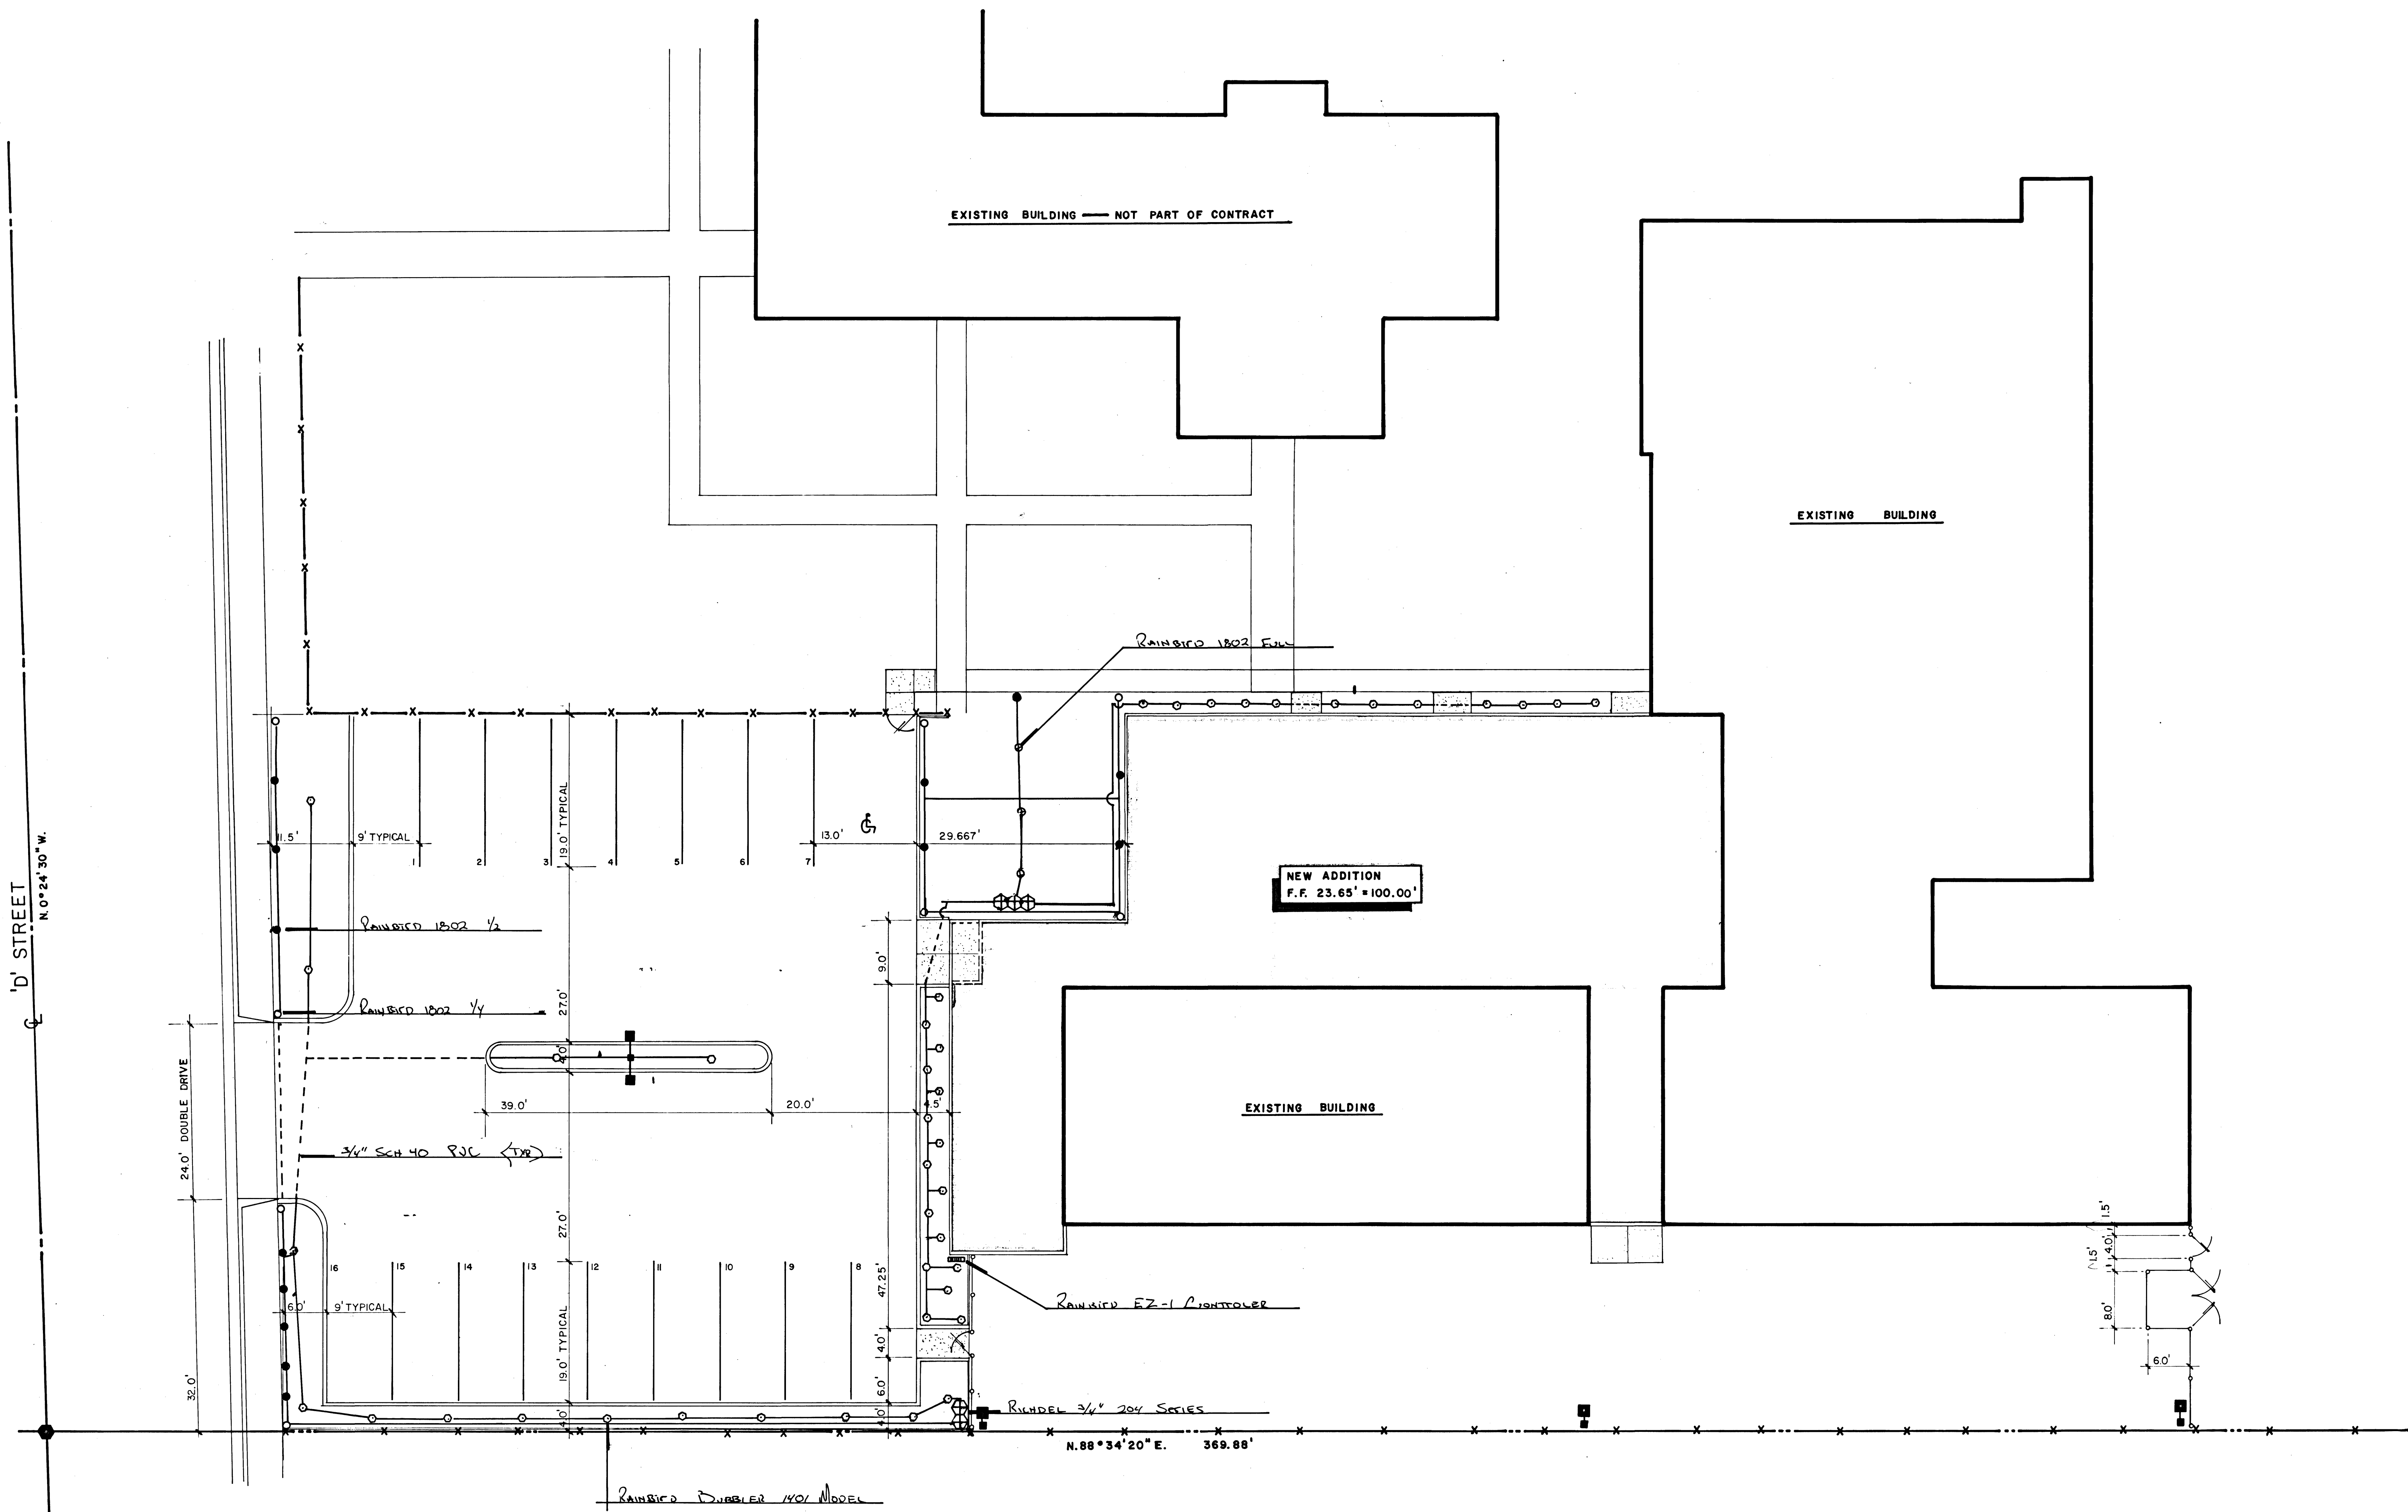

IRRIGATION PLAN

1" = 10'

NOTE: CONTRACTOR SHALL PROVIDE TIE-IN TO BUILDING DOMESTIC WATER SYSTEM - PROVIDING ADEQUATE WATER FLOW PRESSURE FOR IRRIGATION SYSTEM

CITY OF LAS VEGAS
400 EAST STEWART AVENUE
LAS VEGAS, NEVADA 89101

ARCHITECT • GERALD GARAPICH & ASSOCIATES A.I.A.
2300 FIFTH AVENUE, SUITE 201, SAN DIEGO, CA 92101 (619) 233-7296
2300 PASEO DEL PRADO, C-108, LAS VEGAS, NV 89002 (702) 367-4445

PHASE I (VARIETY CLUB)
70' STREET / JEFFERSON AVENUE
NEIGHBORHOOD FACILITY PROJECT

IRRIGATION PLAN


drawn by: dan l. neider
issue dates:
11/3/88
11/22/88 bidding
revisions:
2/1/89 2nd bidding

job no.: 8737 LV

L.2

6

COPYRIGHT 1988 GERALD GARAPICH A.I.A.

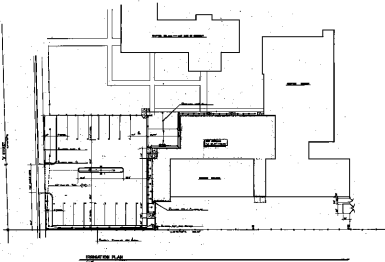

FLOOR PLAN

NOTE: DIMENSIONS SHALL BE GIVEN FROM THE CENTER
 OF THE WALL UNLESS OTHERWISE SPECIFIED
 UNLESS NOTED OTHERWISE

BY: [Signature]
 DATE: 10/10/2010
 1010 EAST BROADWAY AVENUE
 LAS VEGAS, NEVADA 89101

PROJECT: 1010 EAST BROADWAY AVENUE
 SHEET: 1010 EAST BROADWAY AVENUE
 DATE: 10/10/2010
 1010 EAST BROADWAY AVENUE
 LAS VEGAS, NEVADA 89101