


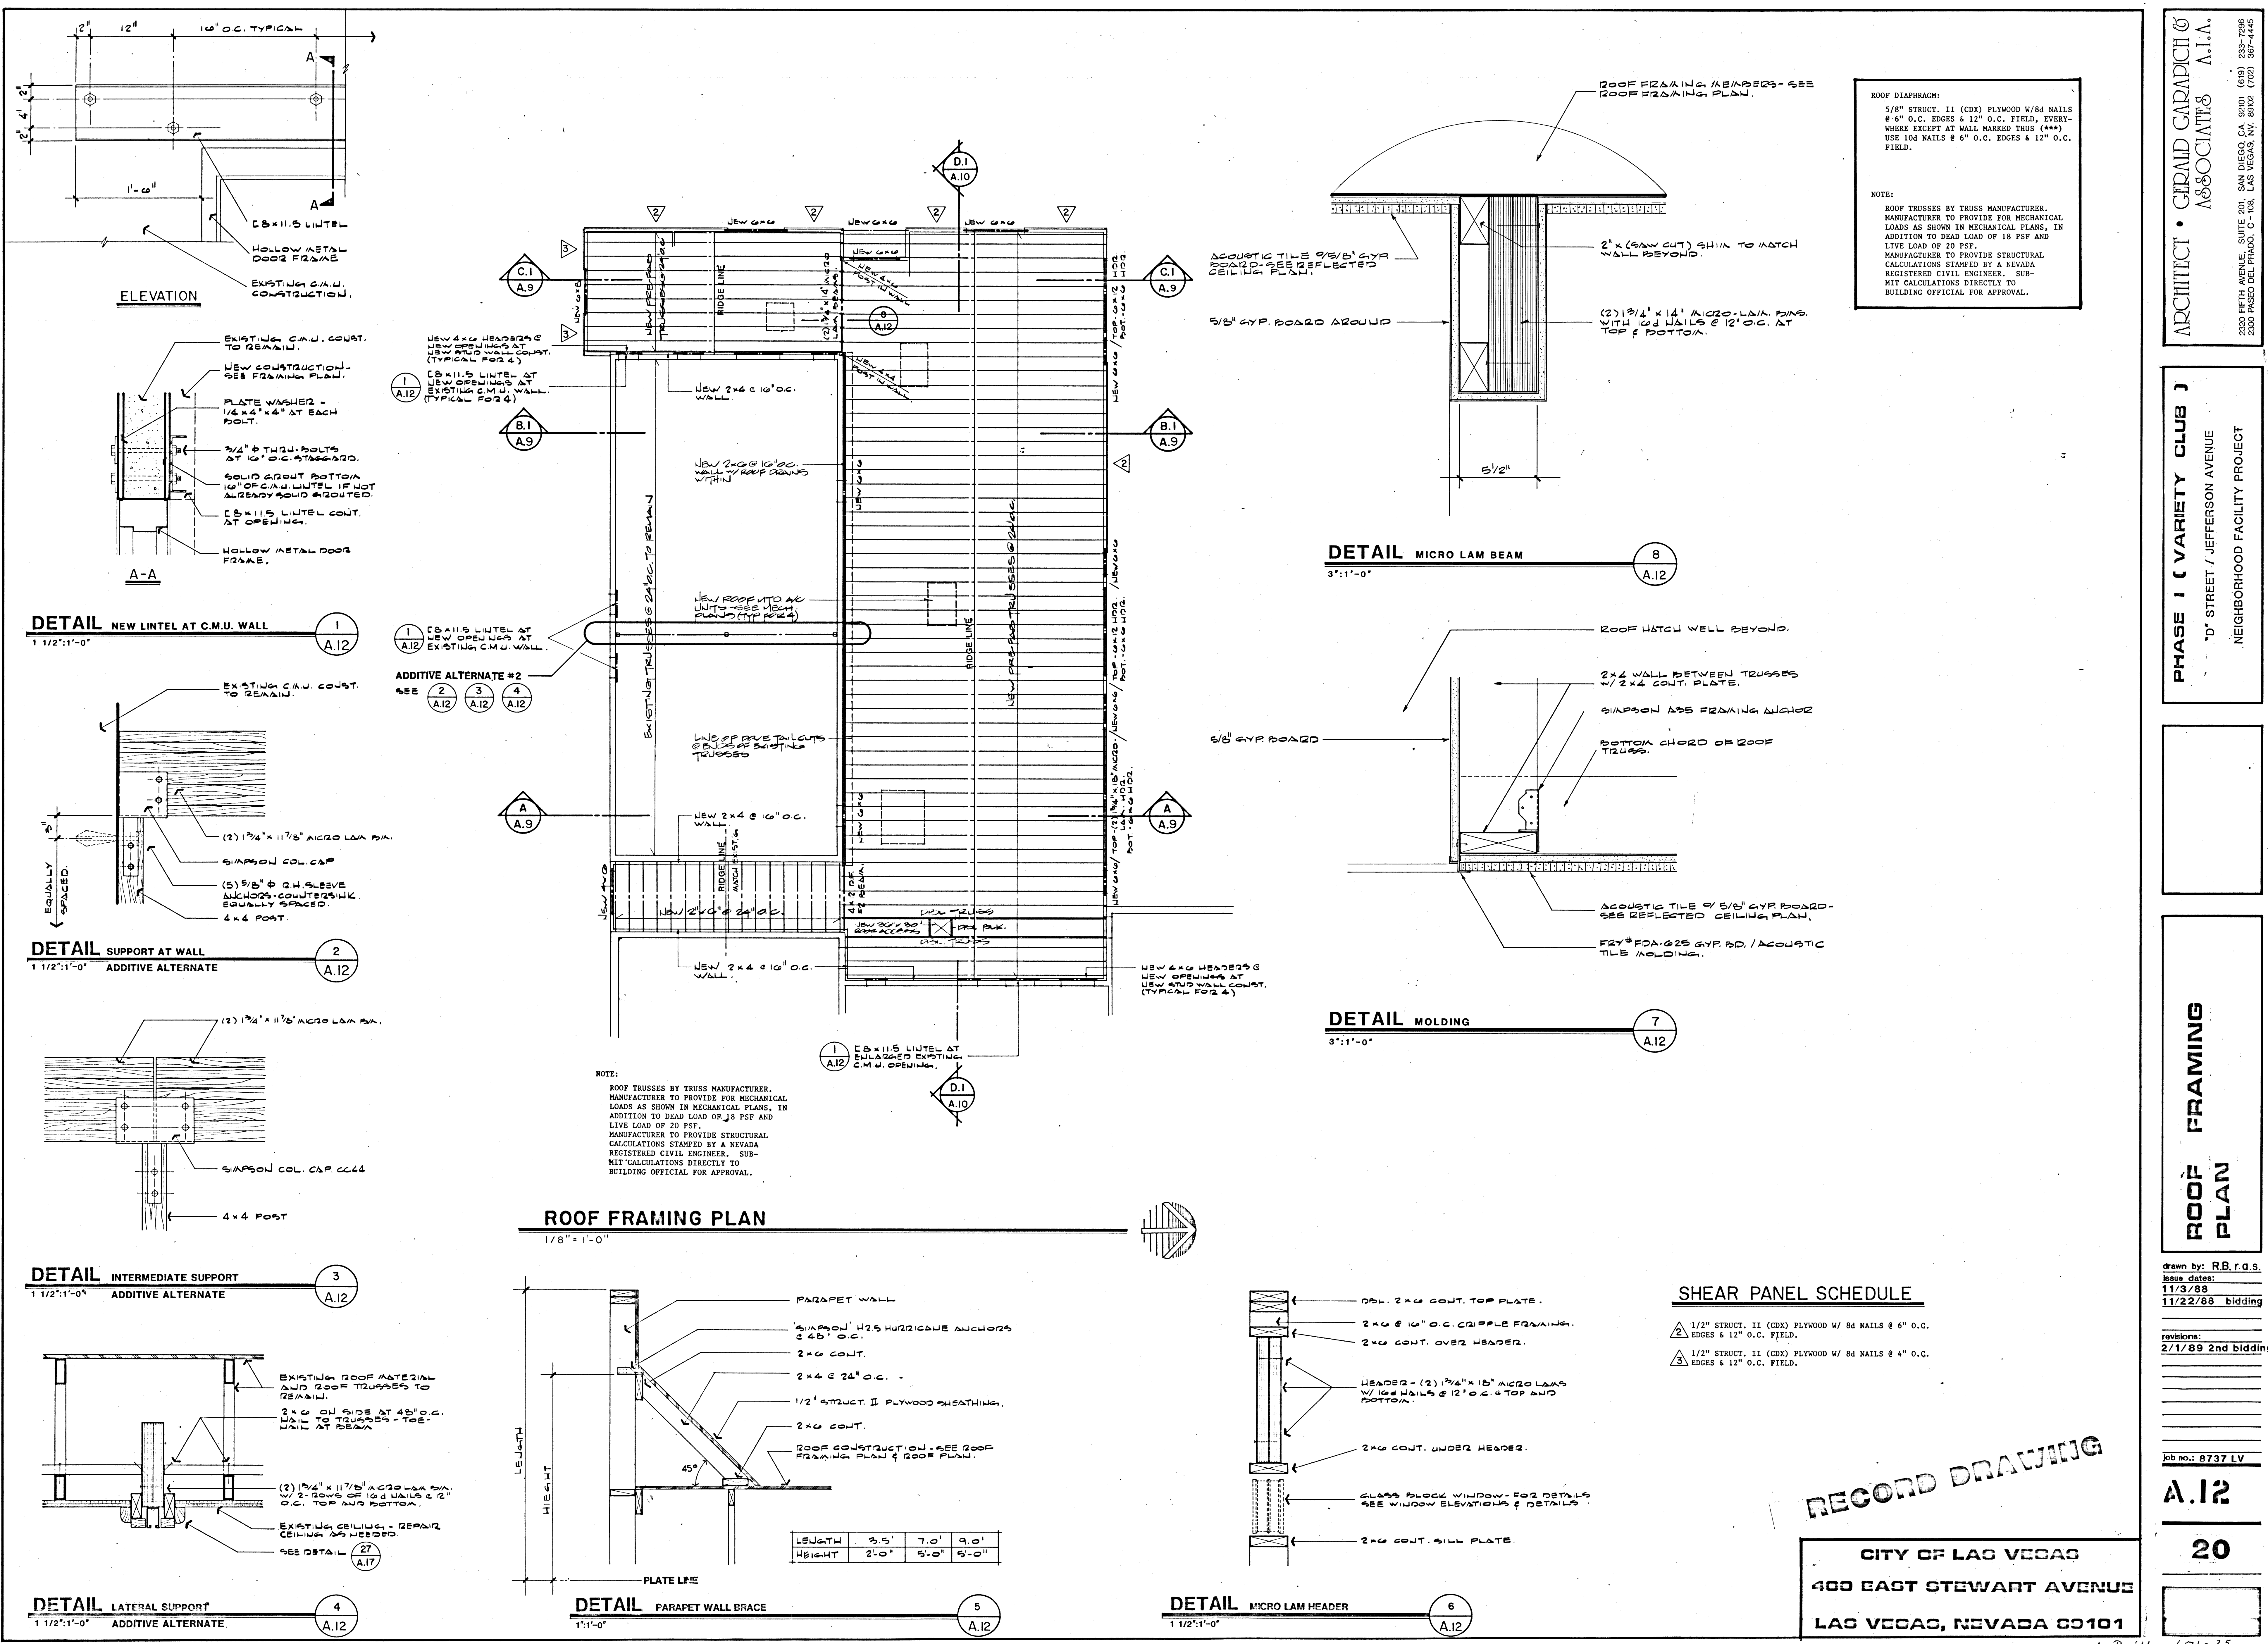

ROOF DIAPHRAGM:
5/8" STRUCT. II (CDX) PLYWOOD W/8d NAILS
@ 4" O.C. EDGES & 12" O.C. FIELD, EVERY-
WHERE EXCEPT AT WALL MARKED THUS (***)
USE 10d NAILS @ 6" O.C. EDGES & 12" O.C.
FIELD.

NOTE:
ROOF TRUSSES BY TRUSS MANUFACTURER.
MANUFACTURER TO PROVIDE FOR MECHANICAL
LOADS AS SHOWN IN MECHANICAL PLANS, IN
ADDITION TO DEAD LOAD OF 18 PSF AND
LIVE LOAD OF 20 PSF.
MANUFACTURER TO PROVIDE STRUCTURAL
CALCULATIONS STAMPED BY A NEVADA
REGISTERED CIVIL ENGINEER. SUB-
MIT CALCULATIONS DIRECTLY TO
BUILDING OFFICIAL FOR APPROVAL.

NOTE:
ROOF TRUSSES BY TRUSS MANUFACTURER.
MANUFACTURER TO PROVIDE FOR MECHANICAL
LOADS AS SHOWN IN MECHANICAL PLANS, IN
ADDITION TO DEAD LOAD OF 18 PSF AND
LIVE LOAD OF 20 PSF.
MANUFACTURER TO PROVIDE STRUCTURAL
CALCULATIONS STAMPED BY A NEVADA
REGISTERED CIVIL ENGINEER. SUB-
MIT CALCULATIONS DIRECTLY TO
BUILDING OFFICIAL FOR APPROVAL.

LENGTH	3.5'	7.0'	9.0'
HEIGHT	2'-0"	5'-0"	5'-0"

SHEAR PANEL SCHEDULE

- 1/2" STRUCT. II (CDX) PLYWOOD W/ 8d NAILS @ 6" O.C. EDGES & 12" O.C. FIELD.
- 1/2" STRUCT. II (CDX) PLYWOOD W/ 8d NAILS @ 4" O.C. EDGES & 12" O.C. FIELD.

RECORD DRAWING

CITY OF LAS VEGAS
400 EAST STEWART AVENUE
LAS VEGAS, NEVADA 89101

ARCHITECT • GERALD CARADACH & ASSOCIATES A.I.A.
2300 FIFTH AVENUE, SUITE 201, SAN DIEGO, CA 92101 (619) 233-7296
2300 PASO DEL PRADO, C-108, LAS VEGAS, NV 89122 (702) 367-4446

PHASE I (VARIETY CLUB)
"D" STREET / JEFFERSON AVENUE
NEIGHBORHOOD FACILITY PROJECT

ROOF FRAMING
PLAN

drawn by: R.B.T.G.S.
Issue dates:
11/3/88
11/22/88 bidding
revisions:
2/1/89 2nd bidding

job no.: 8737 LV
A.12
20

