

SHEET NOTES


1. 1/4" DISCHARGE FROM SP-1 THRU FACE OF CURB TO SPILL ON GRADE WITH A GATE VALVE & CHECK VALVE ON DISCHARGE LINE AT SP-1. DELETED
2. NEW 2" WASTE. CONNECT TO EXIST. KITCHEN WASTE SYSTEM. VERIFY LOCATION.
3. NEW 3/4" HW. CONNECT TO EXIST. KITCHEN HW SYSTEM. VERIFY LOCATION.
4. NEW DISHWASHER FURNISHED BY OTHERS; ROUGH-IN & FINAL CONNECT BY FLGG. CONTR.
5. 3" RD & 3" ORD
6. DROP 3" SD & 3" ORD TO 6" AB. CR. & SPILL TO GRADE.

7. SEE CIVIL DRAWINGS FOR CONTINUATION.
8. T & P RELIEF VALVE DISCHARGE PIPED FULL SIZE TO 6" ABOVE GRADE.
9. CONNECT NEW 1" CW TO EXISTING ADEQUATELY SIZE LINE IN THIS AREA, VERIFY EXACT LOCATION.
10. NEW GAS PIPING ATOP ROOF.
11. MAKE NEW FULL SIZE CONNECTION TO EXISTING GAS LINE ATOP ROOF.
12. REMOVE EXISTING (SHOWN DASHED) GAS PIPING IN ITS ENTIRETY. REPLACE WITH NEW GAS LINE ATOP ROOF & RECONNECT ALL EXISTING (ACTIVE) EQUIPMENT.

13. EXISTING GAS METER TO BE REMOVED.
14. PROPOSED LOCATION OF NEW GAS METER.
15. CONNECT TO EXISTING INCOMING GAS SERVICE.
16. EXISTING GAS LINE ATOP ROOF TO REMAIN.
17. 4" SD & 4" ORD DOWN FROM 4" RD & 4" ORD & DOWN TO BELOW GRADE. DELETED
18. 1 1/2" V. UP FROM BELOW GRADE & UP THRU ROOF. DELETED
19. CP-1 IN A 24" X 24" X 24" PRECAST CONCRETE SUMP W/ GAS TIGHT MANHOLE. DELETED

GENERAL NOTES

1. SEE ARCHITECTURAL DOCUMENTS FOR DESCRIPTION OF BOUNDARIES OF NEW & EXISTING CONSTRUCTION.
2. SEE ARCHITECTURAL DOCUMENTS FOR DESCRIPTION OF ALTERNATES.
3. VERIFY EXTENT OF GAS UTILITY CO. WORK PRIOR TO BID.

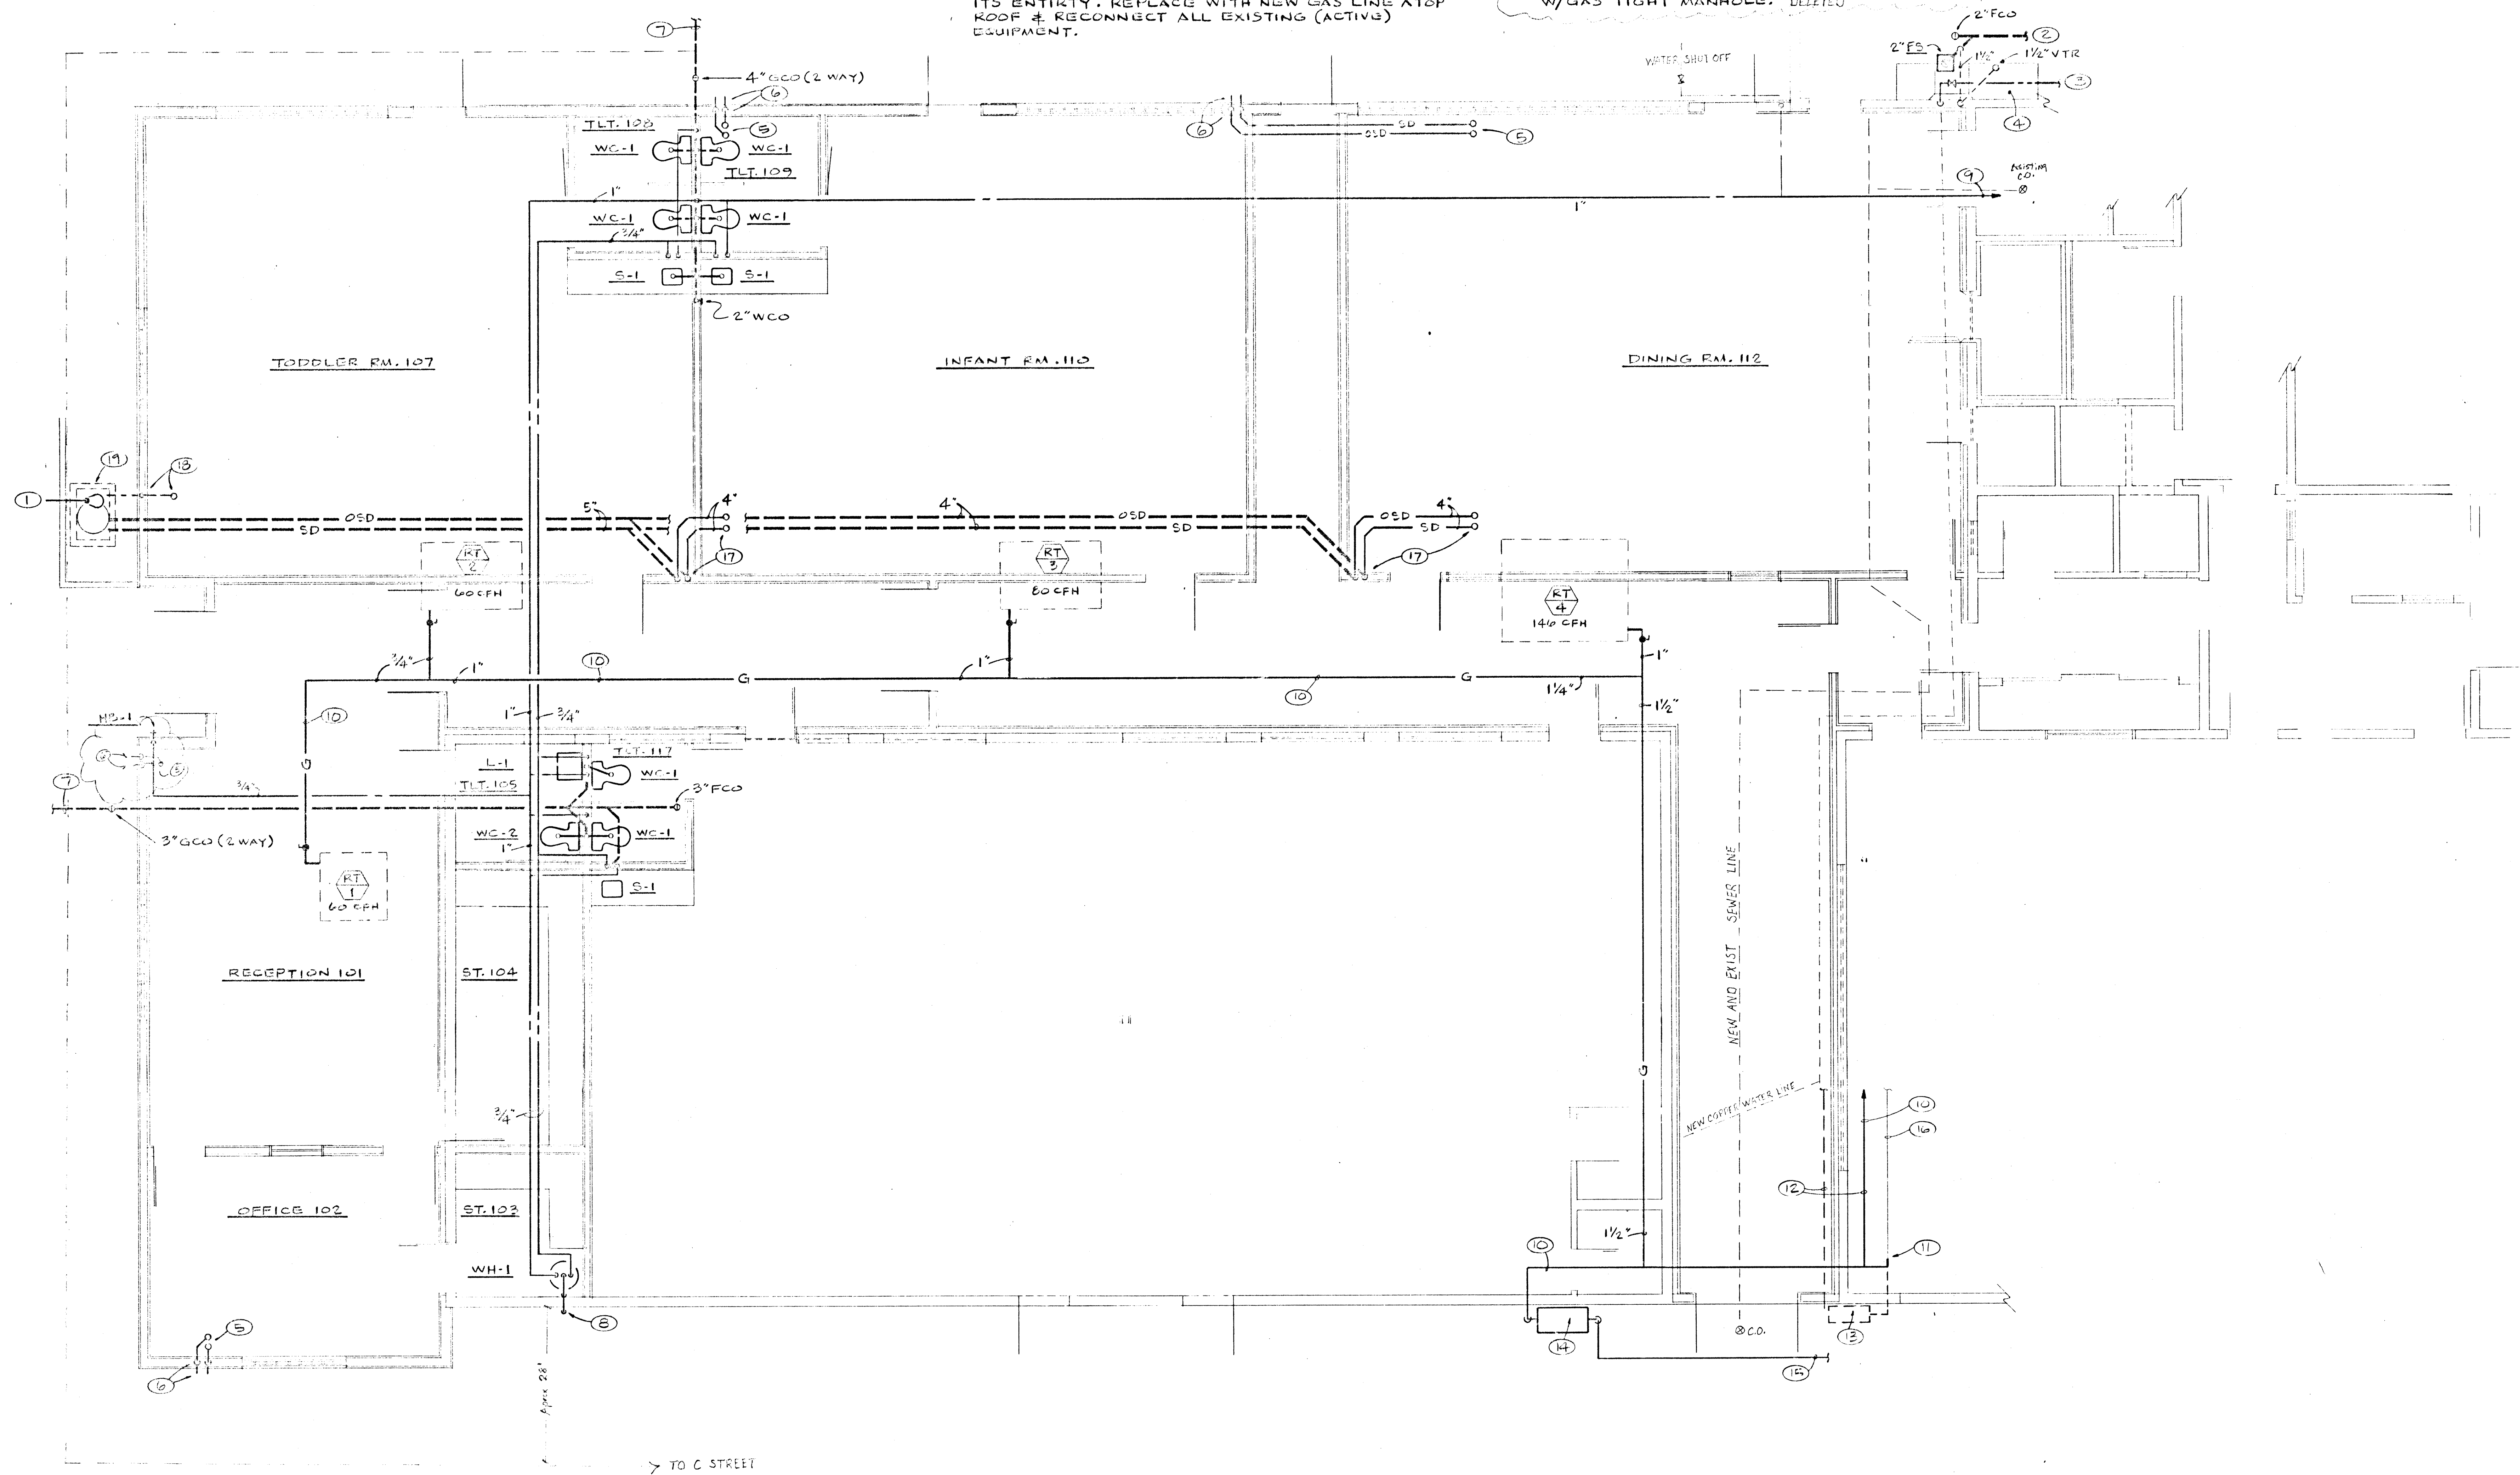

PLUMBING FLOOR PLAN
SCALE: 1/4" = 1'-0"

HARRIS ENGINEERS, INC.
MECHANICAL/ELECTRICAL CONSULTANTS
2785 East Oakes Inn Road, Suite 280
Las Vegas, Nevada 89121
702/796-0228

CITY OF LAS VEGAS
400 EAST STEWART AVENUE
LAS VEGAS, NEVADA 89101

ARCHITECT • **GERALD GARAPICH & ASSOCIATES A.I.A.**
200 FIFTH AVENUE, SUITE 201, SAN DIEGO, CA 92101 (619) 237-7293
2000 PASEO DEL PRADO, C-114, LAS VEGAS, NV 89121 (702) 367-4445

PHASE I (VARIETY CLUB)
"D" STREET / JEFFERSON AVENUE
NEIGHBORHOOD FACILITY PROJECT

PLUMBING FLOOR PLAN

drawn by: R.B.
issue dates:
11/3/88
11/22/88 bidding
revisions:
2/1/89 2nd. bidding
job no.:
M.12
27
As Built 671-25

1. ALL DIMENSIONS ARE TO FACE UNLESS NOTED OTHERWISE.
 2. ALL WALLS ARE 12" THICK UNLESS NOTED OTHERWISE.
 3. ALL FLOORS ARE 4" THICK CONCRETE UNLESS NOTED OTHERWISE.
 4. ALL ROOFS ARE 6" THICK CONCRETE UNLESS NOTED OTHERWISE.
 5. ALL CEILING ARE 8" THICK CONCRETE UNLESS NOTED OTHERWISE.
 6. ALL STAIRS ARE 10" THICK CONCRETE UNLESS NOTED OTHERWISE.
 7. ALL ELEVATORS ARE 10" THICK CONCRETE UNLESS NOTED OTHERWISE.
 8. ALL DOORS ARE 4" THICK UNLESS NOTED OTHERWISE.
 9. ALL WINDOWS ARE 4" THICK UNLESS NOTED OTHERWISE.
 10. ALL PARTITIONS ARE 4" THICK UNLESS NOTED OTHERWISE.


GENERAL NOTES

1. ALL DIMENSIONS ARE TO FACE UNLESS NOTED OTHERWISE.
2. ALL WALLS ARE 12" THICK UNLESS NOTED OTHERWISE.
3. ALL FLOORS ARE 4" THICK CONCRETE UNLESS NOTED OTHERWISE.
4. ALL ROOFS ARE 6" THICK CONCRETE UNLESS NOTED OTHERWISE.
5. ALL CEILING ARE 8" THICK CONCRETE UNLESS NOTED OTHERWISE.
6. ALL STAIRS ARE 10" THICK CONCRETE UNLESS NOTED OTHERWISE.
7. ALL ELEVATORS ARE 10" THICK CONCRETE UNLESS NOTED OTHERWISE.
8. ALL DOORS ARE 4" THICK UNLESS NOTED OTHERWISE.
9. ALL WINDOWS ARE 4" THICK UNLESS NOTED OTHERWISE.
10. ALL PARTITIONS ARE 4" THICK UNLESS NOTED OTHERWISE.

1. ALL DIMENSIONS ARE TO FACE UNLESS NOTED OTHERWISE.
 2. ALL WALLS ARE 12" THICK UNLESS NOTED OTHERWISE.
 3. ALL FLOORS ARE 4" THICK CONCRETE UNLESS NOTED OTHERWISE.
 4. ALL ROOFS ARE 6" THICK CONCRETE UNLESS NOTED OTHERWISE.
 5. ALL CEILING ARE 8" THICK CONCRETE UNLESS NOTED OTHERWISE.
 6. ALL STAIRS ARE 10" THICK CONCRETE UNLESS NOTED OTHERWISE.
 7. ALL ELEVATORS ARE 10" THICK CONCRETE UNLESS NOTED OTHERWISE.
 8. ALL DOORS ARE 4" THICK UNLESS NOTED OTHERWISE.
 9. ALL WINDOWS ARE 4" THICK UNLESS NOTED OTHERWISE.
 10. ALL PARTITIONS ARE 4" THICK UNLESS NOTED OTHERWISE.

GENERAL NOTES

1. ALL DIMENSIONS ARE TO FACE UNLESS NOTED OTHERWISE.
2. ALL WALLS ARE 12" THICK UNLESS NOTED OTHERWISE.
3. ALL FLOORS ARE 4" THICK CONCRETE UNLESS NOTED OTHERWISE.
4. ALL ROOFS ARE 6" THICK CONCRETE UNLESS NOTED OTHERWISE.
5. ALL CEILING ARE 8" THICK CONCRETE UNLESS NOTED OTHERWISE.
6. ALL STAIRS ARE 10" THICK CONCRETE UNLESS NOTED OTHERWISE.
7. ALL ELEVATORS ARE 10" THICK CONCRETE UNLESS NOTED OTHERWISE.
8. ALL DOORS ARE 4" THICK UNLESS NOTED OTHERWISE.
9. ALL WINDOWS ARE 4" THICK UNLESS NOTED OTHERWISE.
10. ALL PARTITIONS ARE 4" THICK UNLESS NOTED OTHERWISE.

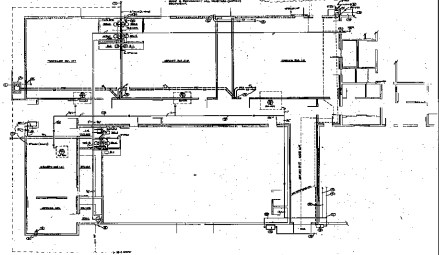

PLANNING FLOOR PLAN

CITY OF LAS VEGAS
DESIGN DIVISION
100 EAST STEWART AVENUE
LAS VEGAS, NEVADA 89101

PROJECT: **CONDOMINIUM PROJECT**
 ADDRESS: **100 EAST STEWART AVENUE**
 CITY: **LAS VEGAS, NEVADA 89101**

DESIGN: **DESIGN DIVISION**
 DRAWN: **DESIGN DIVISION**
 CHECKED: **DESIGN DIVISION**
 DATE: **10/1/88**

PLANNING FLOOR PLAN

100

101

102

200