


TITLE: PARK DEVELOPMENT
 SPRINKLER SYSTEM
 VEGAS VERDES ELEMENTARY

SCHOOL

JOB NO.
 518

DATE
 10/1/78
 DWG.
 10/1/78

COUNTY DISTRICT
 CLARK SCHOOL
 SCHOOL FACILITIES DIVISION
 TELEPHONE (702) 736-5250
 2822 EAST FLAMINGO ROAD
 LAS VEGAS, NV

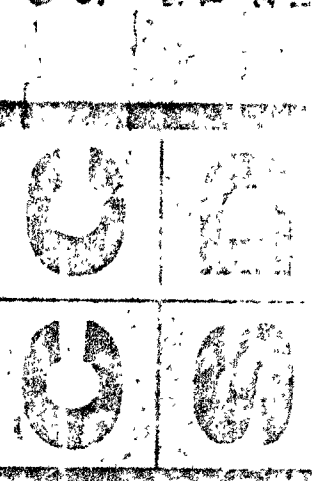


JOB NO.
 518


DATE REVISION

TITLE: PARK DEVELOPMENT
 SPRINKLER SYSTEM
 SCHOOL: VEGAS VERDES ELEM.

715-87 J

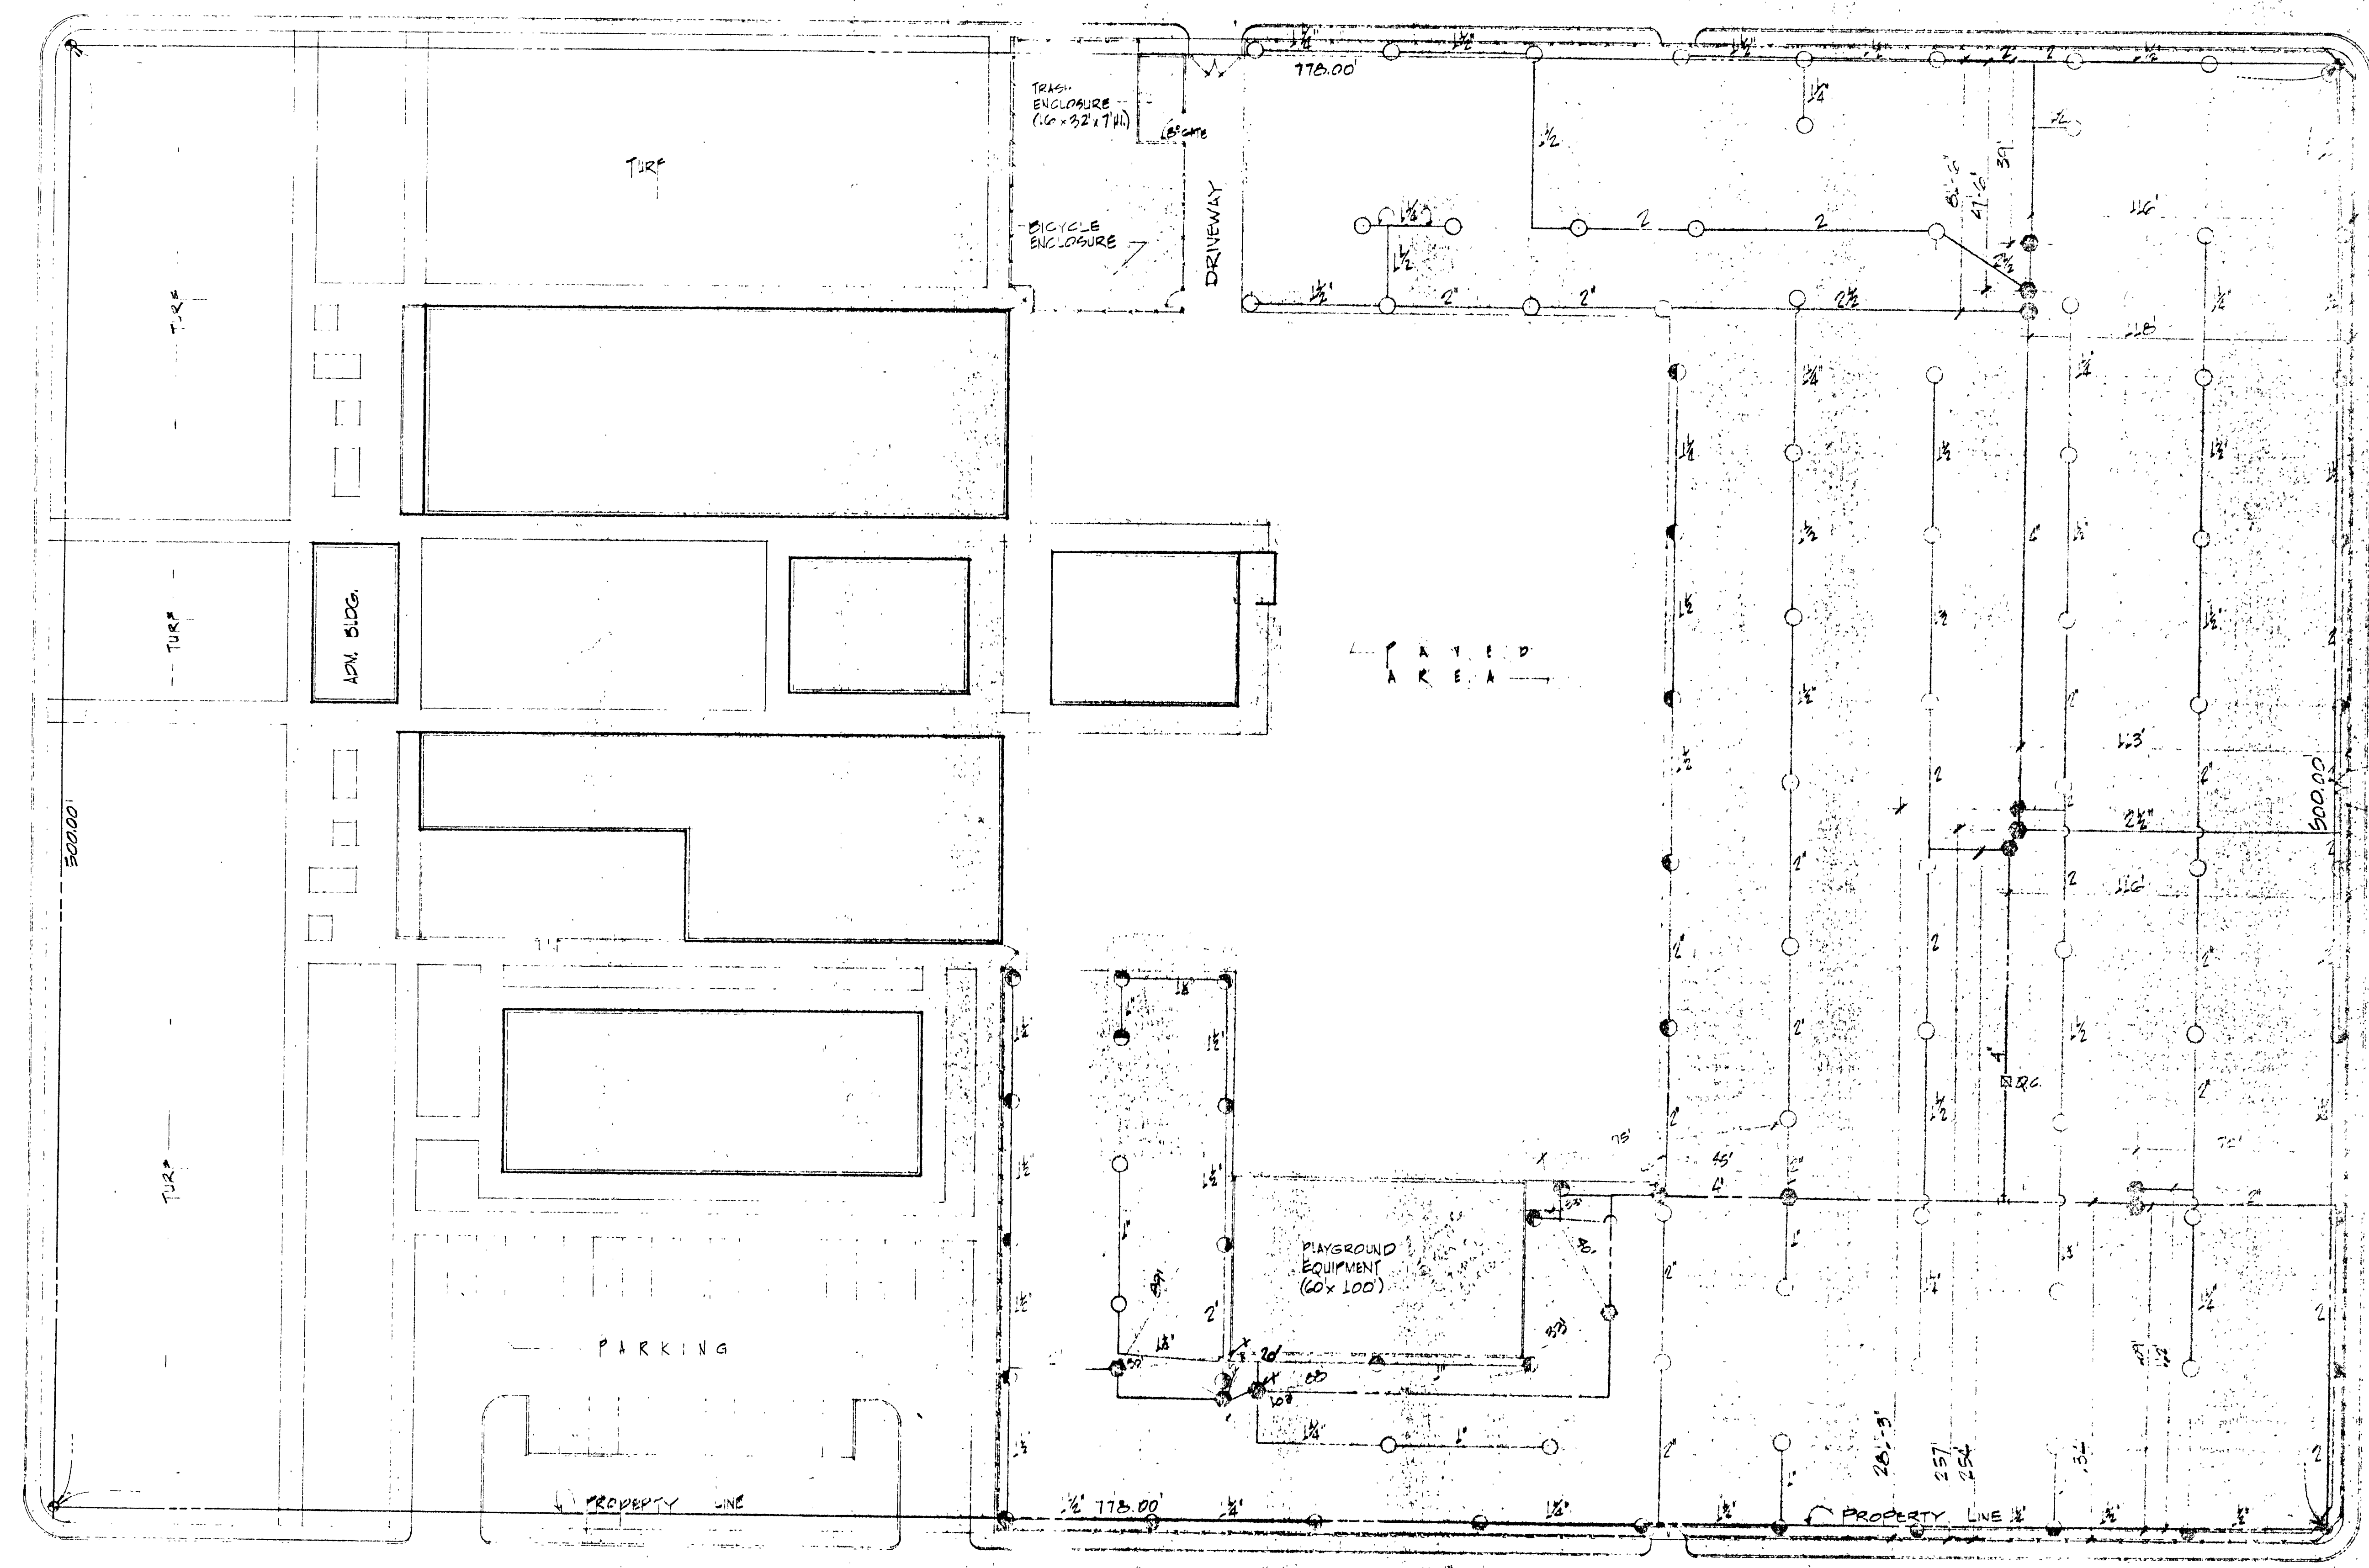

SITE PLAN
 1" = 30'

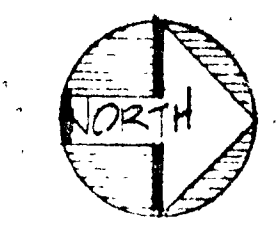

LEGEND - SYMBOLS

- THOMPSON 186
- 187 (175°)
- 187 (20°00'270°)
- AQUA OIL 511P
- AQUA OIL 5160
- 15" NOZZLE - 15 GAL 50 LBS
- DESIGN 75 LBS PEAK LOAD 250 GAL MIN.

TITLE: PARK DEVELOPMENT
 SPRINKLER SYSTEM
 SCHOOL: VEGAS VERDES ELEM.

5618