


[illegible]

Yours about me for
will mention
Alfred
7/12/20

FIRE ALARM DEVICE LAYOUT

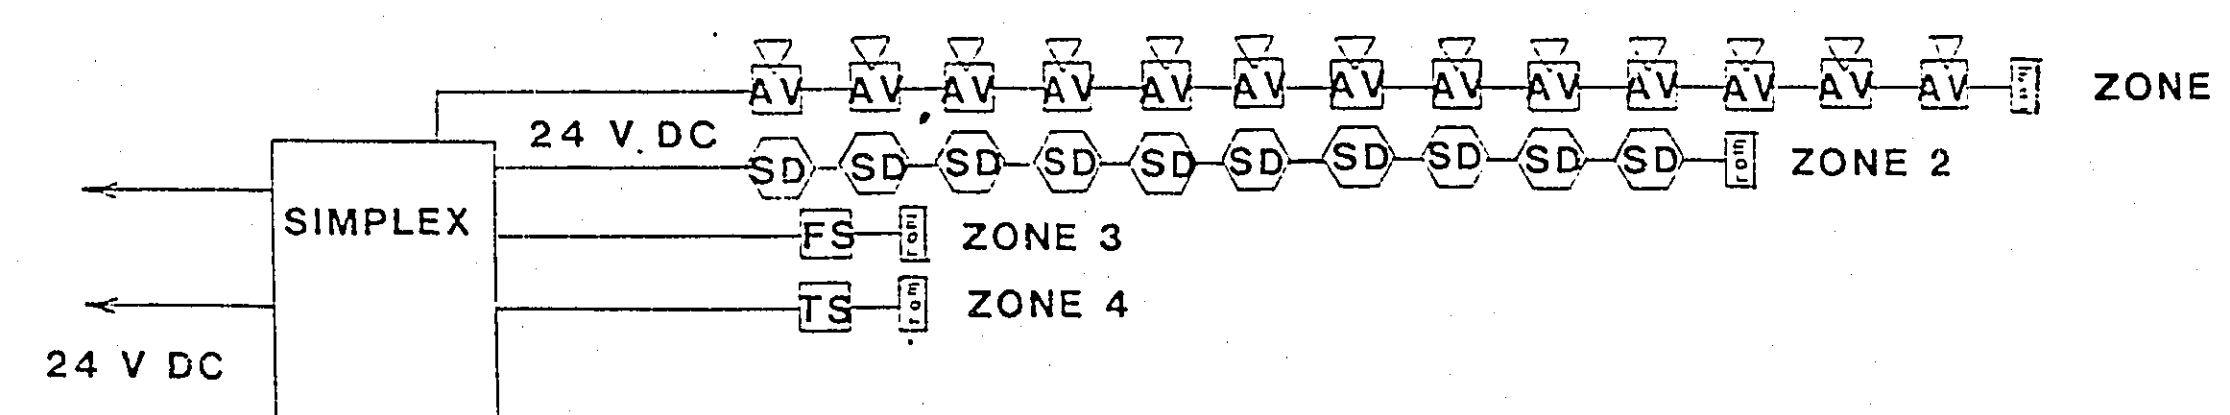

FIRE ALARM RISER DIAGRAM

SYMBOLS

- | | |
|--|-------------------------------------|
| FACP | FIRE ALARM CONTROL PANEL |
|  AV | HORN/AUDIO VISUAL SIGNAL DEVICE #14 |
|  SD | SMOKE DETECTOR #16 |
|  FS | SPRINKLER FLOW SWITCH |
|  TS | SPRINKLER TAMPER SWITCH |
| <p>=====AREA ENCLOSED IS EXISTING,
TO REMAIN EXCEPT AS NOTED</p> | |

NOTES: FIRE ALARM SYSTEM

(ALL COMPONENTS SHALL BE OF ONE MANUFACTURER.)

1. 4 ZONE U.L. LISTED FIRE ALARM CONTROL PANEL.

24 V DC AS MANUFACTURED BY SIMPLEX, AUTOCALL, GAMEWELL OR AS ACCEPTED.

SMOKE DETECTORS SHALL BE CONNECTED TO ONE ZONE, SUPERVISION OF THE

FIRE PROTECTION SYSTEM SHALL OCCUR ON ZONE 2.

PROVIDE BATTERY STANDBY.

2. 24 V DC PHOTOELECTRIC SMOKE DETECTOR U.L. LISTED.

3. COMBINATION FIRE ALARM HORN AND STROBE LIGHT.

NEVADA STATE CONTRACTORS LICENSE #0016366

NEVADA STATE FIRE MARSHAL LICENSE #F15

ASBUILTS

[illegible]

SEAL	PROJECT NO.	DATE 4/11/90
	REVIEW	DRAWN BY BBP
	APPROVED	CHECKED BY
	DATE	SUBMITAL

**FAST TRAC
ELECTRIC**



Simplex[®]

Simplex Time Recorder Co.
Western & Oakley Center
1535 W. Oakley Boulevard
Las Vegas, Nevada 89102-2628
Sales and Service Dept.
Fax: (702) 384-0046

CITY OF LAS VEGAS

**WELFARE SERVICE FACILITY
NUCLEUS PLAZA, NEVADA**

CLUB PLAZA FIRE ALARM

SHEET NO

1 OF 1

As Built 513-57B