

Drawing No.

Project No.

Consultants

The Contractor shall check and verify all dimensions and report all errors and omissions to this office prior to commencing work. These drawings are not to be scaled.

Seal

Revisions	No.	Date	Description

1594

Date 12/18/89
Drawn HA/KB
Checked DL
Project No. 88237

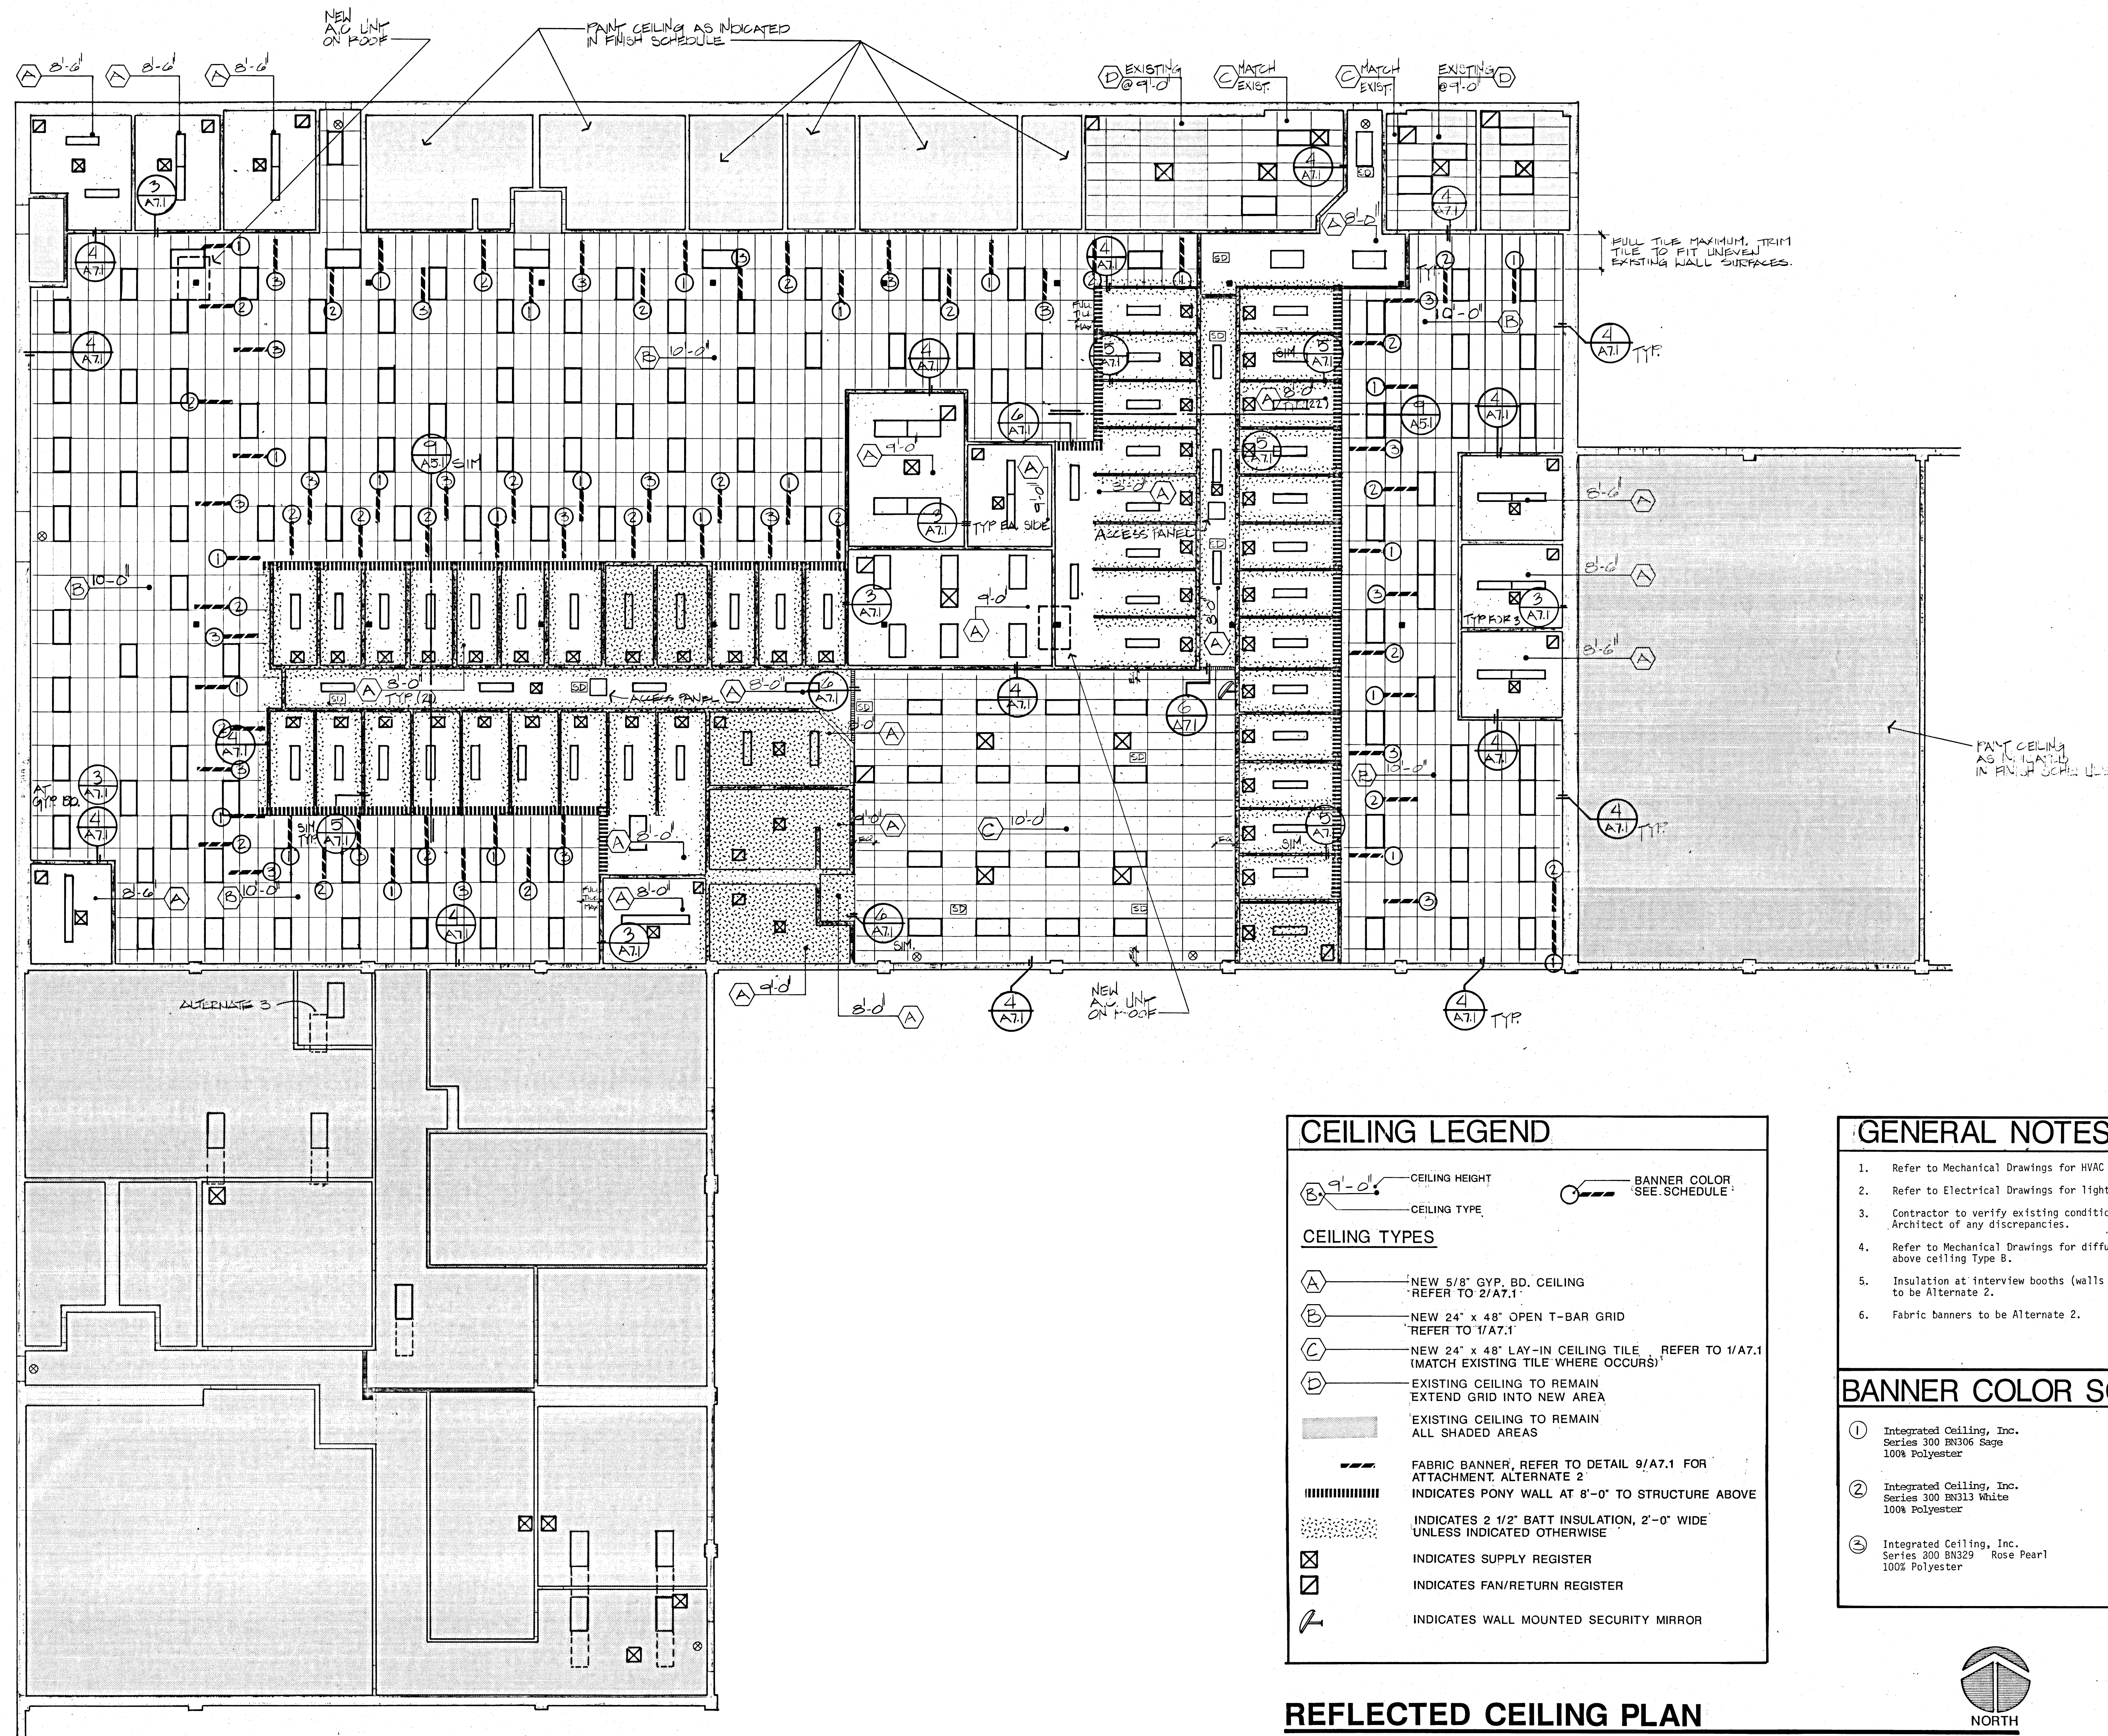
Project
WELFARE SERVICES FACILITY
for
CITY OF LAS VEGAS

LAS VEGAS, NEVADA

Drawing Title
REFLECTED CEILING PLAN

Drawing No.
A3.1

As Built 513-57A

**CEILING LEGEND**

B 9'-0" — CEILING HEIGHT
— CEILING TYPE
BANNER COLOR
SEE SCHEDULE

CEILING TYPES

- A** — NEW 5/8" GYP. BD. CEILING
REFER TO 2/A7.1
- B** — NEW 24" x 48" OPEN T-BAR GRID
REFER TO 1/A7.1
- C** — NEW 24" x 48" LAY-IN CEILING TILE. REFER TO 1/A7.1
(MATCH EXISTING TILE WHERE OCCURS)
- D** — EXISTING CEILING TO REMAIN
EXTEND GRID INTO NEW AREA
- EXISTING CEILING TO REMAIN
ALL SHADED AREAS
- FABRIC BANNER, REFER TO DETAIL 9/A7.1 FOR
ATTACHMENT. ALTERNATE 2
- INDICATES PONY WALL AT 8'-0" TO STRUCTURE ABOVE
- INDICATES 2 1/2" BATT INSULATION, 2'-0" WIDE
UNLESS INDICATED OTHERWISE
- INDICATES SUPPLY REGISTER
- INDICATES FAN/RETURN REGISTER
- INDICATES WALL MOUNTED SECURITY MIRROR

GENERAL NOTES

1. Refer to Mechanical Drawings for HVAC symbols.
2. Refer to Electrical Drawings for lighting symbols.
3. Contractor to verify existing conditions and notify Architect of any discrepancies.
4. Refer to Mechanical Drawings for diffuser locations above ceiling Type B.
5. Insulation at interview booths (walls & ceilings) to be Alternate 2.
6. Fabric banners to be Alternate 2.

BANNER COLOR SCHEDULE

- ① Integrated Ceiling, Inc.
Series 300 BN306 Sage
100% Polyester
- ② Integrated Ceiling, Inc.
Series 300 BN313 White
100% Polyester
- ③ Integrated Ceiling, Inc.
Series 300 BN329 Rose Pearl
100% Polyester

REFLECTED CEILING PLAN

1/8" = 1'-0"

