

Consultants

The Contractor shall check and verify all dimensions and report all errors and omissions to the office prior to commencing work. These drawings are not to be scaled.

Seal

Revisions
No. Date Description

15-102

Date 12/18/89

Drawn D.E.

Checked S.P.F.

Project No.

88237

Project
WELFARE SERVICES
FACILITY


for
CITY OF LAS VEGAS

at
NUCLEUS PLAZA, NEVADA


Drawing Title
**PLUMBING
FLOOR PLAN**

Drawing No.

M - 2

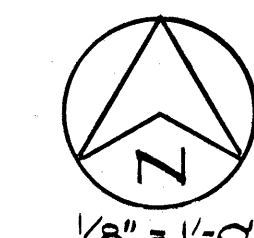

As Built 12/18/89 513-57A

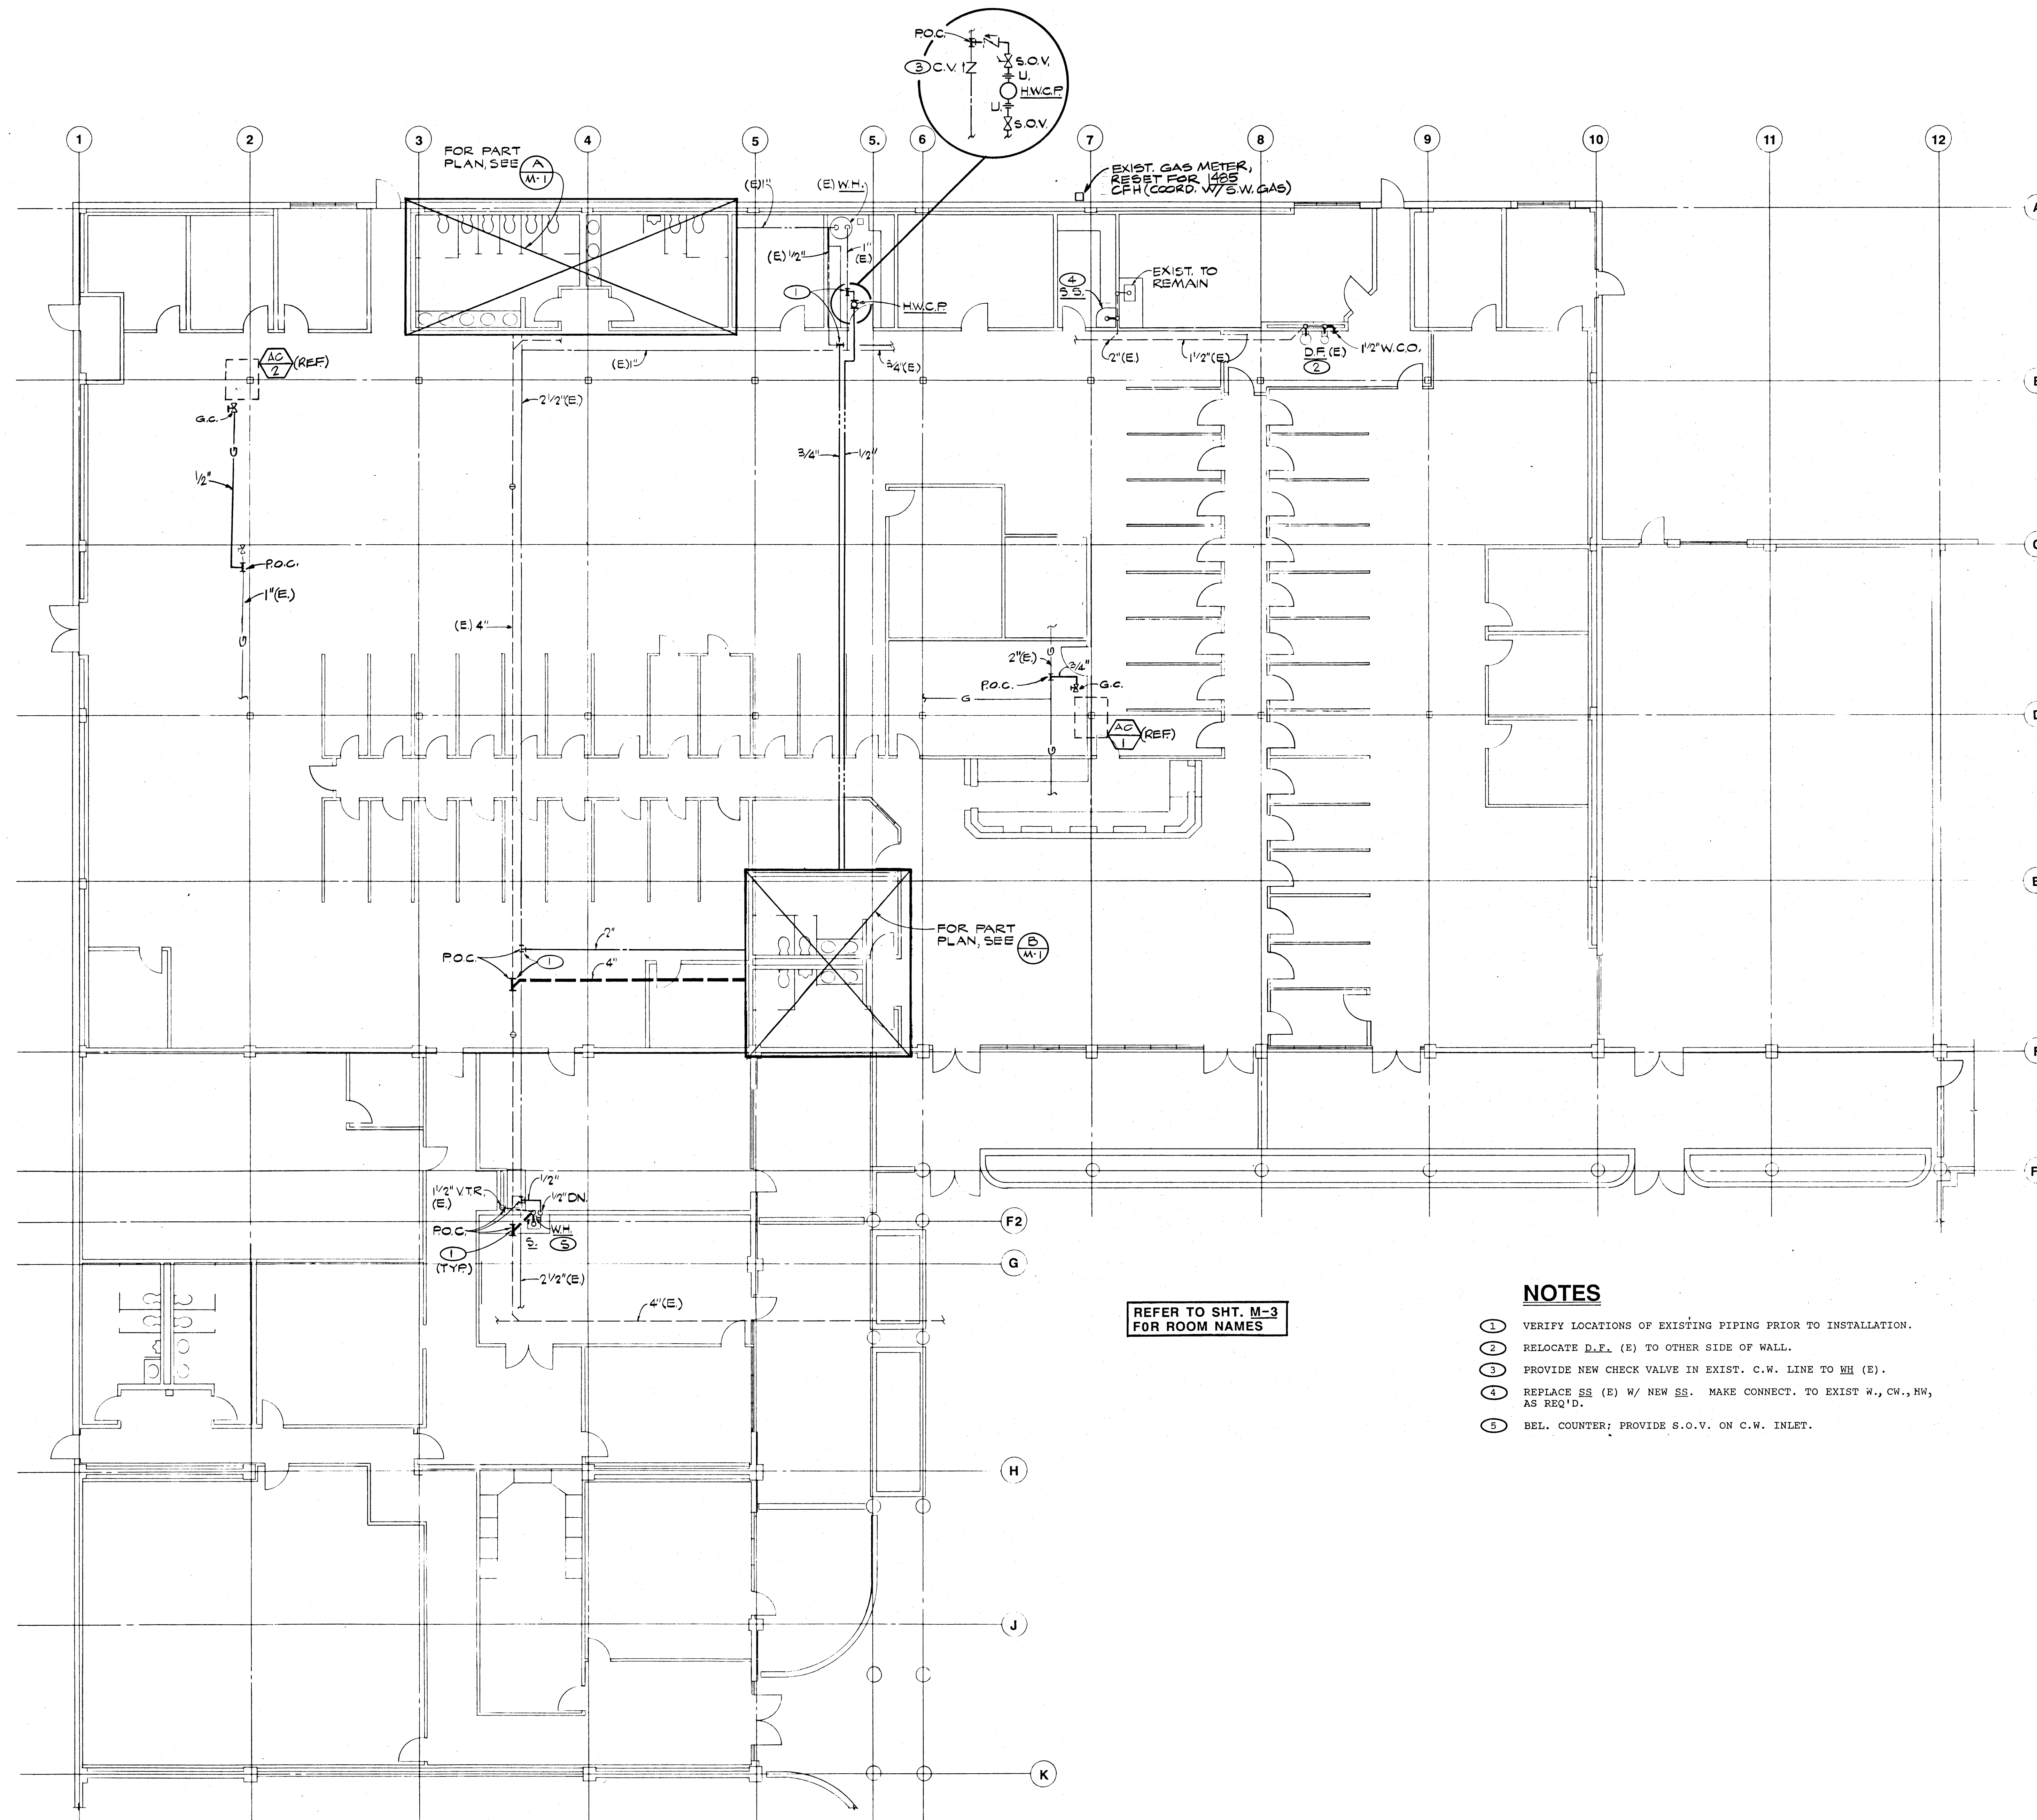

REFER TO SHT. M-3
FOR ROOM NAMES

NOTES

1. VERIFY LOCATIONS OF EXISTING PIPING PRIOR TO INSTALLATION.
2. RELOCATE D.F. (E) TO OTHER SIDE OF WALL.
3. PROVIDE NEW CHECK VALVE IN EXIST. C.W. LINE TO WH (E).
4. REPLACE SS (E) W/ NEW SS. MAKE CONNECT. TO EXIST W., CW., HW, AS REQ'D.
5. BEL. COUNTER: PROVIDE S.O.V. ON C.W. INLET.