


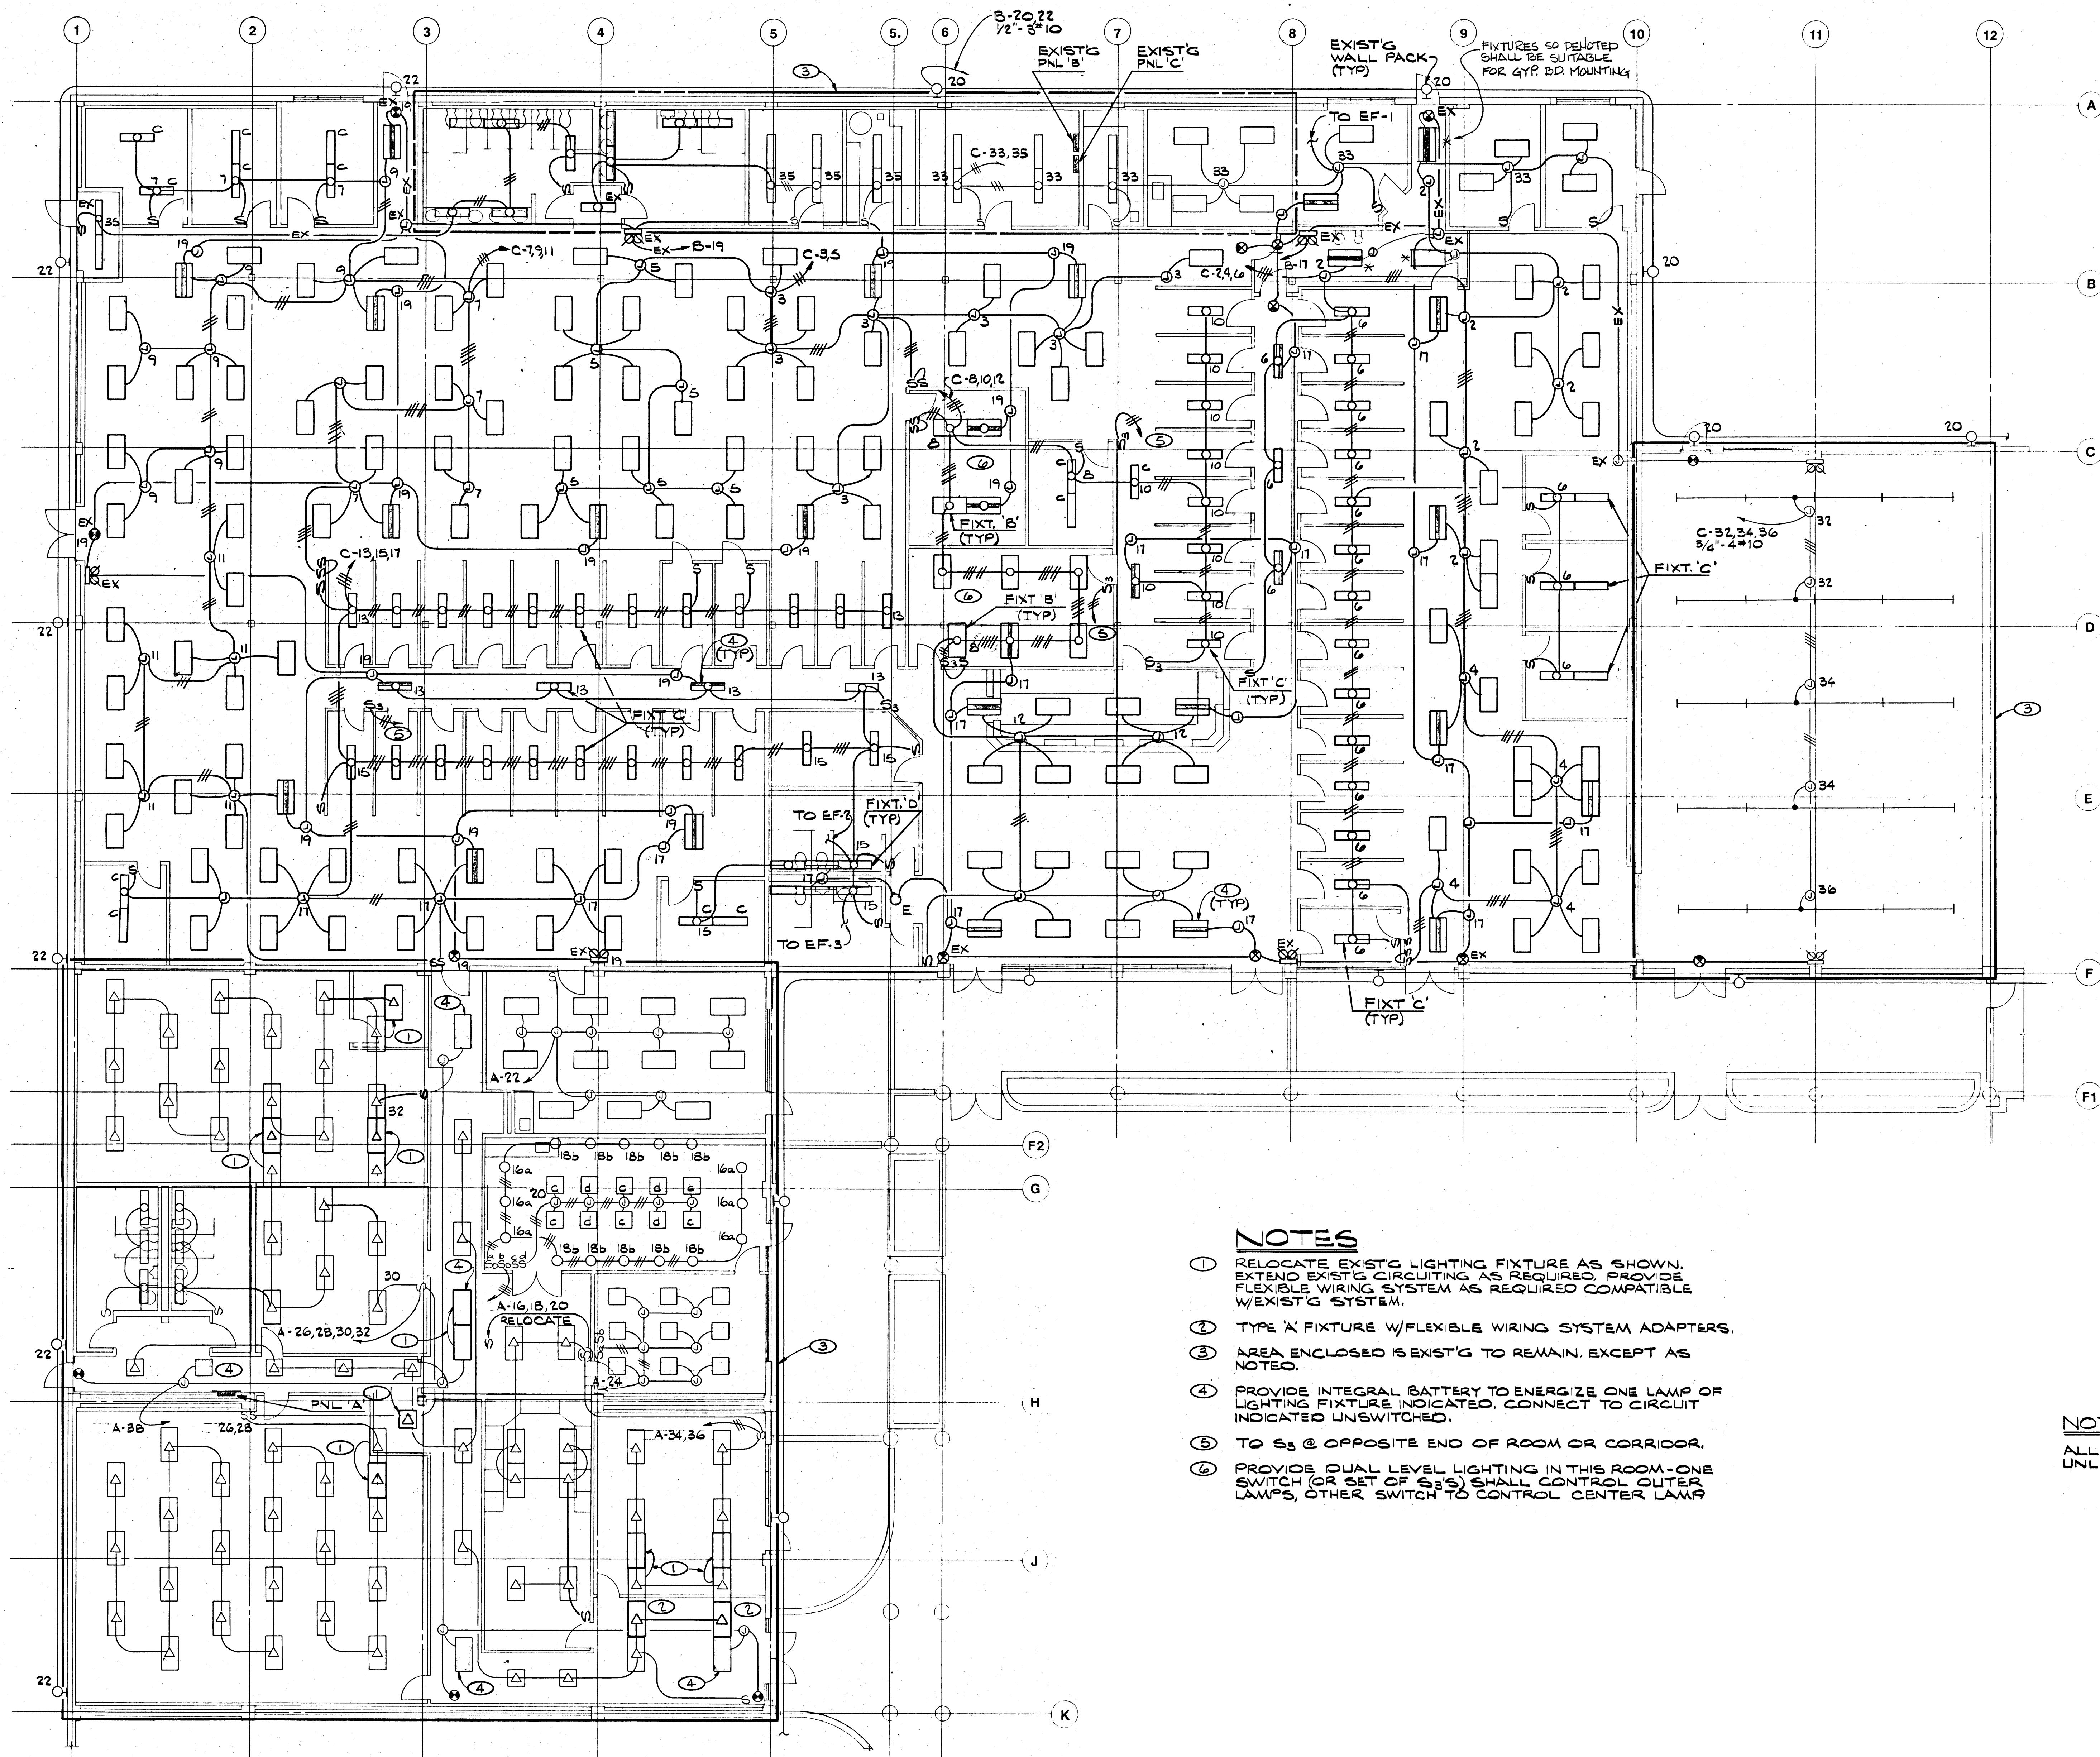

- NOTES**
- RELOCATE EXIST'G LIGHTING FIXTURE AS SHOWN. EXTEND EXIST'G CIRCUITING AS REQUIRED. PROVIDE FLEXIBLE WIRING SYSTEM AS REQUIRED COMPATIBLE W/EXIST'G SYSTEM.
 - TYPE 'A' FIXTURE W/FLEXIBLE WIRING SYSTEM ADAPTERS.
 - AREA ENCLOSED IS EXIST'G TO REMAIN. EXCEPT AS NOTED.
 - PROVIDE INTEGRAL BATTERY TO ENERGIZE ONE LAMP OF LIGHTING FIXTURE INDICATED. CONNECT TO CIRCUIT INDICATED UNSWITCHED.
 - TO S₃ @ OPPOSITE END OF ROOM OR CORRIDOR.
 - PROVIDE DUAL LEVEL LIGHTING IN THIS ROOM - ONE SWITCH (OR SET OF S₃'S) SHALL CONTROL OUTER LAMPS, OTHER SWITCH TO CONTROL CENTER LAMP

NOTICE
ALL LIGHTING FIXTURES TYPE 'A' UNLESS NOTED OTHERWISE.

JMA ARCHITECTS & ENGINEERS, INC.
Architecture and Engineering
Research and Planning
Interior and Graphic Design
Landscape Architecture
4292 N. Alexandria Avenue
Las Vegas, Nevada 89119
702-731-2144
FAX 702-731-2109

Consultants

The Contractor shall verify and correct all dimensions and report all errors and omissions to the architect prior to commencing work. These drawings are not to be scaled.

Seal

Revisions	No.	Date	Description

15-106

Date 12/18/89
Drawn RCB
Checked D.O.B.
Project No. 88237

Project
WELFARE SERVICES FACILITY
for
CITY OF LAS VEGAS
at
NUCLEUS PLAZA, NEVADA
Drawing Title
LIGHTING PLAN
Drawing No.
E1.1

As Bldg 6513-57A