




Revisions

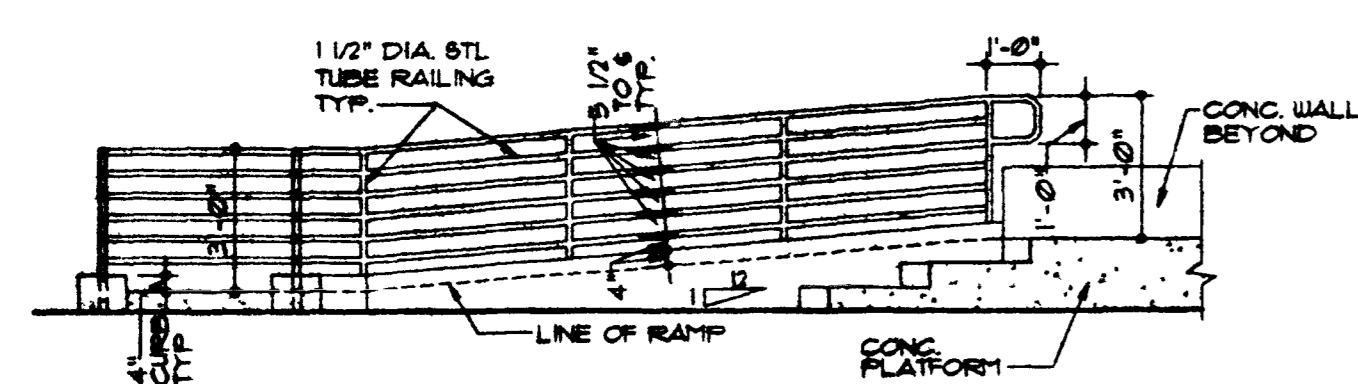



4 RAMP SECTION
SCALE: 1/4" = 1'-0"

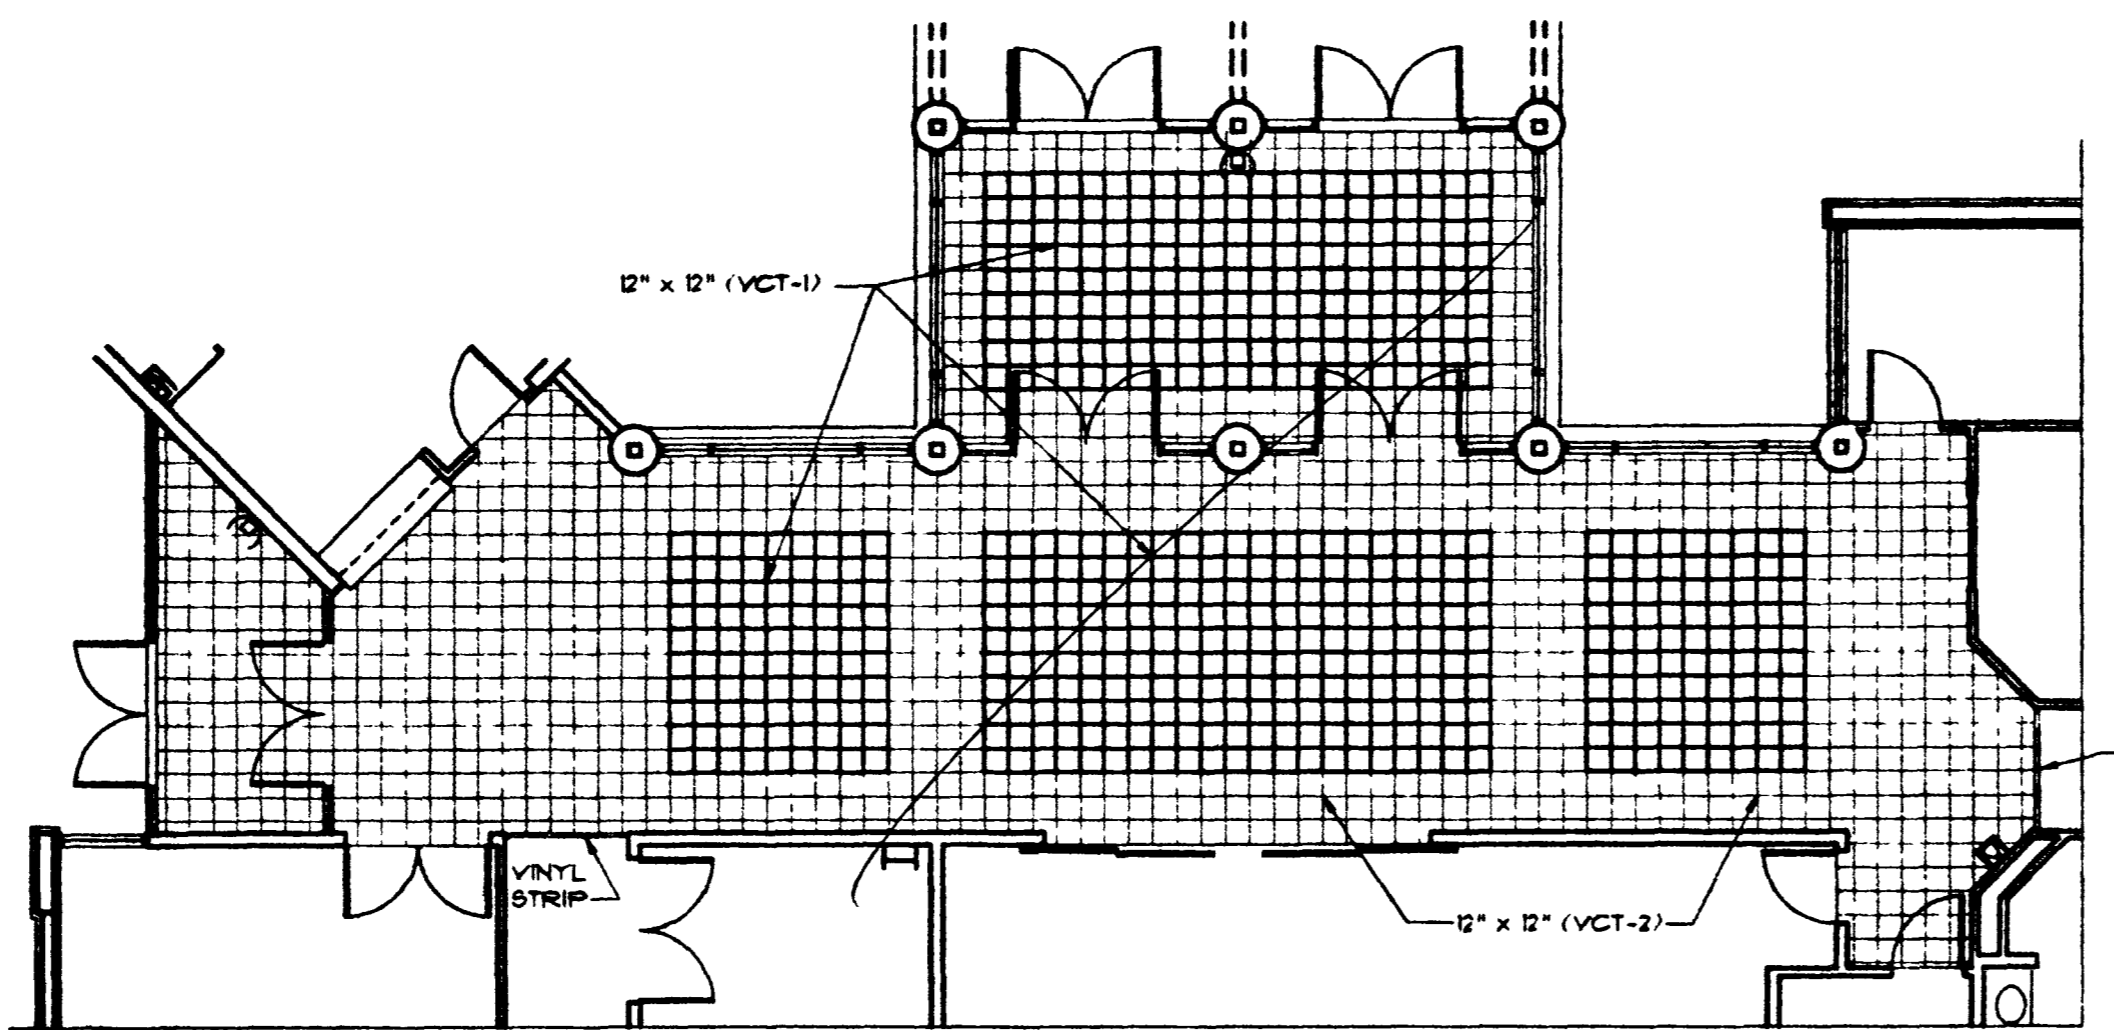

3 DEDUCTIVE ALTERNATE NO. 4
SCALE: 1/8" = 1'-0"

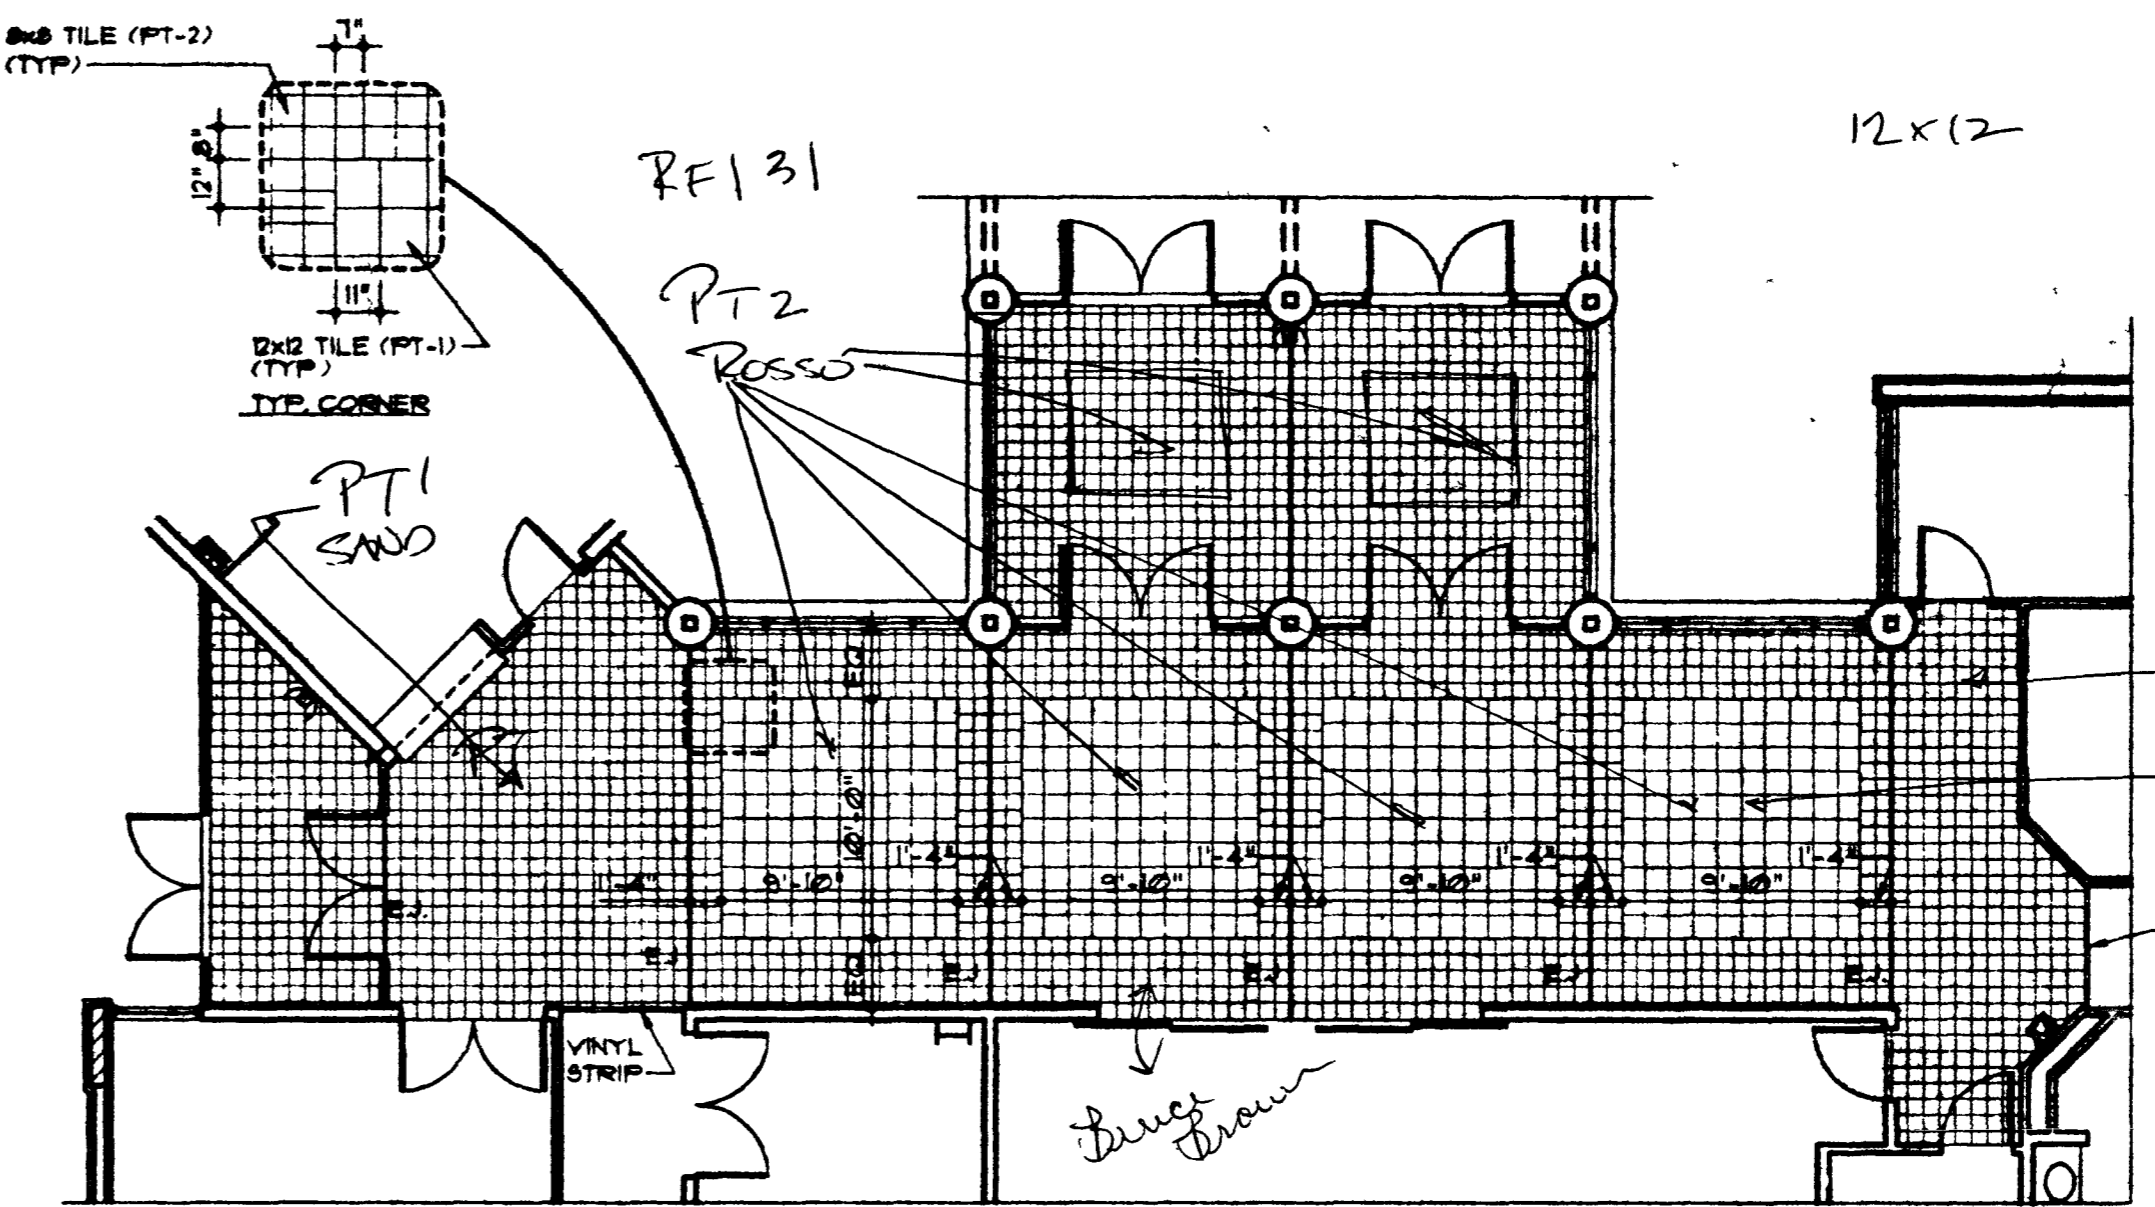


2 LOBBY & VESTIBULE FLOOR FINISH PLAN
SCALE: 1/8" = 1'-0"

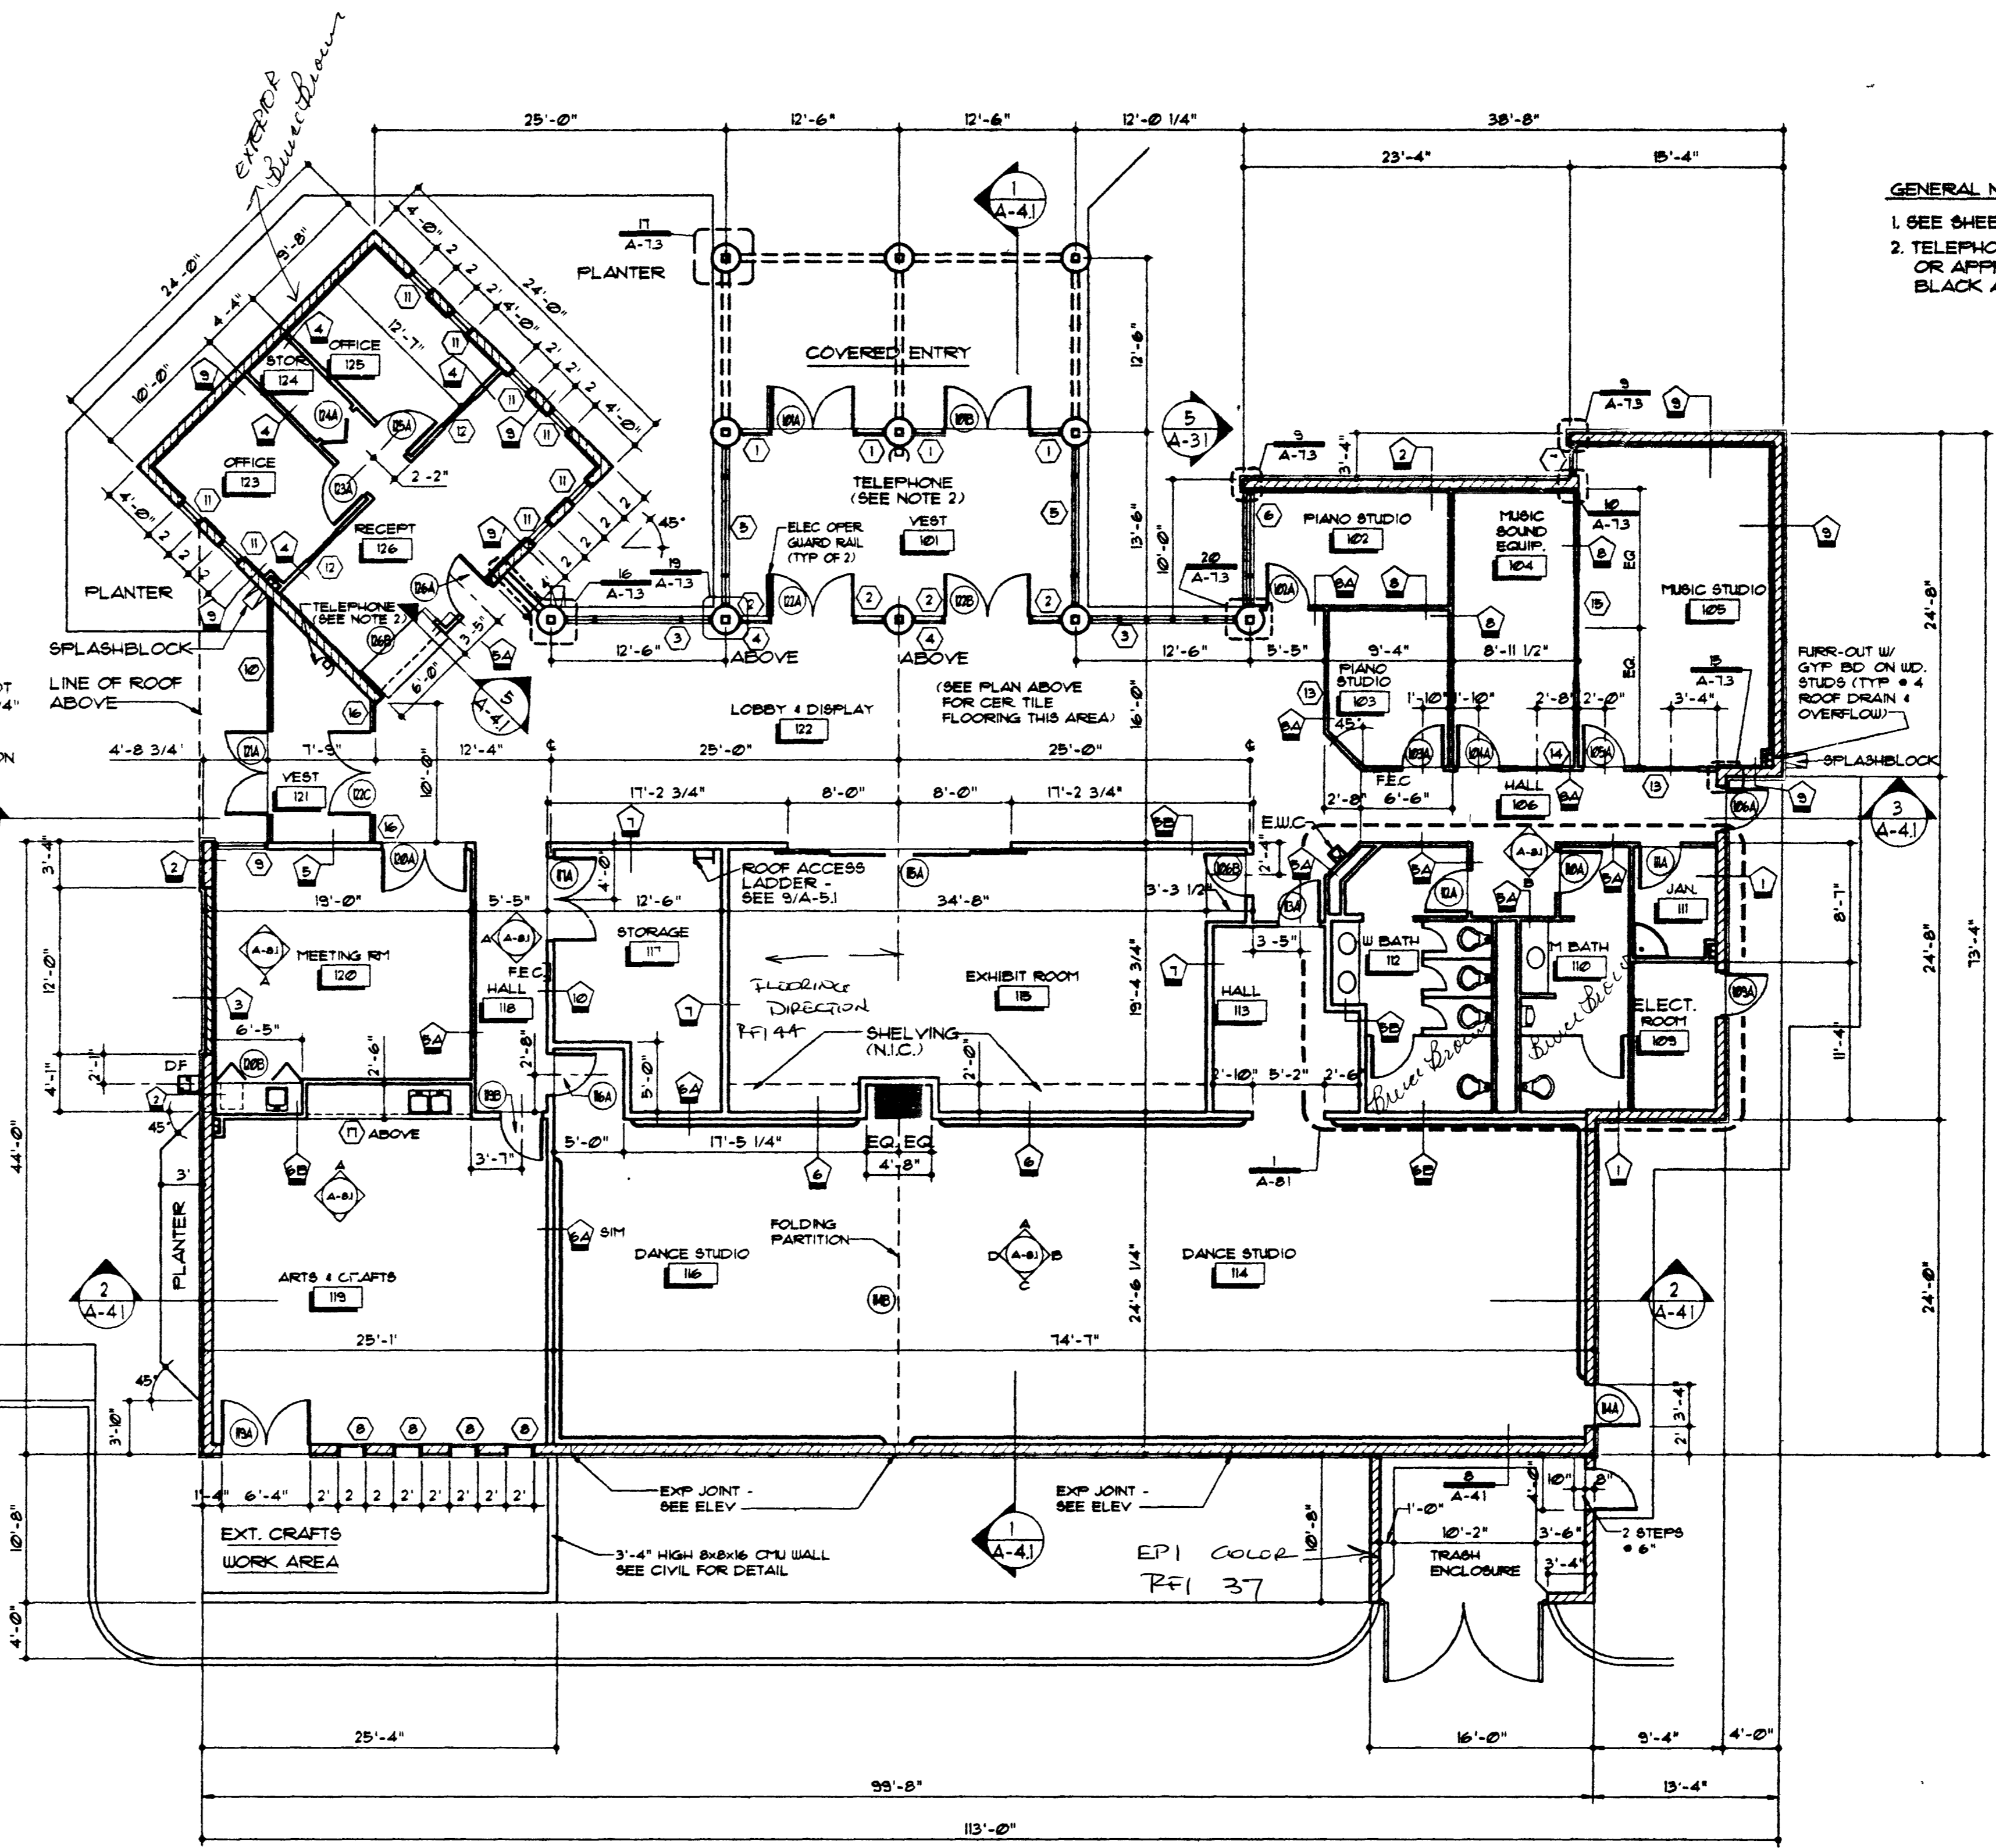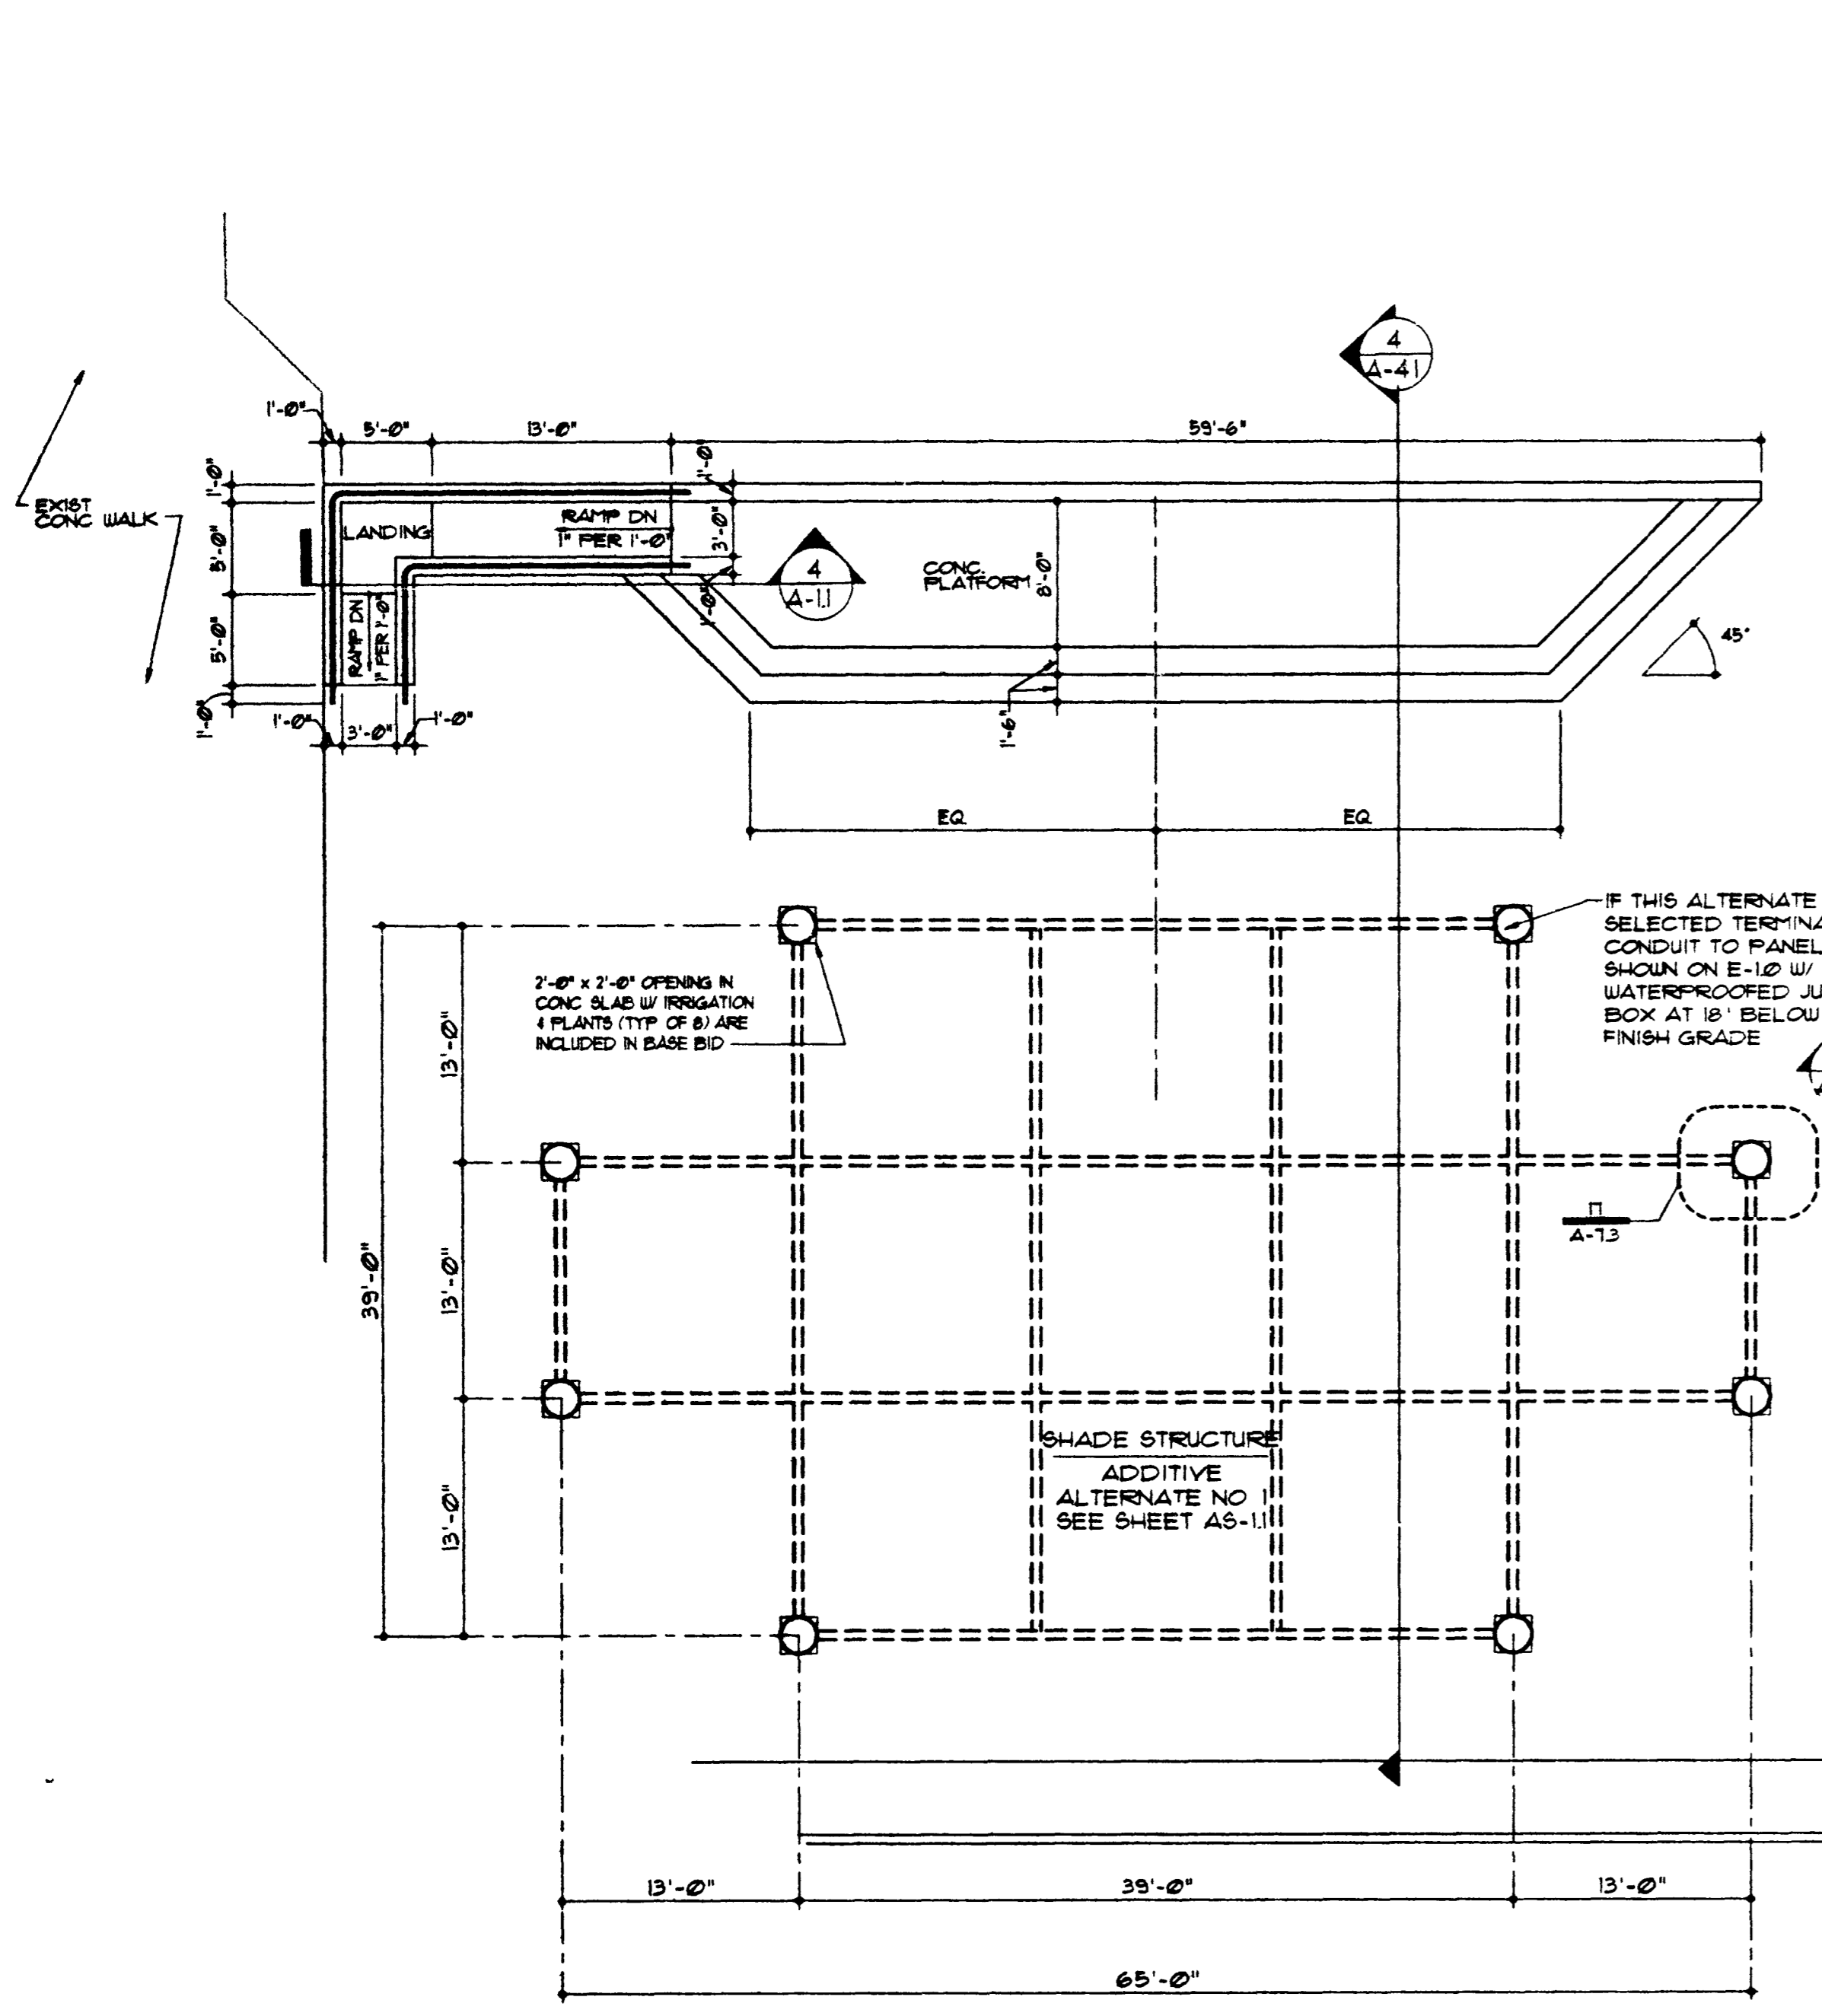

GENERAL NOTES:
1. SEE SHEET A-4.2 FOR WALL SECTIONS
2. TELEPHONE KIOSK TO BE KING - MODEL 540 C OR APPROVED EQUAL - EXTRUDED ALUM. SECTIONS W/ BLACK ANODIZED FINISH.

FRYING COST

1 FLOOR PLAN
SCALE: 1/8" = 1'-0"

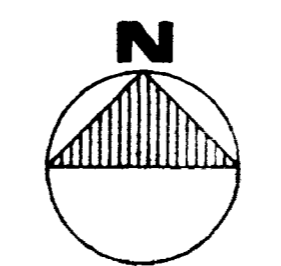

CEM
NICKLES/HAJERKUN
3 FEB 94

Handwritten signature

671-46 671-46

**WEST LAS VEGAS ARTS CENTER
DOOLITTLE PARK - LAS VEGAS, NEVADA**

FLOOR PLAN AS-BUILT

 
Project: WEST LAS VEGAS ARTS CENTER
Date: 8/12/93
Drawn By: MHS
Checked By: MY
Project No: 92-160
Scale: 1/8" = 1'-0"
Sheet No: A-1.1

HARRY CAMPBELL ARCHITECTS
1855 East Flamingo Road, Suite 120 Las Vegas, NV 89119 (702) 731-0363 Fax (702) 731-9266
Three Decades of Excellence in Architecture, we are still Remains the Property of the Design Professionals.
Do Not Scale This Drawing


FILE: 160A11





② RAISE SECTION
DATE 12-11-57



 ③ DESTRUCTIVE ALTERNATE NO. 4
DATE 12-11-57



④ LOBBY & VESTIBULE FLOOR FINISH PLAN
DATE 12-11-57

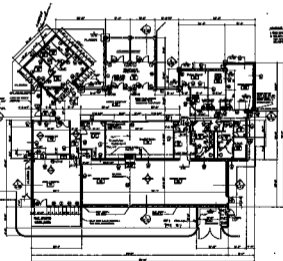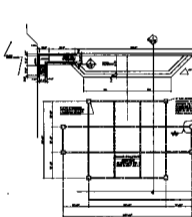

① FLOOR PLAN
DATE 12-11-57

NOTES:
1. SEE SHEET 61-10 FOR STRUCTURAL DETAILS.
2. SEE SHEET 61-11 FOR ELECTRICAL DETAILS.
3. SEE SHEET 61-12 FOR MECHANICAL DETAILS.

*Copy Done
12/11/57*

12/11/57

<p> WEST LAS VEGAS ARTS CENTER DOODLETT PARK - LAS VEGAS, NEVADA FLOOR PLAN A3-B416 </p>
